

Republic of the Philippines
PROVINCE OF DAVAO DEL SUR
Office of the Governor

PROCUREMENT MANAGEMENT OFFICE BIDS AND AWARDS COMMITTEE

Mobile Nos. 0905-229-0526/0908-332-2024 (Goods), 0948-768-5848 (Infra)

Telefax: (082) 553-9579

Website: www.davaodelsur.gov.ph/pgc-bac

Email Add.: bac.davaodelsur2@gmail.com/sbaacdavaodelsur@gmail.com

Province of Davao del Sur

BIDDING DOCUMENTS (Third Opening)

One Job Order for the

REPAIR/ IMPROVEMENT OF SANGGUNIAN PANLALAWIGAN BUILDING located at MATTI, DIGOS CITY, DAVAO DEL SUR

all in accordance to plans, specifications and scope of work and the Green Procurement Policy as adopted by Executive Order No. 30 series of 2019

IB No. C-164-23

Date of Opening of Bids: February 27, 2024 at 09:00 A.M.

Start Date for Issuance of Bidding Documents: February 17, 2024

Sixth Edition
July 2020

TABLE OF CONTENTS

SECTION I.	INVITATION TO BID
SECTION II.	INSTRUCTIONS TO BIDDERS
SECTION III.	BID DATA SHEET
SECTION IV.	GENERAL CONDITIONS OF CONTRACT
SECTION V.	SPECIAL CONDITIONS OF CONTRACT
SECTION VI.	SPECIFICATIONS
SECTION VII.	DRAWINGS
SECTION VIII.	BILL OF QUANTITIES
SECTION IX.	CHECKLIST OF TECHNICAL AND FINANCIAL DOCUMENTS
SECTION X.	OTHER DOCUMENTS

f

SECTION I.

INVITATION TO BID

4



Invitation to Bid for C-164-23 (Third Opening)

REPAIR/ IMPROVEMENT OF SANGGUNIAN PANLALAWIGAN BUILDING located at **MATTI, DIGOS CITY, DAVAO DEL SUR**

all in accordance to plans, specifications and scope of work and the Green Procurement Policy as adopted by Executive Order No. 30 series of 2019

1. The Provincial Government of Davao del Sur, through the CY 2022 SUPPLEMENTAL BUDGET- 20% DEVELOPMENT FUND intends to apply the sum of P7, 400,000.00 being the Approved Budget for the Contract (ABC) to payments under the contract for IB No. C-164-23. Bids received in excess of the ABC shall be automatically rejected at bid opening.
2. The Provincial Government of Davao del Sur now invites bids for the above Procurement Project. Completion of the Works is required 75 Calendar Days Contract Duration. Bidders should have completed a contract similar to the Project. The description of an eligible bidder is contained in the Bidding Documents, particularly, in Section II (Instructions to Bidders).
3. Bidding will be conducted through open competitive bidding procedures using non-discretionary “*pass/fail*” criterion as specified in the 2016 revised Implementing Rules and Regulations (IRR) of Republic Act (RA) No. 9184.
4. Interested bidders may obtain further information from Provincial Government of Davao del Sur and inspect the Bidding Documents at the address given below during 8:00 A.M. – 5:00 P.M. Monday to Friday:

ENGR. SHEILA MAE A. ZAPANTA, MPA
Administrative Officer IV
Head, BAC Secretariat for Infrastructure Projects


5. A complete set of Bidding Documents may be acquired by interested bidders on February 17 - 27, 2024, at the Office of the BAC Secretariat Room 16, Executive Building, Capitol Compound, Brgy. Matti, Digos City upon accomplishing a bidder’s assessment slip pursuant to the latest Guidelines issued by GPPB, in the amount of P10,000.00. The Provincial Government of Davao del Sur shall allow the bidder to present its proof of payment for the fees upon payment of a non-refundable fee for the Bidding Documents in the amount stated above, to the Provincial Treasurer’s Office. An authorization from the proprietor of the company shall be presented in case the latter opted to send representative/s in his/her behalf. Only bidders who purchased the Bidding Documents with corresponding official receipt of the bidding documents will be allowed to submit bids. Eligibility/Technical and Financial documents must be book bound and properly tabbed at right side. The bidder will prepare (3) sets of book bound bidding documents with corresponding proper markings (Original Copy, Copy 1 and Copy 2), respectively. Any documents submitted, not book bound shall be rejected outright. For the Financial Proposals not exceeding ten (10) pages may be book bound or securely stapled.

6. Bids must be duly received by the BAC Secretariat at the following through manual submission. Late bids shall not be accepted.
 - Advance dropping (before February 27, 2024) – Room 16, Procurement Management Office (Infrastructure Projects), Capitol Building, Mati, Digos City.
 - Date of opening (February 27, 2024), before 9:00 A.M.) – Ralota Hall, Davao del Sur Coliseum, Mati, Digos City.
7. All bids must be accompanied by a bid security in any of the acceptable forms and in the amount stated in ITB Clause 16.
8. Bid opening shall be on February 27, 2024 at 9:00 A.M., Ralota Hall, Gov. Douglas Ra. Cagas Cultural, Sports and Business Complex, Barangay Mati, Digos City, Davao del Sur. Bids will be opened in the presence of the bidders' representatives who choose to attend the activity.
9. The Provincial Government of Davao del Sur reserves the right to reject any and all bids, declare a failure of bidding, or not award the contract at any time prior to contract award in accordance with Sections 35.6 and 41 of the 2016 revised Implementing Rules and Regulations (IRR) of RA No. 9184, without thereby incurring any liability to the affected bidder or bidders.
10. For further information, please refer to:

The BAC CHAIRPERSON
Provincial Government of Davao del Sur
Contact No: 09487685848
Email Address: sbacdavaodelsur@gmail.com

Engr. SHEILA MAE A. ZAPANTA, MPA
Head, BAC Secretariat for Infrastructure Projects
PGO – Procurement Management Office
Office of BAC Secretariat for Infrastructure Projects
Room 16, Provincial Capitol Building, Mati, Digos City, Davao del Sur
Contact No: 09487685848; Email Address: shacdavaodelsur@gmail.com

11. You may visit the website, www.davaodelsur.gov.ph, for downloading of Bidding Documents.

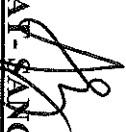
DESSAMIE BUAY SANCHEZ, CPA, JD
Provincial Budget Officer
BAC Chairperson



February 16, 2024

SECTION II.

INSTRUCTION TO BIDDERS



Section II. Instructions to Bidders

1. Scope of Bid

The PROVINCIAL GOVERNMENT OF DAVAO DEL SUR invites Bids for the **REPAIR/ IMPROVEMENT OF SANGGUNIANG PANLALAWIGAN BUILDING** located at **MATTI, DIGOS CITY, DAVAO DEL SUR** with Project Identification Number **C-164-23**

The Procurement Project (referred to herein as ("**REPAIR/ IMPROVEMENT OF SANGGUNIANG PANLALAWIGAN BUILDING** located at **MATTI, DIGOS CITY, DAVAO DEL SUR**") is for the construction of Works, as described in Section VI (Specifications).

2. Funding Information

- 2.1. The GOP through the source of funding as indicated below for **CY 2022** in the amount of **P7,400,000.00**.
- 2.2. The source of funding is **(CY 2022 SUPPLEMENTAL BUDGET- 20% DEVELOPMENT FUND)**:

3. Bidding Requirements

The Bidding for the Project shall be governed by all the provisions of RA No. 9184 and its 2016 revised IRR, including its Generic Procurement Manual and associated policies, rules and regulations as the primary source thereof, while the herein clauses shall serve as the secondary source thereof.

Any amendments made to the IRR and other GPPB issuances shall be applicable only to the ongoing posting, advertisement, or invitation to bid by the BAC through the issuance of a supplemental or bid bulletin.

The Bidder, by the act of submitting its Bid, shall be deemed to have inspected the site, determined the general characteristics of the contracted Works and the conditions for this Project, such as the location and the nature of the work; (b) climatic conditions; (c) transportation facilities; (c) nature and condition of the terrain, geological conditions at the site communication facilities, requirements, location and availability of construction aggregates and other materials, labor, water, electric power and access roads; and (d) other factors that may affect the cost, duration and execution or implementation of the contract, project, or work and examine all instructions, forms, terms, and project requirements in the Bidding Documents.

4. Corrupt, Fraudulent, Collusive, Coercive, and Obstructive Practices

The Procuring Entity, as well as the Bidders and Contractors, shall observe the highest standard of ethics during the procurement and execution of the contract. They or through an agent shall not engage in corrupt, fraudulent, collusive, coercive, and obstructive practices defined under Annex "I" of the 2016 revised IRR of RA No. 9184 or other integrity violations in competing for the Project.

5. Eligible Bidders

- 5.1. Only Bids of Bidders found to be legally, technically, and financially capable will be evaluated.

5.2. The Bidder must have an experience of having completed a Single Largest Completed Contract (SLCC) that is similar to this Project, equivalent to at least fifty percent (50%) of the ABC adjusted, if necessary, by the Bidder to current prices using the PSA's CPI,

Except under conditions provided for in Section 23.4.2.4 of the 2016 revised IRR of RA No. 9184.

A contract is considered to be "similar" to the contract to be bid if it has the major categories of work stated in the **BDS**.

5.3. For Foreign-funded Procurement, the Procuring Entity and the foreign government/foreign or international financing institution may agree on another track record requirement, as specified in the Bidding Document prepared for this purpose.

5.4. The Bidders shall comply with the eligibility criteria under Section 23.4.2 of the 2016 IRR of RA No. 9184.

6. Origin of Associated Goods

There is no restriction on the origin of Goods other than those prohibited by a decision of the UN Security Council taken under Chapter VII of the Charter of the UN.

7. Subcontracts

7.1. **Subcontracting is not allowed.**

8. Pre-Bid Conference

Not Applicable

9. Clarification and Amendment of Bidding Documents

Prospective bidders may request for clarification on and/or interpretation of any part of the Bidding Documents. Such requests must be in writing and received by the Procuring Entity, either at its given address or through electronic mail indicated in the IB, at least ten (10) calendar days before the deadline set for the submission and receipt of Bids.

10. Documents Comprising the Bid: Eligibility and Technical Components

10.1. The first envelope shall contain the eligibility and technical documents of the Bid as specified in **Section IX. Checklist of Technical and Financial Documents**.

10.2. If the eligibility requirements or statements, the bids, and all other documents for submission to the BAC are in foreign language other than English, it must be accompanied by a translation in English, which shall be authenticated by the appropriate Philippine foreign service establishment, post, or the equivalent office having jurisdiction over the foreign bidder's affairs in the Philippines. For Contracting Parties to the Apostille Convention, only the translated documents shall be authenticated through an apostille pursuant to GPPB Resolution No. 13-2019 dated 23 May 2019. The English translation shall govern, for purposes of interpretation of the bid.

10.3. A valid special PCAB License in case of Joint Ventures, and registration for the type and cost of the contract for this Project. Any additional type of Contractor license or permit shall be indicated in the **BDS**.

10.4. A List of Contractor's key personnel (e.g., Project Manager, Project Engineers, Materials Engineers, and Foremen) assigned to the contract to be bid, with their

complete qualification and experience data shall be provided. These key personnel must meet the required minimum years of experience set in the **BDS**.

10.5. A List of Contractor's major equipment units, which are owned, leased, and/or under purchase agreements, supported by proof of ownership, certification of availability of equipment from the equipment lessor/vendor for the duration of the project, as the case may be, must meet the minimum requirements for the contract set in the **BDS**.

11. Documents Comprising the Bid: Financial Component

11.1. The second bid envelope shall contain the financial documents for the Bid as specified in **Section IX. Checklist of Technical and Financial Documents**.

11.2. Any bid exceeding the ABC indicated in paragraph 1 of the **IB** shall not be accepted.

11.3. For Foreign-funded procurement, a ceiling may be applied to bid prices provided the conditions are met under Section 31.2 of the 2016 revised IRR of RA No. 9184.

12. Alternative Bids

Bidders shall submit offers that comply with the requirements of the Bidding Documents, including the basic technical design as indicated in the drawings and specifications. Unless there is a value engineering clause in the **BDS**, alternative Bids shall not be accepted.

13. Bid Prices

All bid prices for the given scope of work in the Project as awarded shall be considered as fixed prices, and therefore not subject to price escalation during contract implementation, except under extraordinary circumstances as determined by the NEDA and approved by the GPPB pursuant to the revised Guidelines for Contract Price Escalation guidelines.

14. Bid and Payment Currencies

14.1. Bid prices may be quoted in the local currency or tradeable currency accepted by the BSP at the discretion of the Bidder. However, for purposes of bid evaluation, Bids denominated in foreign currencies shall be converted to Philippine currency based on the exchange rate as published in the BSP reference rate bulletin on the day of the bid opening.

14.2. Payment of the contract price shall be made in: **Philippine Pesos**.

15. Bid Security

15.1. The Bidder shall submit a Bid Securing Declaration or any form of Bid Security in the amount indicated in the **BDS**, which shall be not less than the percentage of the ABC in accordance with the schedule in the **BDS**.

15.2. The Bid and bid security shall be valid for **120 Calendar Days** upon opening of bids. Any bid not accompanied by an acceptable bid security shall be rejected by the Procuring Entity as non-responsive.

16. Sealing and Marking of Bids

Each Bidder shall submit one copy of the first and second components of its Bid. The Procuring Entity may request additional hard copies and/or electronic copies of the Bid. However, failure of the Bidders to comply with the said request shall not be a ground for disqualification.

If the Procuring Entity allows the submission of bids through online submission to the given website or any other electronic means, the Bidder shall submit an electronic copy of its Bid, which must be digitally signed. An electronic copy that cannot be opened or is corrupted shall be considered non-responsive and, thus, automatically disqualified.

17. Deadline for Submission of Bids

17.1 Bids must be delivered to the Ralota Hall, Gov. Douglas Ra. Cagas Cultural Sports and Business Complex, Barangay Matti, Digos City, Davao del Sur **on or before February 27, 2024 at 9:00 A.M.** Late bids shall not be accepted. All bids must be accompanied by a bid security in any of the acceptable forms and in the amount stated in ITB Clause 18.

18. Opening and Preliminary Examination of Bids

18.1. The BAC shall open the Bids in public at the time, on the date, and at the place specified in paragraph 9 of the **IB**. The Bidders' representatives who are present shall sign a register evidencing their attendance. In case videoconferencing, webcasting or other similar technologies will be used, attendance of participants shall likewise be recorded by the BAC Secretariat.

In case the Bids cannot be opened as scheduled due to justifiable reasons, the rescheduling requirements under Section 29 of the 2016 revised IRR of RA No. 9184 shall prevail.

18.2. The preliminary examination of Bids shall be governed by Section 30 of the 2016 revised IRR of RA No. 9184.

19. Detailed Evaluation and Comparison of Bids

19.1. The Procuring Entity's BAC shall immediately conduct a detailed evaluation of all Bids rated "*passed*" using non-discretionary pass/fail criteria. The BAC shall consider the conditions in the evaluation of Bids under Section 32.2 of 2016 revised IRR of RA No. 9184.

19.2. If the Project allows partial bids, all Bids and combinations of Bids as indicated in the **BDS** shall be received by the same deadline and opened and evaluated simultaneously so as to determine the Bid or combination of Bids offering the lowest calculated cost to the Procuring Entity. Bid Security as required by ITB Clause 15 shall be submitted for each contract (lot) separately.

19.3. In all cases, the NFCC computation pursuant to Section 23.4.2.6 of the 2016 revised IRR of RA No. 9184 must be sufficient for the total of the ABCs for all the lots participated in by the prospective Bidder.

20. Post Qualification

Within a non-extendible period of five (5) calendar days from receipt by the Bidder of the notice from the BAC that it submitted the Lowest Calculated Bid, the Bidder shall submit its latest income and business tax returns filed and paid through the BIR Electronic Filing and Payment System (eFPS), and other appropriate licenses and permits required by law and stated in the **BDS**.

21. Signing of the Contract

The documents required in Section 37.2 of the 2016 revised IRR of RA No. 9184 shall form part of the Contract. Additional Contract documents are indicated in the **BDS**.



SECTION III.

BID DATA SHEET

Bid Data Sheet

(IB No.: C-164-23)

ITB Clause	
5.2	For this purpose, contracts similar to the Project refer to contracts which have the same major categories of work, which shall be: Buildings: Construction or Repair
7.1	(Based on DPWH DO 14 Series of 2017) Subcontracting is not allowed.
10.3	<i>"No further instructions."</i>
10.4	The key personnel must meet the required minimum years of experience set below: <u>Key Personnel</u> <u>General Experience</u> <u>Relevant Experience</u>
10.5	<i>"No further instructions."</i> The minimum major equipment requirements are the following: <u>Equipment</u> <u>Capacity</u> <u>Number of Units</u>
12	<i>"No further instructions."</i> None.
15.1	The bid security shall be in the form of a Bid Securing Declaration or any of the following forms and amounts: a. The amount of not less than P148,000.00 <i>two percent (2%) of ABCI</i> , if bid security is in cash, cashier's/manager's check, bank draft/guarantee or irrevocable letter of credit; b. The amount of not less than P370, 000.00 <i>five percent (5%) of ABCI</i> , if bid security is in Surety Bond.
19.2	Partial bid is not allowed. The infrastructure project is packaged in a single lot and the lot shall not be divided into sub-lots for the purpose of bidding, evaluation, and contract award.
20	In all cases, the NFCC computation must be sufficient for the contract to be awarded to the Bidder. <i>Permits and Clearances as required by the End-User.</i> <i>Post-Qualification Requirements: Latest Income Tax Returns, Business Tax Returns for the last 6 months.</i>
21	1. Presentation of the Bidding Documents a. Envelope 1 (Eligibility/ Technical Documents) One (1) ORIGINAL COPY, another copy for COPY 1, and another copy for COPY 2. b. Envelope 2 (Financial Proposal) One (1) ORIGINAL COPY, another copy for COPY 1, and another copy for COPY 2. Such documents shall be duly signed by the bidders or its duly authorized

A

<p>representative/s.</p>	<p>Eligibility/Technical and Financial Proposal must be book bound and properly tabbed at the right side. Any documents submitted not book bound shall be rejected outright. For the Financial Proposal not exceeding ten (10) pages maybe book bound or securely stapled.</p> <p>All copies must be properly marked (ORIGINAL COPY, COPY 1 AND COPY 2)</p> <p>Envelope 1 and Envelope 2 must be properly sealed, and will be placed in one sealed mother envelope.</p> <p>2. Other documents/materials to comply with other non-discretionary criteria and requirements as stated in the Instruction to Bidders:</p> <ul style="list-style-type: none"> - Construction Methods - Construction schedule and S-Curve - Pert-CPM - Manpower Utilization Schedule - Equipment Utilization Schedule - Construction Safety & Health Program - Affidavit of Site Inspection - Duly Notarized Certification as to compliance to Labor Laws and Standard <p>The DOLE approved Construction Safety and Health Program is required before entering into Contract.</p>
--------------------------	--

SECTION IV.

GENERAL CONDITIONS OF CONTRACT

A

General Conditions of Contract

1. Scope of Contract

This Contract shall include all such items, although not specifically mentioned, that can be reasonably inferred as being required for its completion as if such items were expressly mentioned herein. All the provisions of RA No. 9184 and its 2016 revised IRR, including the Generic Procurement Manual, and associated issuances, constitute the primary source for the terms and conditions of the Contract, and thus, applicable in contract implementation. Herein clauses shall serve as the secondary source for the terms and conditions of the Contract.

This is without prejudice to Sections 74.1 and 74.2 of the 2016 revised IRR of RA No. 9184 allowing the GPPB to amend the IRR, which shall be applied to all procurement activities, the advertisement, posting, or invitation of which were issued after the effectivity of the said amendment.

2. Sectional Completion of Works

If sectional completion is specified in the Special Conditions of Contract (SCC), references in the Conditions of Contract to the Works, the Completion Date, and the Intended Completion Date shall apply to any Section of the Works (other than references to the Completion Date and Intended Completion Date for the whole of the Works).

3. Possession of Site

3.1 The Procuring Entity shall give possession of all or parts of the Site to the Contractor based on the schedule of delivery indicated in the SCC, which corresponds to the execution of the Works. If the Contractor suffers delay or incurs cost from failure on the part of the Procuring Entity to give possession in accordance with the terms of this clause, the Procuring Entity's Representative shall give the Contractor a Contract Time Extension and certify such sum as fair to cover the cost incurred, which sum shall be paid by Procuring Entity.

3.2 If possession of a portion is not given by the above date, the Procuring Entity will be deemed to have delayed the start of the relevant activities. The resulting adjustments in contract time to address such delay may be addressed through contract extension provided under Annex "E" of the 2016 revised IRR of RA No. 9184.

4. The Contractor's Obligations

The Contractor shall employ the key personnel named in the Schedule of Key Personnel indicating their designation, in accordance with ITB Clause 10.3 and specified in the BDS, to carry out the supervision of the Works.

The Procuring Entity will approve any proposed replacement of key personnel only if their relevant qualifications and abilities are equal to or better than those of the personnel listed in the Schedule.

5. Performance Security



5.1. Within ten (10) calendar days from receipt of the Notice of Award from the Procuring Entity but in no case later than the signing of the contract by both parties, the successful

Bidder shall furnish the performance security in any of the forms prescribed in Section 39 of the 2016 revised IRR.

5.2. The Contractor, by entering into the Contract with the Procuring Entity, acknowledges the right of the Procuring Entity to institute action pursuant to RA No. 3688 against any subcontractor be they an individual, firm, partnership, corporation, or association supplying the Contractor with labor, materials and/or equipment for the performance of this Contract.

6. Site Investigations

The Contractor, in preparing the Bid, shall rely on any Site Investigation Reports referred to in the SCC supplemented by any information obtained by the Contractor.

7. Warranty

7.1. In case the Contractor fails to undertake the repair works under Section 62.2.2 of the 2016 revised IRR, the Procuring Entity shall forfeit its performance security, subject its property(ies) to attachment or garnishment proceedings, and perpetually disqualify it from participating in any public bidding. All payables of the GOP in his favor shall be offset to recover the costs.

7.2. The warranty against Structural Defects/Failures, except that occasioned-on force majeure, shall cover the period from the date of issuance of the Certificate of Final Acceptance by the Procuring Entity. Specific duration of the warranty is found in the SCC.

8. Liability of the Contractor

Subject to additional provisions, if any, set forth in the SCC, the Contractor's liability under this Contract shall be as provided by the laws of the Republic of the Philippines.

If the Contractor is a joint venture, all partners to the joint venture shall be jointly and severally liable to the Procuring Entity.

9. Termination for Other Causes

Contract termination shall be initiated in case it is determined prima facie by the Procuring Entity that the Contractor has engaged, before, or during the implementation of the contract, in unlawful deeds and behaviors relative to contract acquisition and implementation, such as, but not limited to corrupt, fraudulent, collusive, coercive, and obstructive practices as stated in ITB Clause 4.

10. Dayworks

Subject to the guidelines on Variation Order in Annex "E" of the 2016 revised IRR of RA No. 9184, and if applicable as indicated in the SCC, the Dayworks rates in the Contractor's Bid shall be used for small additional amounts of work only when the Procuring Entity's Representative has given written instructions in advance for additional work to be paid for in that way.

11. Program of Work

11.1. The Contractor shall submit to the Procuring Entity's Representative for approval the said Program of Work showing the general methods, arrangements, order, and timing for all the activities in the Works. The submissions of the Program of Work are indicated in the SCC.

11.2. The Contractor shall submit to the Procuring Entity's Representative for approval an updated Program of Work at intervals no longer than the period stated in the SCC. If the Contractor does not submit an updated Program of Work within this period, the Procuring Entity's Representative may withhold the amount stated in the SCC from the next payment certificate and continue to withhold this amount until the next payment after the date on which the overdue Program of Work has been submitted.

12. Instructions, Inspections and Audits

The Contractor shall permit the GOP or the Procuring Entity to inspect the Contractor's accounts and records relating to the performance of the Contractor and to have them audited by auditors of the GOP or the Procuring Entity, as may be required.

13. Advance Payment

The Procuring Entity shall, upon a written request of the Contractor which shall be submitted as a Contract document, make an advance payment to the Contractor in an amount not exceeding fifteen percent (15%) of the total contract price, to be made in lump sum, or at the most two installments according to a schedule specified in the SCC, subject to the requirements in Annex "E" of the 2016 revised IRR of RA No. 9184.

14. Progress Payments

The Contractor may submit a request for payment for Work accomplished. Such requests for payment shall be verified and certified by the Procuring Entity's Representative/Project Engineer. Except as otherwise stipulated in the SCC, materials and equipment delivered on the site but not completely put in place shall not be included for payment.

15. Operating and Maintenance Manuals

15.1. If required, the Contractor will provide "as built" Drawings and/or operating and maintenance manuals as specified in the SCC.

15.2. If the Contractor does not provide the Drawings and/or manuals by the dates stated above, or they do not receive the Procuring Entity's Representative's approval, the Procuring Entity's Representative may withhold the amount stated in the SCC from payments due to the Contractor.

SECTION V.

**SPECIAL CONDITIONS
OF CONTRACT**

A

Special Conditions of Contract

GCC Clause	
2	<i>The Intended Completion Date is 75 calendar days upon receipt of the Notice to Proceed.</i>
4.1	<i>The Procuring Entity shall give possession in full the parts of the Site to the Contractor upon receipt of the Notice to Proceed.</i>
6	The site investigation reports are: Site Inspection Report
7.2	<i>[In case of semi-permanent structures, such as buildings of types 1, 2, and 3 as classified under the National Building Code of the Philippines, concrete/asphalt roads, concrete river control, drainage, irrigation lined canals, river landing, deep wells, rock causeway, pedestrian overpass, and other similar semi-permanent structures.] Five (5) years.</i>
10	a. Day works are applicable at the rate shown in the Contractor's original Bid.
11.1	"No further instruction."
11.2	"No further instruction."
13	The amount of the advance payment shall not exceed Fifteen Percent (15%) of the total contract price to be recouped every progress billing.
14	Materials and equipment delivered on the site but not completely put in place shall not be included for payment.
15.1	"No further instructions." The date by which "as built" drawings are required is 15 days prior turn-over and acceptance.
15.2	"No further instructions."



SECTION VI.

SPECIFICATIONS

[See attached file.]



Name of Project : REPAIR/IMPROVEMENT OF SANGGUNIAN PANLALAWIGAN BUILDING
 Location : MATTI, DIGOS CITY, DAVAO DEL SUR

SPECIFICATIONS

<i>Item</i>	<i>Description</i>	<i>Unit</i>	<i>Quantity</i>
B.5	Project Billboard/Signboard	each	1.00
B.7	Occupational Safety and Health	l.s.	1.00
801(1)	Removal of Structures and Obstruction	l.s.	1.00
803(1)a	Structure Excavation, (Common Soil)	cu.m.	34.26
804(7)	Gravel-Fill	cu.m.	8.39
900(2)a	Structural Concrete, Class B, 7 Days	cu.m.	37.97
902(1)a1	Reinforcing Steel (Deformed) Grade 40	kgs.	381.60
903(1)	Formworks and Falseworks	l.s.	1.00
1046(2)a1	CHB Non-Load Bearing(Including reinforcing Steel),100mm	sq.m.	43.22
1027(1)	Cement Plaster Finish	sq.m.	43.43
1010(2)b	Doors (Wood Panel)	sq.m.	69.72
1010(1)	Frames (Jambs, Sills, Head Transoms and Mullions)	set	22.00
1004 (2)	Finishing Hardware	l.s.	1.00
1003 (17)	Carpentry & Joinery Works	l.s.	1.00
1003(1)e	Gypsum Board on Metal Frame Ceiling	sq.m.	13.26
1003(1)	4.5 mm Marine Plywood on metal frame ceiling	sq.m.	613.40
1018 (1)	Glazed Tiles	sq.m.	260.10
1018	Unglazed Tiles	sq.m.	89.00
1007(1)d	Aluminum Glass Door, (Sliding/Fixed Type)	sq.m.	19.62
1003(2)	6.0mm thk. Fiber Cement Board on Metal Frame Double Wall Partition	sq.m.	98.18
1014(1)b2	Pre-painted Metal Sheets, above 0.427 mm, Rib Type, Long Span	sq.m.	481.41
1013(2)az	Fabricated Metal Roofing Accessory, Gauge 26 (0.551 mm), Flashing	Ln.m.	171.00
1013(2)b1	Fabricated Metal Roofing Accessory, Gauge 24 (0.701 mm), Gutters	Ln.m.	29.49
1002(4)	Plumbing Fixtures	l.s.	1.00
1001(11)	Septic Vault/Tank, Concrete/CHB	l.s.	1.00

1019(1)	Wood Tiles (Narra, Tanguile, others)	sq.m.	12.00	/
1047 (8)	Structural Steel	l.s.	1.00	/
1001(9)	Storm Drainage Downspout	l.s.	1.00	/
1032(1)a	Painting Works, Masonry/Concrete	sq.m.	1200.00	/
1032(1)b	Painting Works, Wood	sq.m.	901.73	/
1032(1)c	Painting Works, Steel	sq.m.	80.00	/
SPL-I	Siphoning/Cleaning of Septic Tank	l.s.	1.00	/
SPL-II	Supply & Installation of Ergodynamic Deluxe Theater Seat	l.s.	1.00	/
SPL-III	Installation of WPC Flute Panel	sq.m.	104.00	/
SPL-IV	Tempered Glass Railing	l.s.	1.00	/
SPL-V	20mm thk. Granite Slab	sq.m.	13.88	/
SPL-VI	PVC Ceiling	sq.m.	143.70	/
SPL-VII	Carpet Floor	sq.m.	276.00	/
SPL VIII	Davao del Sur Logo	l.s.	1.00	/
1100 (10)	Conduits, Boxes & Fittings (Conduit Works/Conduit Rough-in)	l.s.	1.00	/
1101(33)	Wires and Wiring Devices	l.s.	1.00	/
1103 (1)	Lighting Fixtures	l.s.	1.00	/
1200 (1)	Ventilating Equipment	l.s.	1.00	/


NOTE:

Specifications shall be in accordance with the DPWH Standard Specifications for Public Works Structures. Volume III 2019

Prepared by:


REXIE GREY B. TABAY
 Architect III

Reviewed by:

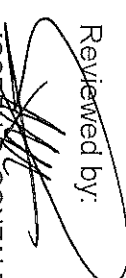
JOSEPH R. GONZALES
 Engineer III
 Planning and Programming Division Head

Recommending Approval:


LEONARDO M. SUARIO
 Provincial Engineer

SECTION VII.


DRAWINGS

[The **Detailed Engineering Design** is available at the Provincial Government of Davao del Sur, Procurement Management Office, Office of the BAC Secretariat for Infrastructure Projects, Room 16, Executive Building of Provincial Capitol, Mati, Digos City, upon purchase of the corresponding bidding documents.]





REPUBLIC OF THE PHILIPPINES
PROVINCE OF DAVAO DEL SUR
PROVINCIAL ENGINEER'S OFFICE
SAN AGUSTIN, DIGOS CITY, DAVAO DEL SUR

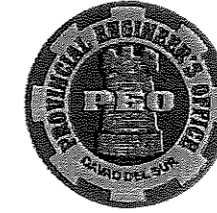


DETAILED ARCHITECTURAL AND ENGINEERING DESIGN
FOR

REPAIR /IMPROVEMENT OF SANGGUNIANG PANLALAWIGAN BUILDING

LOCATION: MATTI, DIGOS CTIY, DAVAO DEL SUR

SUBMITTED:

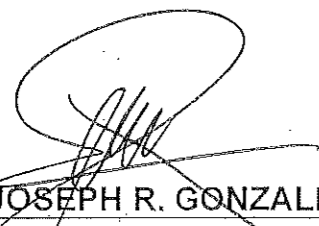

JOSEPH R. GONZALES
ENGINEER III
PLANNING AND PROGRAMMING DIVISION HEAD

RECOMMENDING APPROVAL:



LEONERL MARCH P. SUARIO
PROVINCIAL ENGINEER

APPROVED:



YVONNE RONA CAGAS
PROVINCIAL GOVERNOR

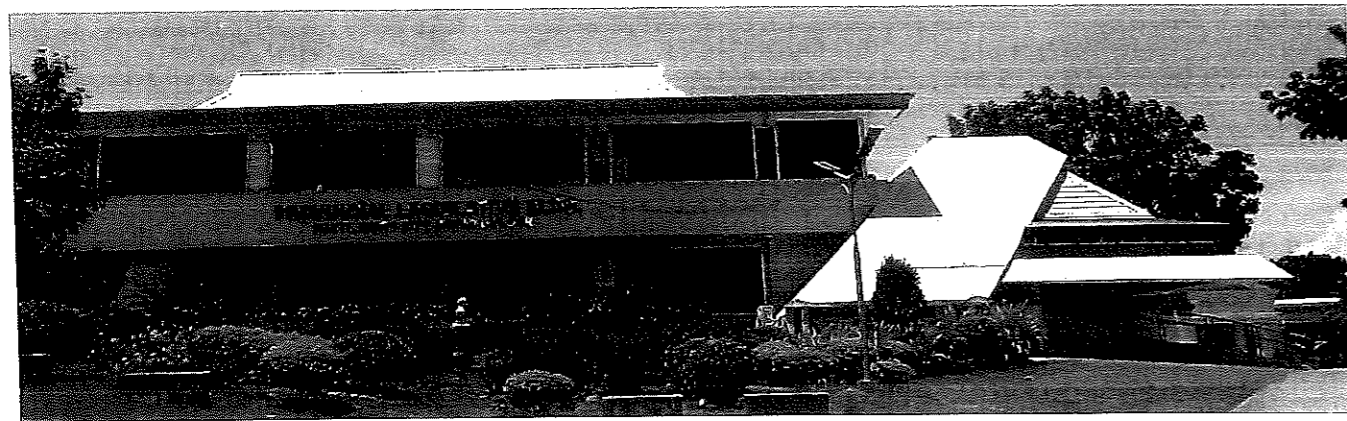

1 PERSPECTIVE
A-1 DRAWN NOT TO SCALE

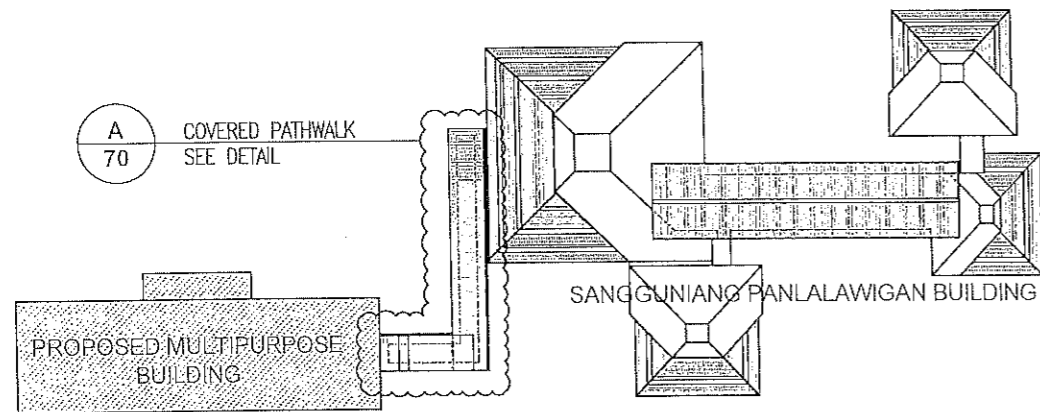

2 SITE DEVELOPMENT PLAN
A-1 SCALE 1:1500 M.

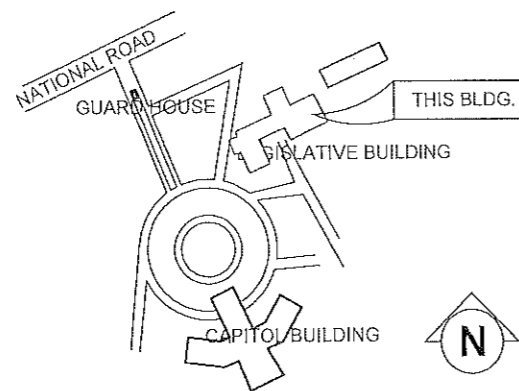


3 VICINITY MAP
A-1

TABLE OF CONTENTS

PAGE NO.	DESCRIPTION	PAGE NO.	DESCRIPTION
A-1	PERSPECTIVE VICINITY MAP SITE DEV. PLAN	A-42	TOILET-3 FEMALE TOILET @ 2ND FLR.
A-2	1ST FLOOR LEVEL	A-43	PERSPECTIVE
A-3	2ND FLOOR LEVEL	A-44	EXISTING FLOOR PLAN PROPOSED FLOOR PLAN FLOOR TILE LAYOUT CEILING PLAN
A-4	3RD FLOOR LEVEL	A-45	TYPICAL CONCRETE COUNTER DET. TYPICAL WATER CLOSET DET. TYPICAL COUNTERTOP LAVATORY DET.
A-5	ROOF PLAN	A-46	SECTION A-A TOILET PAPER HOLDER-TYPICAL TYPICAL LAV. FAUCET DET. TYPICAL URINAL DETAIL TOILET-3 LIGHTING LAYOUT
A-6	SCHEDULE OF DOORS	A-47	TOILET-4 MALE TOILET @ 2ND FLR.
A-7	BLOW UP DETAIL CANOPY ROOFING DETAIL SHELVES DETAIL SEPTIC TANK DETAIL WALL FOOTING (WF-01)DET.	A-48	PERSPECTIVE
A-8	SESSION HALL	A-49	EXISTING FLOOR PLAN PROPOSED FLOOR PLAN FLOOR TILE LAYOUT CEILING PLAN
A-9	SESSION HALL @ 2ND FLOOR	A-50	TYPICAL CONCRETE COUNTER DET. TYPICAL WATER CLOSET DET. TYPICAL COUNTERTOP LAVATORY DET.
A-10	PERSPECTIVE FLOOR PLAN	A-51	TOILET PAPER HOLDER-TYPICAL TYPICAL LAV. FAUCET DET. TYPICAL URINAL DETAIL TOILET-4 LIGHTING LAYOUT
A-11	SECTION THRU B-B	A-52	TOILET-5 TOILET - 5 @ 3RD FLR.
A-12	SECTION THRU A-A	A-53	PERSPECTIVE
A-13	SECTION THRU C-C	A-54	EXISTING FLOOR PLAN PROPOSED FLOOR PLAN FLOOR TILE LAYOUT CEILING PLAN
A-14	CLADDING DETAIL BACKWALL DETAIL FLOOR TILES DETAIL DELUXED THEATER SEAT DETAIL CEILING PERSPECTIVE @ SESSION HALL CEILING DETAIL SESSION HALL LIGHTING & POWER LAYOUT	A-55	TYPICAL CONCRETE COUNTER DET. TYPICAL WATER CLOSET DET. TYPICAL COUNTERTOP LAVATORY DET.
A-15	LOUNGE & MESH HALL	A-56	TOILET PAPER HOLDER-TYPICAL TYPICAL LAV. FAUCET DET. TYPICAL URINAL DETAIL TOILET-5 LIGHTING LAYOUT
A-16	LOUNGE	A-57	PERSPECTIVE
A-17	PERSPECTIVE LOUNGE @ 2ND LVL. PERSPECTIVE MESH HALL @ 2ND LVL.	A-58	EXISTING FLOOR PLAN PROPOSED FLOOR PLAN FLOOR TILE LAYOUT CEILING PLAN
A-18	FLOOR PLAN SECTION A SECTION B CEILING DETAIL LOUNGE LIGHTING LAYOUT	A-59	TYPICAL WATER CLOSET DET. TYPICAL COUNTERTOP LAVATORY DET.
A-19	EX-OFFICIO	A-60	TOILET PAPER HOLDER-TYPICAL TYPICAL LAV. FAUCET DET. TYPICAL CONCRETE COUNTER DET. TOILET-5 LIGHTING LAYOUT
A-20	EX-OFFICIO @ 3RD LEVEL	A-61	TOILET-6 & PANTRY TOILET - 6 & PANTRY DET. PERSPECTIVE
A-21	PERSPECTIVE EX-OFFICIO	A-62	EXISTING FLOOR PLAN PROPOSED FLOOR PLAN SECTION A-A ROOF PLAN CEILING PLAN
A-22	CEILING PLAN SECTION A EX-OFFICIO LIGHTING LAYOUT	A-63	TYPICAL WATER CLOSET DET. TYPICAL COUNTERTOP LAVATORY DET. TYPICAL LAV. FAUCET DET. KITCHEN SINK DETAIL TYPICAL CONCRETE COUNTER DET. ELECTRICAL PLAN
A-23	TOILET-1	A-64	COVERED PATHWALK
A-24	MALE TOILET @ 1ST FLOOR	A-65	KEY PLAN
A-25	PERSPECTIVE TOILET-1 @ 1ST FLOOR	A-66	PERSPECTIVE
A-26	EXISTING FLOOR PLAN PROPOSED FLOOR PLAN FLOOR TILE LAYOUT CEILING PLAN TYPICAL CUBICLE DETAIL TYPICAL CONCRETE COUNTER DET. TYPICAL WATER CLOSET DET. TYPICAL COUNTERTOP LAVATORY DET. TOILET PAPER HOLDER-TYPICAL TYPICAL LAV. FAUCET DET. TYPICAL URINAL DETAIL TOILET-1 LIGHTING LAYOUT	A-67	CROSS SECTION
A-27	TOILET-2	A-68	FRONT VIEW
A-28	FEMALE TOILET @ 1ST FLR.	A-69	FOUNDATION PLAN
A-29	PERSPECTIVE	A-70	ROOF PLAN
A-30	EXISTING FLOOR PLAN PROPOSED FLOOR PLAN FLOOR TILE LAYOUT CEILING PLAN TYPICAL CONCRETE COUNTER DET. TYPICAL WATER CLOSET DET. TYPICAL COUNTERTOP LAVATORY DET. TOILET PAPER HOLDER-TYPICAL TYPICAL LAV. FAUCET DET. TYPICAL URINAL DETAIL TOILET-2 LIGHTING LAYOUT	A-71	F-C1 DETAIL
A-31	TOILET-3	A-72	WALL FOOTING DETAIL LIGHTING LAYOUT
A-32	FEMALE TOILET @ 2ND FLR.	A-73	GENSET ROOM
A-33	PERSPECTIVE	A-74	GENSET ROOM KEY PLAN
A-34	EXISTING FLOOR PLAN PROPOSED FLOOR PLAN FLOOR TILE LAYOUT CEILING PLAN TYPICAL CONCRETE COUNTER DET. TYPICAL WATER CLOSET DET. TYPICAL COUNTERTOP LAVATORY DET. TOILET PAPER HOLDER-TYPICAL TYPICAL LAV. FAUCET DET. TYPICAL URINAL DETAIL TOILET-2 LIGHTING LAYOUT	A-75	PERSPECTIVE
A-35	TOILET-4	A-76	FLOOR PLAN
A-36	MALE TOILET @ 2ND FLR.	A-77	FOUNDATION PLAN
A-37	PERSPECTIVE	A-78	CROSS SECTION
A-38	EXISTING FLOOR PLAN PROPOSED FLOOR PLAN FLOOR TILE LAYOUT CEILING PLAN TYPICAL CONCRETE COUNTER DET. TYPICAL WATER CLOSET DET. TYPICAL COUNTERTOP LAVATORY DET. TOILET PAPER HOLDER-TYPICAL TYPICAL LAV. FAUCET DET. TYPICAL URINAL DETAIL TOILET-2 LIGHTING LAYOUT	A-79	FRONT ELEVATION
A-39	TOILET-5	A-80	LIGHTING LAYOUT
A-40	TOILET - 5 @ 3RD FLR.	A-81	
A-41	PERSPECTIVE	A-82	
A-42	EXISTING FLOOR PLAN PROPOSED FLOOR PLAN FLOOR TILE LAYOUT CEILING PLAN	A-83	
A-43	TYPICAL CONCRETE COUNTER DET. TYPICAL WATER CLOSET DET. TYPICAL COUNTERTOP LAVATORY DET.	A-84	
A-44	TOILET PAPER HOLDER-TYPICAL TYPICAL LAV. FAUCET DET. TYPICAL URINAL DETAIL TOILET-4 LIGHTING LAYOUT	A-85	
A-45	TOILET-4 MALE TOILET @ 2ND FLR.	A-86	
A-46	PERSPECTIVE	A-87	
A-47	EXISTING FLOOR PLAN PROPOSED FLOOR PLAN FLOOR TILE LAYOUT CEILING PLAN	A-88	
A-48	TYPICAL CONCRETE COUNTER DET. TYPICAL WATER CLOSET DET. TYPICAL COUNTERTOP LAVATORY DET.	A-89	
A-49	TOILET PAPER HOLDER-TYPICAL TYPICAL LAV. FAUCET DET. TYPICAL URINAL DETAIL TOILET-4 LIGHTING LAYOUT	A-90	
A-50	TOILET-5 TOILET - 5 @ 3RD FLR.	A-91	
A-51	PERSPECTIVE	A-92	
A-52	EXISTING FLOOR PLAN PROPOSED FLOOR PLAN FLOOR TILE LAYOUT CEILING PLAN	A-93	
A-53	TYPICAL CONCRETE COUNTER DET. TYPICAL WATER CLOSET DET. TYPICAL COUNTERTOP LAVATORY DET.	A-94	
A-54	TOILET PAPER HOLDER-TYPICAL TYPICAL LAV. FAUCET DET. TYPICAL URINAL DETAIL TOILET-5 LIGHTING LAYOUT	A-95	
A-55	TOILET-6 & PANTRY TOILET - 6 & PANTRY DET. PERSPECTIVE	A-96	
A-56	EXISTING FLOOR PLAN PROPOSED FLOOR PLAN SECTION A-A ROOF PLAN CEILING PLAN	A-97	
A-57	TYPICAL WATER CLOSET DET. TYPICAL COUNTERTOP LAVATORY DET. TYPICAL LAV. FAUCET DET. KITCHEN SINK DETAIL TYPICAL CONCRETE COUNTER DET. ELECTRICAL PLAN	A-98	
A-58	COVERED PATHWALK	A-99	
A-59	KEY PLAN	A-100	
A-60	PERSPECTIVE	A-101	
A-61	CROSS SECTION	A-102	
A-62	FRONT VIEW	A-103	
A-63	FOUNDATION PLAN	A-104	
A-64	ROOF PLAN	A-105	
A-65	F-C1 DETAIL	A-106	
A-66	WALL FOOTING DETAIL LIGHTING LAYOUT	A-107	
A-67	GENSET ROOM	A-108	
A-68	GENSET ROOM KEY PLAN	A-109	
A-69	PERSPECTIVE	A-110	
A-70	FLOOR PLAN	A-111	
A-71	FOUNDATION PLAN	A-112	
A-72	CROSS SECTION	A-113	
A-73	FRONT ELEVATION	A-114	
A-74	LIGHTING LAYOUT	A-115	
A-75		A-116	
A-76		A-117	
A-77		A-118	
A-277		A-318	
A-2			

SCOPE OF WORKS :

- REPAIR/IMPROVEMENT OF TOILET 1,2 AND 6.
- SIPHONING OF TWO (2) SEPTIC TANK.
- CONSTRUCTION OF 1-UNIT SEPTIC TANK.
- CONSTRUCTION OF PANTRY.
- CONSTRUCTION OF GENSET HOUSING.
- FIXING/REPAIR OF GLASS DOORS.
- INSTALLATION OF PANELS DOORS.
- INSTALLATION,REPAIR OF ELECTRICAL LINES AND FIXTURES.
- INSTALLATION,REPAIR OF SANITARY AND PLUMBING LINES.
- REPAIR OF WATER LEAKS
- REPAINTING OF INTERIOR & EXTERIOR WALLS.

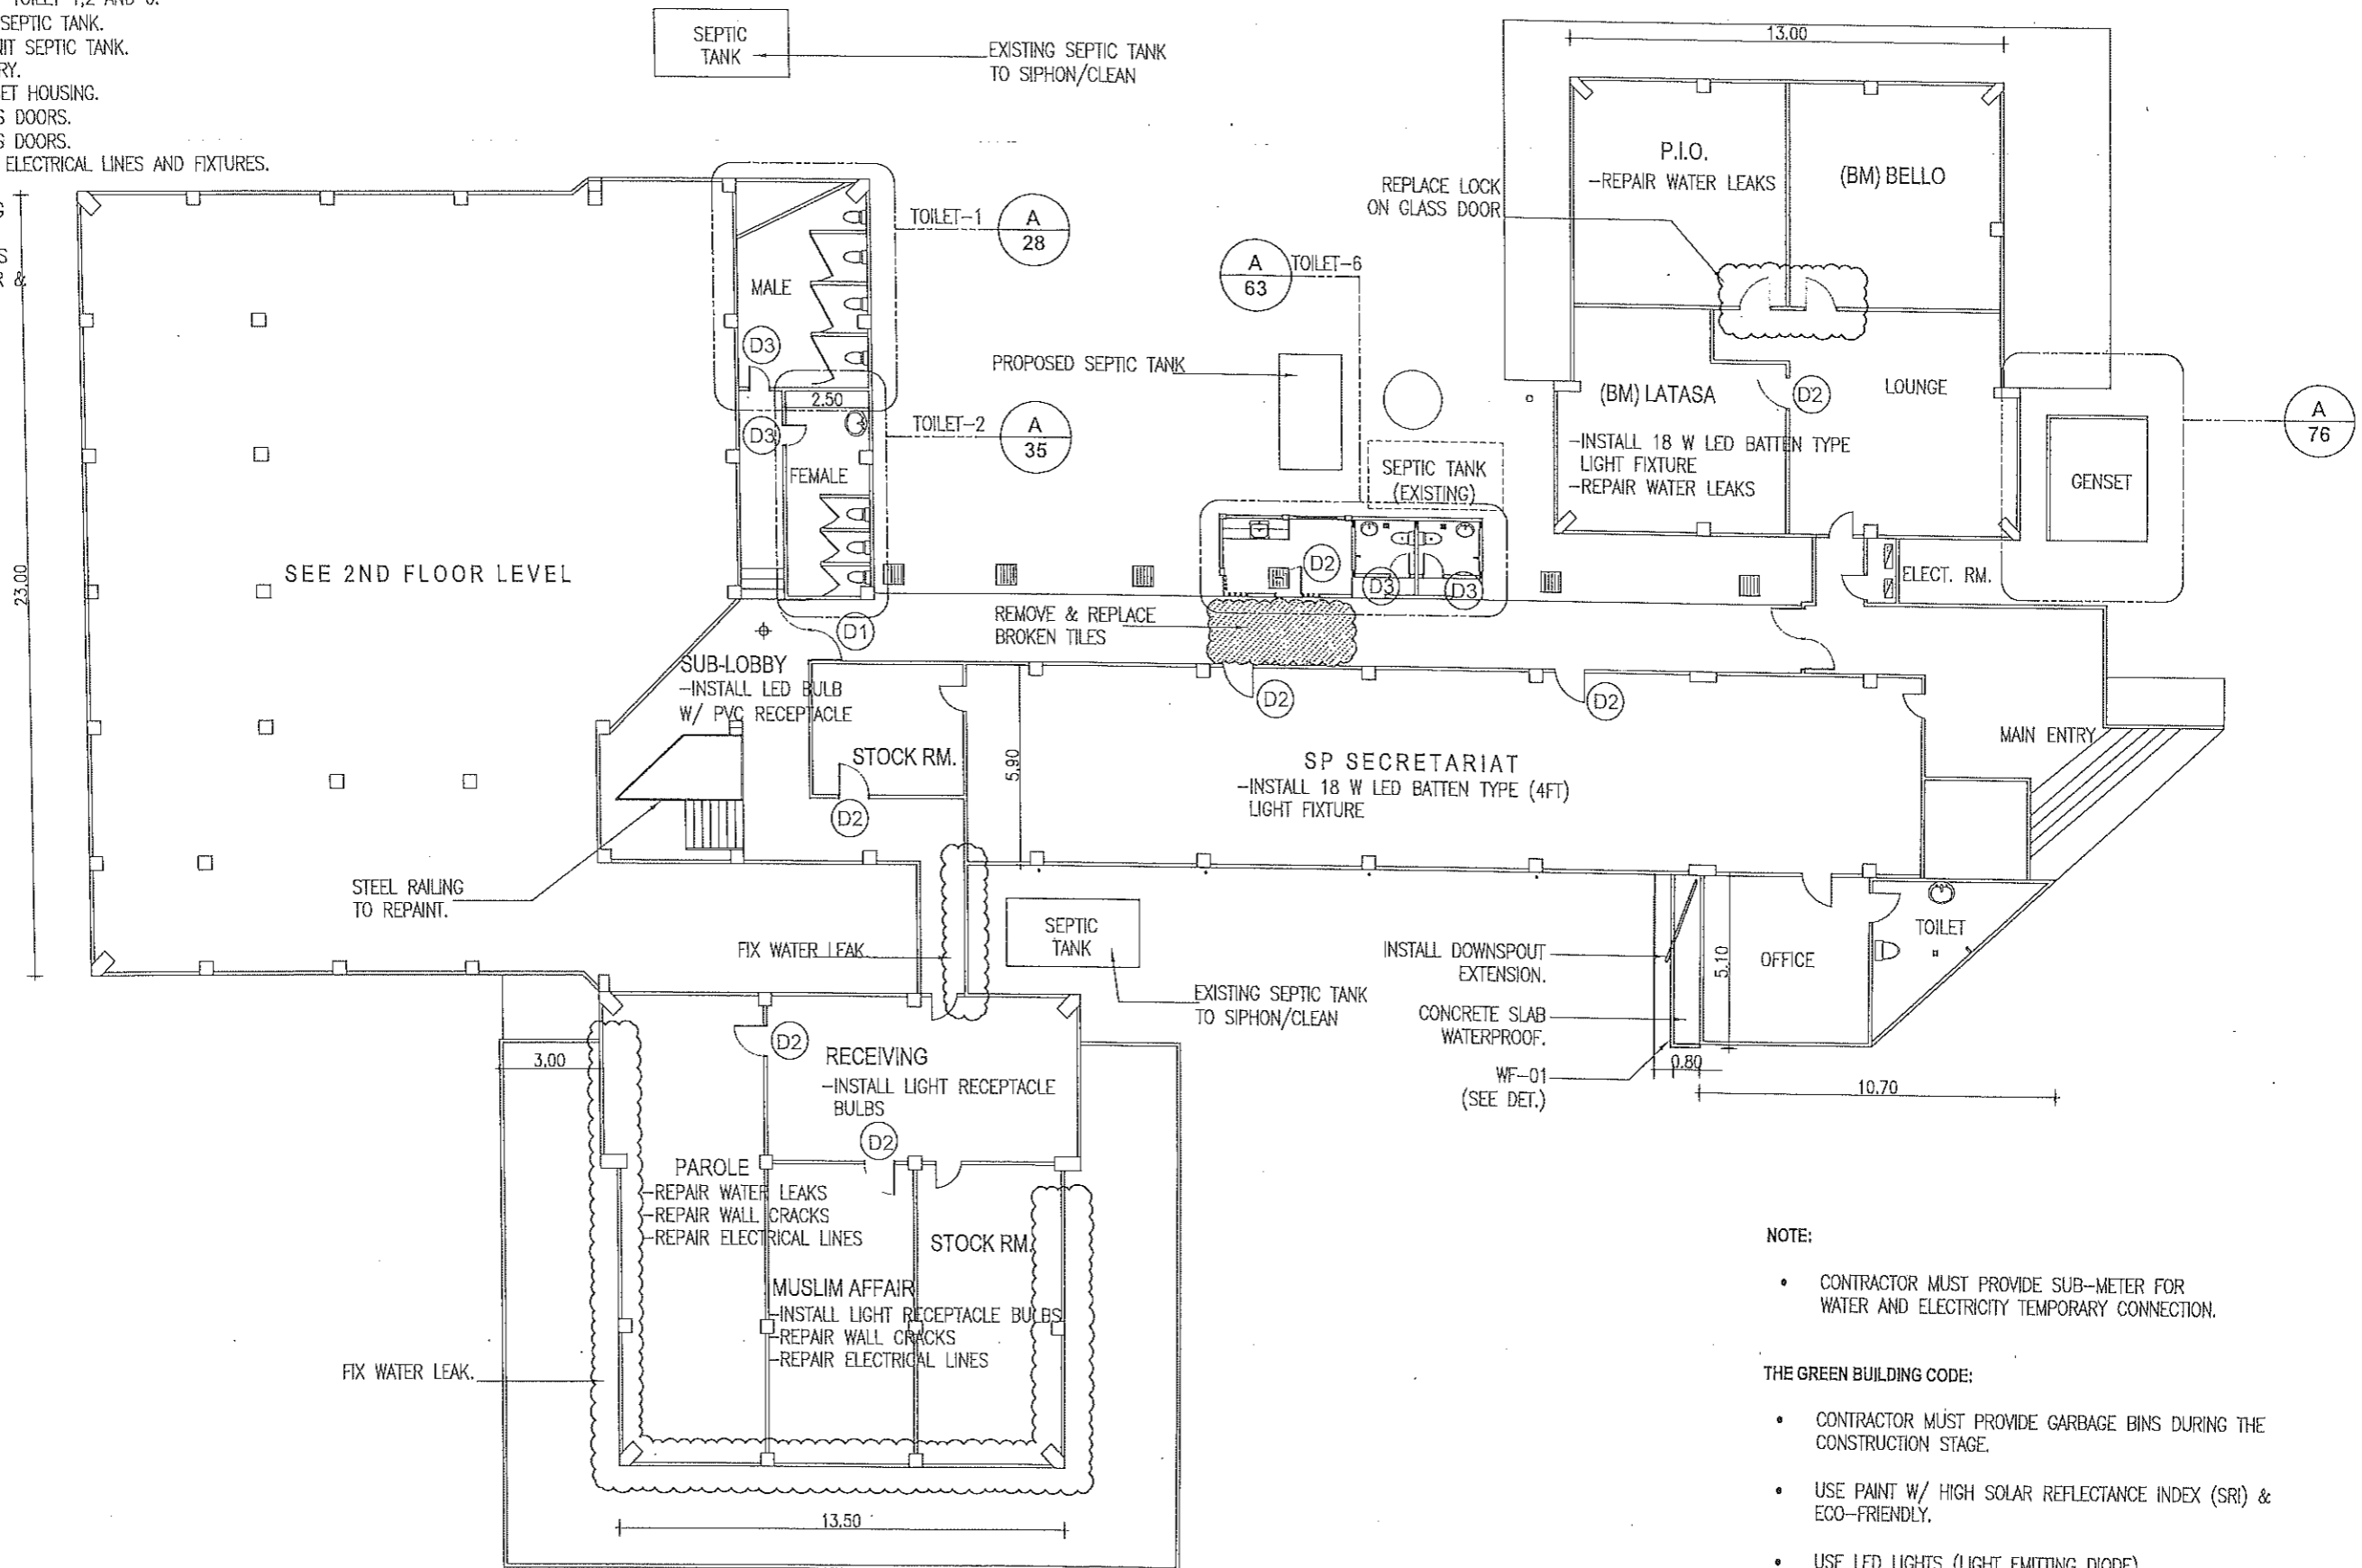

NOTE:

- CONTRACTOR MUST PROVIDE SUB-METER FOR WATER AND ELECTRICITY TEMPORARY CONNECTION.

THE GREEN BUILDING CODE:

- CONTRACTOR MUST PROVIDE GARBAGE BINS DURING THE CONSTRUCTION STAGE.
- USE PAINT W/ HIGH SOLAR REFLECTANCE INDEX (SRI) & ECO-FRIENDLY.
- USE LED LIGHTS (LIGHT EMITTING DIODE).
- USE EFFECIENT WATER FIXTURES(FAUCET,URINALS,WATER CLOSET)

1 1ST FLOOR LEVEL
A-2 SCALE 1:150



REPUBLIC OF THE PHILIPPINES
PROVINCIAL ENGINEER'S OFFICE
SAN AGUSTIN, DIGOS CITY, DAVAO DEL SUR

PROJECT TITLE:
**REPAIR /IMPROVEMENT OF SANGGUNIANG
PANLALAWIGAN BUILDING**

LOCATION:
MATTI, DIGOS CITY, DAVAO DEL SUR

PREPARED BY:
[Signature]
REXIE GREY V. TABAY
ARCHITECT III

REVIEWED BY:
[Signature]
JOSEPH R. GONZALES
ENGINEER III
PLANNING AND PROGRAMMING DIV. HEAD


RECOMMENDING APPROVAL:
[Signature]
LEONERL MARCH P. SUARIO
PROVINCIAL ENGINEER

APPROVED BY:
[Signature]
YVONNE ROÑA CAGAS
PROVINCIAL GOVERNOR

SHEET NO.:
A-2
2 79

TOILET SCOPE OF WORKS:

- REMOVE & REPLACE FLOOR & WALL TILES
- INSTALL WALL TILES, UP TO CEILING
- REMOVE & REPLACE ALL TOILET FIXTURES
- REPAINT ALL CONCRETE & STEEL SURFACES
- INSTALL CEILING
- INSTALL LIGHTING FIXTURES
- INSTALL WATERLESS URINAL

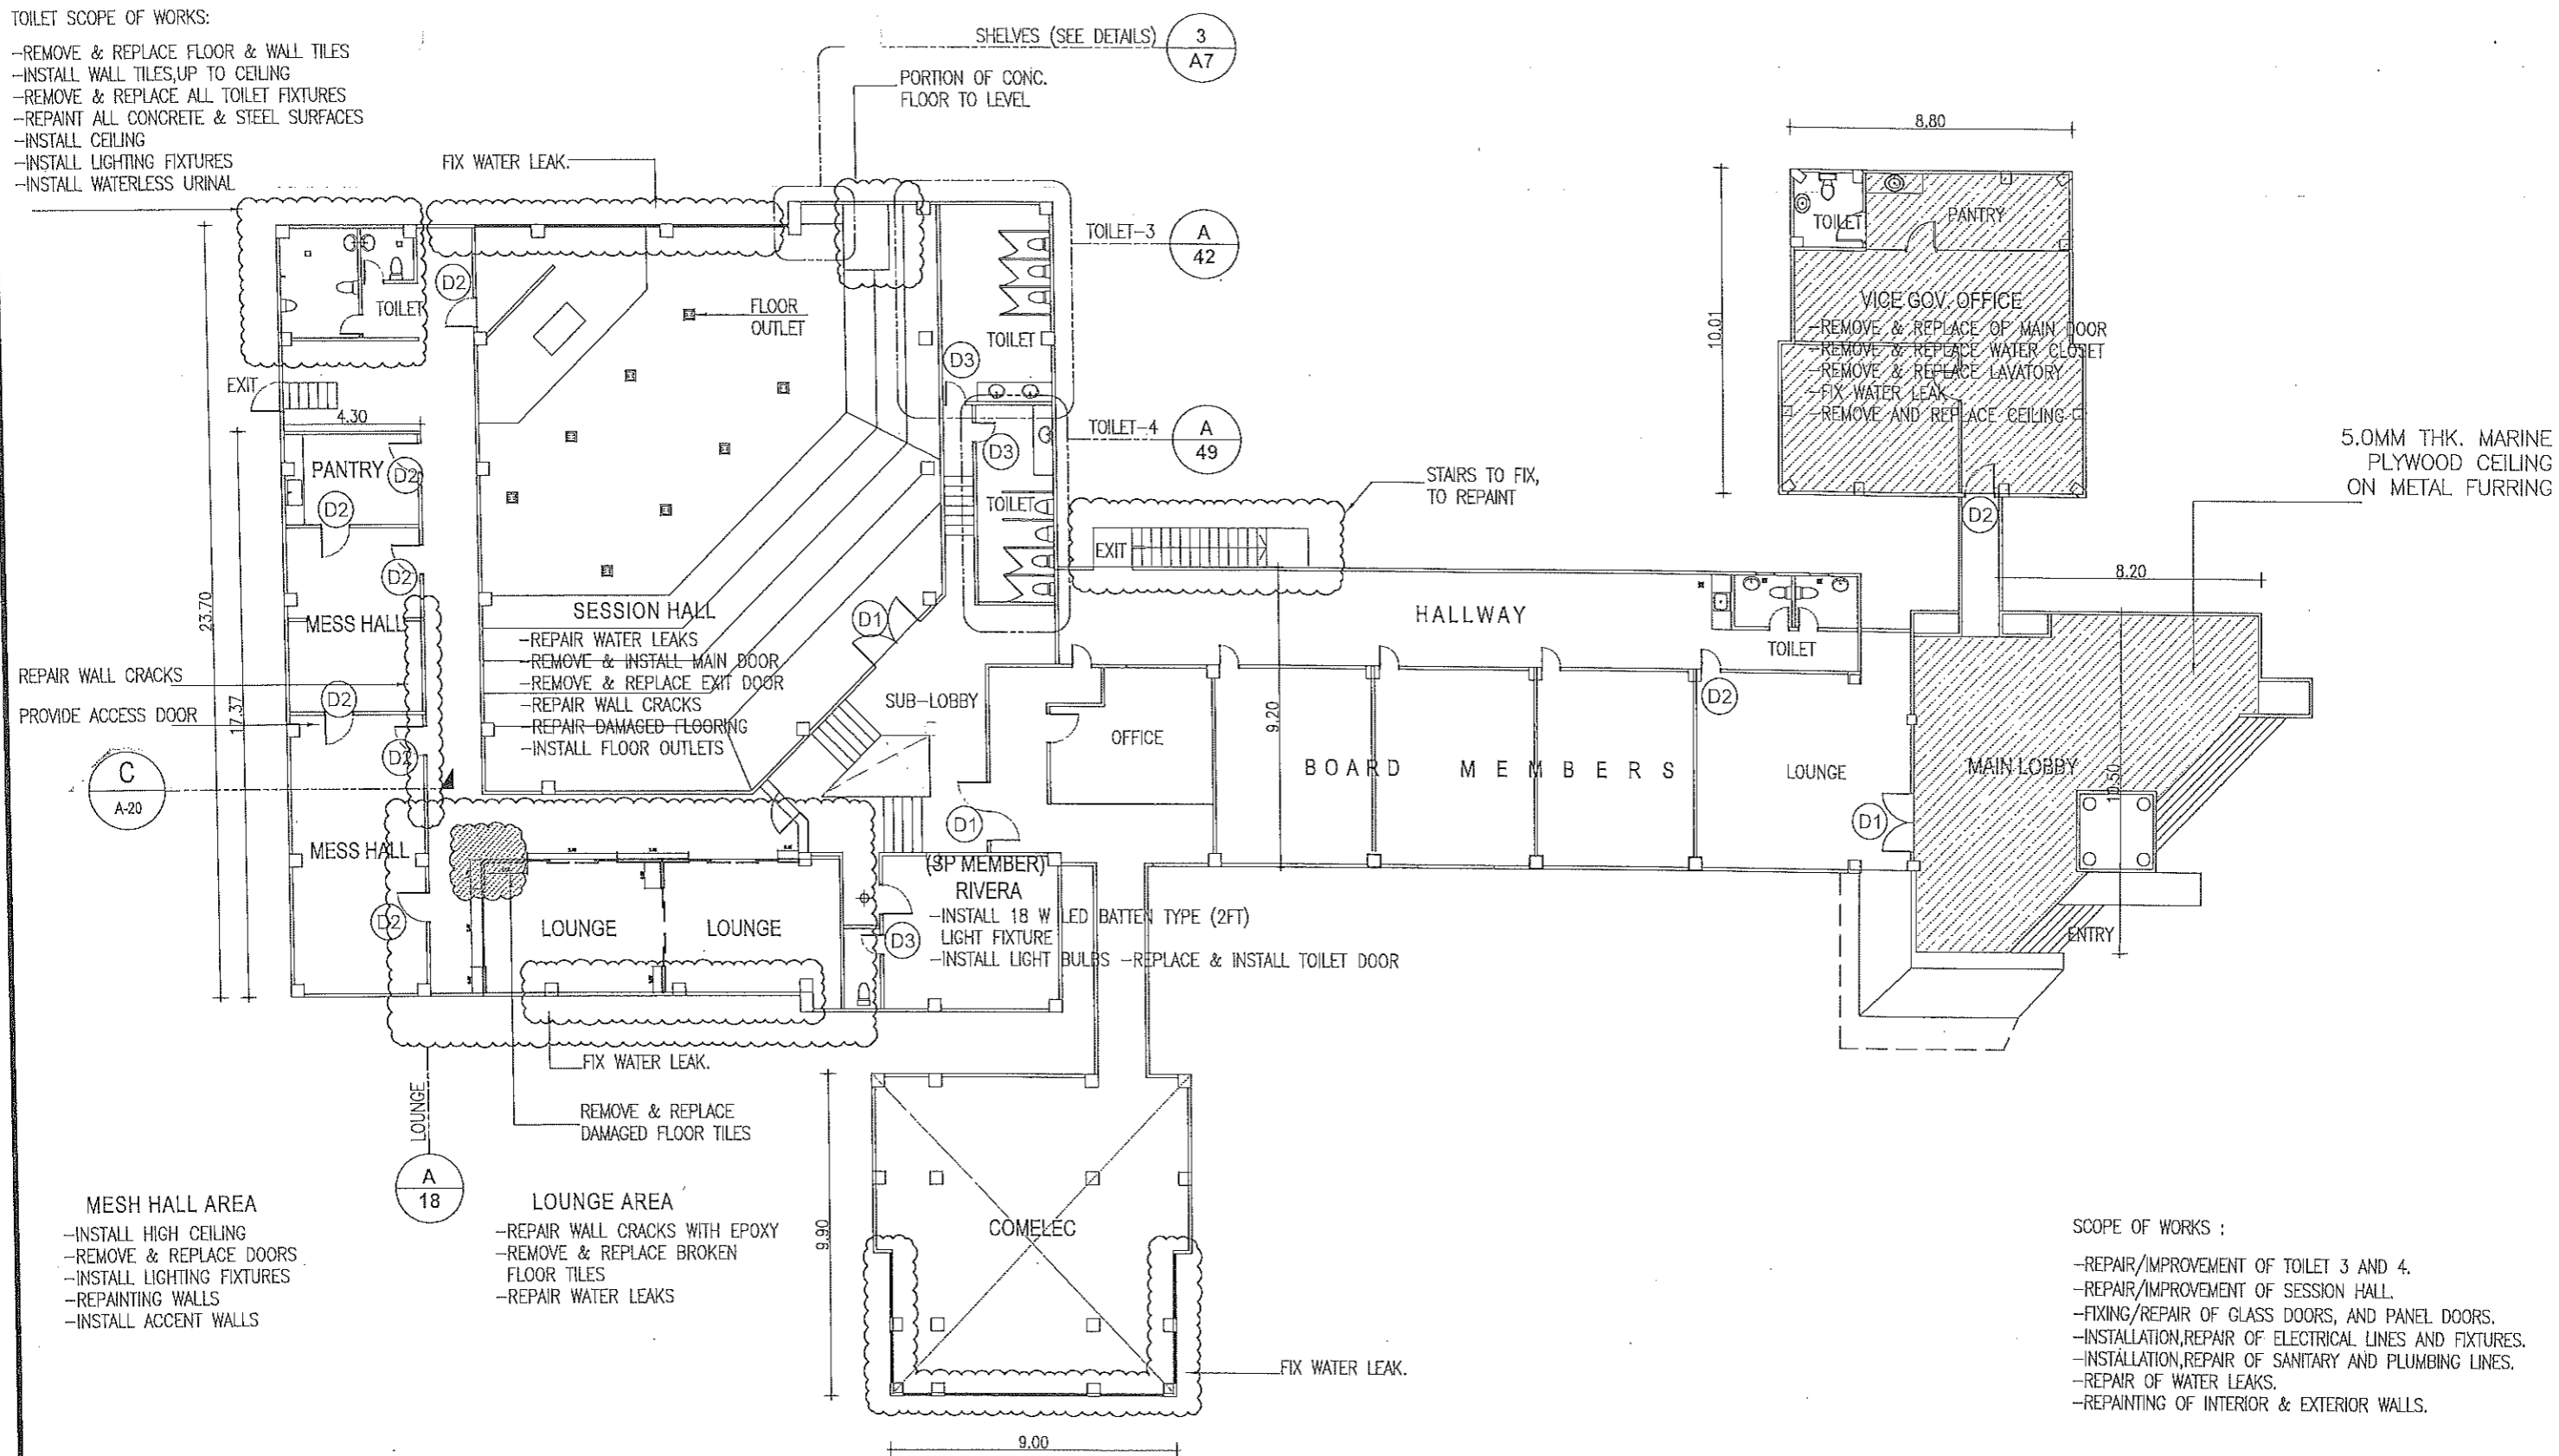

1 2ND FLOOR LEVEL
A-3 SCALE 1:150



REPUBLIC OF THE PHILIPPINES
PROVINCIAL ENGINEER'S OFFICE
SAN AGUSTIN, DIGOS CITY, DAVAO DEL SUR

PROJECT TITLE:
REPAIR /IMPROVEMENT OF SANGGUNIANG
PANLALAWIGAN BUILDING

LOCATION:
MATTI, DIGOS CITY, DAVAO DEL SUR


PREPARED BY:
REXIE GREY B. TABAY
ARCHITECT III

REVIEWED BY:
JOSEPH R. GONZALES
ENGINEER - III
PLANNING AND PROGRAMMING DIV. HEAD


RECOMMENDING APPROVAL:
LEONERL MARCH P. SUARIO
PROVINCIAL ENGINEER




APPROVED BY:
YVONNE ROMA CAGAS
PROVINCIAL GOVERNOR

SHEET NO.:
A-3
3 79

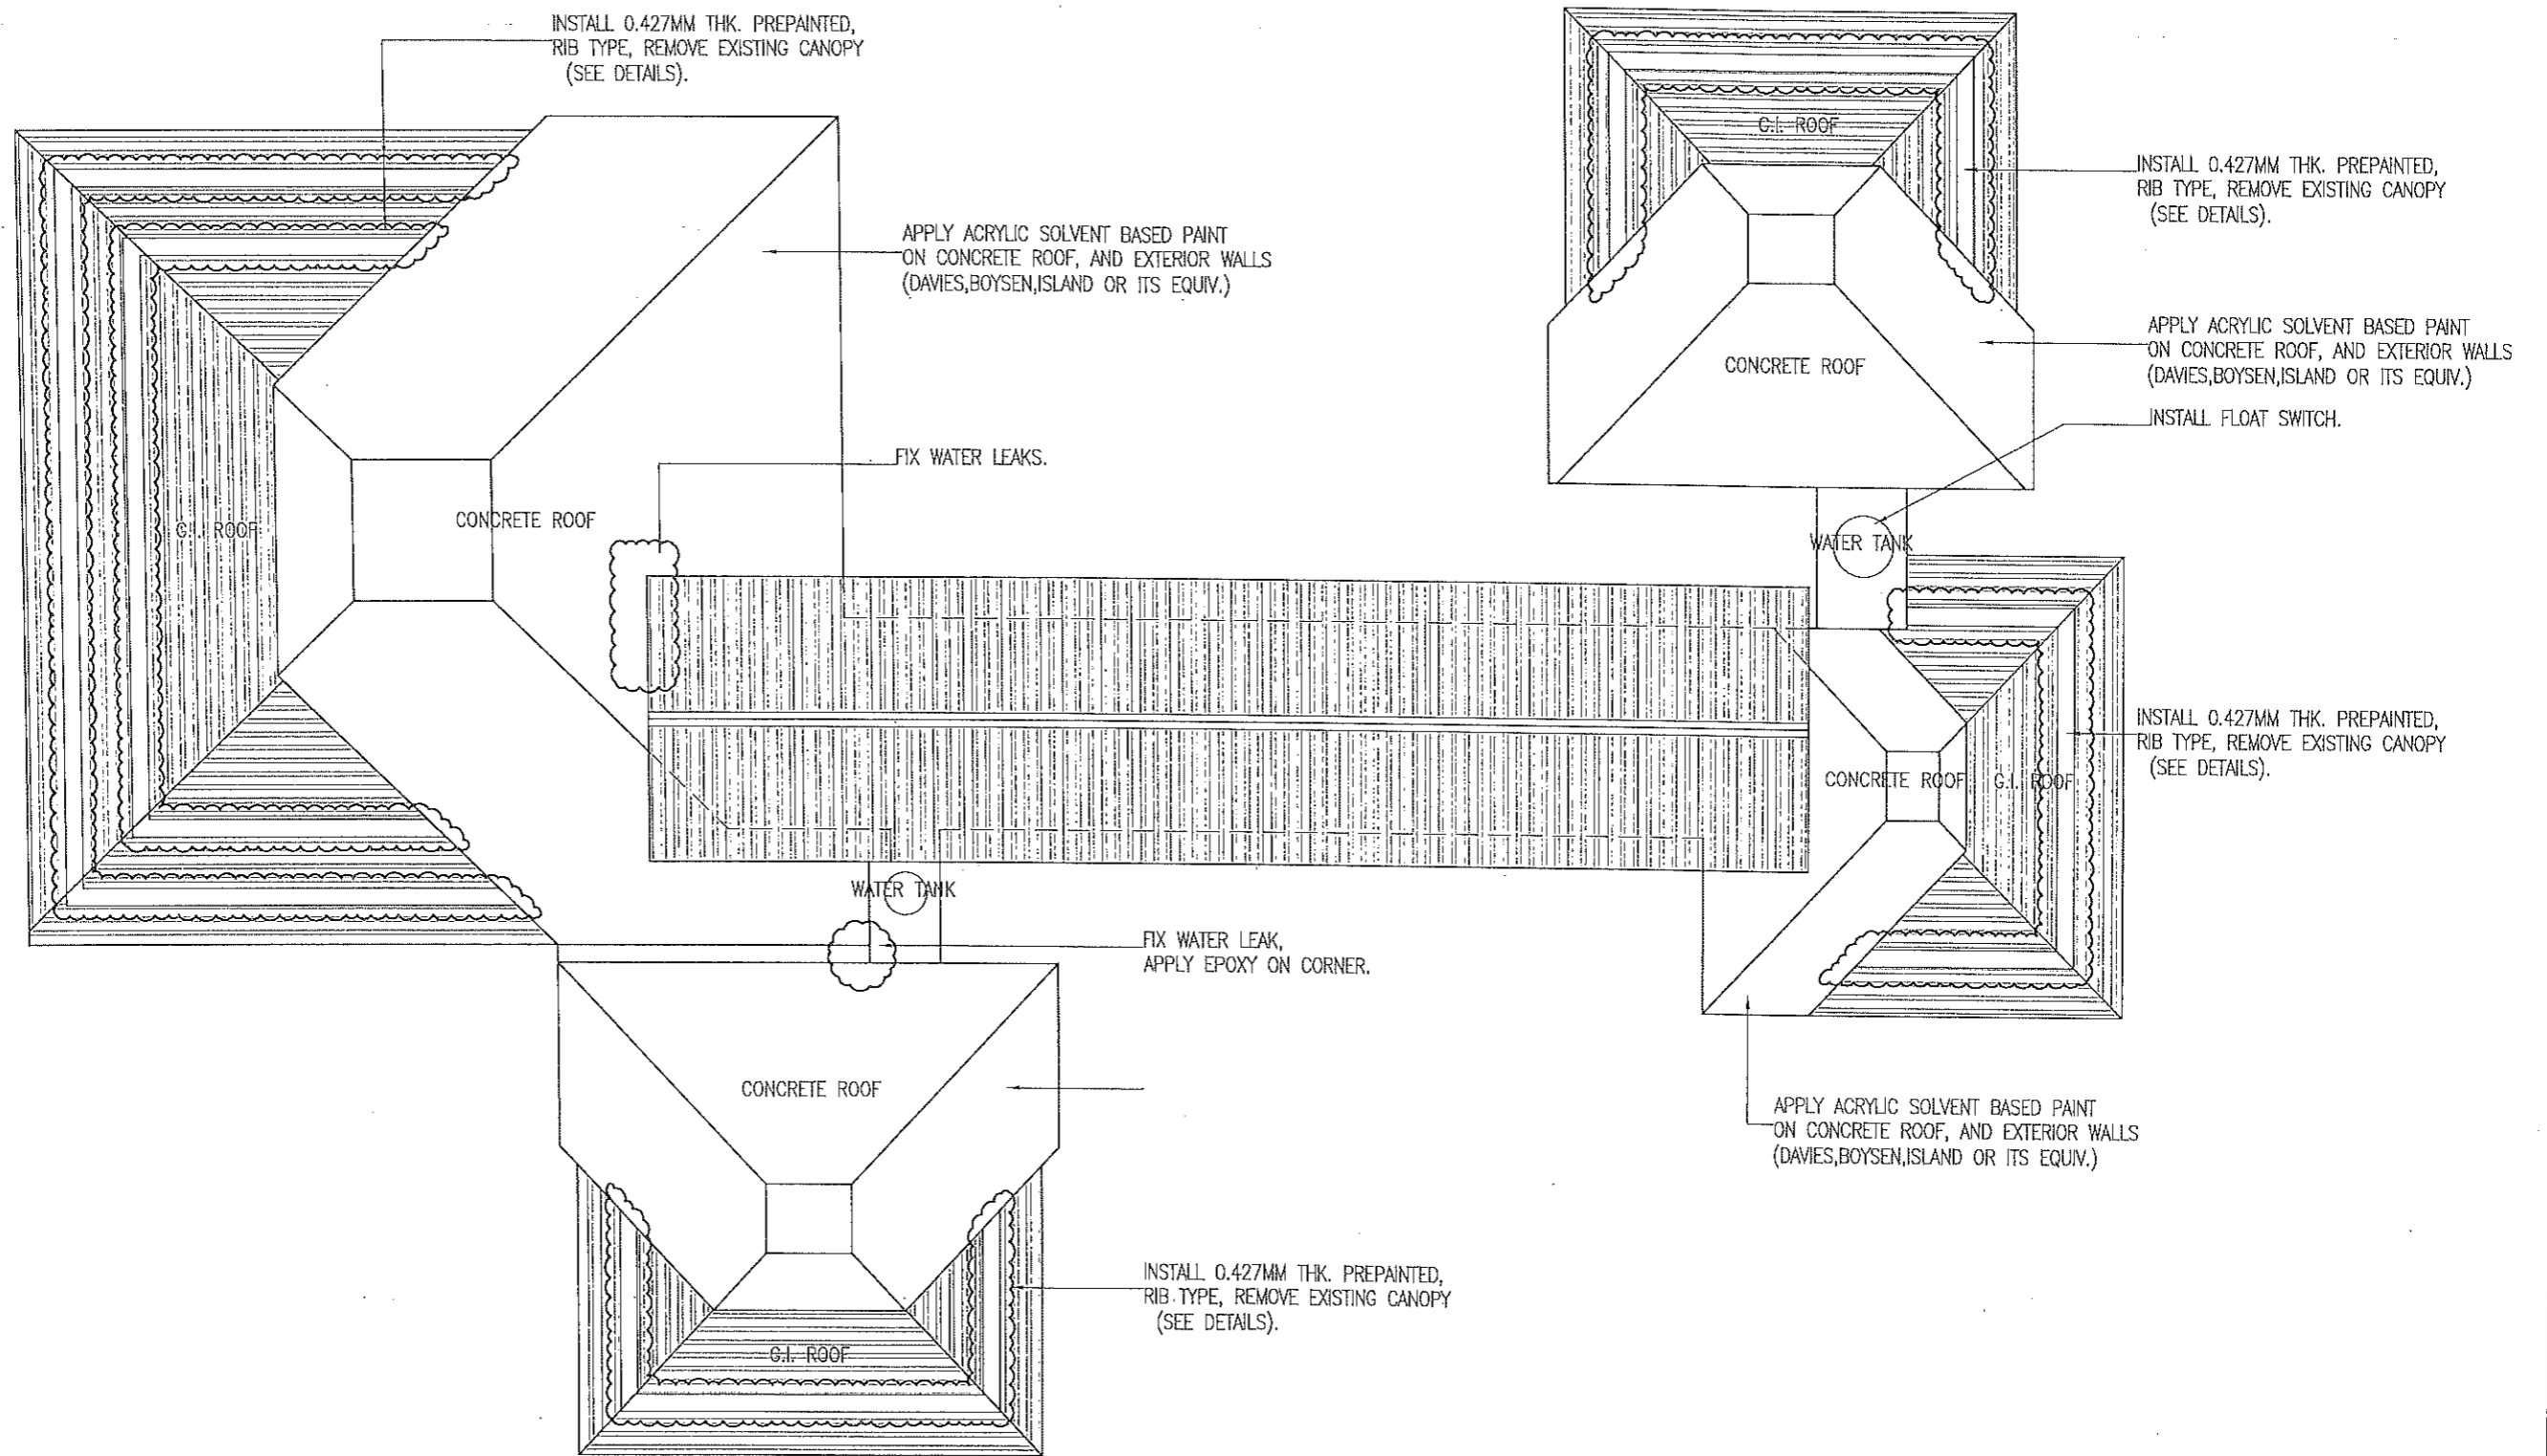

1
ROOF PLAN
 A-5 SCALE 1:150

 <p>REPUBLIC OF THE PHILIPPINES PROVINCIAL ENGINEER'S OFFICE SAN AGUSTIN, DIGOS CITY, DAVAO DEL SUR</p>	PROJECT TITLE:	PREPARED BY:	REVIEWED BY:	RECOMMENDING APPROVAL:	APPROVED BY:	SHEET NO.:
	REPAIR /IMPROVEMENT OF SANGGUNIANG PANLALAWIGAN BUILDING LOCATION: MATTI, DIGOS CITY, DAVAO DEL SUR	REXIE GREY B. TABA ARCHITECT III	JOSEPH R. GONZALES ENGINEER - III PLANNING AND PROGRAMMING DIV. HEAD	LEONERL. MARCH P. SUARIO PROVINCIAL ENGINEER	YVONNE ROMA CAGAS PROVINCIAL GOVERNOR	A-5 5 79

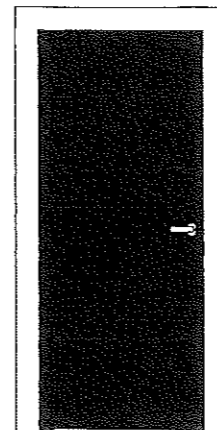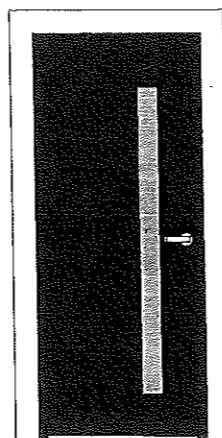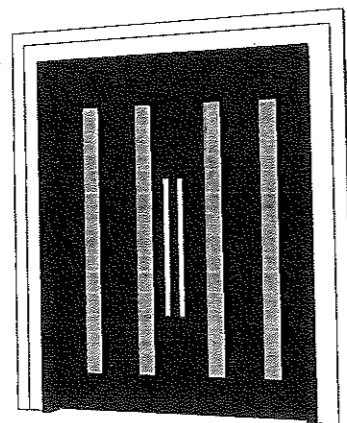

FIN. FLR. LINE LEVEL					
MARK	(D1)	(D2)	(D3)		
TYPE & SPECIFICATION	-2"x6" SOLID WOOD FRAME, MAHOGANY OR ITS EQUIV. -W/ 5MM THK. VIEWING CLEAR GLASS -2"x6" DOOR JAMB, MAHOGANY OR ITS EQUIV.	-2"x6" SOLID WOOD FRAME, MAHOGANY OR ITS EQUIV. -W/ 5MM THK. VIEWING CLEAR GLASS -2"x6" DOOR JAMB, MAHOGANY OR ITS EQUIV.	-2"x6" SOLID WOOD FRAME, MAHOGANY OR ITS EQUIV. -FIXED GLASS (USE THE EXISTING GLASS DOOR) -2"x6" DOOR JAMB, MAHOGANY OR ITS EQUIV.		
HARDWARES	-DOUBLE DOOR LOCKSET -BARREL BOLT, 6-SETS -3 SETS OF LOOSE PIN BUTT HINGES. -PULL BAR DOOR HANDLE, S.S.	-DOOR LOCK LEVER TYPE -4 SETS OF LOOSE PIN BUTT HINGES. -BARREL BOLT, 3-SETS	-DOOR LOCK LEVER TYPE -4 SETS OF LOOSE PIN BUTT HINGES. -BARREL BOLT, 3-SETS		
LOCATION	SESSION HALL, HALLWAY, SUB-LOBBY	OFFICES	TOILETS, OFFICES		
QUANTITY	4 SETS	12 SETS	10 SETS		

1 SCHEDULE OF DOORS
A-6 SCALE 1:150



REPUBLIC OF THE PHILIPPINES
PROVINCIAL ENGINEER'S OFFICE
SAN AGUSTIN, DIGOS CITY, DAVAO DEL SUR

PROJECT TITLE:
**REPAIR /IMPROVEMENT OF SANGGUNIANG
PANLALAWIGAN BUILDING**

LOCATION:
MATTI, DIGOS CITY, DAVAO DEL SUR


PREPARED BY:
[Signature]
REXIE GREY B. TAYAY
ARCHITECT III

REVIEWED BY:
[Signature]
JOSEPH R. GONZALES
ENGINEER - III
PLANNING AND PROGRAMMING DIV. HEAD


RECOMMENDING APPROVAL:
[Signature]
LEONERL MARCH P. SJARIO
PROVINCIAL ENGINEER

APPROVED BY:
[Signature]
YVONNE ROÑA CAGAS
PROVINCIAL GOVERNOR

SHEET NO.:
A-6
6 79

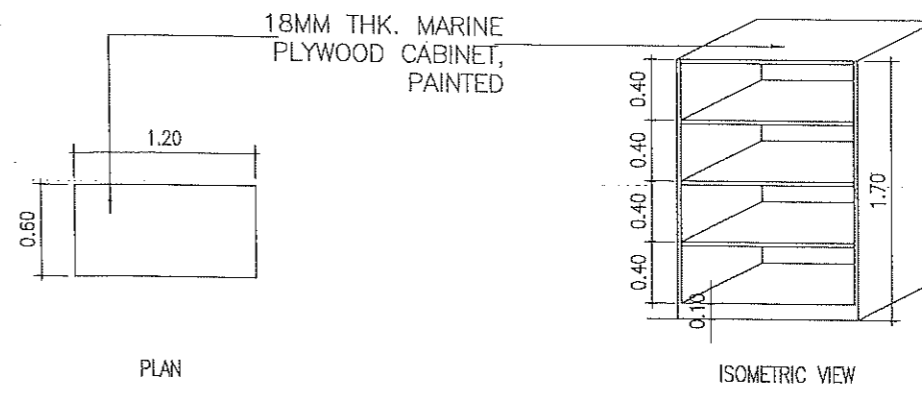

3 **SHELVES DETAIL**
 A-7 **SCALE** **1:50**

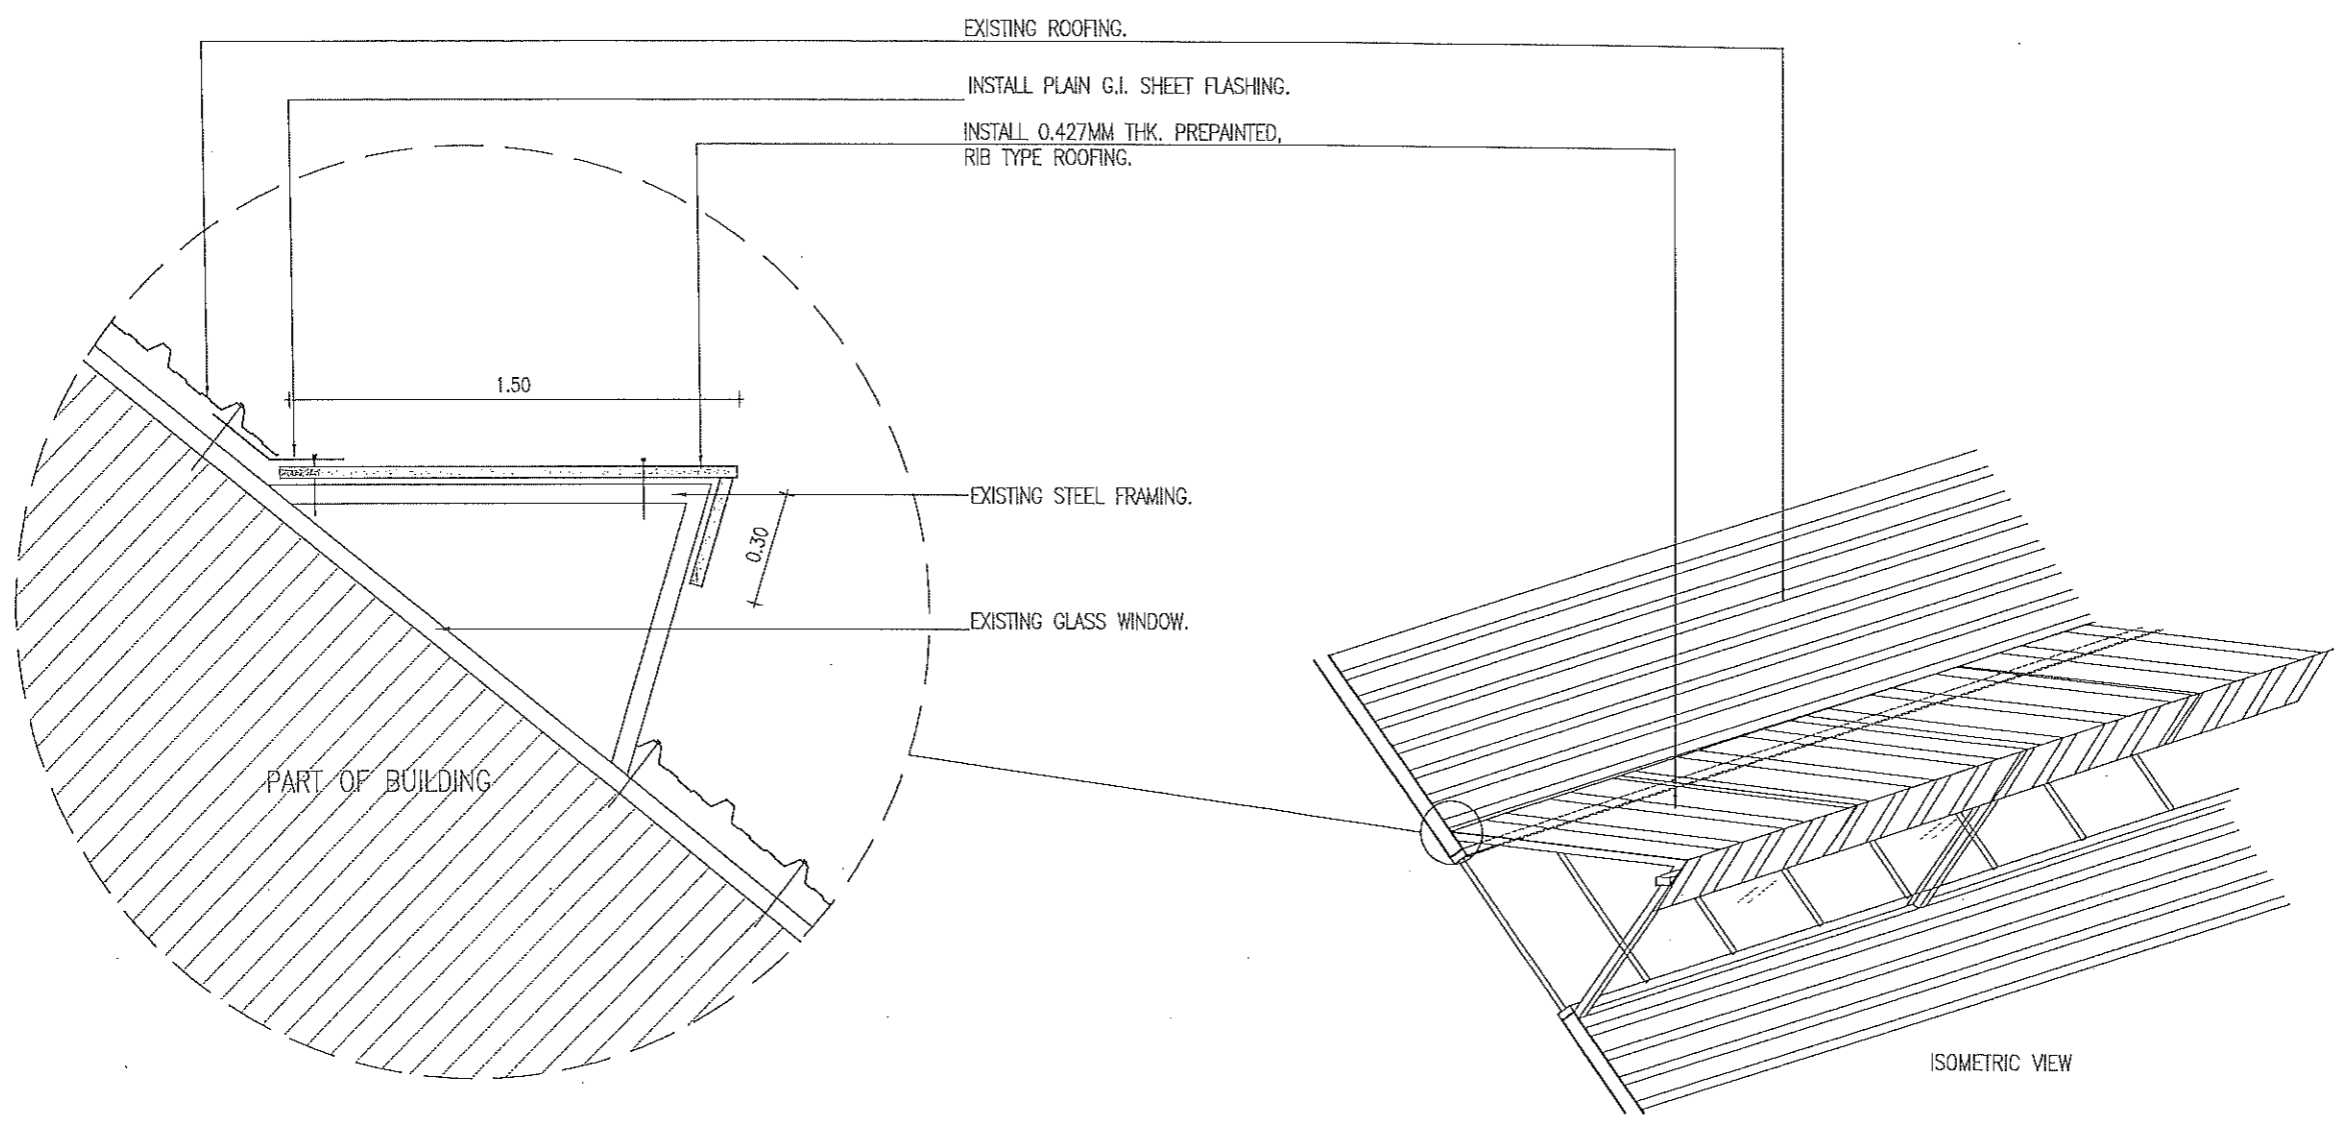

1 **BLOW UP DETAIL**
 A-7 **SCALE** **1:20**

2 **CANOPY ROOFING DET.**
 A-7 **SCALE** **1:50**



REPUBLIC OF THE PHILIPPINES
PROVINCIAL ENGINEER'S OFFICE
 SAN AGUSTIN, DIGOS CITY, DAVAO DEL SUR


PROJECT TITLE: REPAIR /IMPROVEMENT OF SANGGUNIANG PANLALAWIGAN BUILDING	PREPARED BY: <i>Rexie Grey B. Tabay</i> REXIE GREY B. TABAY ARCHITECT III	REVIEWED BY: <i>Joseph R. Gonzales</i> JOSEPH R. GONZALES ENGINEER - III PLANNING AND PROGRAMMING DIV. HEAD	RECOMMENDING APPROVAL: <i>Leonerl March P. Suario</i> LEONERL MARCH P. SUARIO PROVINCIAL ENGINEER	APPROVED BY: <i>Yvonne Roña Cagas</i> YVONNE ROÑA CAGAS PROVINCIAL GOVERNOR	SHEET NO.: A-7 7 79
LOCATION: MATTI, DIGOS CITY, DAVAO DEL SUR					

100MM THK. CONCRETE SLAB
WITH 10MMØ RSB
SP @ 0.50M O.C., B.W.


100MM THK CHB (350PSI)
10MMØ DEFORMED BAR, VERT.
SPACE @ 600MM O.C.

CONCRETE FOOTING W/ 10MMØ LONG. BARS


100MM THK. GRAVEL BASE

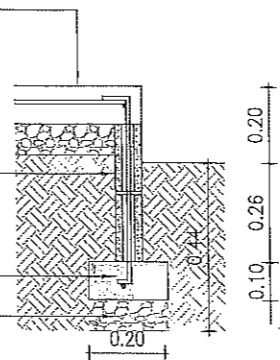

2 WALL FOOTING (WF-01) DET.
A-8 SCALE 1:20

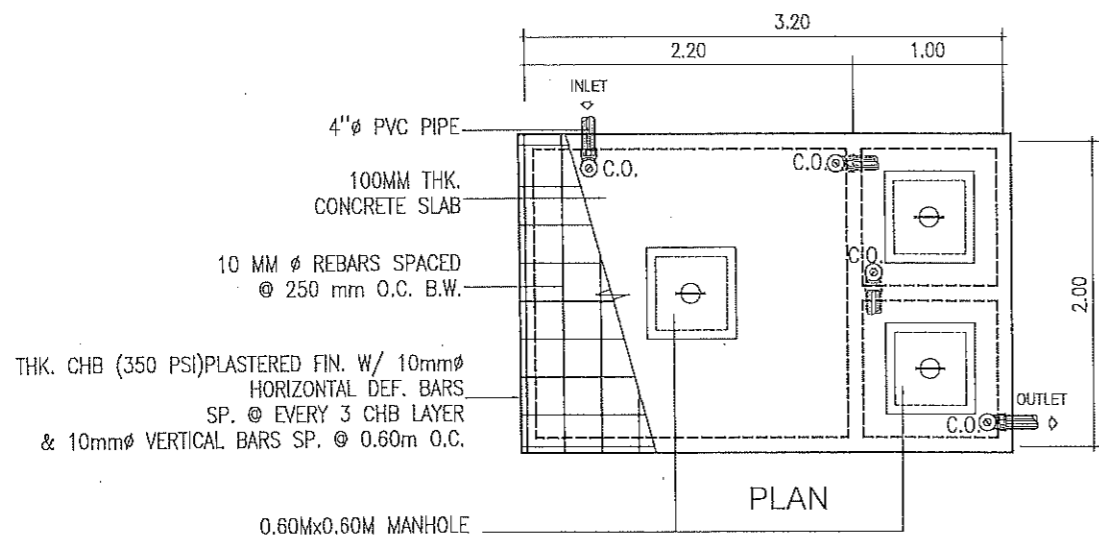

1 SEPTIC TANK DETAIL
A-8 SCALE 1:50

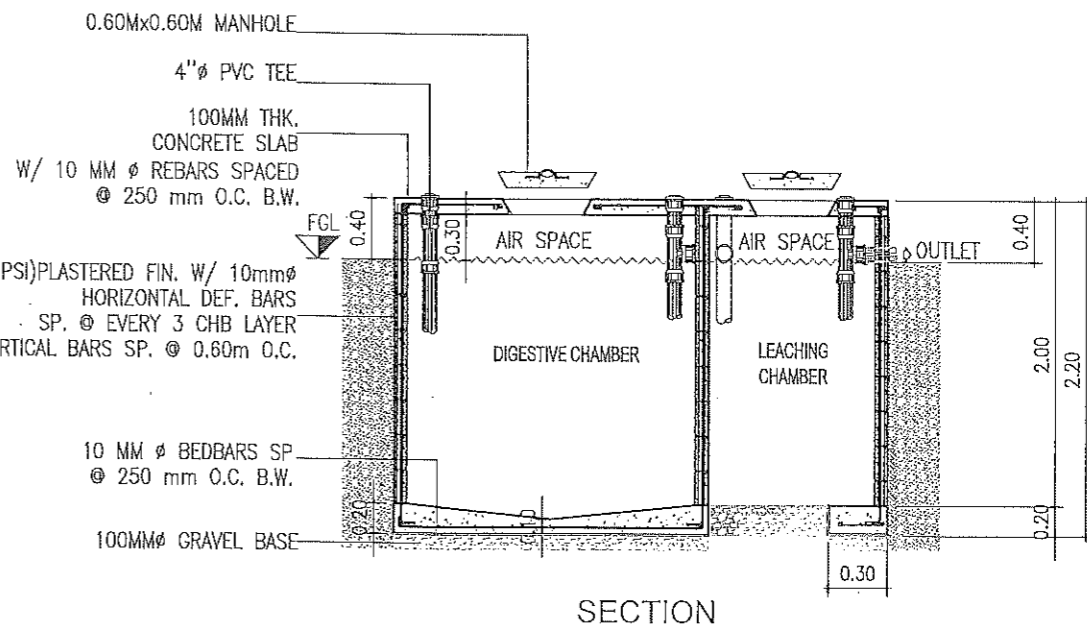

REPUBLIC OF THE PHILIPPINES
PROVINCIAL ENGINEER'S OFFICE
SAN AGUSTIN, DIGOS CITY, DAVAO DEL SUR

PROJECT TITLE:
REPAIR /IMPROVEMENT OF SANGGUNIANG
PANLALAWIGAN BUILDING
LOCATION:
MATTI, DIGOS CITY, DAVAO DEL SUR

PREPARED BY:
REXIE GREY B. TABAY
ARCHITECT III


REVIEWED BY:
JOSEPH R. GONZALES
ENGINEER -
PLANNING AND PROGRAMMING DIV. HEAD

RECOMMENDING APPROVAL:
LEONERL MARCH P. SUARIO
PROVINCIAL ENGINEER

APPROVED BY:
YVONNE ROÑA CAGAS
PROVINCIAL GOVERNOR

SHEET NO.:
A-8
8 79



SESSION HALL
(@ 2ND FLOOR)

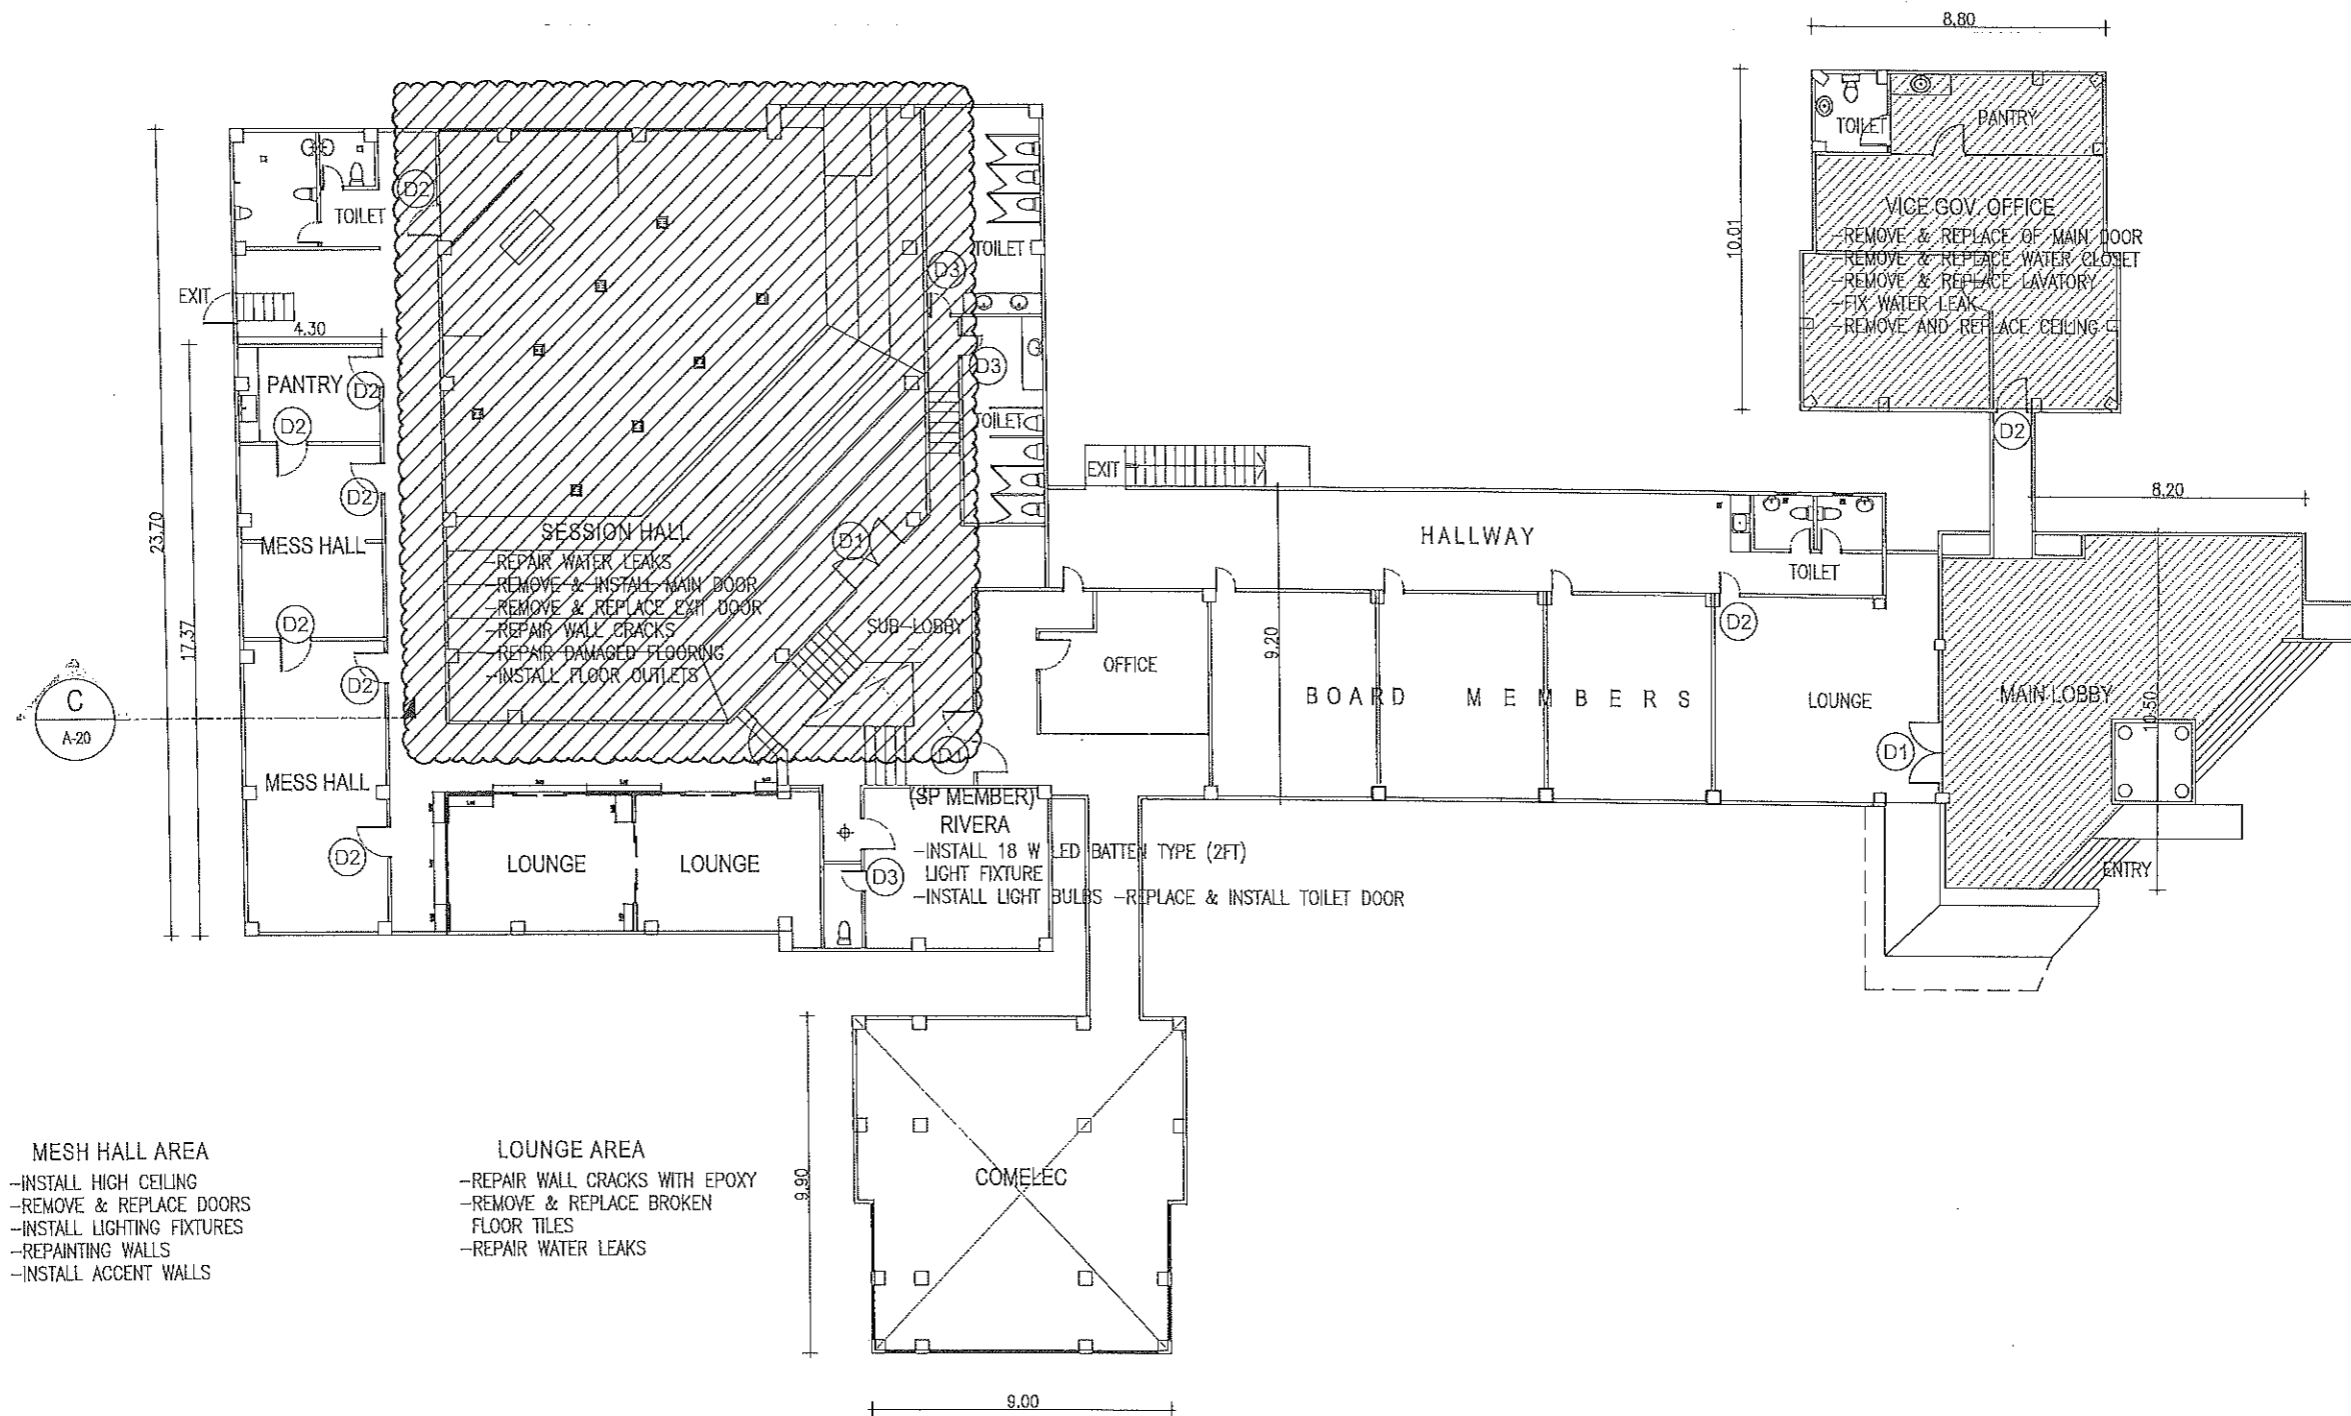


SESSION HALL DETAIL (@ 2ND FLOOR)

1
A-9

 <p>REPUBLIC OF THE PHILIPPINES PROVINCIAL ENGINEER'S OFFICE SAN AGUSTIN, DIGOS CITY, DAVAO DEL SUR</p>	<p>PROJECT TITLE: REPAIR /IMPROVEMENT OF SANGGUNIANG PANLALAWIGAN BUILDING</p>	<p>PREPARED BY: <i>[Signature]</i> REXIE GREY B. TABAY ARCHITECT III</p>	<p>REVIEWED BY: <i>[Signature]</i> JOSEPH R. GONZALES ENGINEER - III PLANNING AND PROGRAMMING DIV. HEAD</p>	<p>RECOMMENDING APPROVAL: <i>[Signature]</i> LEONERL MARCH P. SUARIO PROVINCIAL ENGINEER</p>	<p>APPROVED BY: <i>[Signature]</i> YVONNE RONA CAGAS PROVINCIAL GOVERNOR</p>	<p>SHEET NO.: A-9 9 79</p>
	<p>LOCATION: MATTI, DIGOS CITY, DAVAO DEL SUR</p>					

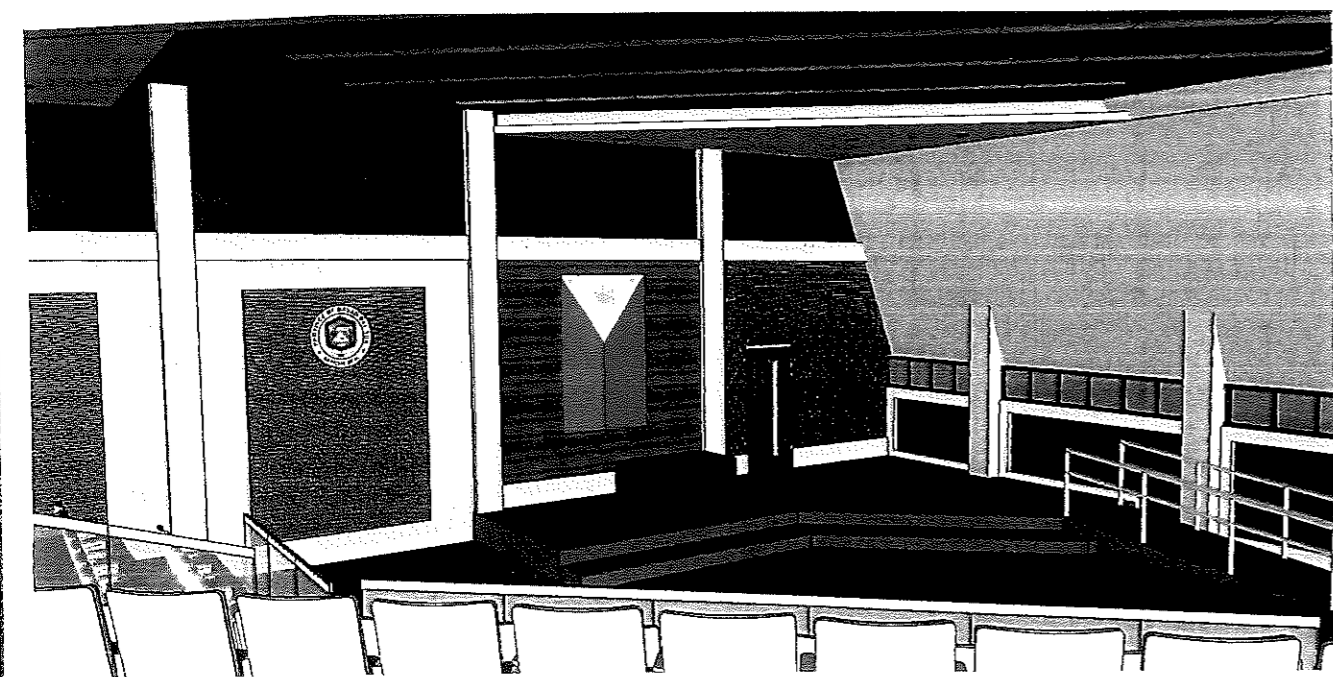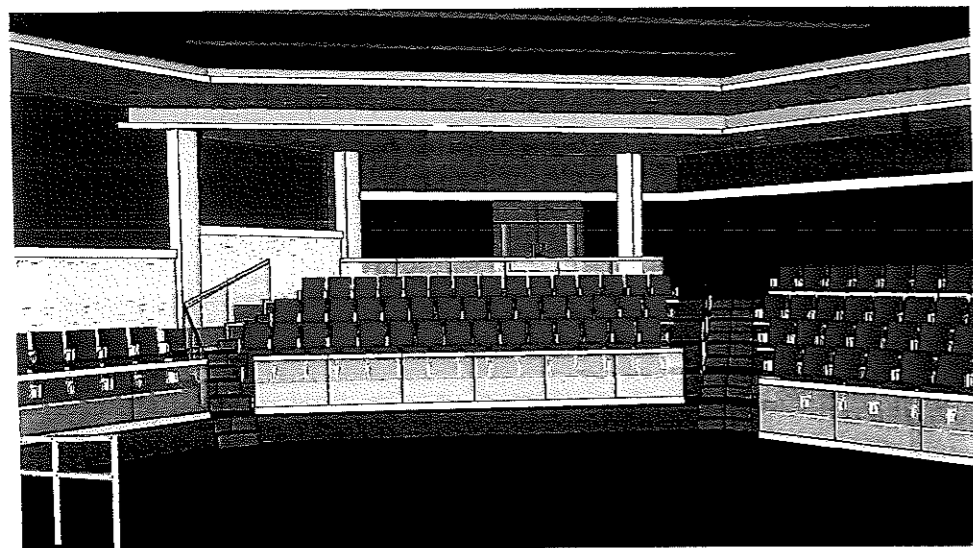

1 PERSPECTIVE
A-10

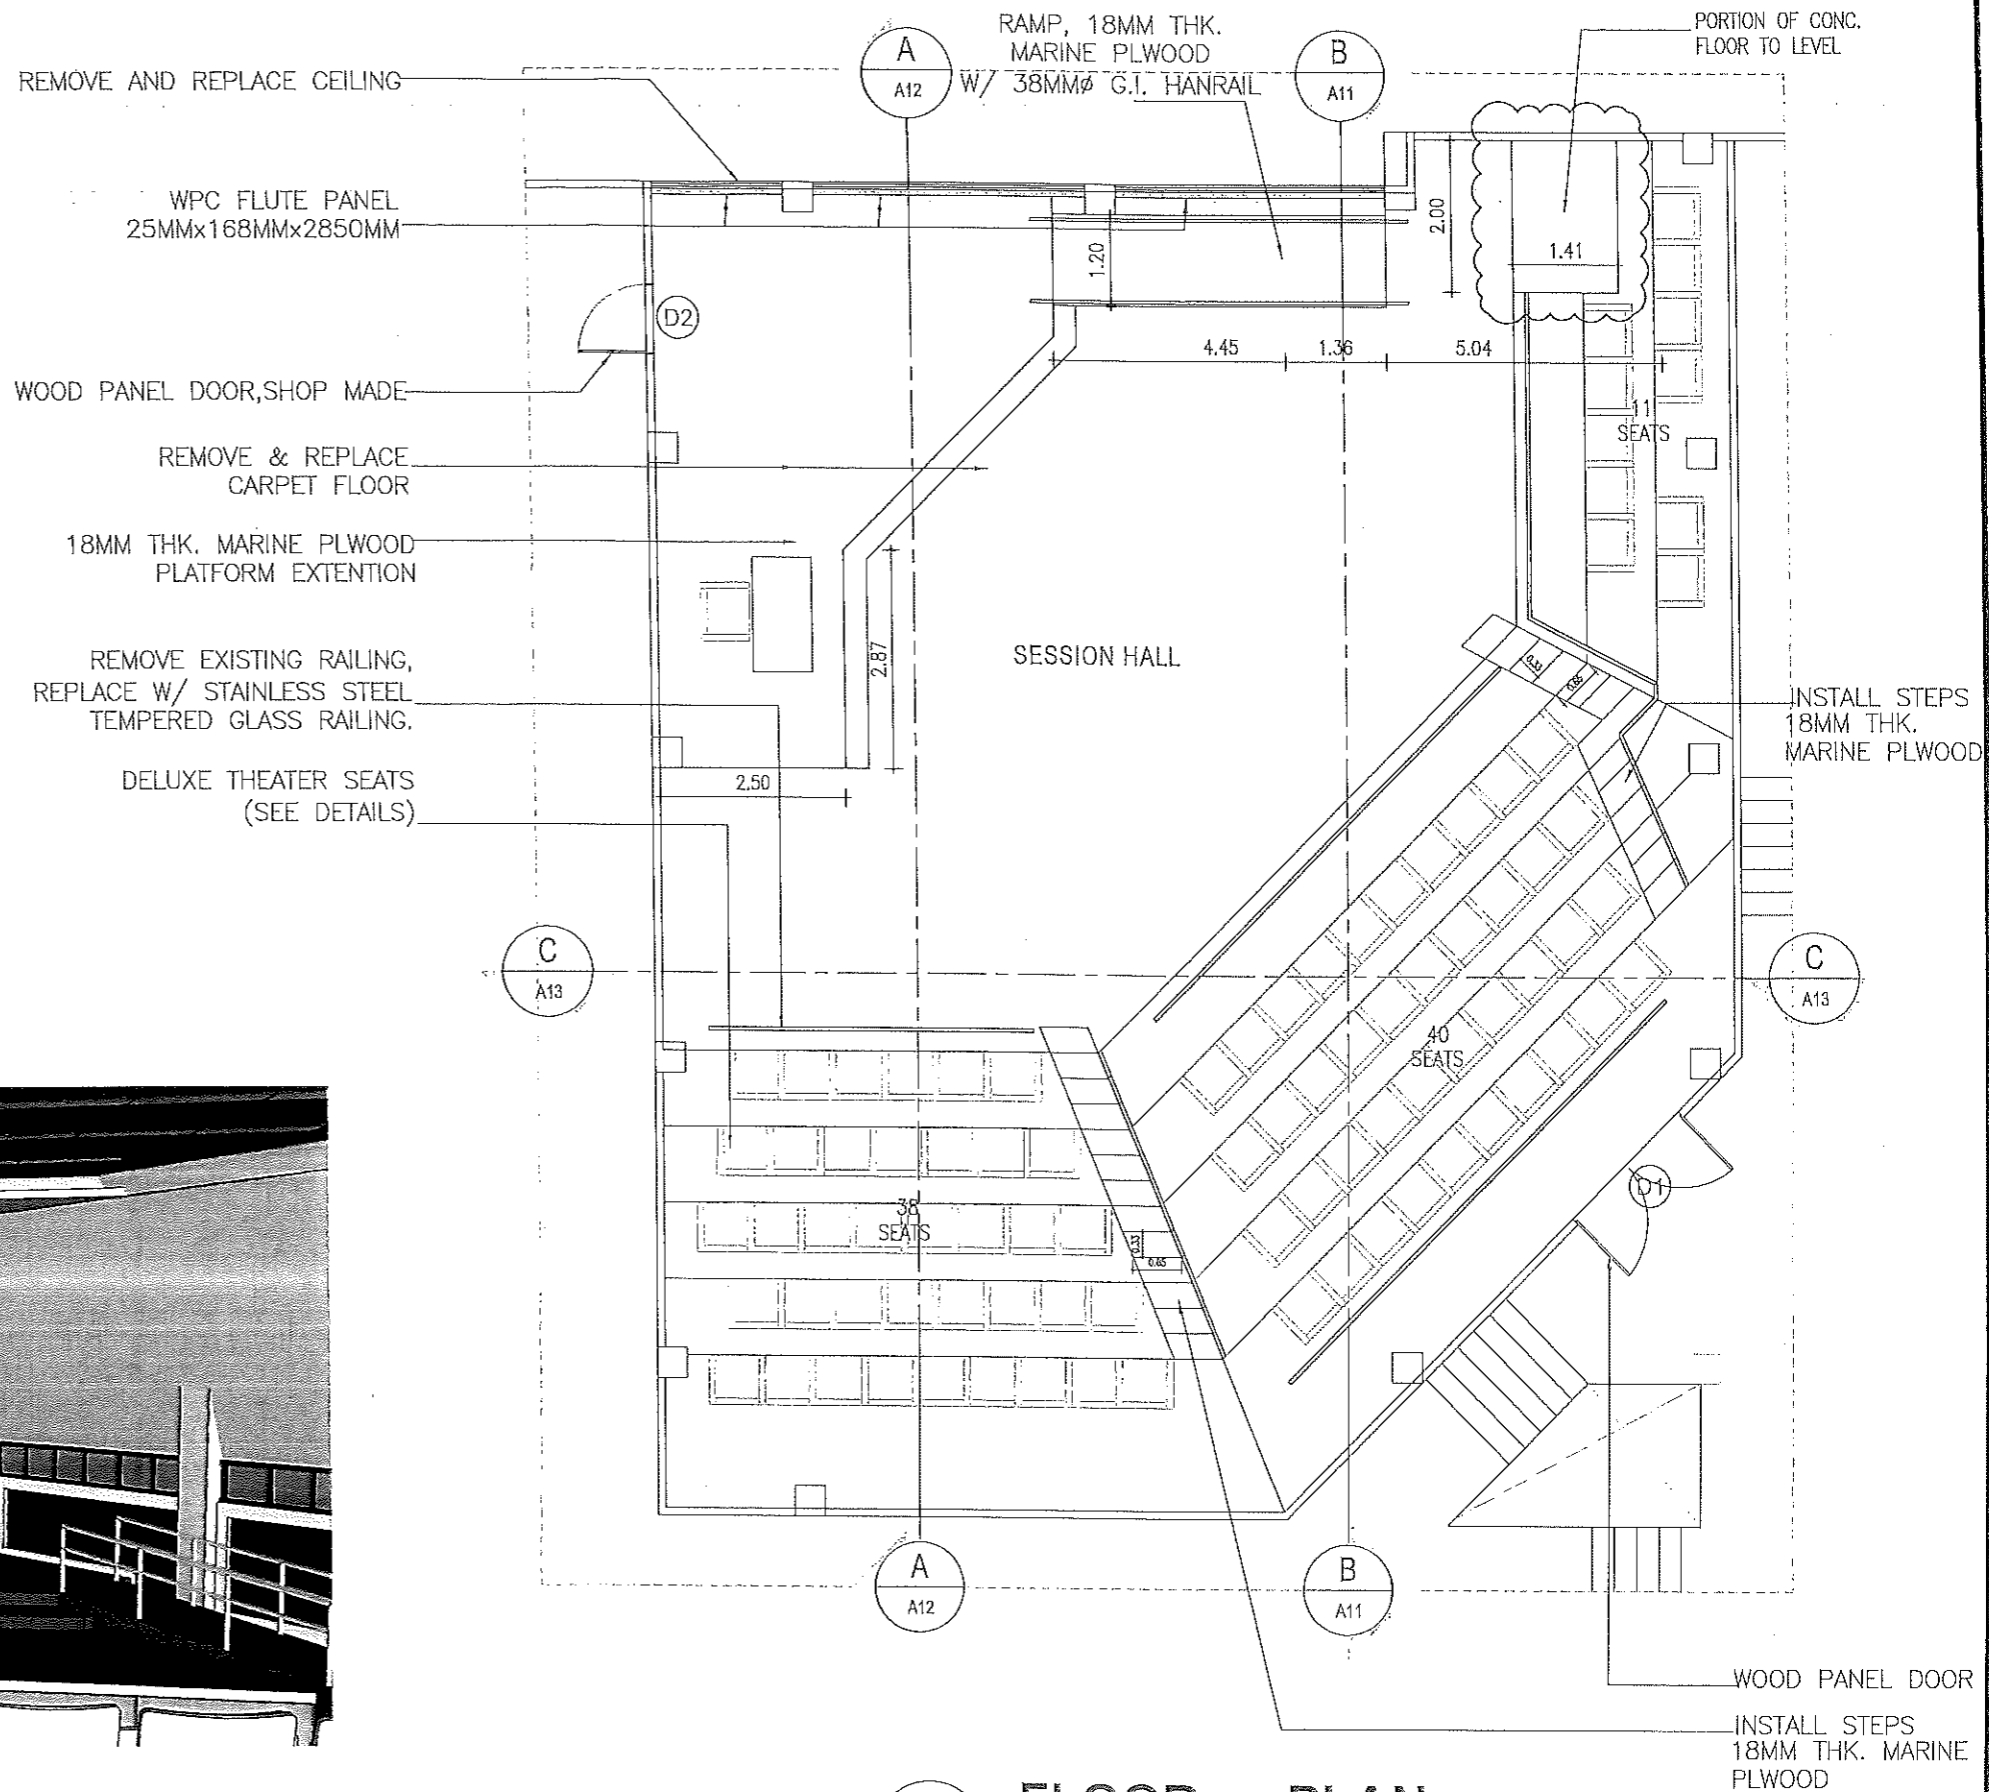

2 FLOOR PLAN
SCALE 1:100
A-10



REPUBLIC OF THE PHILIPPINES
PROVINCIAL ENGINEER'S OFFICE
SAN AGUSTIN, DIGOS CITY, DAVAO DEL SUR

PROJECT TITLE:
REPAIR /IMPROVEMENT OF SANGGUNIANG
PANLALAWIGAN BUILDING
LOCATION:
MATTI, DIGOS CITY, DAVAO DEL SUR


PREPARED BY:
REXIE GREY B. TABAY
ARCHITECT III

REVIEWED BY:
JOSEPH R. GONZALES
ENGINEER - III
PLANNING AND PROGRAMMING DIV. HEAD

RECOMMENDING APPROVAL:
LEONERL MARCH P. SUARIO
PROVINCIAL ENGINEER




APPROVED BY:
YVONNE ROÑA CAGAS
PROVINCIAL GOVERNOR


SHEET NO.:
A-10
10 79

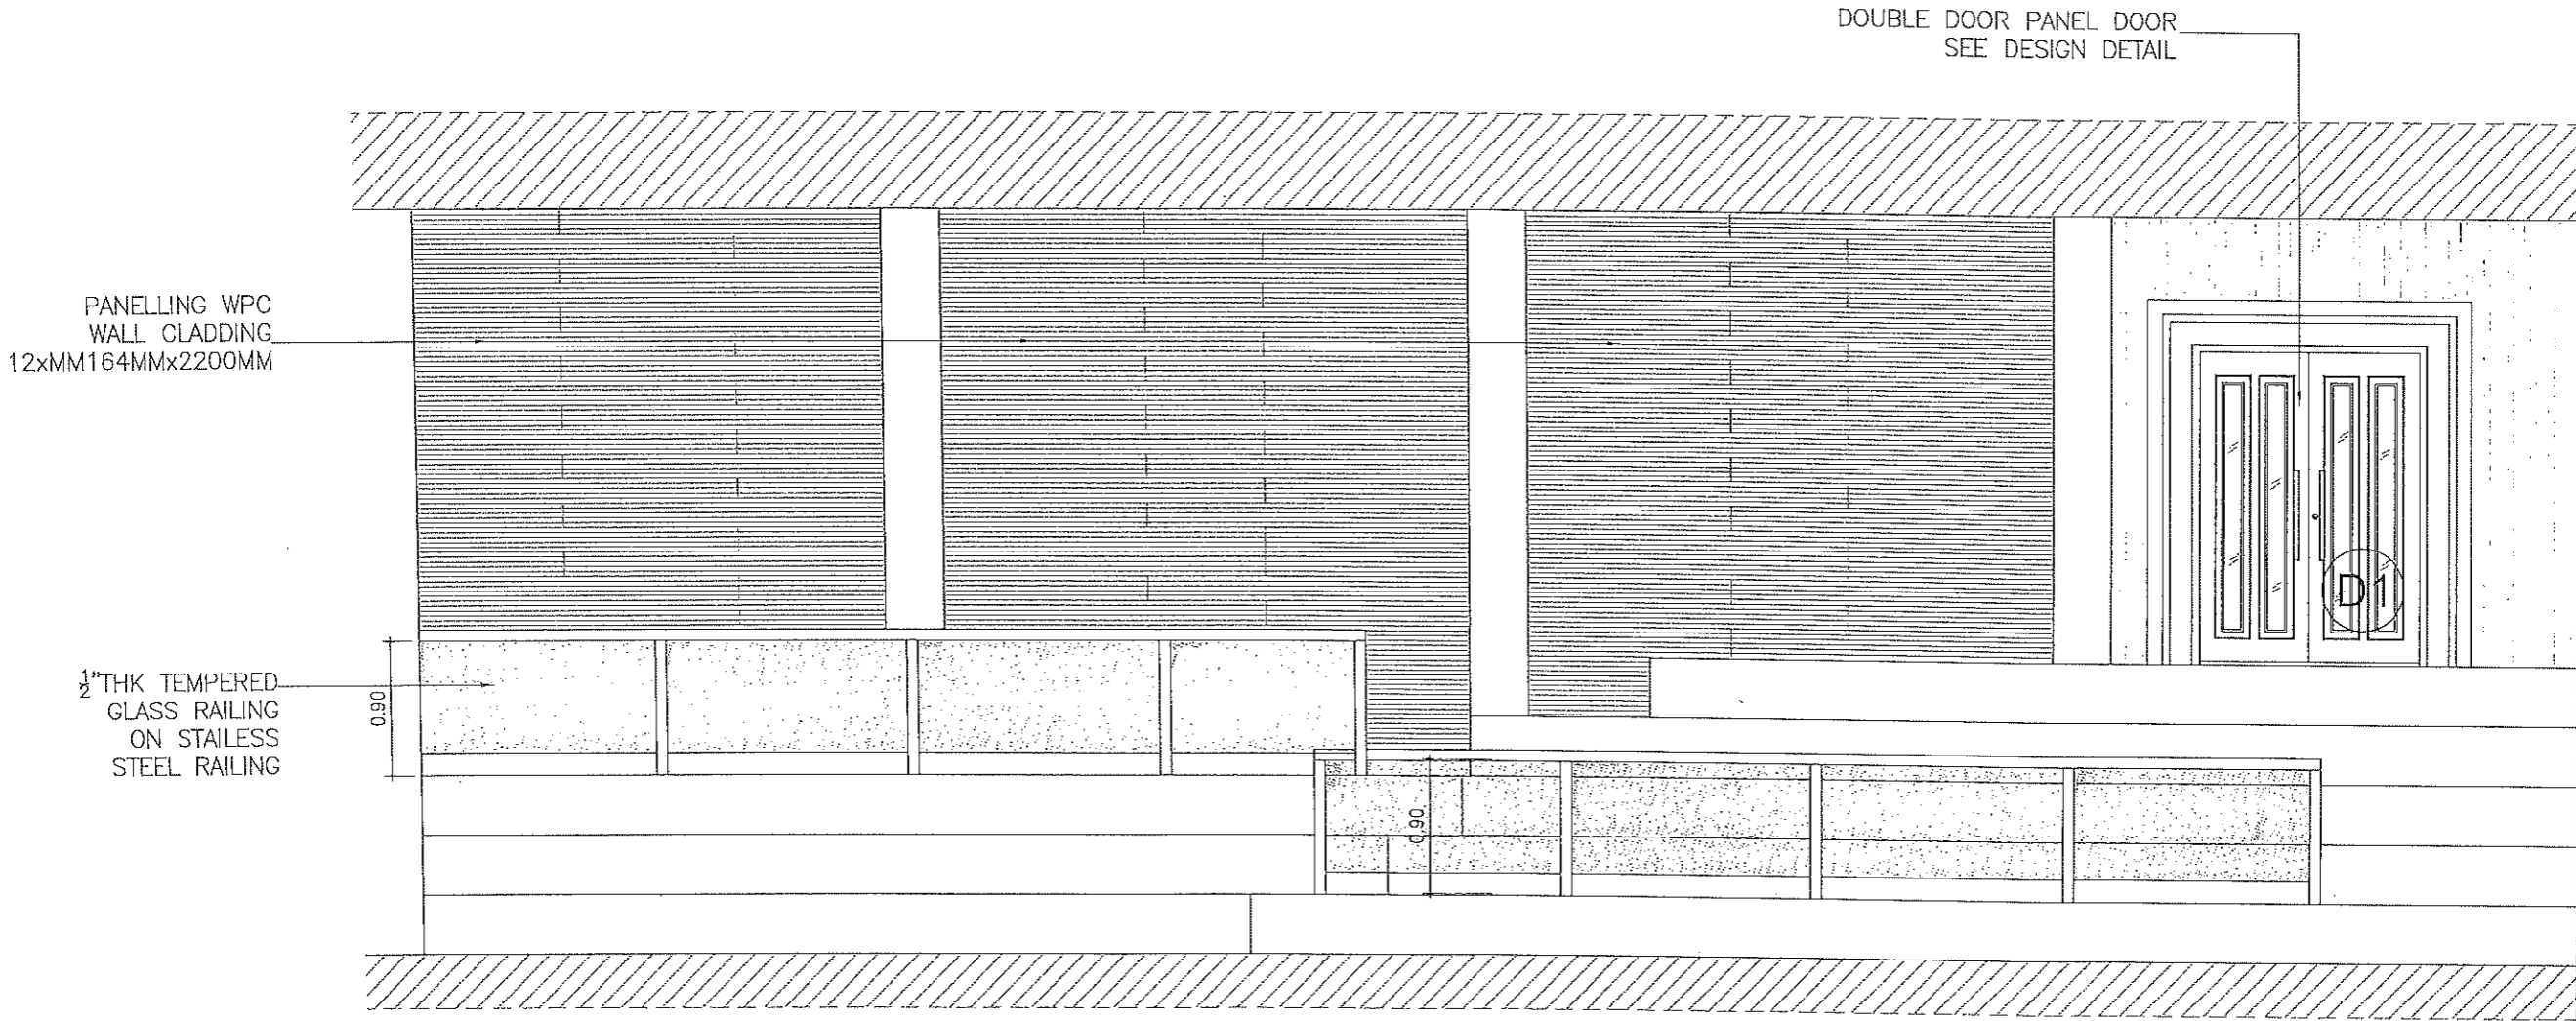

ELEVATION

  1 SECTION THRU B-B
 A-11 SCALE 1:50


 <p>REPUBLIC OF THE PHILIPPINES PROVINCIAL ENGINEER'S OFFICE SAN AGUSTIN, DIGOS CITY, DAVAO DEL SUR</p>	PROJECT TITLE: REPAIR /IMPROVEMENT OF SANGGUNIANG PANLALAWIGAN BUILDING	PREPARED BY:  REXIE GREY B. TABAY ARCHITECT III	REVIEWED BY:  JOSEPH R. GONZALES ENGINEER III PLANNING AND PROGRAMMING DIV. HEAD	RECOMMENDING APPROVAL:  LEONERL MARCH P. SUARIO PROVINCIAL ENGINEER	APPROVED BY:  YVONNE RONA CAGAS PROVINCIAL GOVERNOR	SHEET NO.: A-11
	LOCATION: MATTI, DIGOS CITY, DAVAO DEL SUR	ARCHITECT III	ENGINEER III PLANNING AND PROGRAMMING DIV. HEAD	PROVINCIAL ENGINEER	PROVINCIAL GOVERNOR	11 79

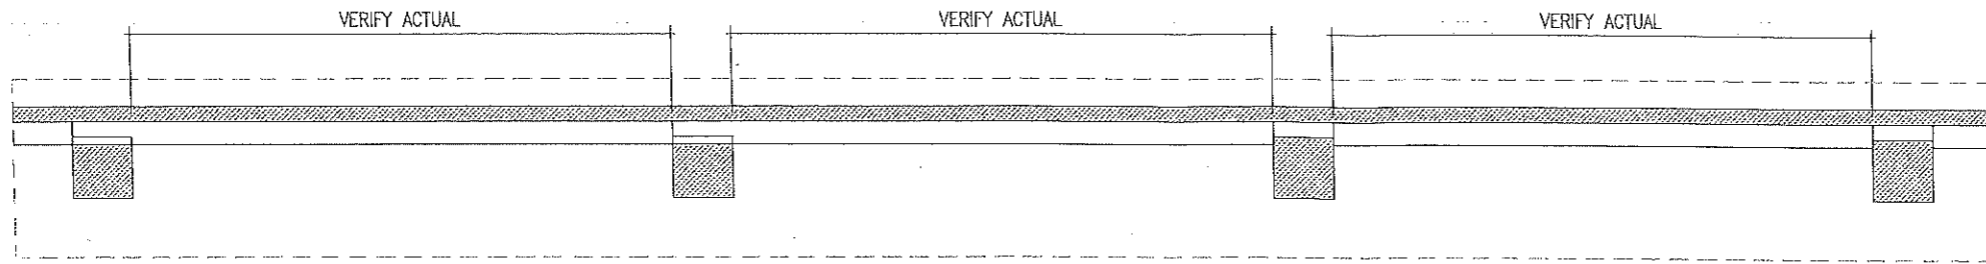


PLAN VIEW

DAVAO DEL SUR VINYL STICKER LOGO
ON STAINLESS STEEL BACKING
WITH LED BACKLIGHT

 WALL CLADDING
SEE DETAIL



ENGINEERED WOOD PLANKS 910X125MM
(TONGUE AND GROOVE JOINTS)

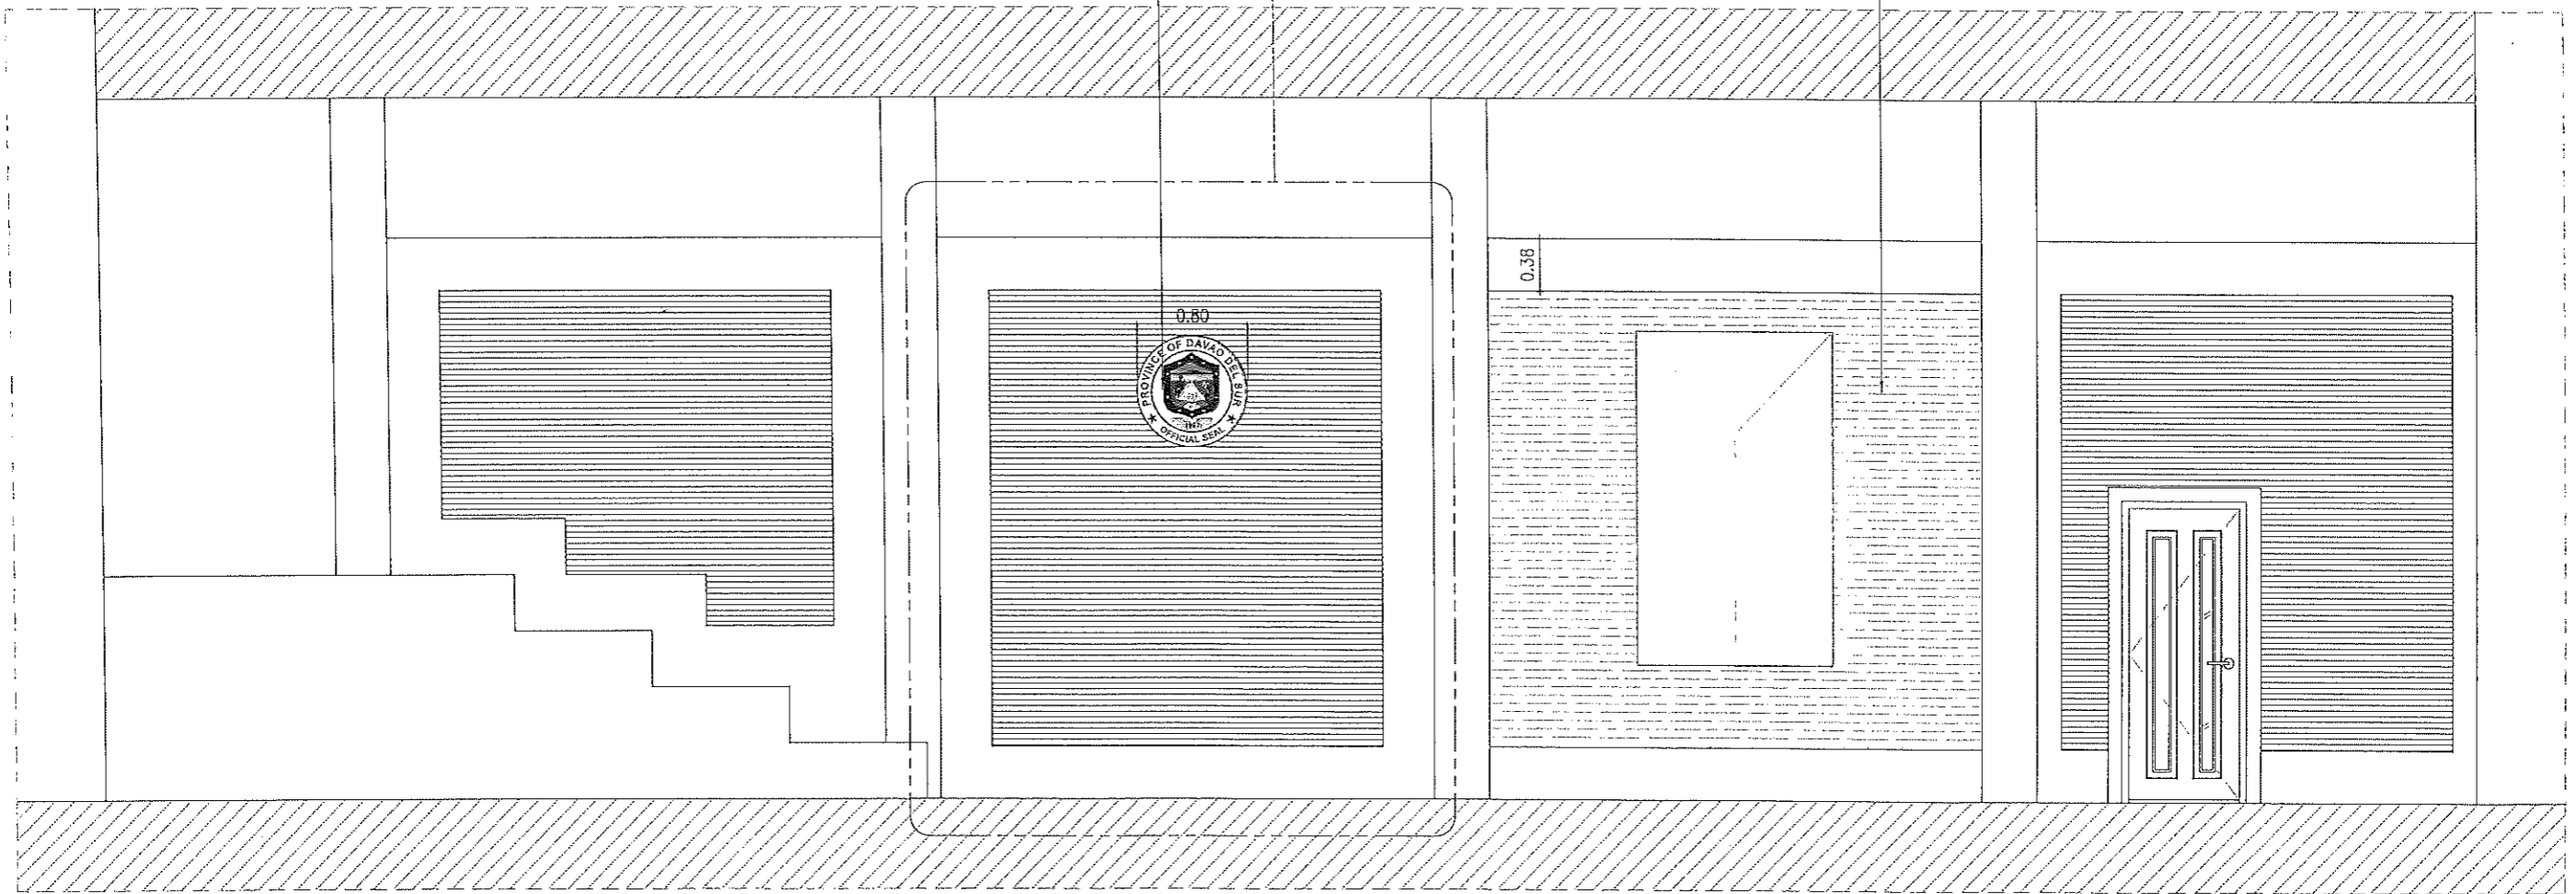

1 SECTION THRU A-A
A-12 SCALE 1:50



REPUBLIC OF THE PHILIPPINES
PROVINCIAL ENGINEER'S OFFICE
SAN AGUSTIN, DIGOS CITY, DAVAO DEL SUR

PROJECT TITLE:
REPAIR /IMPROVEMENT OF SANGGUNIANG
PANLALAWIGAN BUILDING

LOCATION:
MATTI, DIGOS CITY, DAVAO DEL SUR


PREPARED BY:
[Signature]
REXIE GREY B. TABAY
ARCHITECT III

REVIEWED BY:
[Signature]
JOSEPH R. GONZALES
ENGINEER III
PLANNING AND PROGRAMMING DIV. HEAD

RECOMMENDING APPROVAL:
[Signature]
LEONERL MARCH P. SUARIO
PROVINCIAL ENGINEER

APPROVED BY:
[Signature]
YVONNE RONALD CAGAS
PROVINCIAL GOVERNOR

SHEET NO.:
A-12
12 79

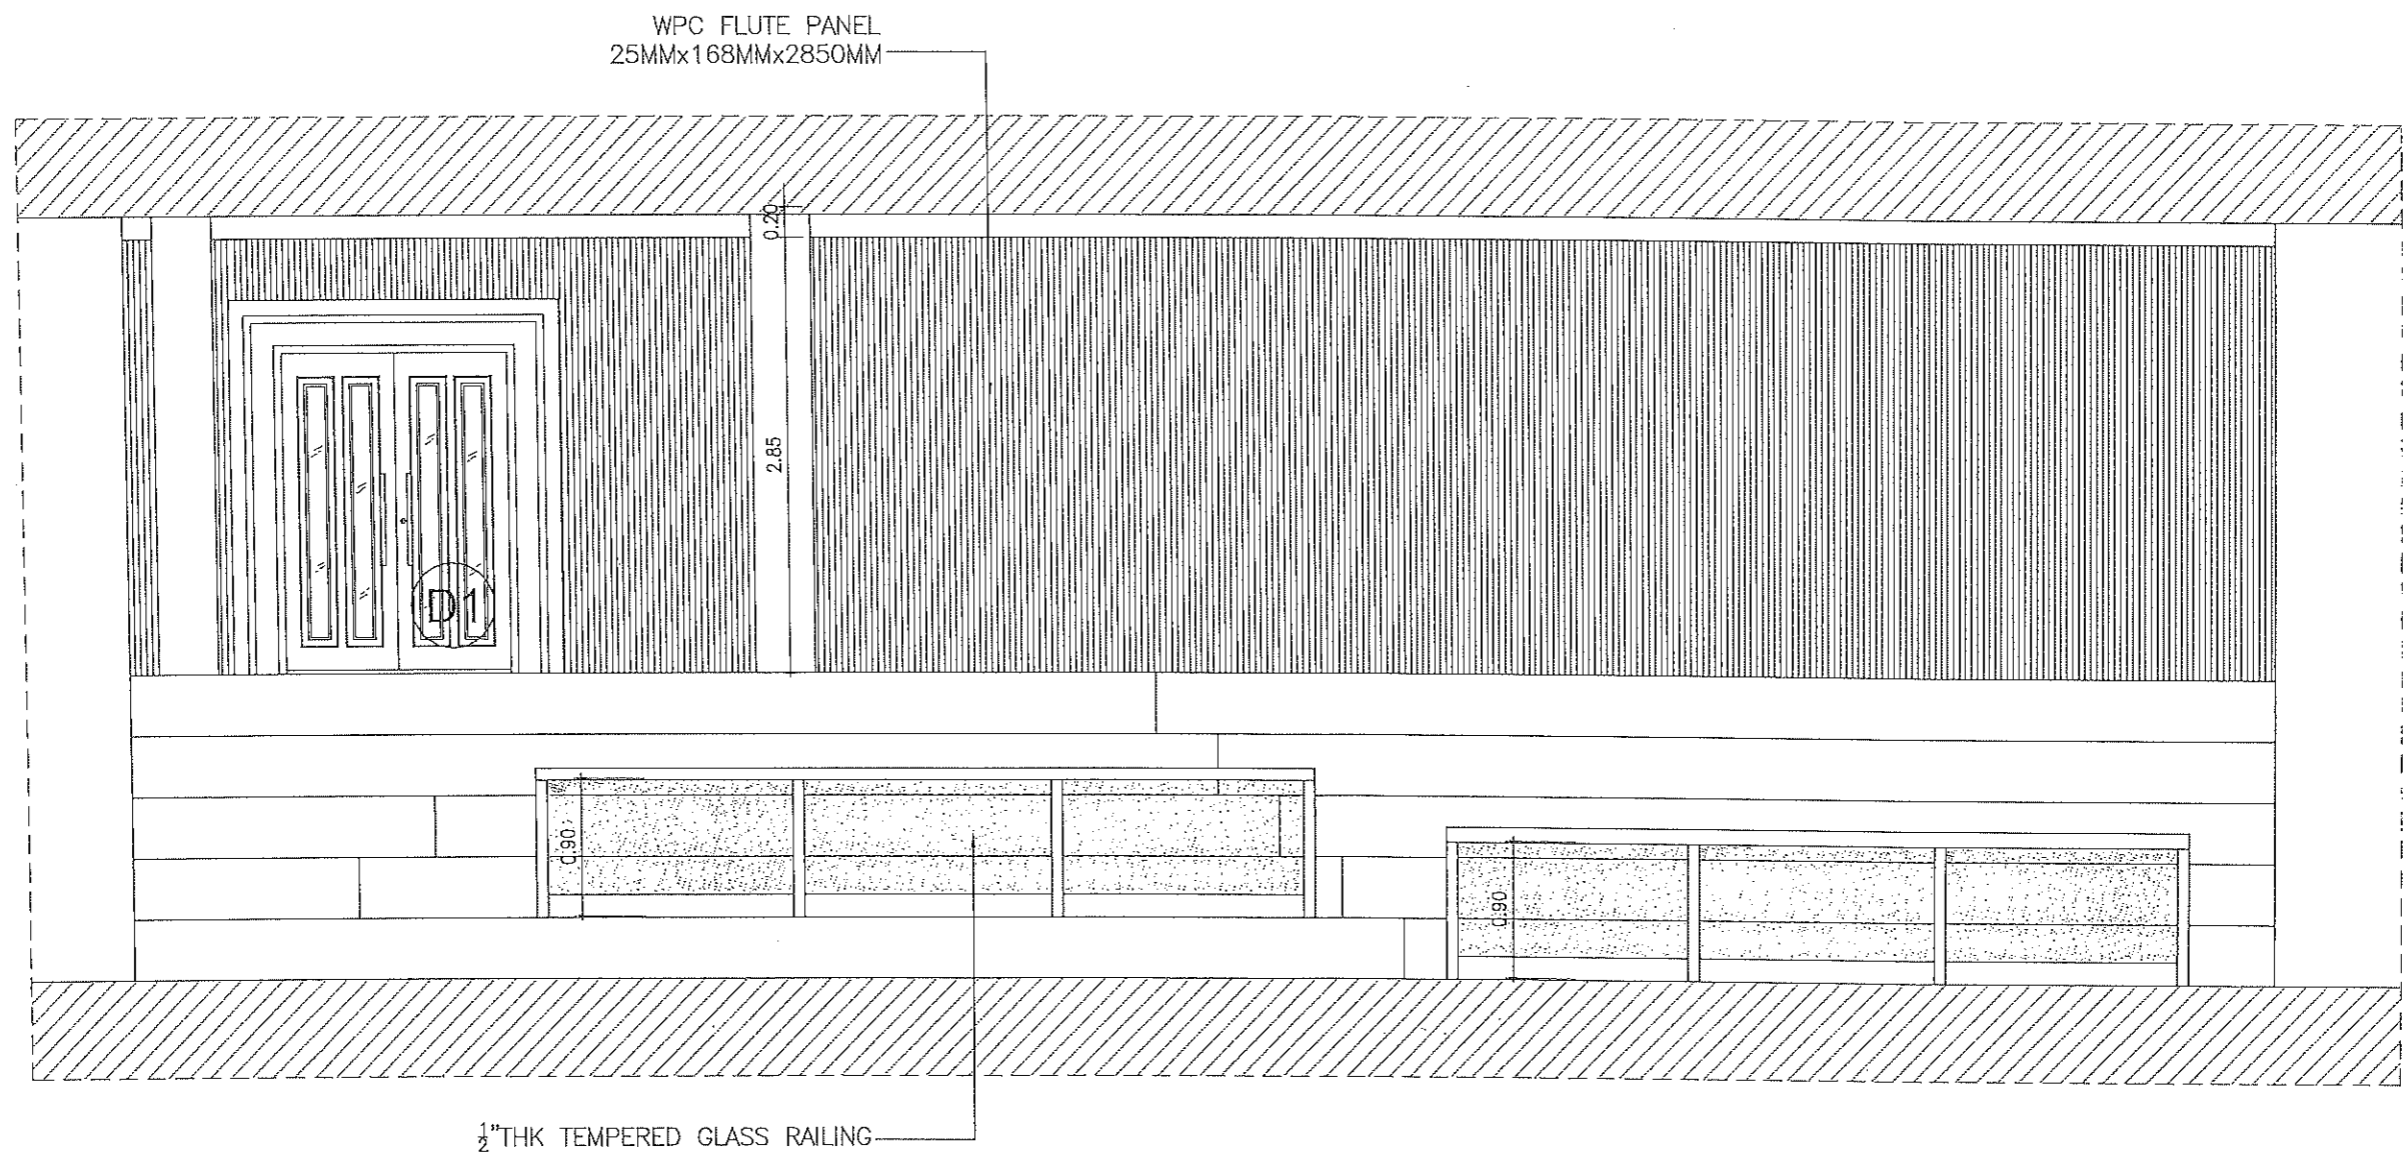

1 SECTION THRU C-C
A-13 SCALE 1:50




REPUBLIC OF THE PHILIPPINES
PROVINCIAL ENGINEER'S OFFICE
SAN AGUSTIN, DIGOS CITY, DAVAO DEL SUR

PROJECT TITLE: REPAIR /IMPROVEMENT OF SANGGUNIANG PANLALAWIGAN BUILDING	PREPARED BY: <i>Rexie Grey B. Tabay</i> REXIE GREY B. TABAY ARCHITECT III	REVIEWED BY: <i>Joseph R. Gonzales</i> JOSEPH R. GONZALES ENGINEER - III PLANNING AND PROGRAMMING DIV. HEAD	RECOMMENDING APPROVAL: <i>Leonerl March P. Suario</i> LEONERL MARCH P. SUARIO PROVINCIAL ENGINEER	APPROVED BY: <i>Yvonne Roña Cagas</i> YVONNE ROÑA CAGAS PROVINCIAL GOVERNOR	SHEET NO.: A-13 13 79
LOCATION: MATTI, DIGOS CITY, DAVAO DEL SUR					


18MM THK MARINE PLYWOOD
PAINTED FINISH.

WPC FLUTE PANEL
25MMx168MMx2850MM


T5 TUBE COVELIGHT

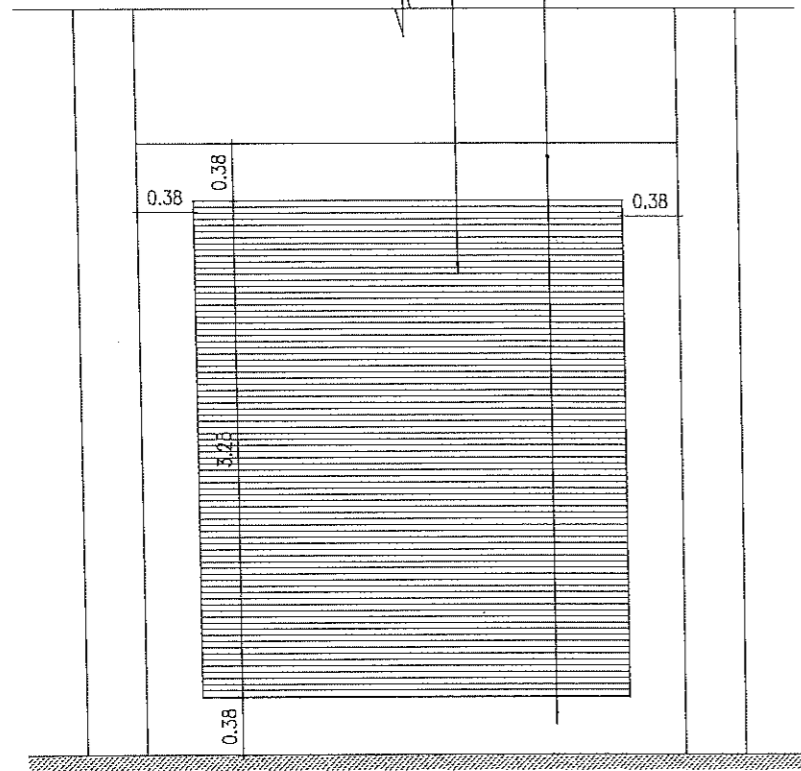

ELEVATION VIEW

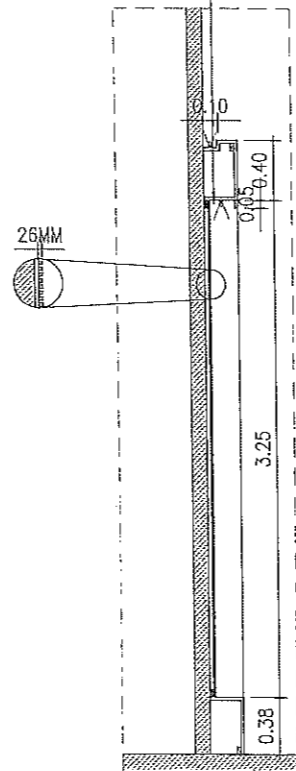


SECTION VIEW

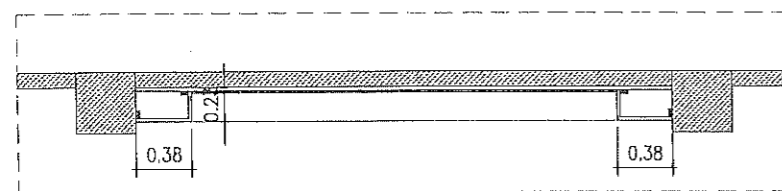


PLAN VIEW

6.0MM THK. FIBER CEMENT
BOARD ON METAL FRAMES, BACKWALL,
CLAD W/WOOD PLANKS,
(910MMx125MMx15MM)

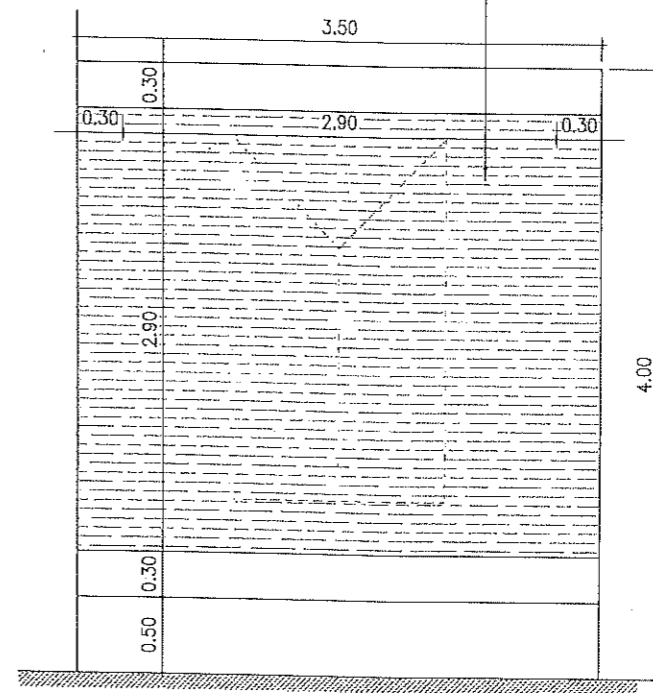

ELEVATION VIEW

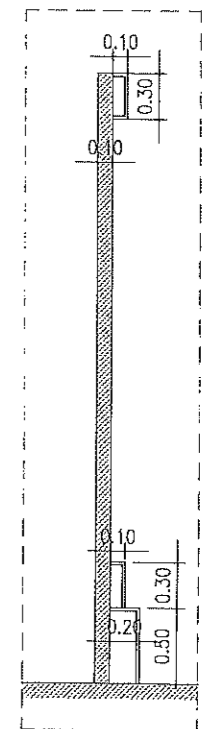

SECTION VIEW

1 CLADDING DETAIL
A-14 SCALE 1:50

2 BACKWALL DETAIL
A-14 SCALE 1:50



REPUBLIC OF THE PHILIPPINES
PROVINCIAL ENGINEER'S OFFICE
SAN AGUSTIN, DIGOS CITY, DAVAO DEL SUR

PROJECT TITLE:
REPAIR /IMPROVEMENT OF SANGGUNIANG
PANLALAWIGAN BUILDING
LOCATION:
MATTI, DIGOS CITY, DAVAO DEL SUR


PREPARED BY:
[Signature]
REXIE GREY B. TABAY
ARCHITECT III

REVIEWED BY:
[Signature]
JOSEPH R. GONZALES
ENGINEER - III
PLANNING AND PROGRAMMING DIV. HEAD

RECOMMENDING APPROVAL:
[Signature]
LEONERL MARCH P. SUARIO
PROVINCIAL ENGINEER


APPROVED BY:
[Signature]
YVONNE ROÑA CAGAS
PROVINCIAL GOVERNOR

SHEET NO.:
A-14
14 79

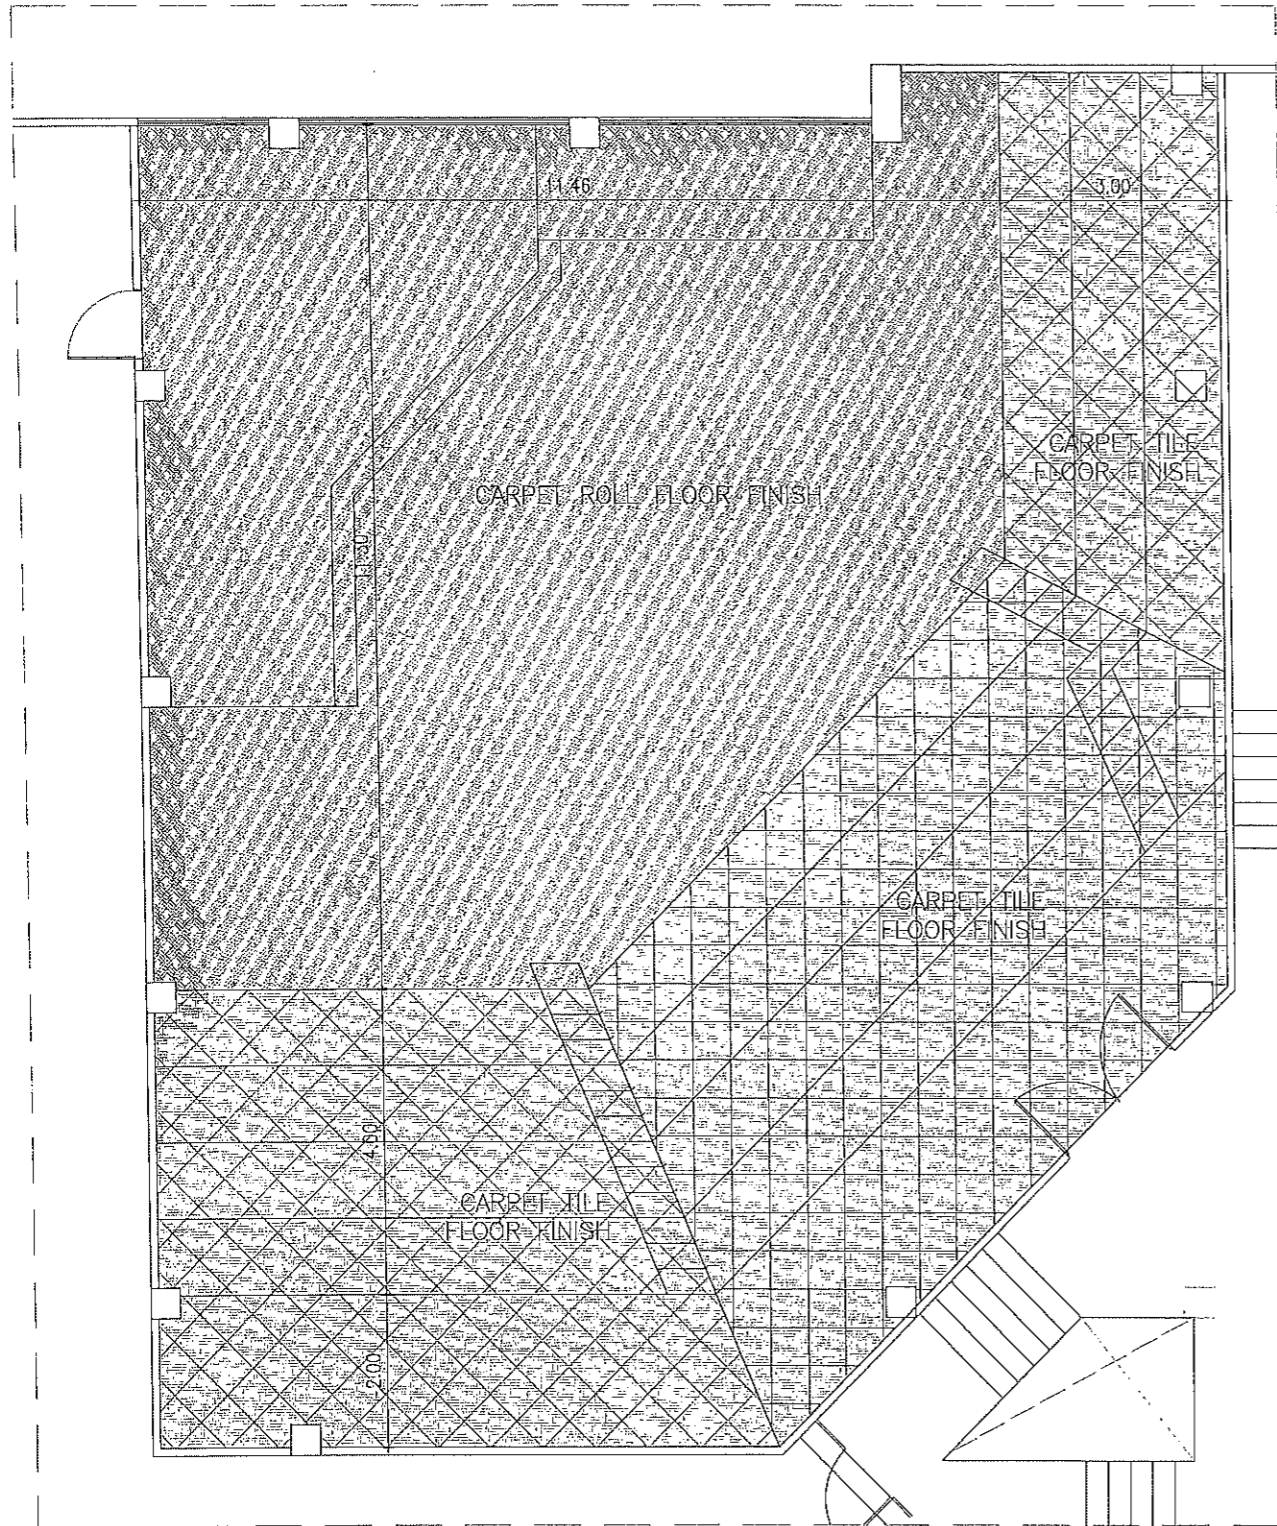

SPECIFICATIONS

- COLD-ROLLED STEEL
- ABS PLASTIC SHELL
- 100% ACRYLIC FABRIC UPHOLSTERED
- CUTTING AND MOULD FOAM
- WOOD OR PLASTIC ARMREST

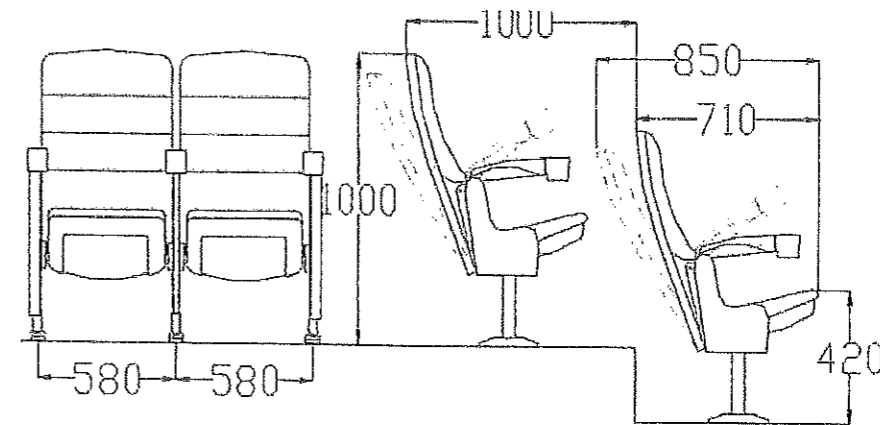

1 CARPET FLOOR DETAIL
A-15 SCALE 1:100

2 DELUXE THEATER SEAT DETAIL
A-15



REPUBLIC OF THE PHILIPPINES
PROVINCIAL ENGINEER'S OFFICE
SAN AGUSTIN, DIGOS CITY, DAVAO DEL SUR

PROJECT TITLE:
**REPAIR /IMPROVEMENT OF SANGGUNIANG
PANLALAWIGAN BUILDING**

LOCATION:
MATTI, DIGOS CITY, DAVAO DEL SUR

PREPARED BY:
[Signature]
REXIE GREY B. TABAY
ARCHITECT III

REVIEWED BY:
[Signature]
JOSEPH R. GONZALES
ENGINEER - III
PLANNING AND PROGRAMMING DIV. HEAD


RECOMMENDING APPROVAL:
[Signature]
LEONERL MARCH P. SUARIO
PROVINCIAL ENGINEER

APPROVED BY:
[Signature]
YVONNE ROÑA CAGAS
PROVINCIAL GOVERNOR

SHEET NO.:
A-15
15 79

T5 FLOUSCENT LED COVELIGHTING

RECESSED PINLIGHT
(REFER TO ELECTRICAL)

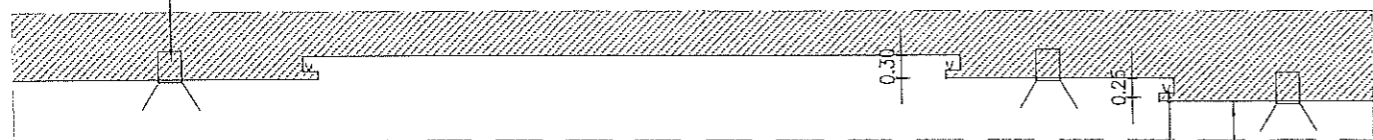

SECTION THRU A-A

T5 FLOUSCENT LED COVELIGHTING


5.0MM THK. MARINE
PLYWOOD CEILING
ON METAL FURRING

PVC CEILING PANEL, WALNUT
W/ CEILING CORNICE


T5 FLOUSCENT LED COVELIGHTING

A
A-16

LED PANEL LIGHT

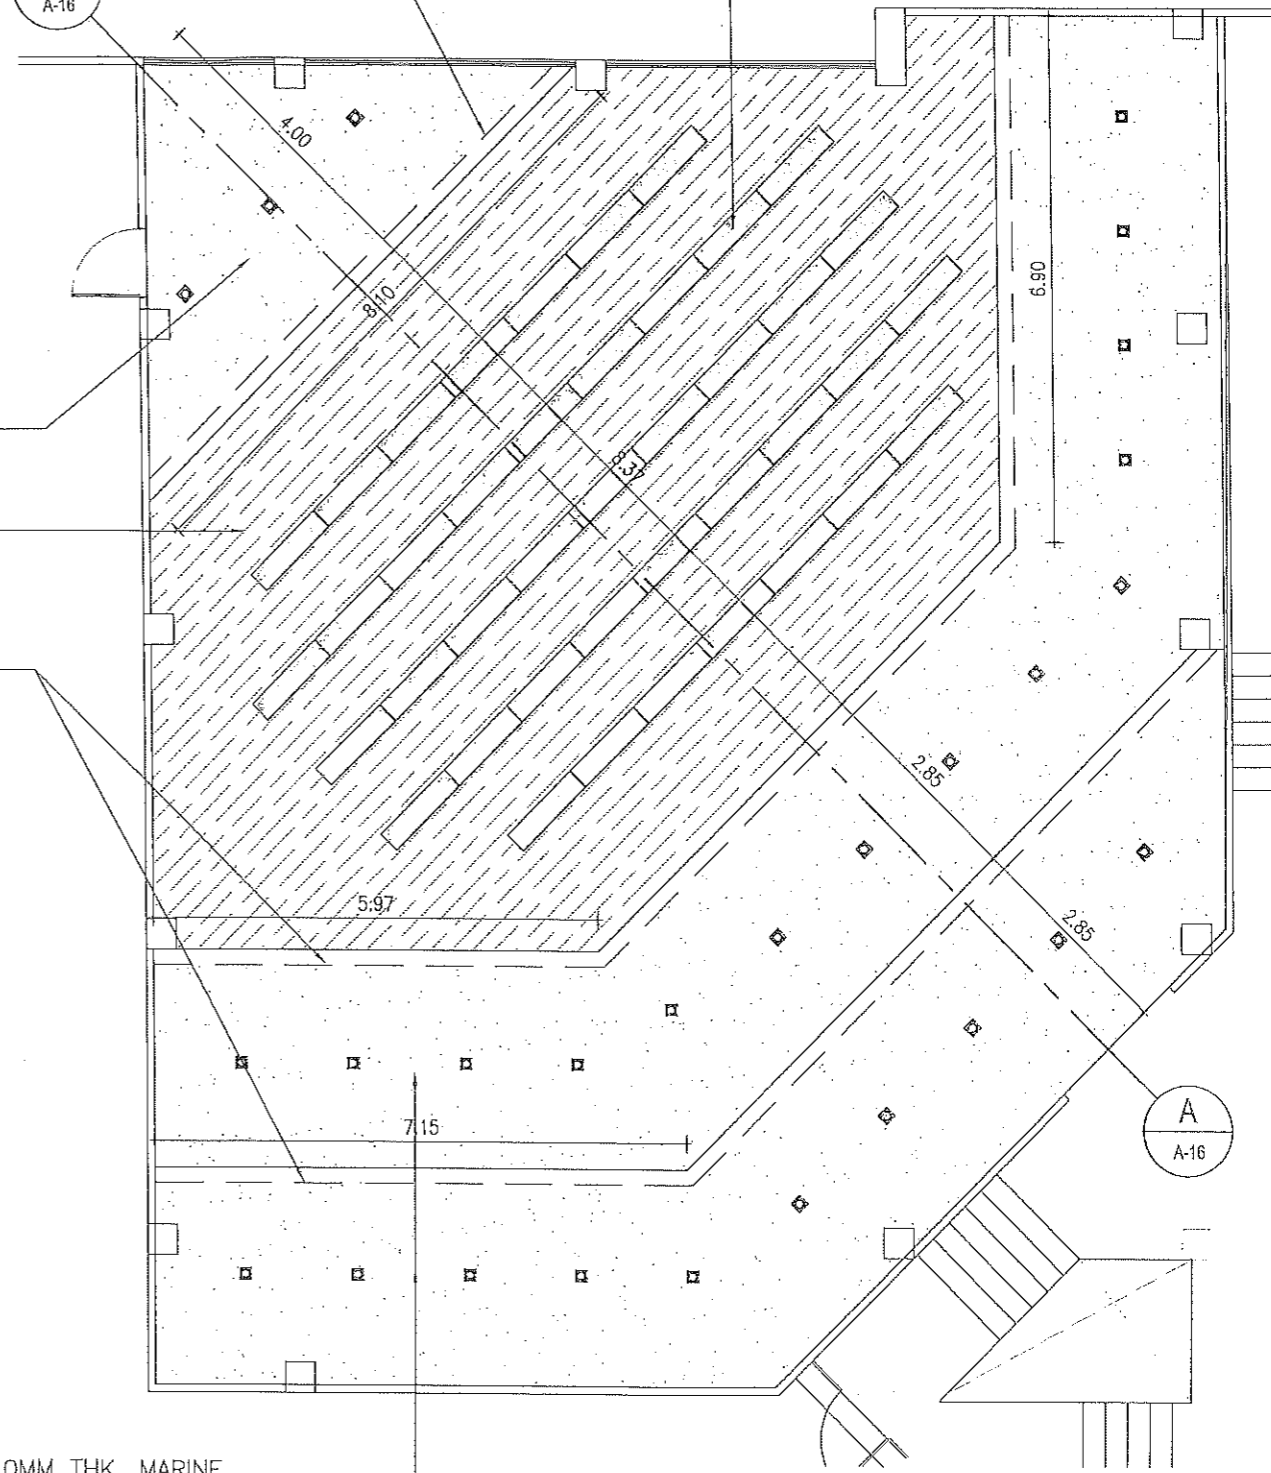

5.0MM THK. MARINE
PLYWOOD CEILING
ON METAL FURRING
W/ CEILING CORNICE

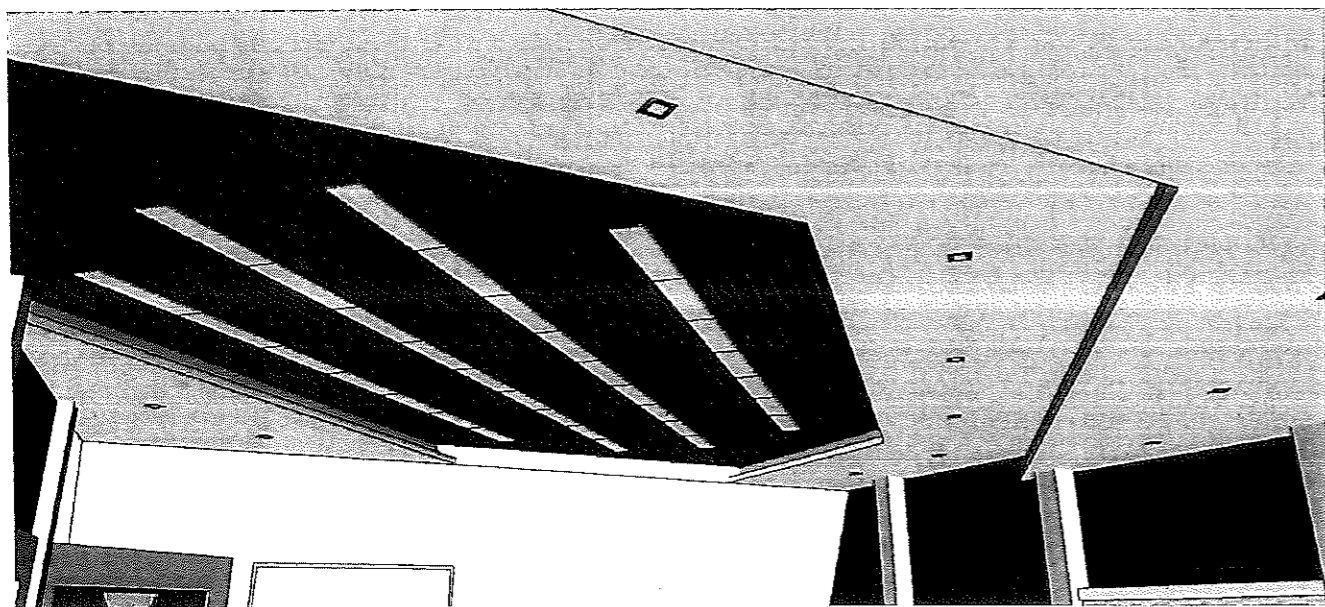

**CEILING PERSPECTIVE
SESSION HALL**

1
A-16

2
A-16

CEILING DETAIL

SCALE 1:100



REPUBLIC OF THE PHILIPPINES
PROVINCIAL ENGINEER'S OFFICE
SAN AGUSTIN, DIGOS CITY, DAVAO DEL SUR

PROJECT TITLE:
REPAIR /IMPROVEMENT OF SANGGUNIANG
PANLALAWIGAN BUILDING

LOCATION:
MATTI, DIGOS CITY, DAVAO DEL SUR

PREPARED BY:
Rexie Grey B. Tabay
REXIE GREY B. TABAY
ARCHITECT III

REVIEWED BY:
Joseph R. Gonzales
JOSEPH R. GONZALES
ENGINEER - III
PLANNING AND PROGRAMMING DIV. HEAD


RECOMMENDING APPROVAL:
Leonerl March P. Suario
LEONERL MARCH P. SUARIO
PROVINCIAL ENGINEER

APPROVED BY:
Yvonne Roña Cagas
YVONNE ROÑA CAGAS
PROVINCIAL GOVERNOR


SHEET NO.:
A-16
16 79

LOAD SCHEDULE :


CIRCUIT NO.	DESCRIPTION	QUANTITY	VOLTS	WATTS	AMPS	TRIP	CONDUCTOR SIZE	CONDUIT SIZE
PB 1	LIGHTING OUTLET	27	230	1,350	5.87	20 A	2- 3.5 mm ² THW Stranded Copper Wire , 1 - 2.0 mm ² THW Stranded Copper Wire	20 mm dia. uPVC
PB 2	LIGHTING OUTLET	41	230	2,050	8.91	20 A	2- 3.5 mm ² THW Stranded Copper Wire , 1 - 2.0 mm ² THW Stranded Copper Wire	20 mm dia. uPVC
PB 3	LIGHTING OUTLET	30	230	1,500	6.52	20 A	2- 3.5 mm ² THW Stranded Copper Wire , 1 - 2.0 mm ² THW Stranded Copper Wire	20 mm dia. uPVC
PB 4	LIGHTING OUTLET	24	230	1,200	5.22	20 A	2- 3.5 mm ² THW Stranded Copper Wire , 1 - 2.0 mm ² THW Stranded Copper Wire	20 mm dia. uPVC
PB 5	CONVENIENCE OUTLET	8	230	1,440	6.26	20 A	2- 3.5 mm ² THW Stranded Copper Wire , 1 - 2.0 mm ² THW Stranded Copper Wire	20 mm dia. uPVC

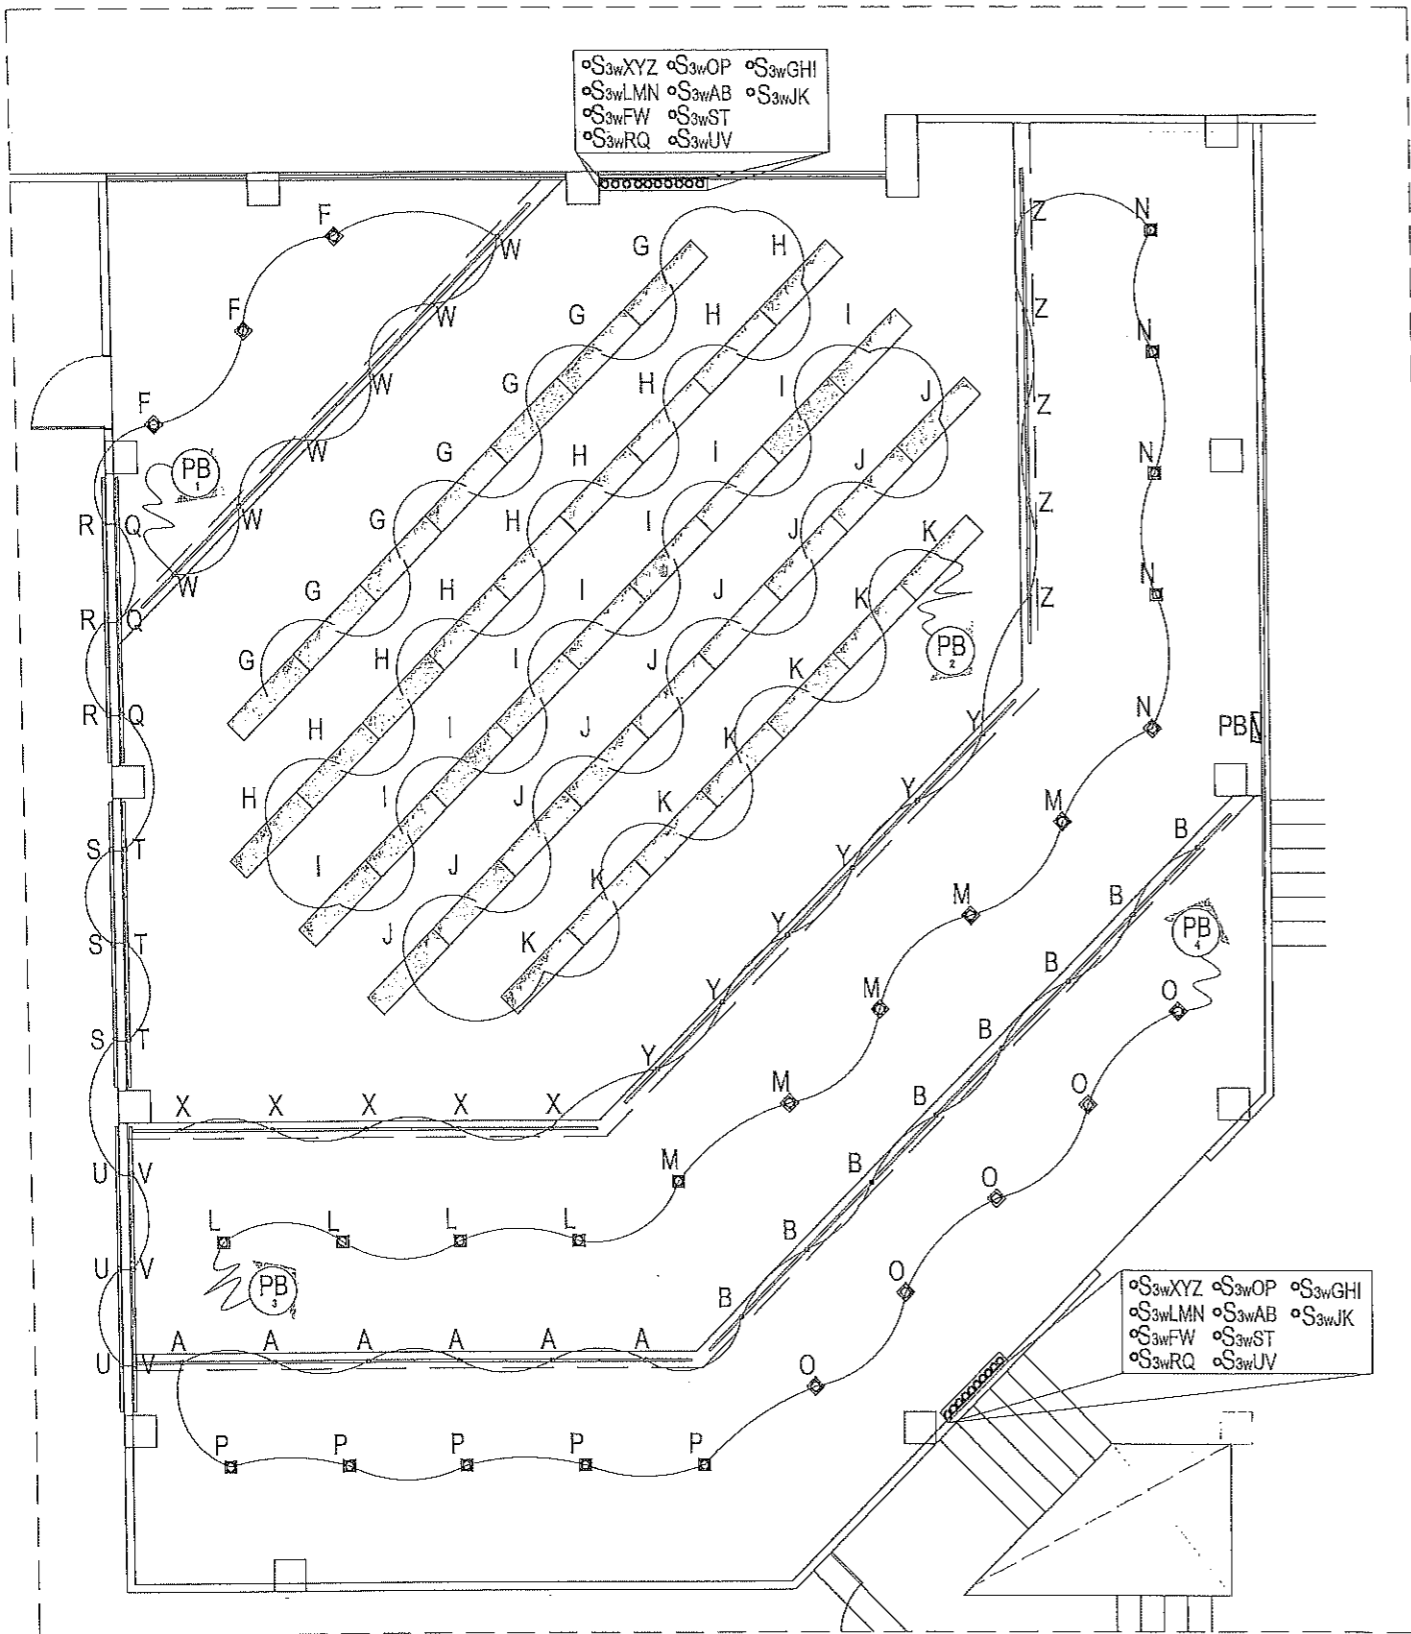

LEGEND:

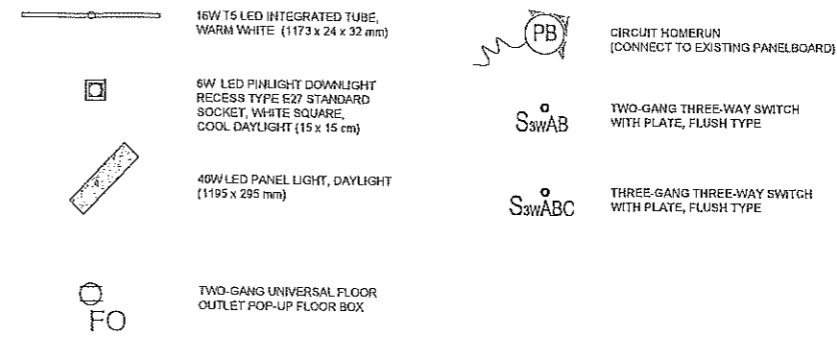


NOTE:
- CONNECT TO EXISTING PANEL BOARD FOR POWER SOURCE

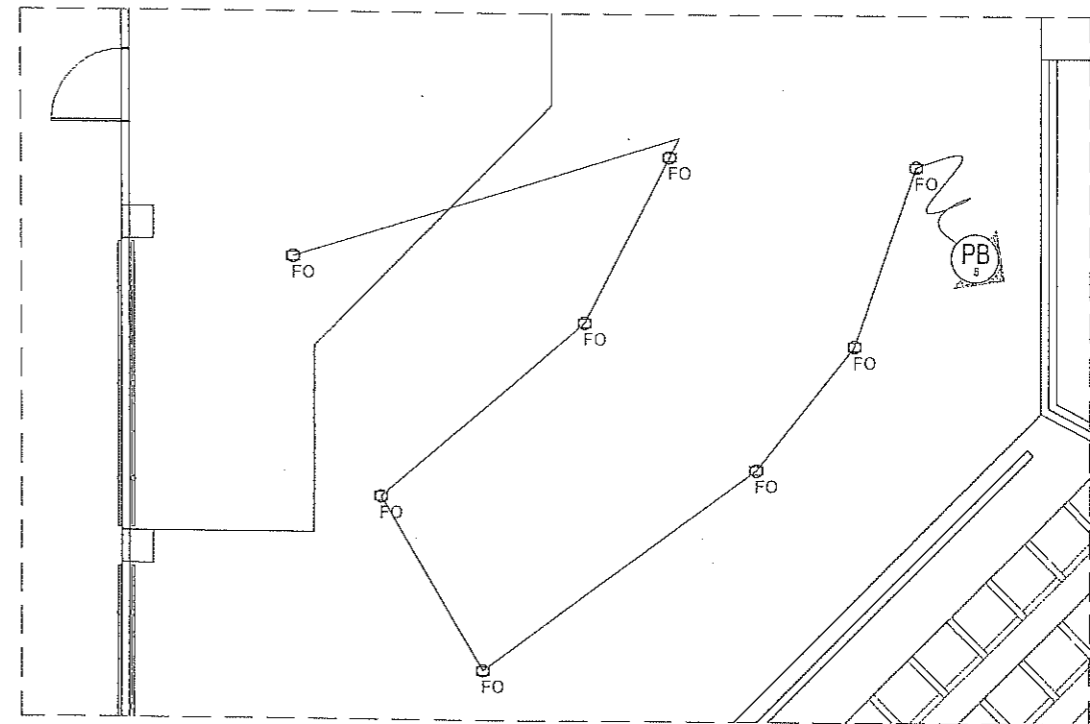


 
 


1 SESSION HALL LIGHTING & POWER LAYOUT
E-1 SCALE 1:100

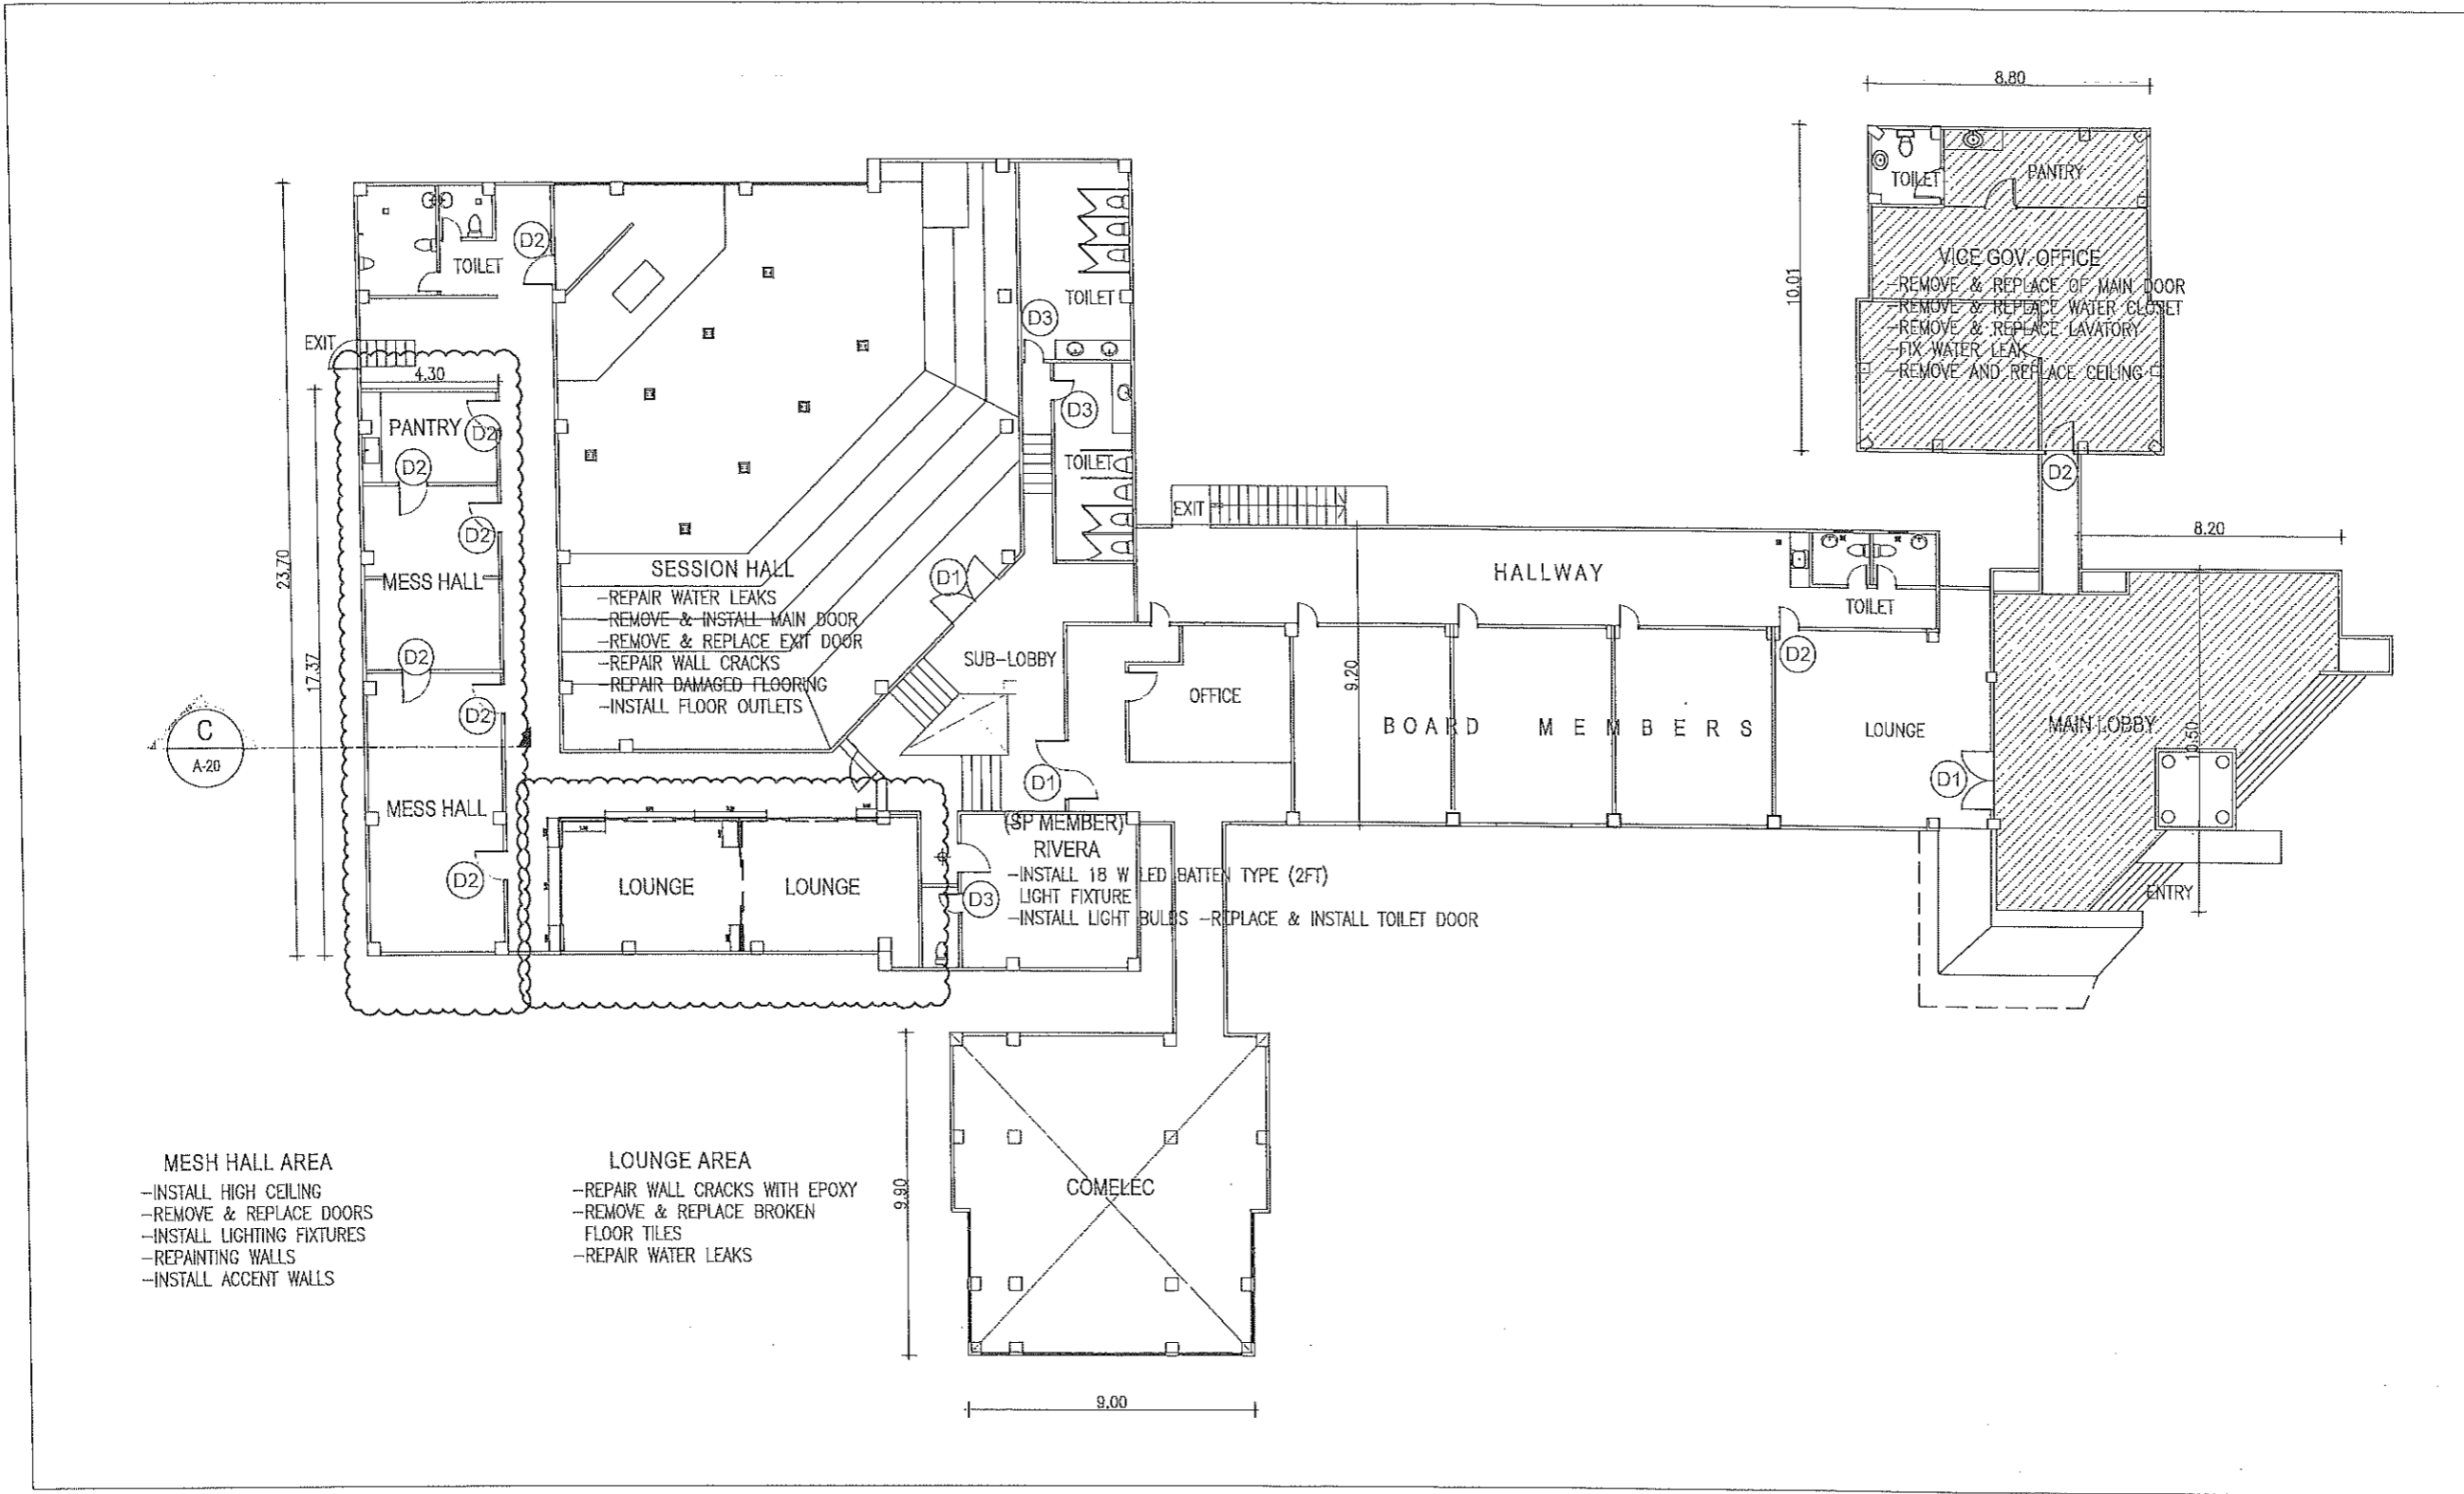
L O U N G E & M E S H H A L L
(@ 2ND FLOOR)



LOUNGE & MESH HALL DETAIL @ 2ND FLOOR

1
A-18


 <p>REPUBLIC OF THE PHILIPPINES PROVINCIAL ENGINEER'S OFFICE SAN AGUSTIN, DIGOS CITY, DAVAO DEL SUR</p>	PROJECT TITLE: REPAIR /IMPROVEMENT OF SANGGUNIANG PANLALAWIGAN BUILDING	PREPARED BY:  REXIE GREY B. TABAY ARCHITECT III	REVIEWED BY:  JOSEPH R. GONZALES ENGINEER - III PLANNING AND PROGRAMMING DIV. HEAD	RECOMMENDING APPROVAL:  LEONERL MARCH P. SUARIO PROVINCIAL ENGINEER	APPROVED BY:  YVONNE RONA CAGAS PROVINCIAL GOVERNOR	SHEET NO.: A-18 18 79
	LOCATION: MATTI, DIGOS CITY, DAVAO DEL SUR					

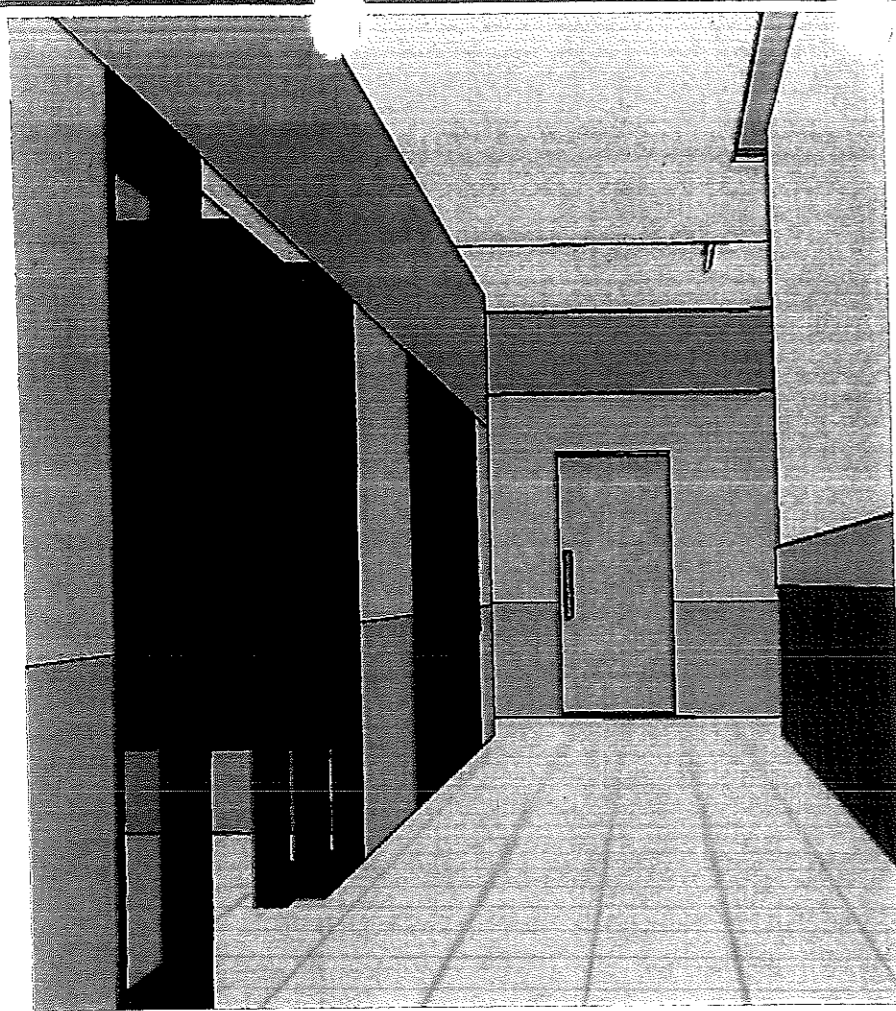

LOUNGE HALLWAY

PVC CEILING WOOD GRAIN DESIGN.
PINLIGHT FIXTURE.

NOTE : FURNITURE AND APPLIANCE ARE NOT INCLUDED ON PAY ITEM.

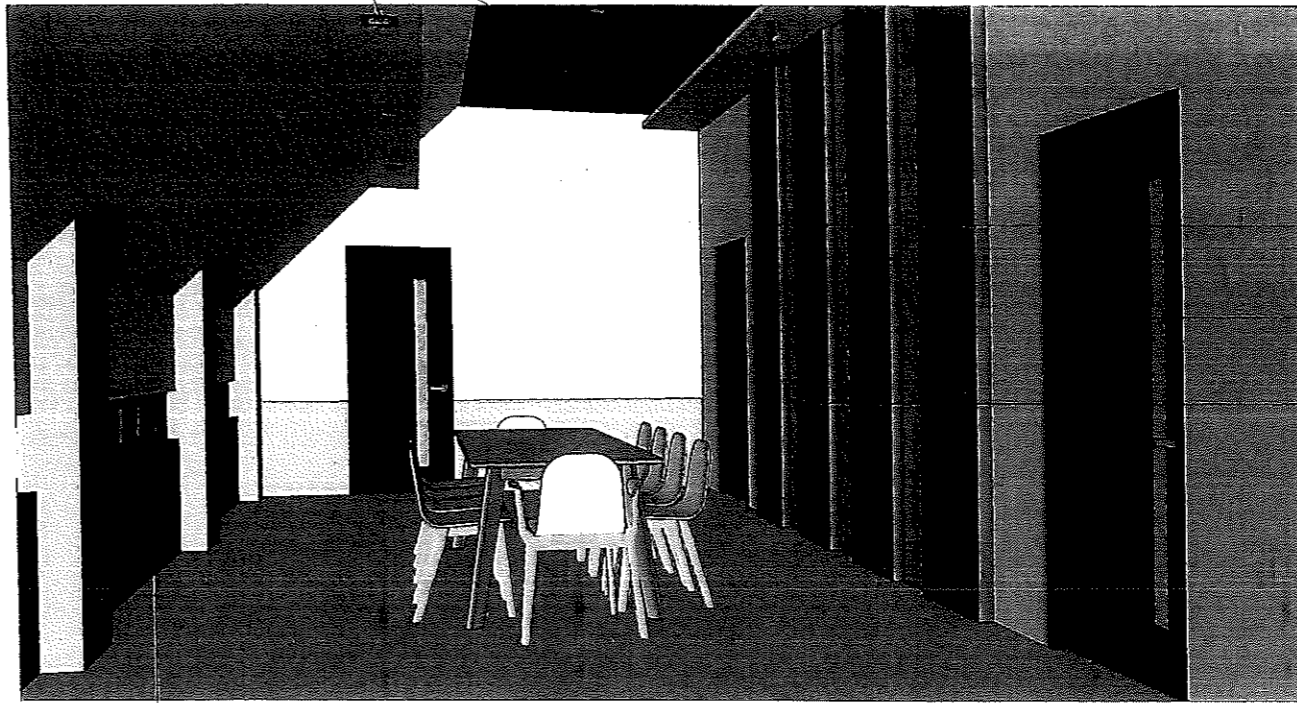


LAMINATED BOARD
ACCENT WALL.
PANEL DOOR W/
FIXED GLASS.
MIRROR.


WPC FLUTE PANEL
25MMx168MMx2850MM

2
A-19

**PERSPECTIVE
MESH HALL AT 2ND LEVEL**

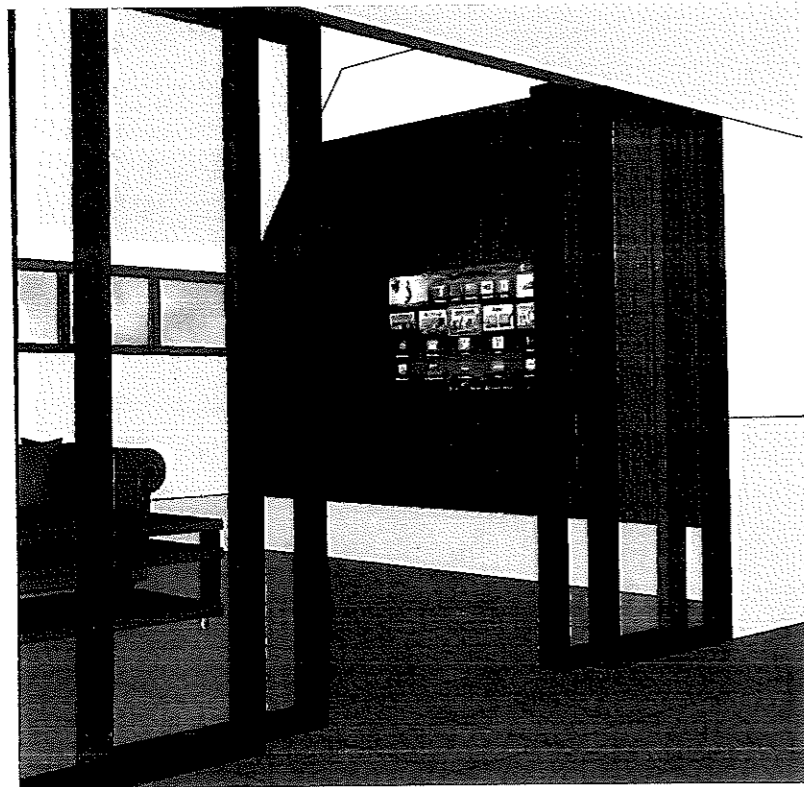

LOUNGE ENTRY

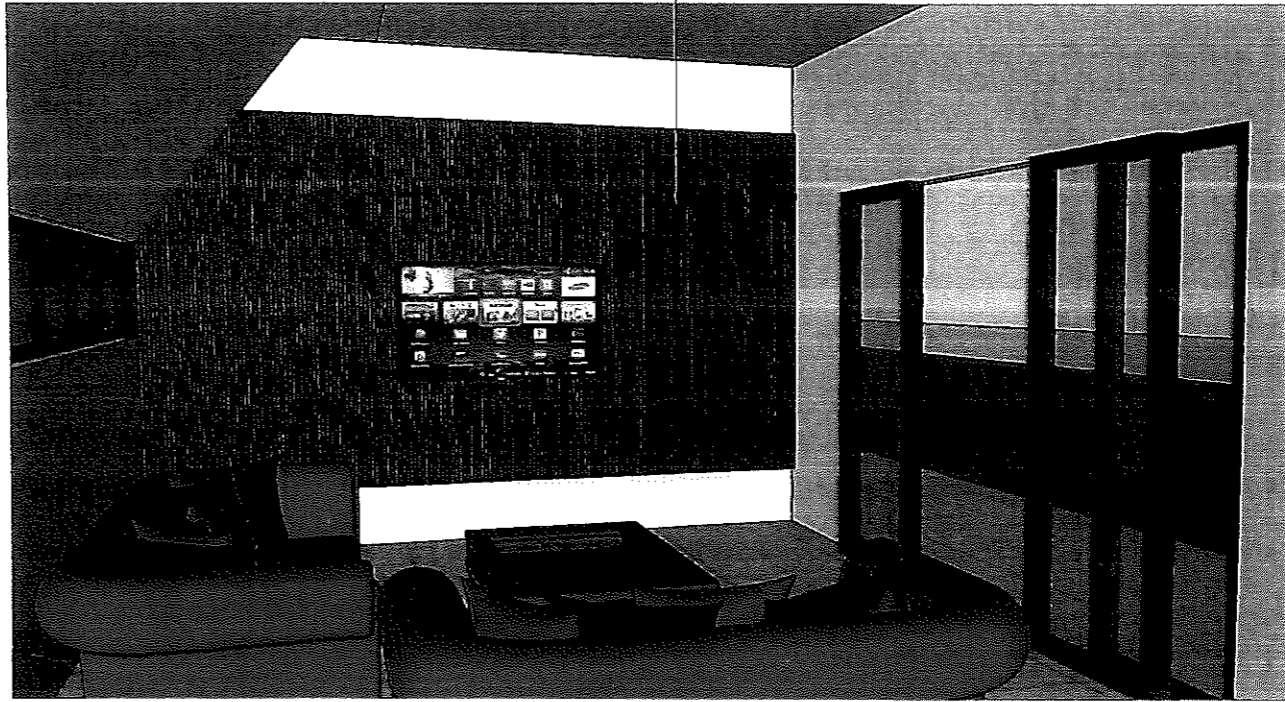

LOUNGE INSIDE

1
A-19

**PERSPECTIVE
LOUNGE AT 2ND LEVEL**



REPUBLIC OF THE PHILIPPINES
PROVINCIAL ENGINEER'S OFFICE
SAN AGUSTIN, DIGOS CITY, DAVAO DEL SUR

PROJECT TITLE:
**REPAIR /IMPROVEMENT OF SANGGUNIANG
PANLALAWIGAN BUILDING**
LOCATION:
MATTI, DIGOS CITY, DAVAO DEL SUR


PREPARED BY:
Rexie Grey B. Tagay
REXIE GREY B. TAGAY
ARCHITECT III

REVIEWED BY:
Joseph R. Gonzales
JOSEPH R. GONZALES
ENGINEER - III
PLANNING AND PROGRAMMING DIV. HEAD


RECOMMENDING APPROVAL:
Leonerl March P. Suario
LEONERL MARCH P. SUARIO
PROVINCIAL ENGINEER

APPROVED BY:
Yvonne Roñacagas
YVONNE ROÑACAGAS
PROVINCIAL GOVERNOR


SHEET NO.:
A-19
19 79

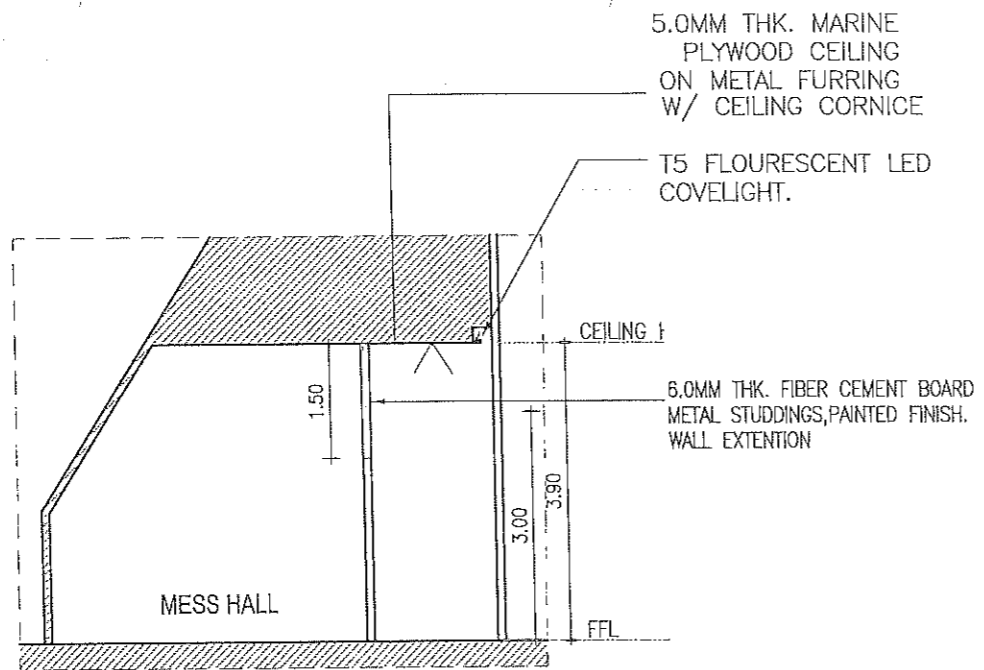


3 SECTION 'C'
 A-20 SCALE 1:100 M.

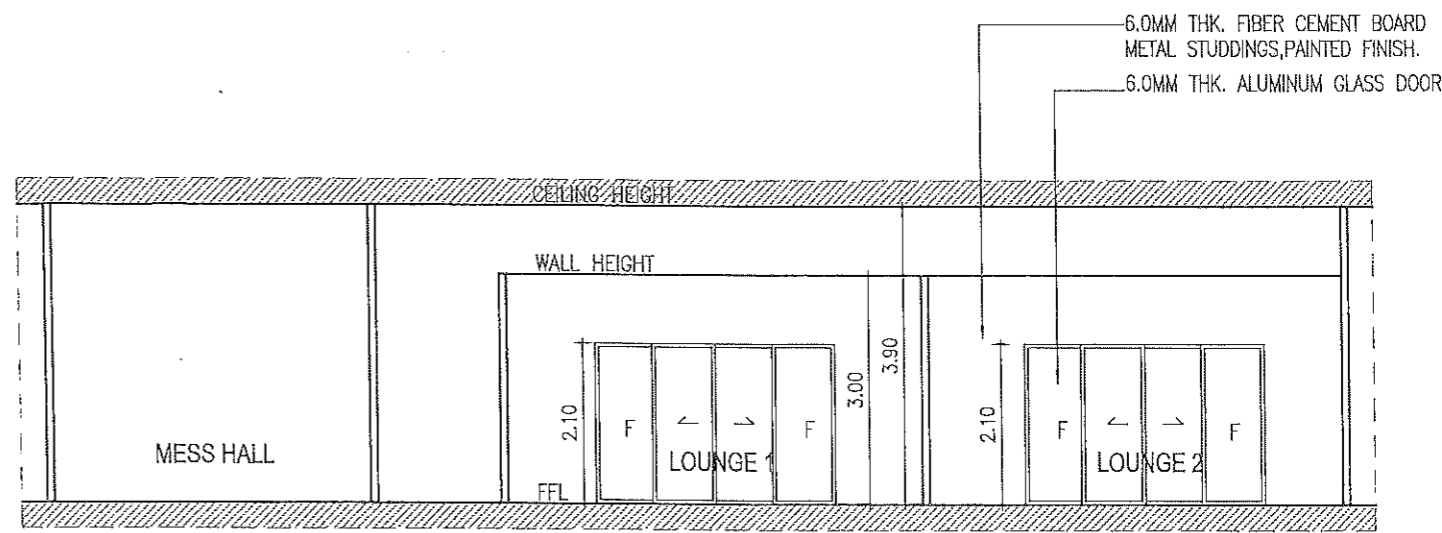

4 SECTION 'B'
 A-20 SCALE 1:100 M.

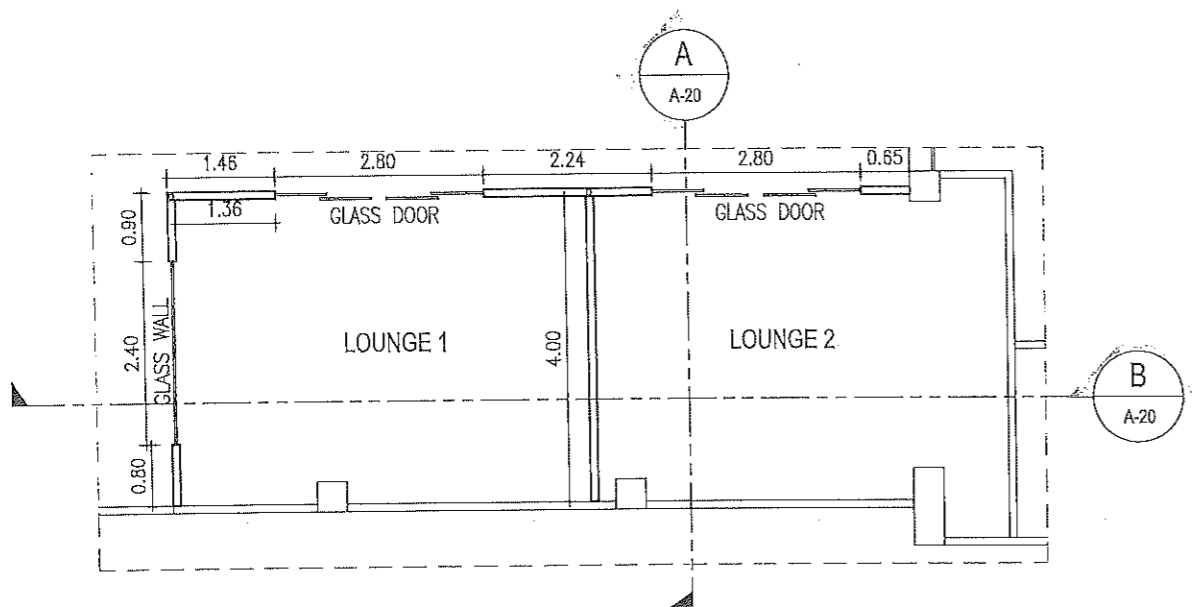

1 FLOOR PLAN
 A-20 SCALE 1:100 M.

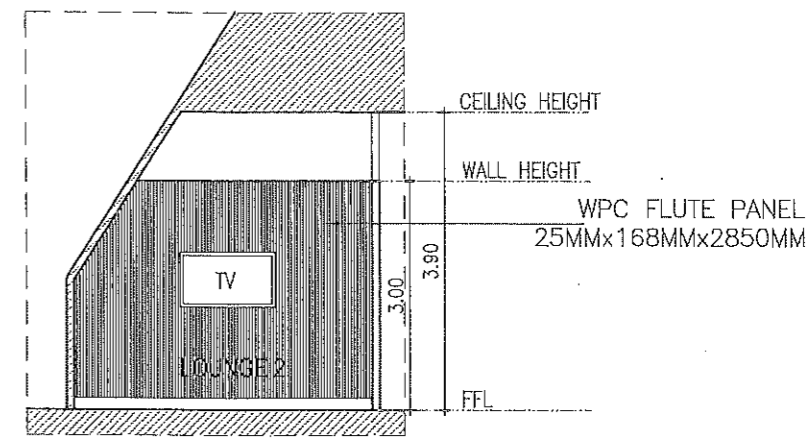

2 SECTION 'A'
 A-20 SCALE 1:100 M.



REPUBLIC OF THE PHILIPPINES
PROVINCIAL ENGINEER'S OFFICE
 SAN AGUSTIN, DIGOS CITY, DAVAO DEL SUR

PROJECT TITLE:
 REPAIR /IMPROVEMENT OF SANGGUNIANG
 PANLALAWIGAN BUILDING

LOCATION:
 MATTI, DIGOS CITY, DAVAO DEL SUR


PREPARED BY:
[Signature]
 REXIE GREY B. TABAY
 ARCHITECT III

REVIEWED BY:
[Signature]
 JOSEPH R. GONZALES
 ENGINEER - III
 PLANNING AND PROGRAMMING DIV. HEAD

RECOMMENDING APPROVAL:
[Signature]
 LEONERL MARCH P. SUARIO
 PROVINCIAL ENGINEER

APPROVED BY:
[Signature]
 YVONNE RONALD CAGAS
 PROVINCIAL GOVERNOR

SHEET NO.:
A-20
 20 79


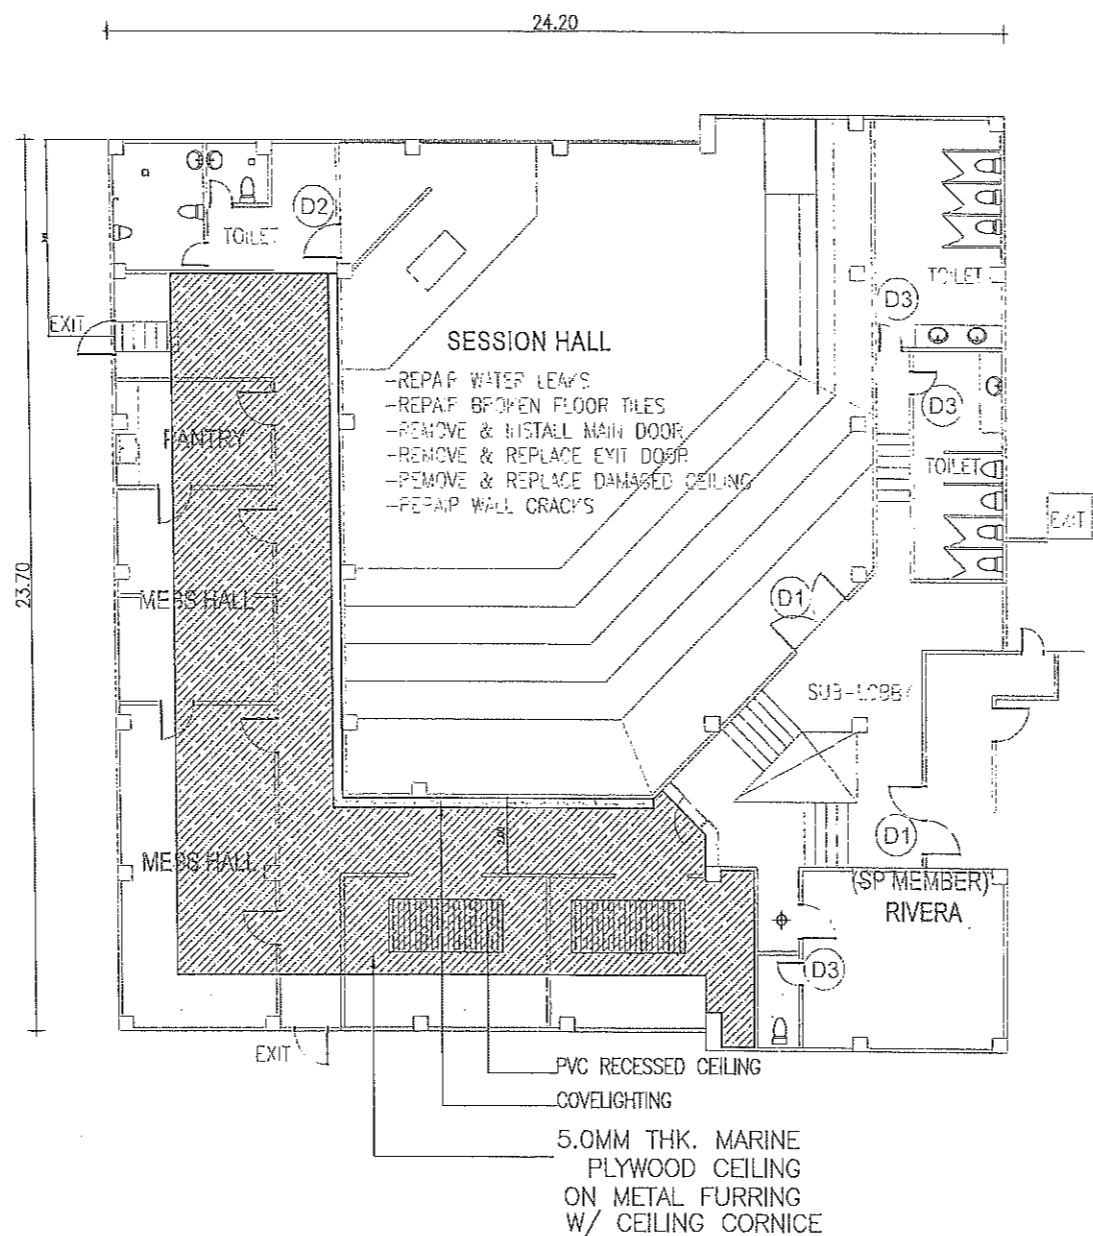


1 CEILING DETAIL
 A-21 SCALE 1:100



REPUBLIC OF THE PHILIPPINES
PROVINCIAL ENGINEER'S OFFICE
 SAN AGUSTIN, DIGOS CITY, DAVAO DEL SUR

PROJECT TITLE: REPAIR /IMPROVEMENT OF SANGGUNIANG PANLALAWIGAN BUILDING	PREPARED BY: <i>[Signature]</i> REXIE GREY B. TABAY ARCHITECT III	REVIEWED BY: <i>[Signature]</i> JOSEPH R. GONZALES ENGINEER III PLANNING AND PROGRAMMING DIV. HEAD	RECOMMENDING APPROVAL: <i>[Signature]</i> LEONERL MARCH P. SUARIO PROVINCIAL ENGINEER	APPROVED BY: <i>[Signature]</i> YVONNE ROÑAL CAGAS PROVINCIAL GOVERNOR	SHEET NO.: A-21 21 79
LOCATION: MATTI, DIGOS CITY, DAVAO DEL SUR					

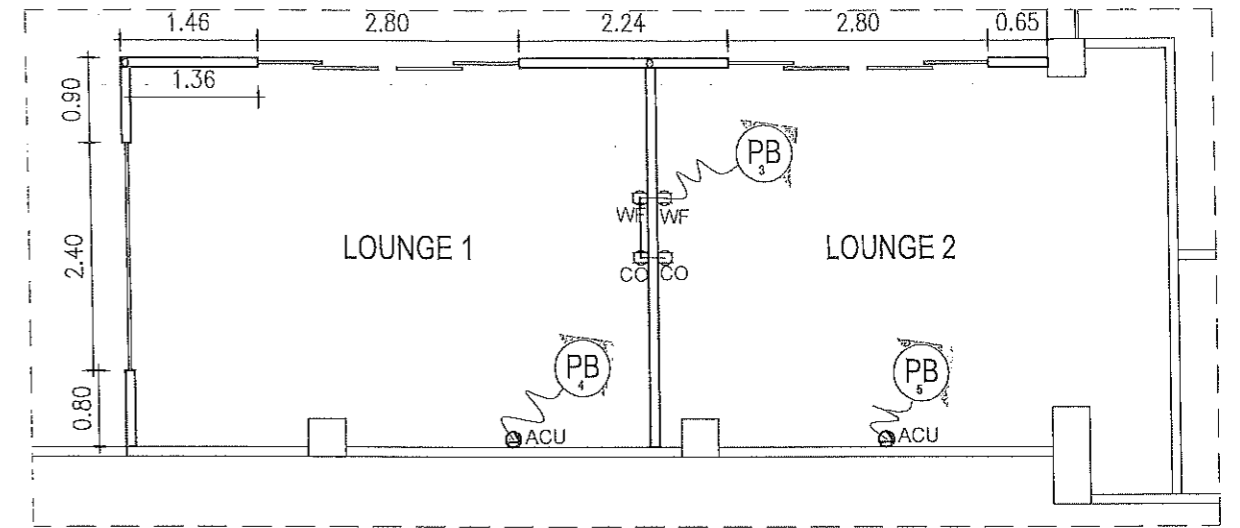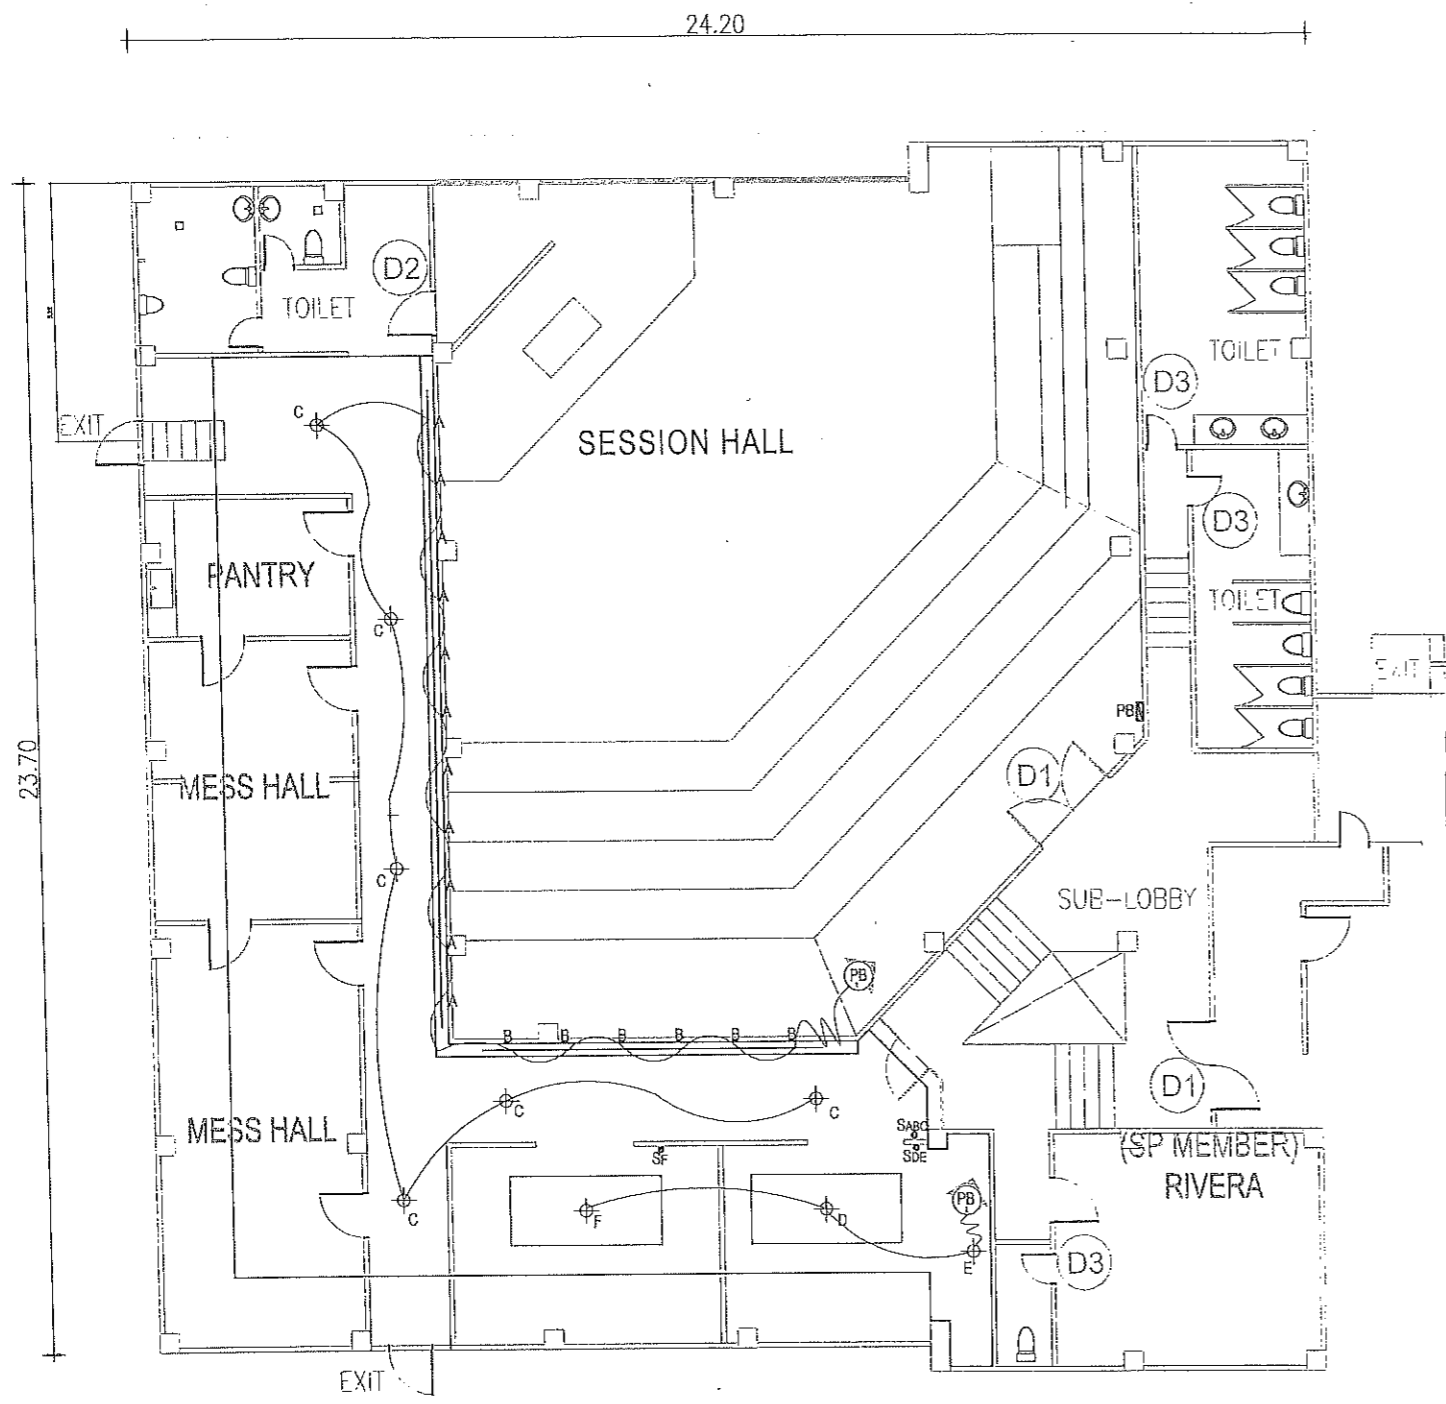

LOAD SCHEDULE :

CIRCUIT NO.	DESCRIPTION	QUANTITY	VOLTS	WATTS	AMPS	TRIP	CONDUCTOR SIZE	CONDUIT SIZE
PB 1	LIGHTING OUTLET	23	230	1,150	5.00	20 A	2- 3.5 mm ² THW Stranded Copper Wire , 1 - 2.0 mm ² THW Stranded Copper Wire	20 mm dia. uPVC
PB 2	LIGHTING OUTLET	3	230	150	0.65	20 A	2- 3.5 mm ² THW Stranded Copper Wire , 1 - 2.0 mm ² THW Stranded Copper Wire	20 mm dia. uPVC
PB 3	CONVENIENCE OUTLET	4	230	720	3.13	20 A	2- 3.5 mm ² THW Stranded Copper Wire , 1 - 2.0 mm ² THW Stranded Copper Wire	20 mm dia. uPVC
PB 4	1.5 HP ACU	1	230	2,300	10.00	40 A	2- 8.0 mm ² THW Stranded Copper Wire , 1 - 2.0 mm ² THW Stranded Copper Wire	25 mm dia. uPVC
PB 5	1.5 HP ACU	1	230	2,300	10.00	40 A	2- 8.0 mm ² THW Stranded Copper Wire , 1 - 2.0 mm ² THW Stranded Copper Wire	25 mm dia. uPVC

NOTE:
 - CONNECT TO EXISTING PANEL BOARD FOR POWER SOURCE

- LEGEND:**
- 100 FS LED DETERMINED TYPE COOL DOWN LIGHT (1170 x 1170 mm)
 - 150 LED DOWNLIGHT CEILING LIGHT (150 x 150 mm)
 - TWO GANG CONVENIENCE UNIVERSAL OUTLET
 - 10" ALL PAIN PLASTIC BRIDGE ROMNEY SWITCH COVER FULL SIZE WORK COVER COVER-GANG UNIVERSAL OUTLET
 - 1.5HP BRIST TYPE AIR CONDITIONER UNIT
 - CHECK BATTERY (CONNECT TO EXISTING PWA-REGULATOR)
 - ONE GANG SWITCH WITH PLATE, FLUSH TYPE
 - TWO GANG SWITCH WITH PLATE, FLUSH TYPE
 - THREE GANG SWITCH WITH PLATE, FLUSH TYPE

1 LOUNGE ELECTRICAL PLAN
 E-1 SCALE 1:100



REPUBLIC OF THE PHILIPPINES
PROVINCIAL ENGINEER'S OFFICE
 SAN AGUSTIN, DIGOS CITY, DAVAO DEL SUR

PROJECT TITLE:
 REPAIR /IMPROVEMENT OF SANGGUNIANG PANLALAWIGAN BUILDING
 LOCATION:
 MATTI, DIGOS CITY, DAVAO DEL SUR

PREPARED BY:

 MARY FLOR L. HECTIN
 ENGINEER I

REVIEWED BY:

 JOSEPH R. GONZALES
 ENGINEER - III
 PLANNING AND PROGRAMMING DIV. HEAD

RECOMMENDING APPROVAL:

 LEONERL MARCH P. SUARIO
 PROVINCIAL ENGINEER


APPROVED BY:

 YVONNE RONA CAGAS
 PROVINCIAL GOVERNOR

SHEET NO.:
 E-1
 22 79

E X - O F F I C I O

(@ 3RD FLOOR)

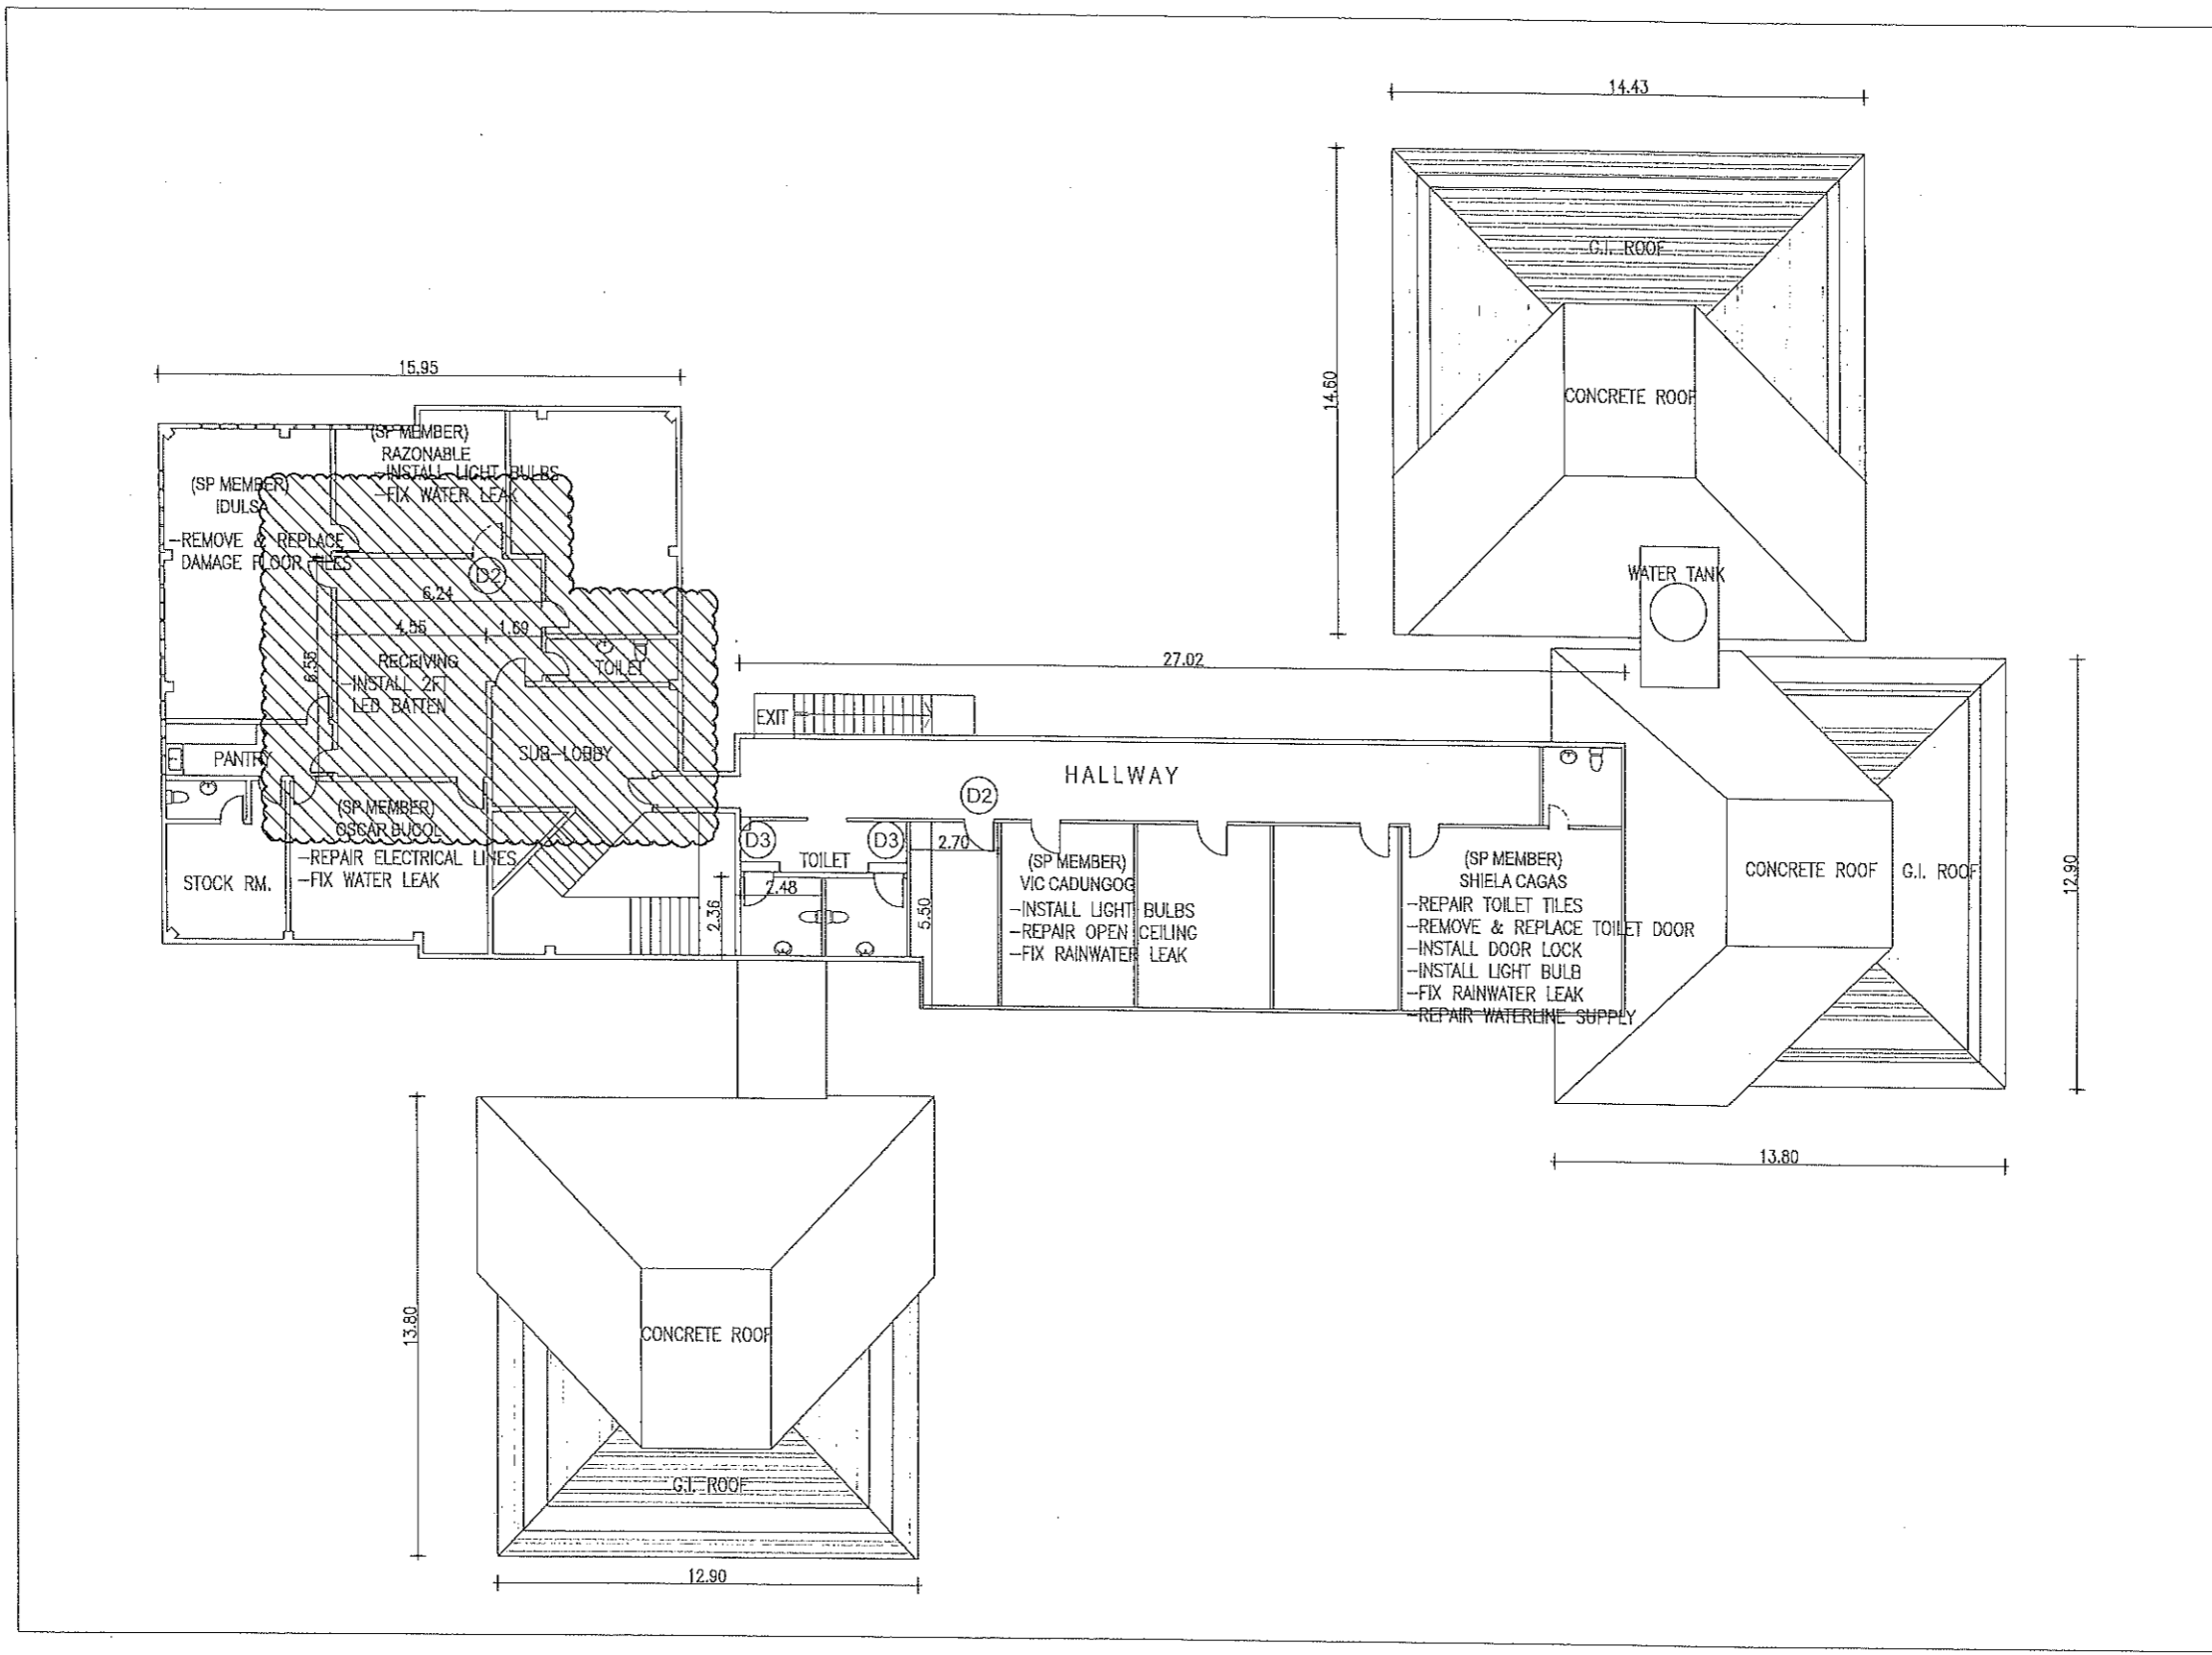

**EX-OFFICIO DETAIL
@ 3RD FLOOR**

1
A-23



REPUBLIC OF THE PHILIPPINES
PROVINCIAL ENGINEER'S OFFICE
SAN AGUSTIN, DIGOS CITY, DAVAO DEL SUR

PROJECT TITLE:
**REPAIR /IMPROVEMENT OF SANGGUNIANG
PANLALAWIGAN BUILDING**

LOCATION:
MATTI, DIGOS CITY, DAVAO DEL SUR


PREPARED BY:
[Signature]
REXIE GREY B. TABAY
ARCHITECT III

REVIEWED BY:
[Signature]
JOSEPH R. GONZALES
ENGINEER III
PLANNING AND PROGRAMMING DIV. HEAD

RECOMMENDING APPROVAL:
[Signature]
LEONERL MARCH P. SUARIO
PROVINCIAL ENGINEER

APPROVED BY:
[Signature]
YVONNE ROÑA CAGAS
PROVINCIAL GOVERNOR

SHEET NO.:
A-23
23 79

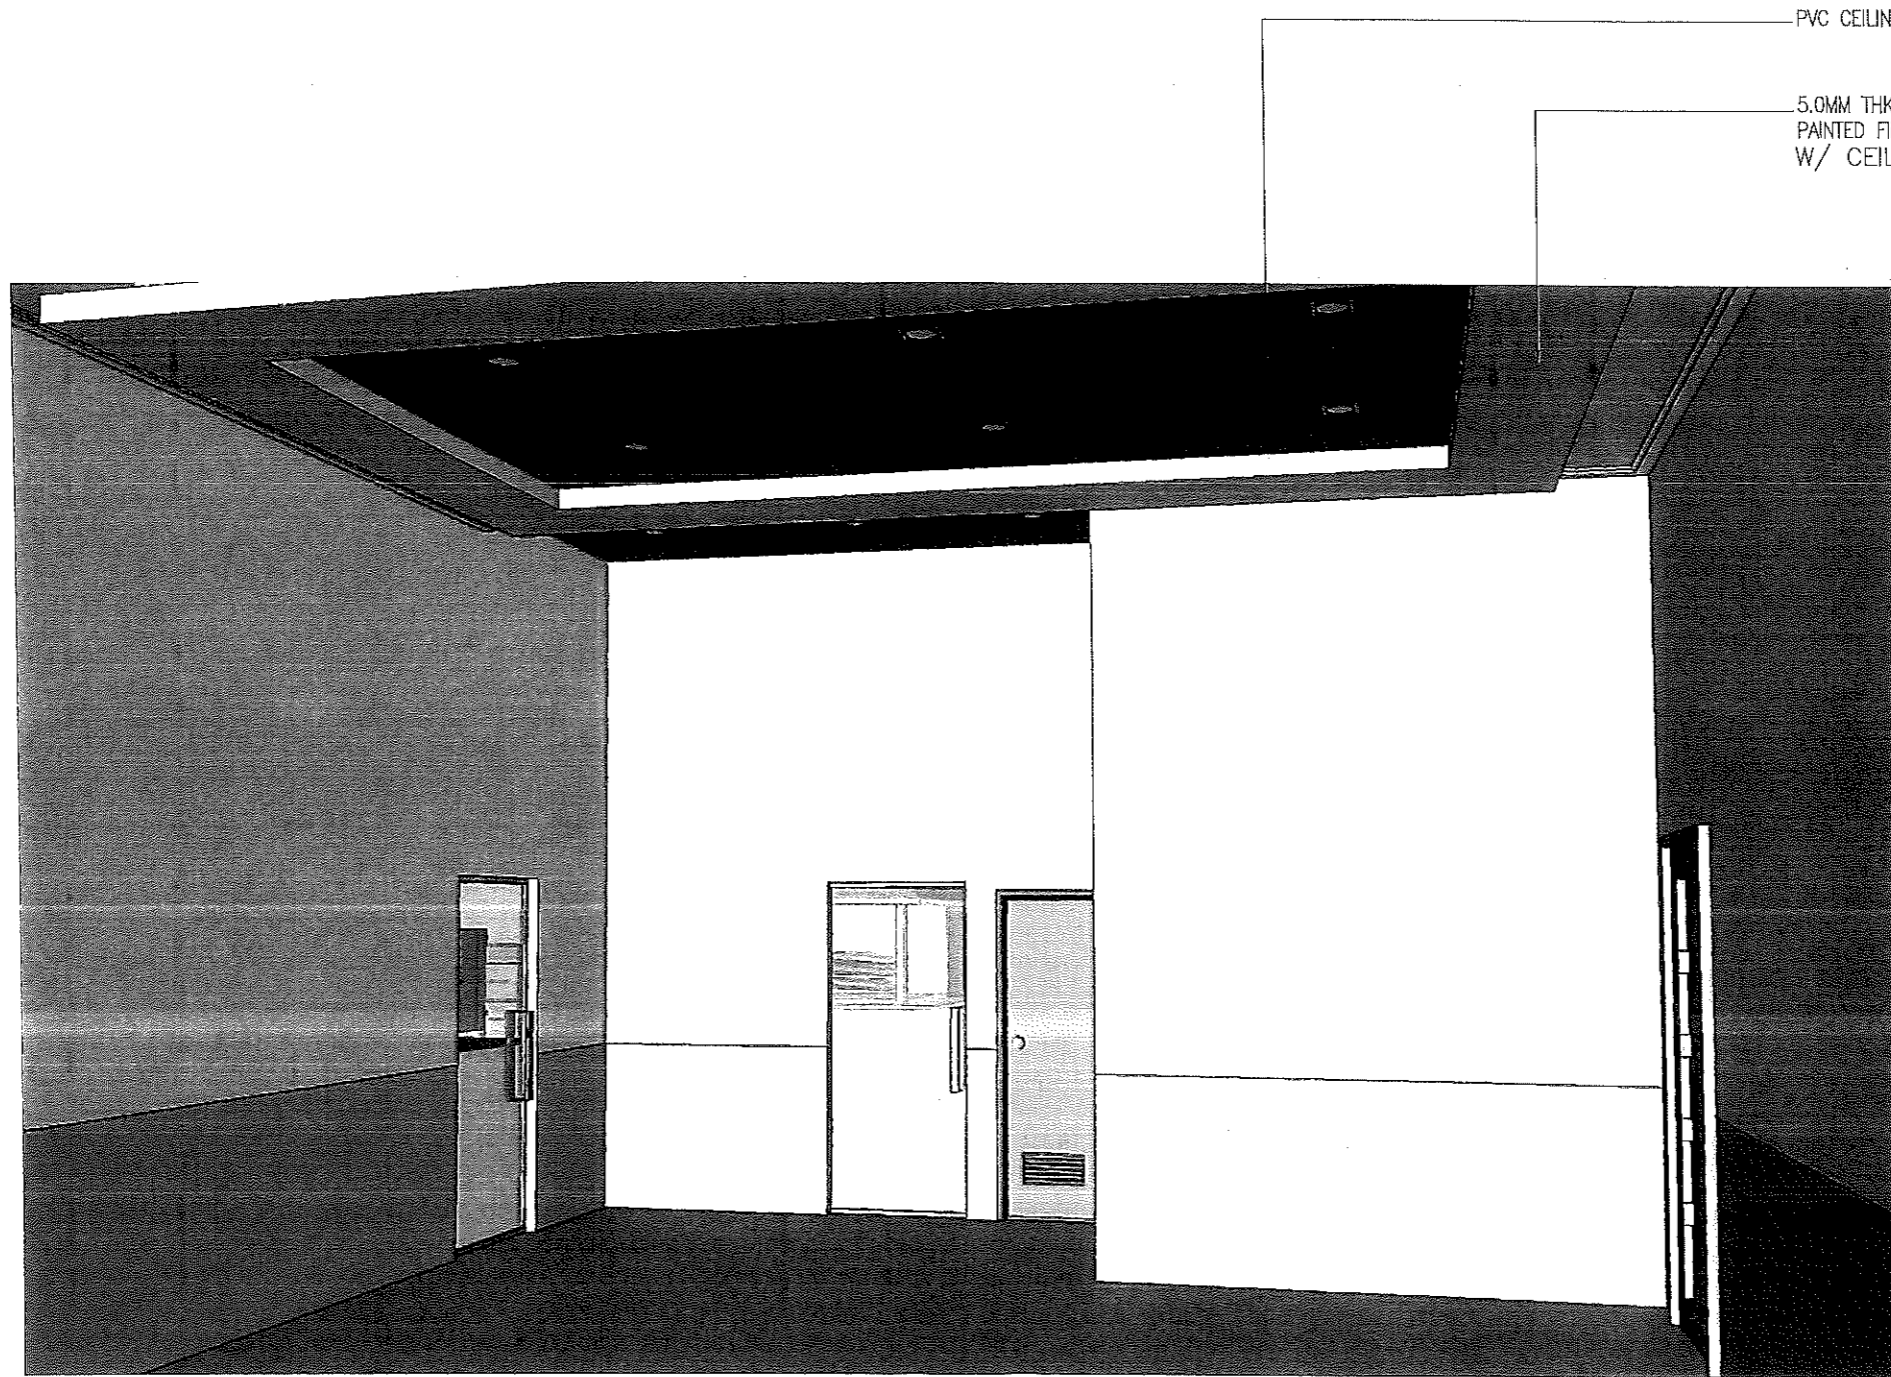

**PERSPECTIVE
RECEIVING AT EX-OFFICIO**

1
A-24



REPUBLIC OF THE PHILIPPINES
PROVINCIAL ENGINEER'S OFFICE
SAN AGUSTIN, DIGOS CITY, DAVAO DEL SUR

PROJECT TITLE:
**REPAIR /IMPROVEMENT OF SANGGUNIANG
PANLALAWIGAN BUILDING**

LOCATION:
MATTI, DIGOS CITY, DAVAO DEL SUR


PREPARED BY:
[Signature]
REXIE GREY B. TABAY
ARCHITECT III

REVIEWED BY:
[Signature]
JOSEPH R. GONZALES
ENGINEER - II
PLANNING AND PROGRAMMING DIV. HEAD


 
 

 
RECOMMENDING APPROVAL:
[Signature]
LEONERL MARCH P. SUARIO
PROVINCIAL ENGINEER


APPROVED BY:
[Signature]
YVONNE ROSA CAGAS
PROVINCIAL GOVERNOR

SHEET NO.:
A-24
24 79

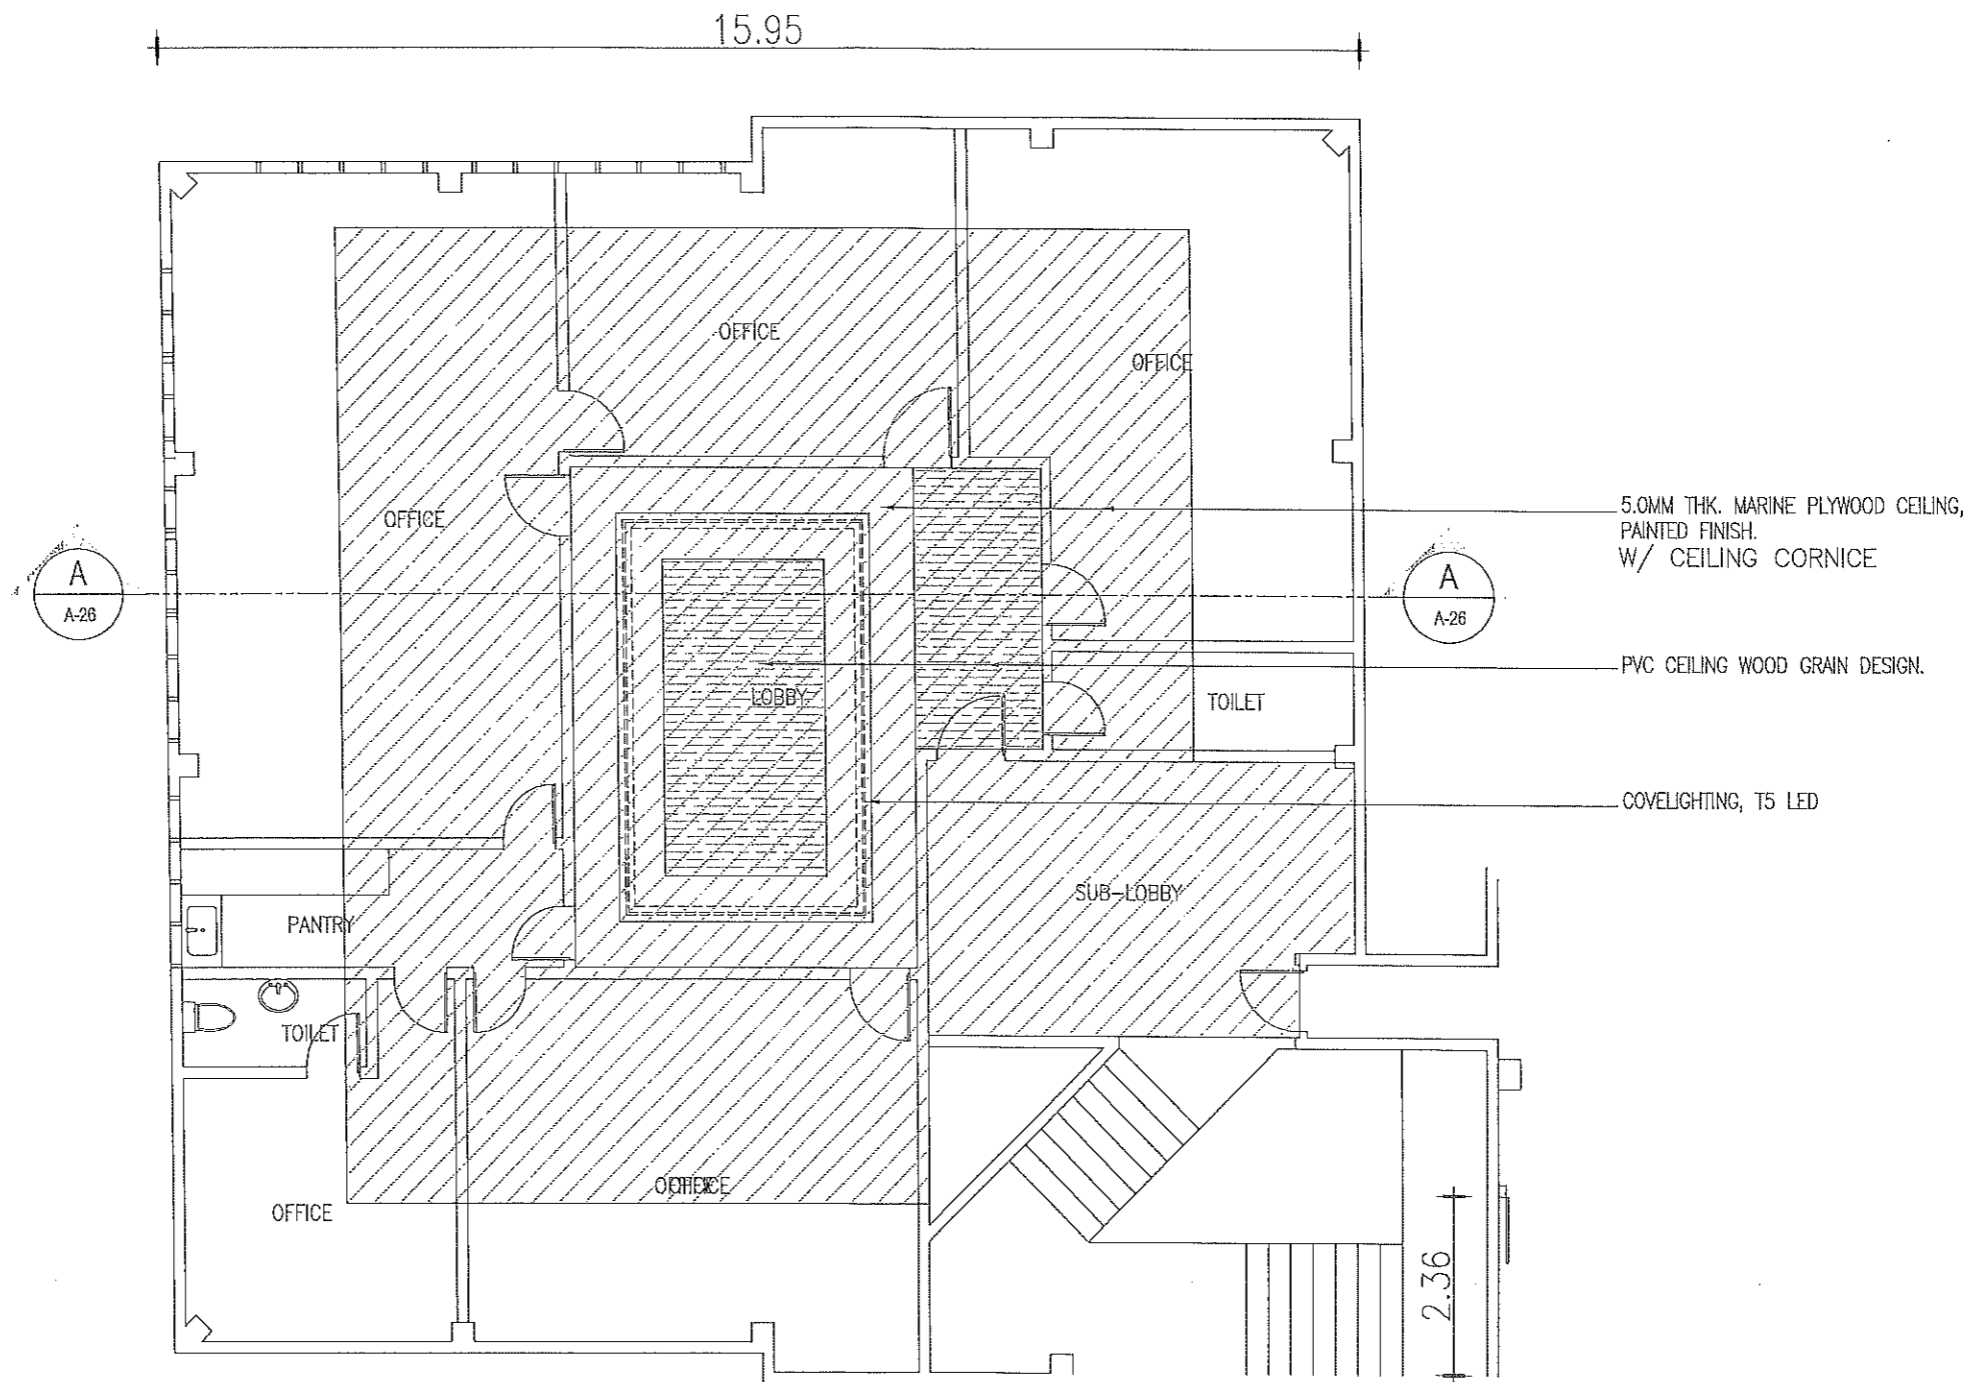

1 CEILING PLAN
 A-25 SCALE 1:50

 <p>REPUBLIC OF THE PHILIPPINES PROVINCIAL ENGINEER'S OFFICE SAN AGUSTIN, DIGOS CITY, DAVAO DEL SUR</p>	PROJECT TITLE: REPAIR /IMPROVEMENT OF SANGGUNIANG PANLALAWIGAN BUILDING	PREPARED BY:  REXIE BREY B. TABAY ARCHITECT III	REVIEWED BY:  JOSEPH R. GONZALES ENGINEER - III PLANNING AND PROGRAMMING DIV. HEAD	RECOMMENDING APPROVAL:  LEONERL MARCH P. SUARIO PROVINCIAL ENGINEER	APPROVED BY:  YVONNE RONA CAGAS PROVINCIAL GOVERNOR	SHEET NO.: A-25 25 79
	LOCATION: MATTI, DIGOS CITY, DAVAO DEL SUR					

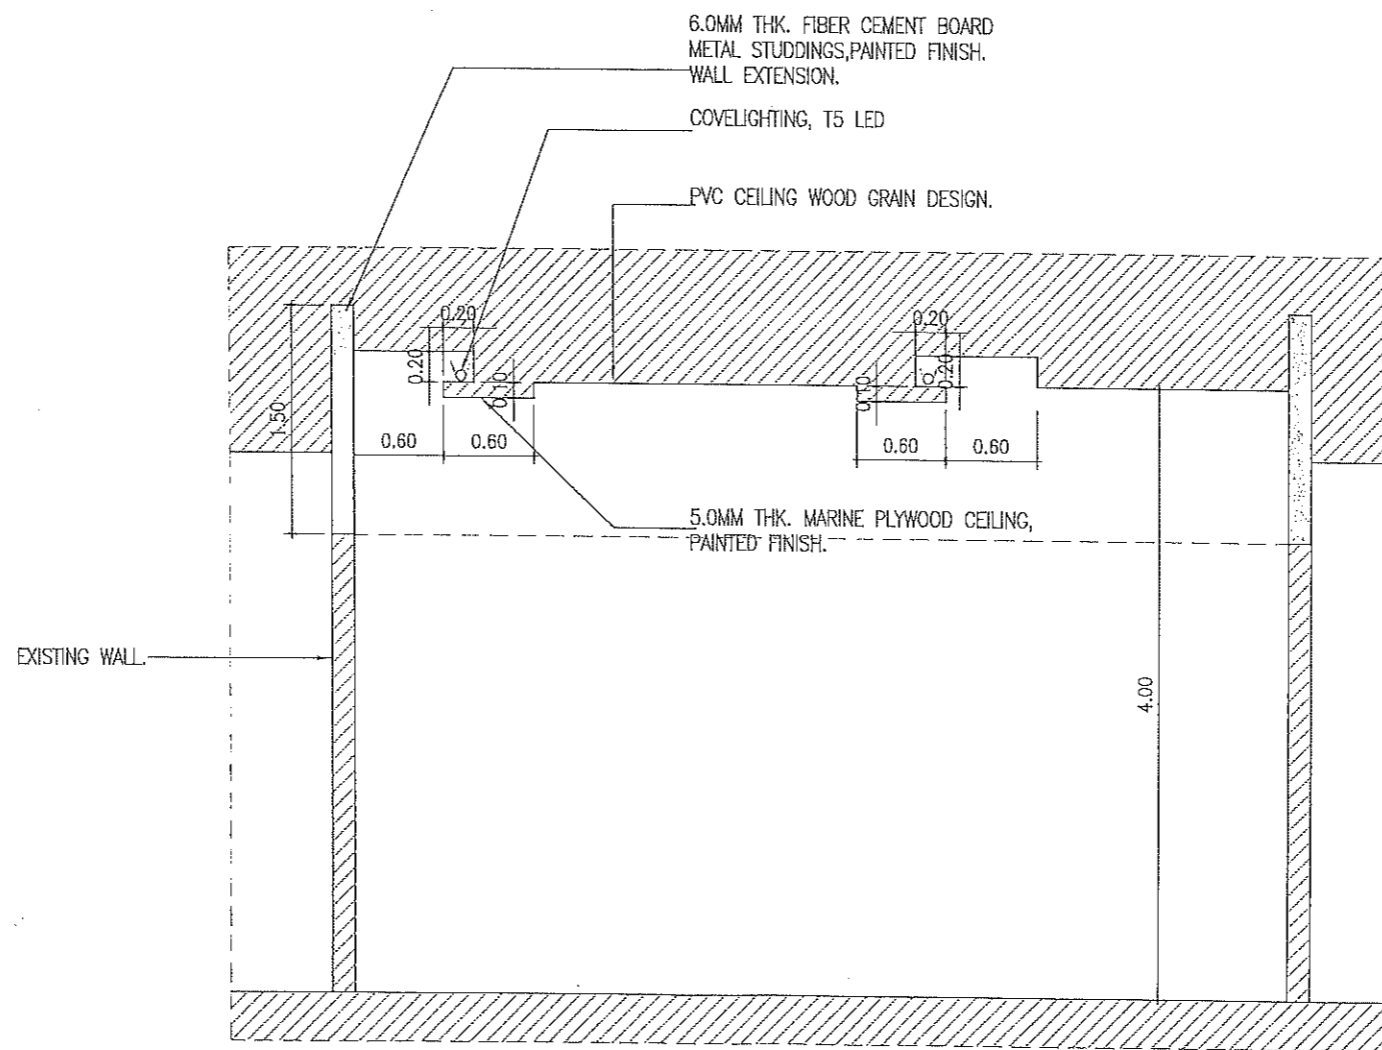


1 SECTION 'A'
A-26 SCALE 1:50



REPUBLIC OF THE PHILIPPINES
PROVINCIAL ENGINEER'S OFFICE
 SAN AGUSTIN, DIGOS CITY, DAVAO DEL SUR

PROJECT TITLE: REPAIR /IMPROVEMENT OF SANGGUNIANG PANLALAWIGAN BUILDING	PREPARED BY: <i>[Signature]</i> REXIE GREY B. TABAY ARCHITECT III	REVIEWED BY: <i>[Signature]</i> JOSEPH R. GONZALES ENGINEER - II PLANNING AND PROGRAMMING DIV. HEAD	RECOMMENDING APPROVAL: <i>[Signature]</i> LEONERL MARCH P. SUARIO PROVINCIAL ENGINEER	APPROVED BY: <i>[Signature]</i> YVONNE ROÑA CAGAS PROVINCIAL GOVERNOR	SHEET NO.: A-26 26 79
LOCATION: MATTI, DIGOS CITY, DAVAO DEL SUR					

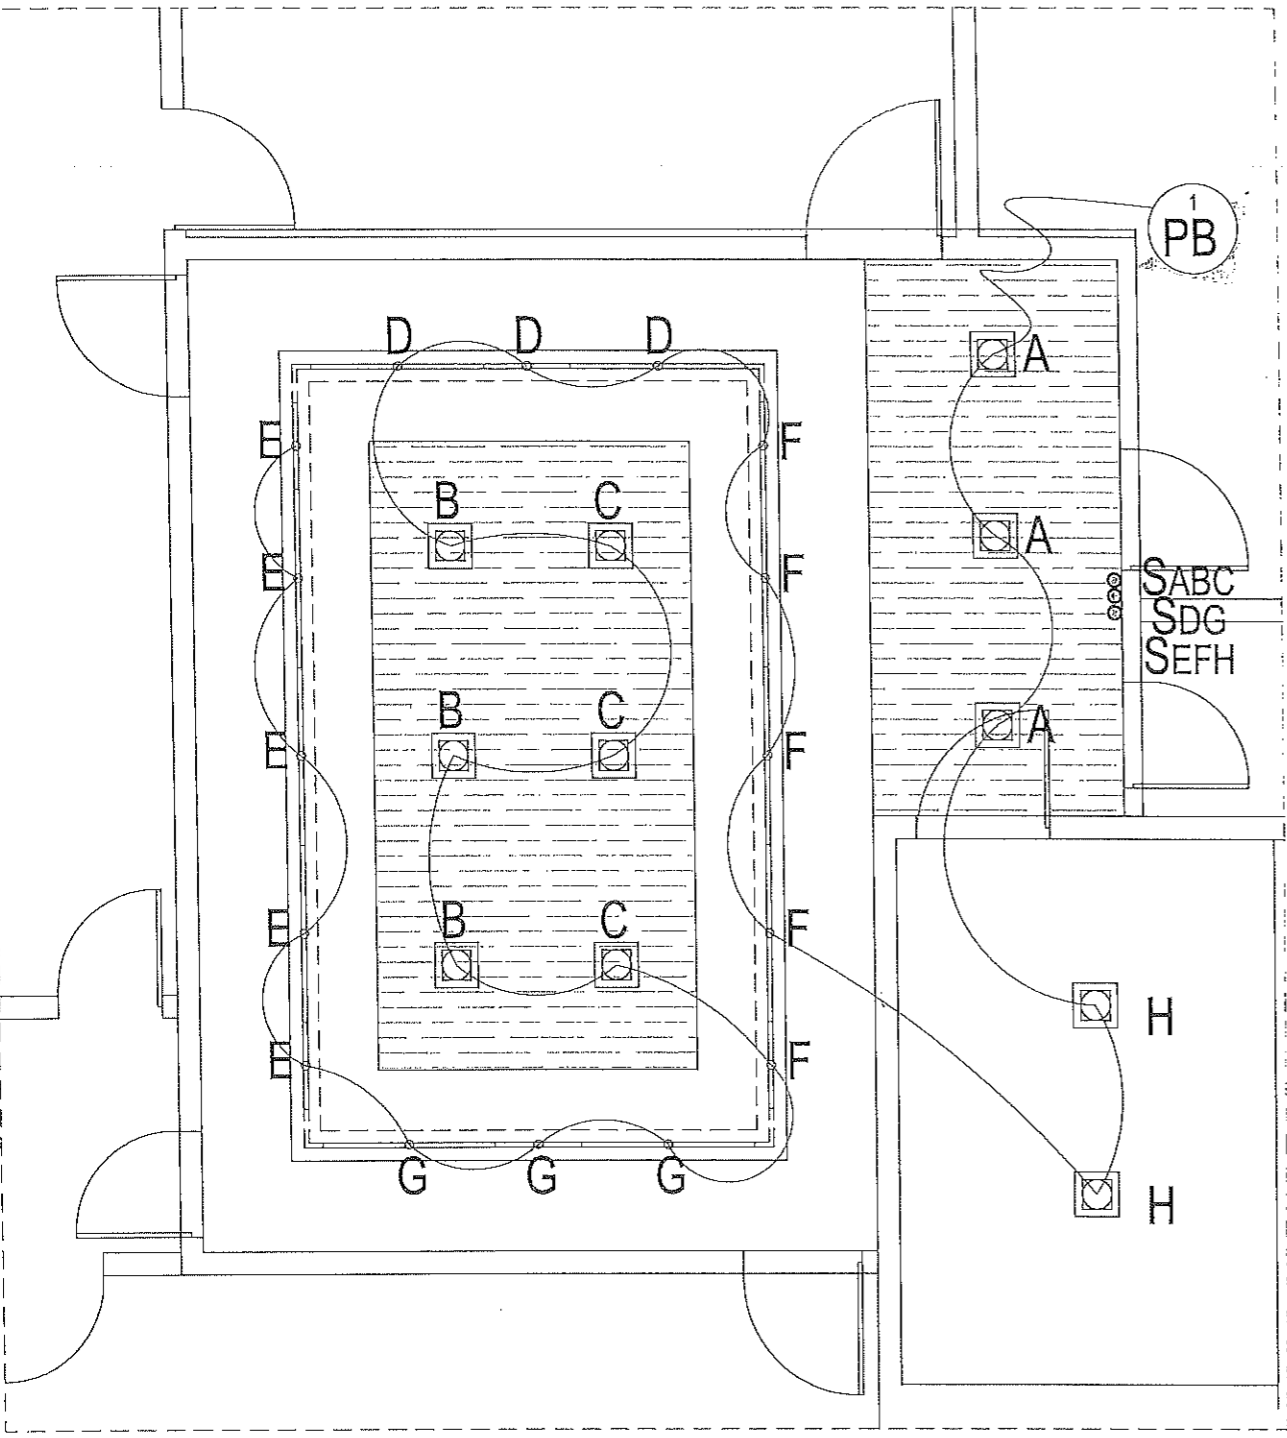

LOAD SCHEDULE :

CIRCUIT NO.	DESCRIPTION	QUANTITY	VOLTS	WATTS	AMPS	TRIP	CONDUCTOR SIZE	CONDUIT SIZE
PB 1	LIGHTING OUTLET	27	230	1,350	5.87	20 A	2- 3.5 mm ² THW Stranded Copper Wire ; 1 - 2.0 mm ² THW Stranded Copper Wire	20 mm dia. uPVC

NOTE:
 - CONNECT TO EXISTING PANEL BOARD FOR POWER SOURCE


LEGEND:

- 16W T5 LED INTEGRATED TUBE, WARM WHITE (1173 x 24 x 32 mm)
- 6W LED PINLIGHT DOWNLIGHT RECESS TYPE E27 STANDARD SOCKET, WHITE SQUARE, COOL DAYLIGHT (16 x 15 cm)
- 8W T5 LED INTEGRATED TUBE, WARM WHITE (573x 24 x 32 mm)
- CIRCUIT HOMERUN (CONNECT TO EXISTING PANELBOARD)
- TWO-GANG SWITCH WITH PLATE, FLUSH TYPE
- THREE-GANG SWITCH WITH PLATE, FLUSH TYPE


1 EX - OFFICIO LIGHTING LAYOUT
 E-1 SCALE 1:50

<p>REPUBLIC OF THE PHILIPPINES PROVINCIAL ENGINEER'S OFFICE SAN AGUSTIN, DIGOS CITY, DAVAO DEL SUR</p>	PROJECT TITLE:	PREPARED BY:	REVIEWED BY:	RECOMMENDING APPROVAL:	APPROVED BY:	SHEET NO.:
	REPAIR /IMPROVEMENT OF SANGGUNIANG PANLALAWIGAN BUILDING LOCATION: MATTI, DIGOS CITY, DAVAO DEL SUR	MARY FLOR L. HECTIN ENGINEER I	JOSEPH R. GONZALES ENGINEER, III PLANNING AND PROGRAMMING DIV. HEAD	LEONERL MARCH P. SUARIO PROVINCIAL ENGINEER	YVONNE RONA CAGAS PROVINCIAL GOVERNOR	E-1 27 79

TOILET - 1
MALE TOILET
(@ 1ST FLOOR)

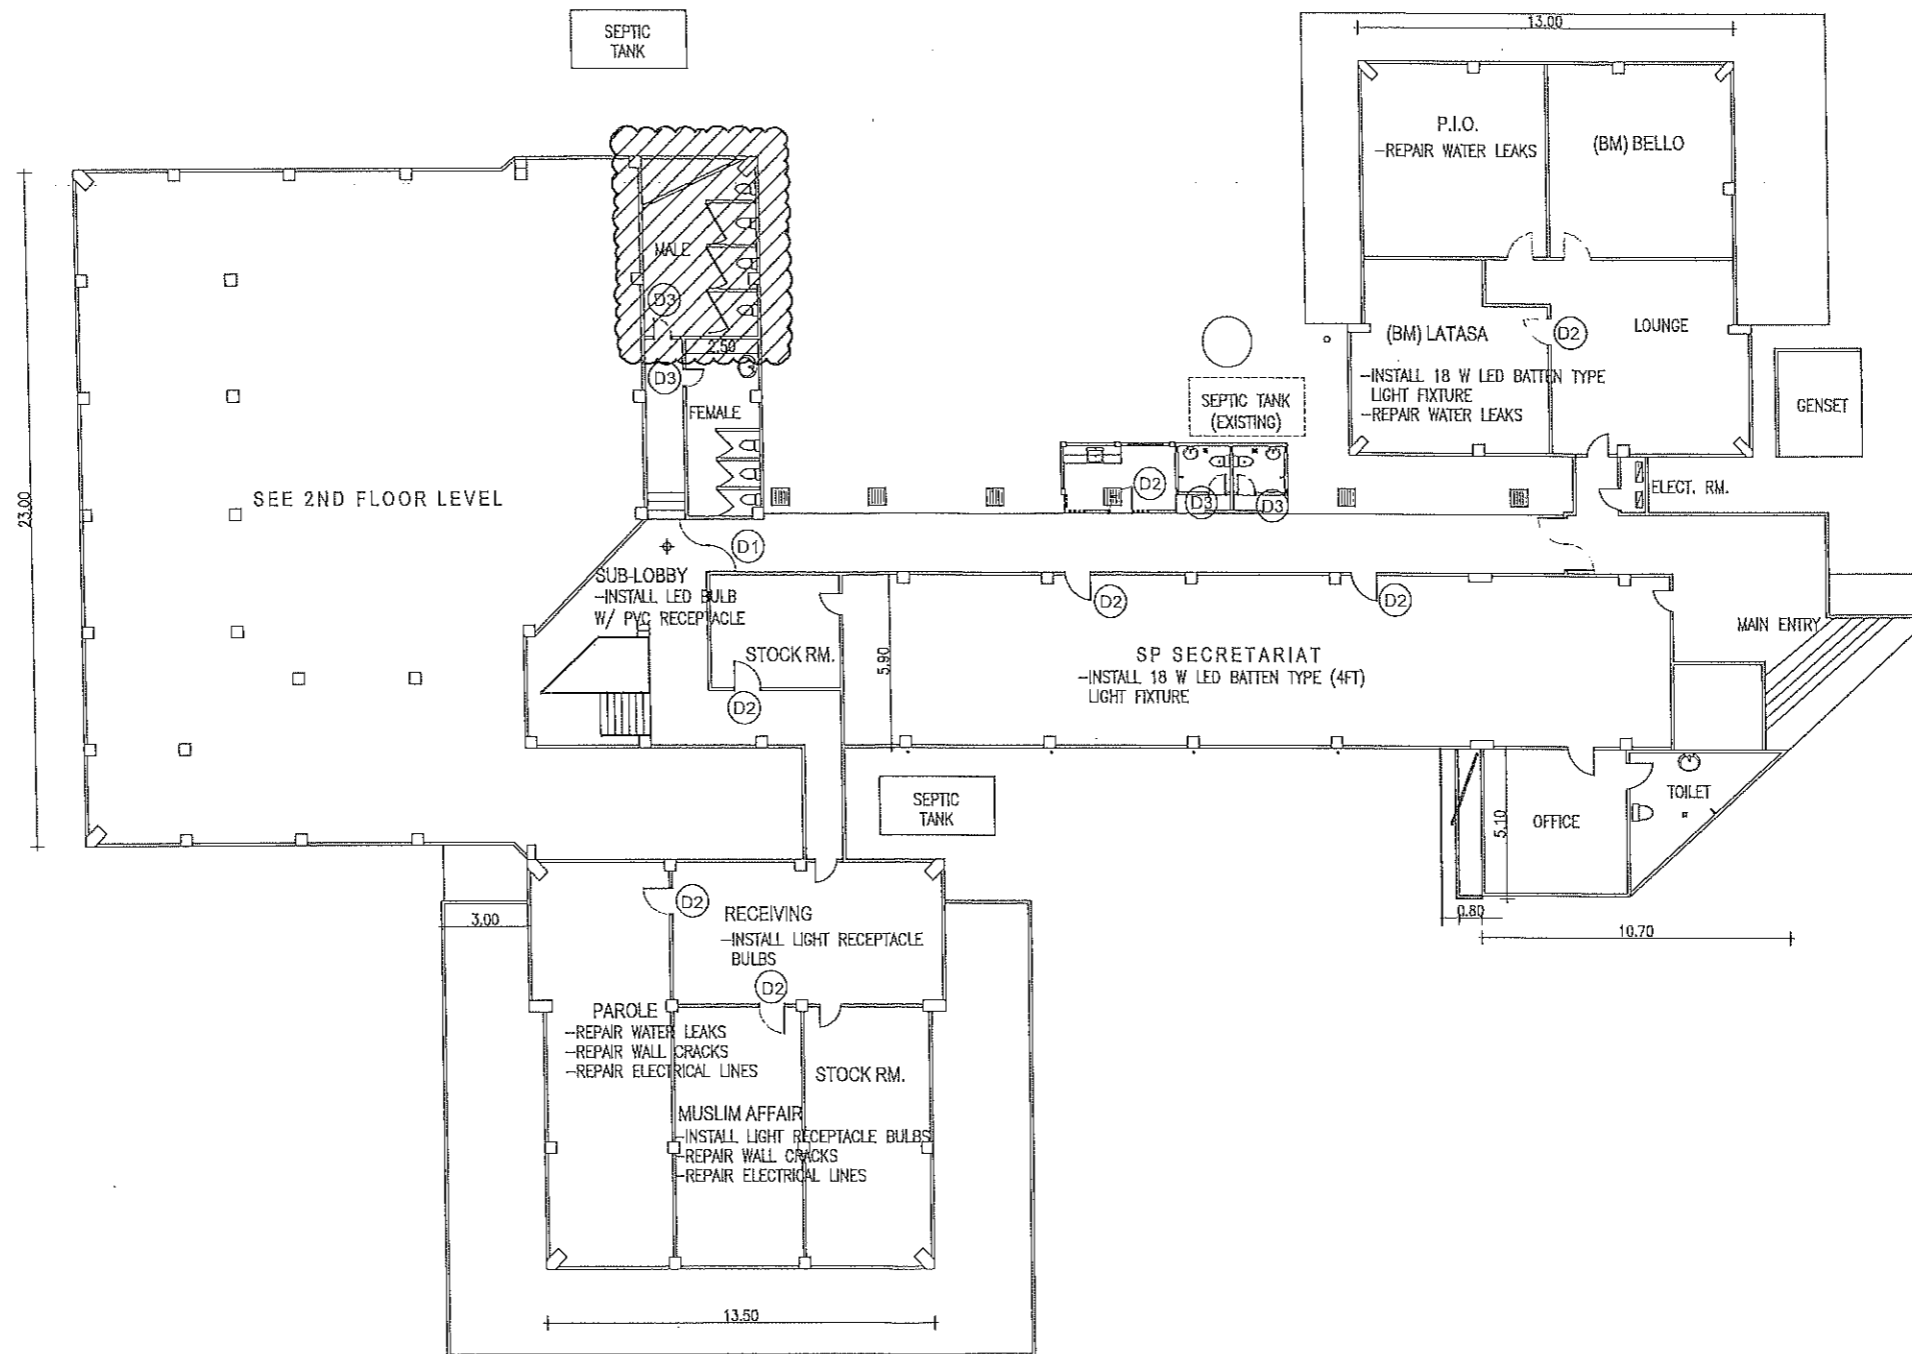


1
**TOILET-1
MALE TOILET (1ST FLOOR)**

 <p>REPUBLIC OF THE PHILIPPINES PROVINCIAL ENGINEER'S OFFICE SAN AGUSTIN, DIGOS CITY, DAVAO DEL SUR</p>	PROJECT TITLE:	PREPARED BY:	REVIEWED BY:	RECOMMENDING APPROVAL:	APPROVED BY:	SHEET NO.:
	REPAIR /IMPROVEMENT OF SANGGUNIANG PANLALAWIGAN BUILDING	<i>Rexie Grey B. Tabay</i> REXIE GREY B. TABAY ARCHITECT III	<i>Joseph R. Gonzales</i> JOSEPH R. GONZALES ENGINEER - III PLANNING AND PROGRAMMING DIV. HEAD	<i>Leonerl March P. Suarion</i> LEONERL MARCH P. SUARION PROVINCIAL ENGINEER	<i>Yvonne Roma Cagas</i> YVONNE ROMA CAGAS PROVINCIAL GOVERNOR	A-28
	LOCATION:	MATTI, DIGOS CITY, DAVAO DEL SUR				28 79

T5 LED COVELIGHT

30MMX60MM SYNTHETIC GRANITE
TILES GLAZED
(SUBJECT TO ARCHITECT'S APPROVAL)

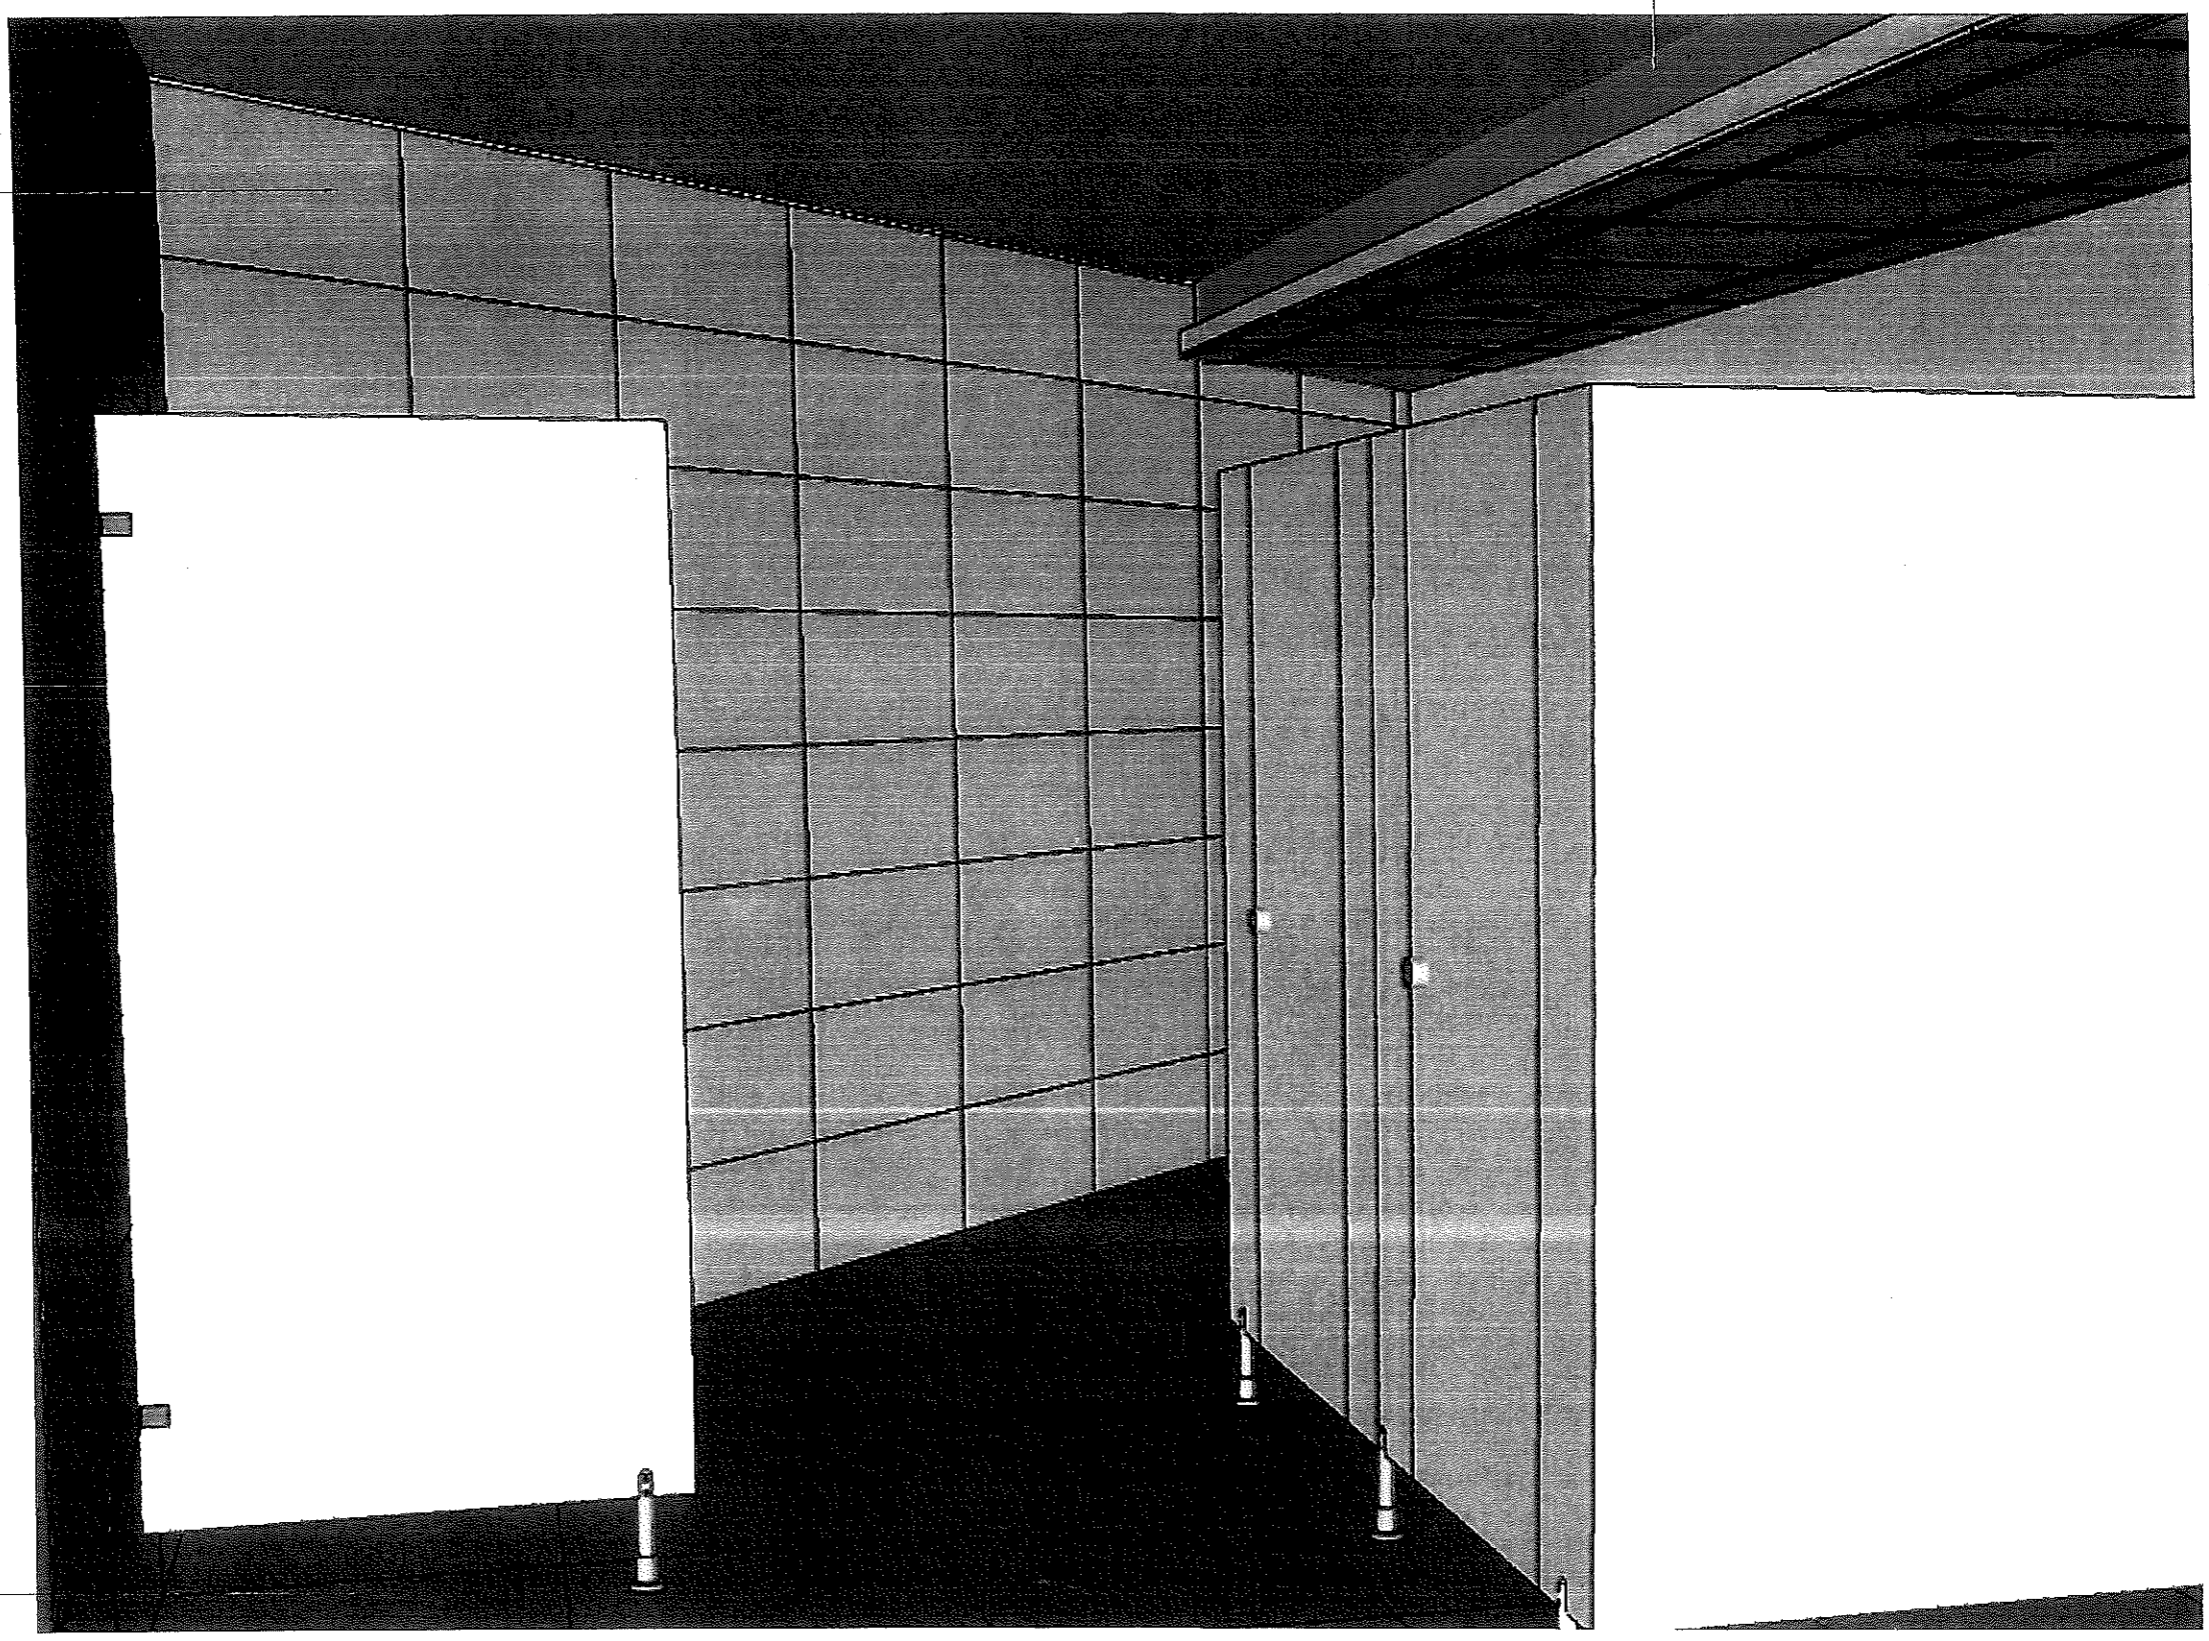

60MMX60MM SYNTHETIC GRANITE
TILES UNGLAZED
(SUBJECT TO ARCHITECT'S APPROVAL)

**PERSPECTIVE
TOILET-1 (1ST FLOOR)**

1
A-29



REPUBLIC OF THE PHILIPPINES
PROVINCIAL ENGINEER'S OFFICE
SAN AGUSTIN, DIGOS CITY, DAVAO DEL SUR

PROJECT TITLE:
REPAIR /IMPROVEMENT OF SANGGUNIANG
PANLALAWIGAN BUILDING

LOCATION:
MATTI, DIGOS CITY, DAVAO DEL SUR

PREPARED BY:
[Signature]
REXIE GREY B. TABAY
ARCHITECT III

REVIEWED BY:
[Signature]
JOSEPH R. GONZALES
ENGINEER - III
PLANNING AND PROGRAMMING DIV. HEAD

RECOMMENDING APPROVAL:
[Signature]
LEONERL MARCH P. SUARIO
PROVINCIAL ENGINEER

APPROVED BY:
[Signature]
YVONNE ROSA CAGAS
PROVINCIAL GOVERNOR

SHEET NO.:
A-29
29 79

SCOPE OF WORKS :


- DEMOLISH CONCRETE CUBICLE WALL
- REMOVE FLOOR AND WALL TILES
- REPAINT WALLS
- INSTALL CEILING
- INSTALL CONCRETE LAVATORY COUNTER
- INSTALL PHENOLIC BOARD CUBICLE PARTITIONS W/ COMPLETE FITTINGS & ACCESSORIES
- INSTALL LAVATORY, MIRROR, URINAL, AND WATER CLOSET WITH BIDET
- INSTALL TOILET PAPER HOLDER (STAINLESS STEEL)
- INSTALL EXHAUST FAN
- INSTALL PANEL DOOR (0.80M WIDTH)
- INSTALL 60MMx60MM SYNTHETIC GRANITE TILES

TOILET FIXTURES SPECIFICATIONS :

- | | |
|---------------------|---|
| WATER CLOSET | -1.6GPF WATER CLOSET, LEVER TYPE FLUSH. |
| LAVATORY | -COUNTERTOP CERAMIC LAVATORY (SEE DETAIL) |
| LAVATORY FAUCET | 304 STAINLESS STEEL FAUCET |
| SINK FAUCET | -304 STAINLESS STEEL GOOSENECK FAUCET |
| WALL FAUCET | -304 STAINLESS STEEL WALL FAUCET |
| BIDET | -304 STAINLESS BIDET |
| TOILET PAPER HOLDER | -304 STAINLESS TOILET PAPER HOLDER |
| URINAL | -WATERLESS WALL MOUNTED URINAL |
| TOILET MIRROR | -6.0MM THK TOILET MIRROR |

NOTE :

ALL FINISHING MATERIALS AND ITEMS TO BE USED SHALL BE IN ACCORDANCE TO SPECIFICATIONS AND SUBJECT TO THE APPROVAL OF ARCHITECT PRIOR INSTALLATION.

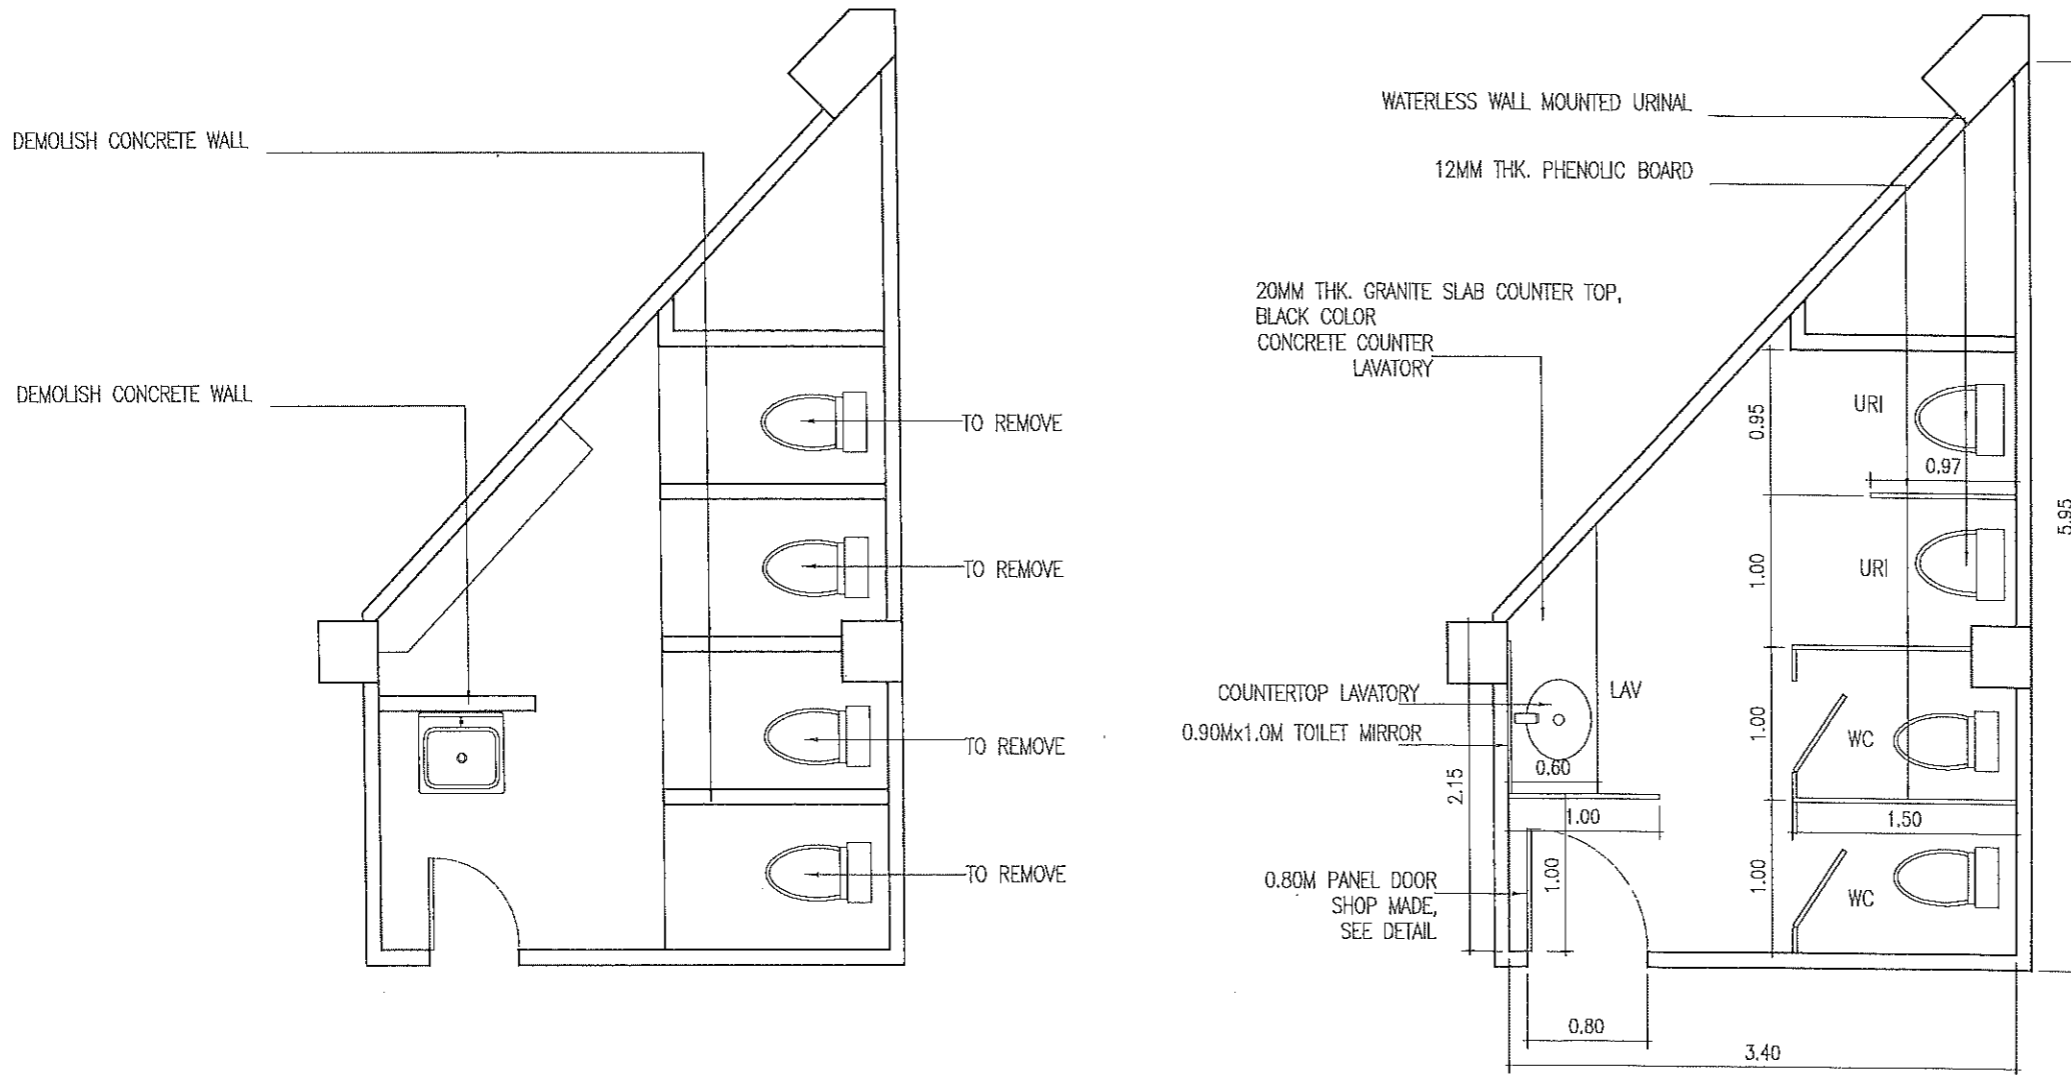

1 EXISTING FLOOR
A-30 SCALE 1:50

1 PROPOSED FLOOR PLAN
A-30 SCALE 1:50



REPUBLIC OF THE PHILIPPINES
PROVINCIAL ENGINEER'S OFFICE
SAN AGUSTIN, DIGOS CITY, DAVAO DEL SUR

PROJECT TITLE:
REPAIR /IMPROVEMENT OF SANGGUNIANG
PANLALAWIGAN BUILDING
LOCATION:
MATTI, DIGOS CITY, DAVAO DEL SUR

PREPARED BY:
REXIE GREY B. TABAY
ARCHITECT III

REVIEWED BY:
JOSEPH R. GONZALES
ENGINEER - II
PLANNING AND PROGRAMMING DIV. HEAD


RECOMMENDING APPROVAL:
LEONERL MARCH P. SUARIO
PROVINCIAL ENGINEER

APPROVED BY:
YVONNE ROÑA CAGAS
PROVINCIAL GOVERNOR

SHEET NO.:
A-30
30 79

60MMx60MM SYNTHETIC
GRANITE FLOOR TILES (NON-SKID)
(SUBJECT TO ARCHITECT'S APPROVAL)

30MMx60MM SYNTHETIC
GRANITE WALL TILES (GLAZED)
(SUBJECT TO ARCHITECT'S APPROVAL)

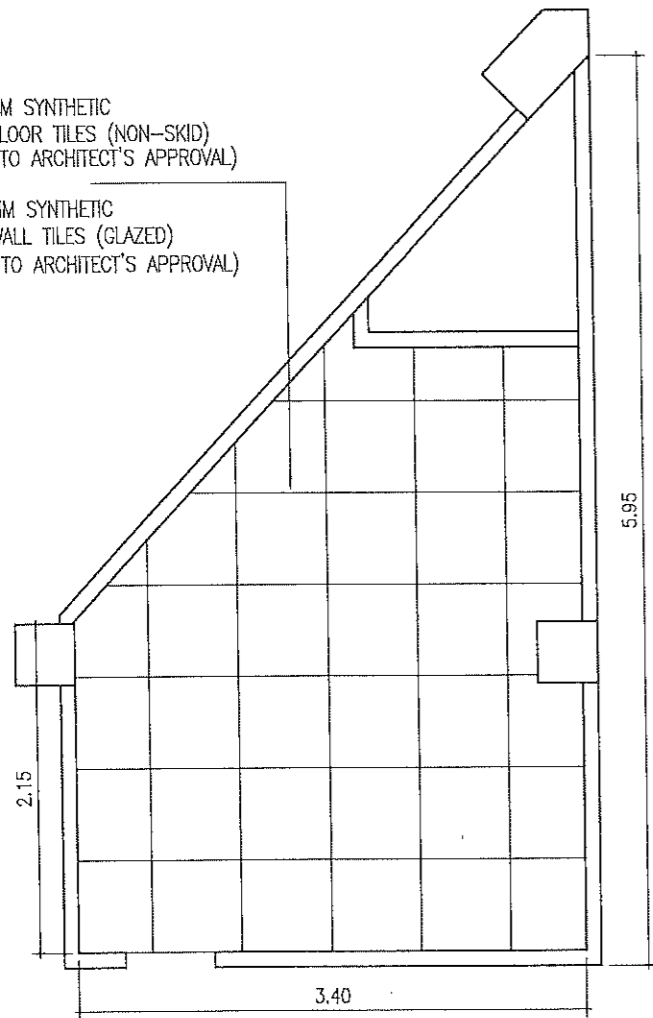


1 FLOOR TILE LAYOUT
SCALE 1:50

600MMx600MM GYPSUM
BOARD CEILING TILES


T5 LED COVELIGHT
5.0MM THK. MARINE
PLYWOOD CEILING
ON METAL FURRING
W/ CEILING CORNICE

PINLIGHT, REFER TO
ELECTRICAL

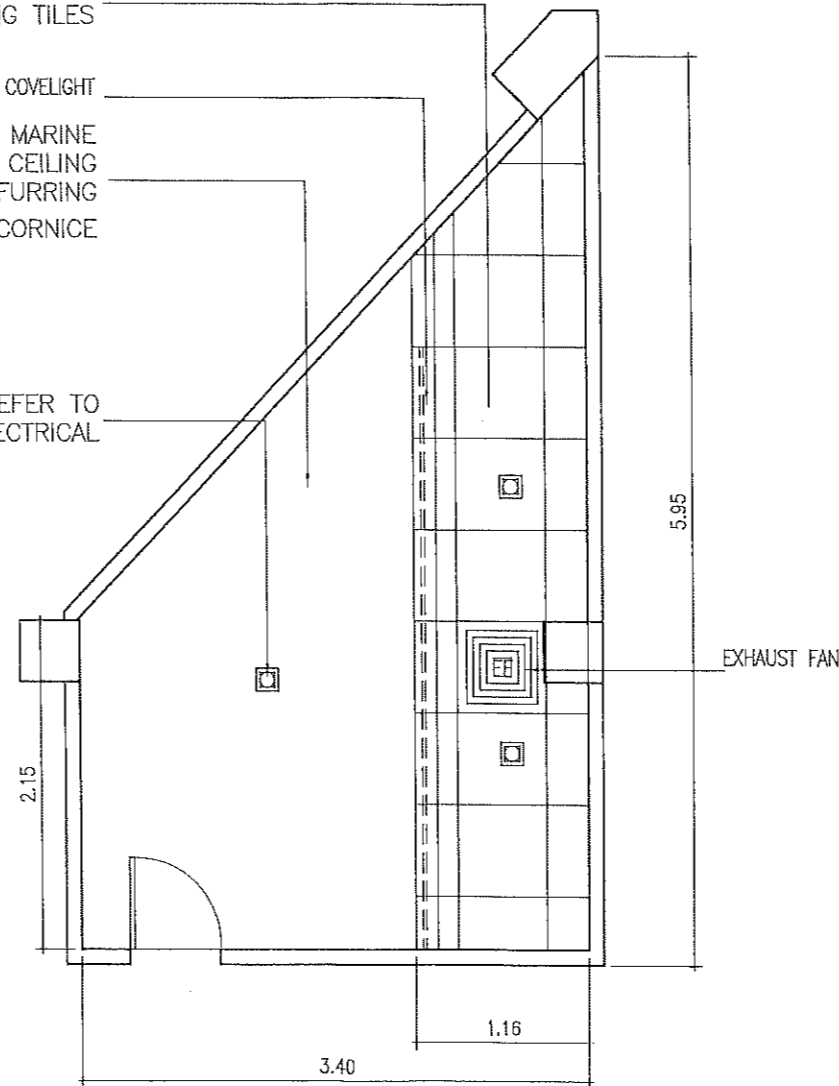

2 CEILING PLAN
SCALE 1:50

12MM THK. PHENOLIC BOARD
PAINTED FINISH.

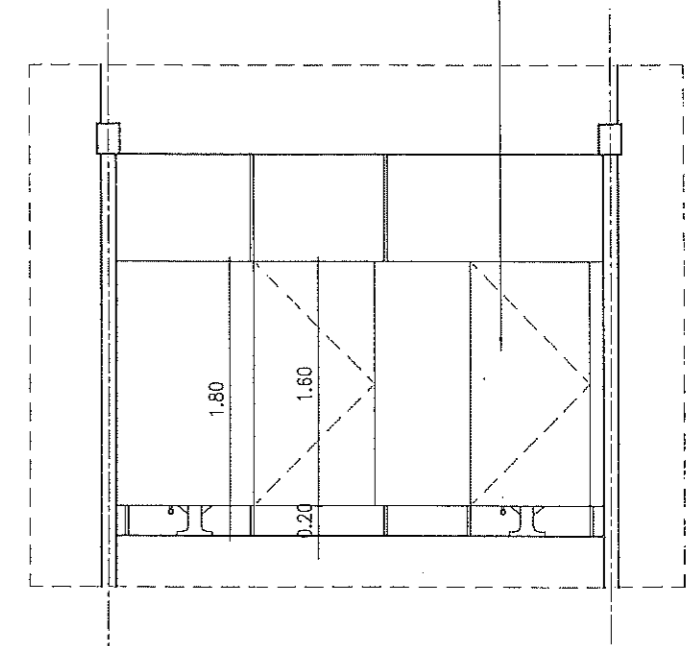

3 TYPICAL CUBICLE DET.
SCALE 1:50



REPUBLIC OF THE PHILIPPINES
PROVINCIAL ENGINEER'S OFFICE
SAN AGUSTIN, DIGOS CITY, DAVAO DEL SUR

PROJECT TITLE:
REPAIR /IMPROVEMENT OF SANGGUNIANG
PANLALAWIGAN BUILDING

LOCATION:
MATTI, DIGOS CITY, DAVAO DEL SUR


PREPARED BY:
[Signature]
REXIE GREY B. TABAY
ARCHITECT III

REVIEWED BY:
[Signature]
JOSEPH R. GONZALES
ENGINEER - IN
PLANNING AND PROGRAMMING DIV. HEAD

RECOMMENDING APPROVAL:
[Signature]
LEONERL MARCH P. SUARIO
PROVINCIAL ENGINEER


APPROVED BY:
[Signature]
YVONNE ROÑA CAGAS
PROVINCIAL GOVERNOR

SHEET NO.:
A-31
31 79

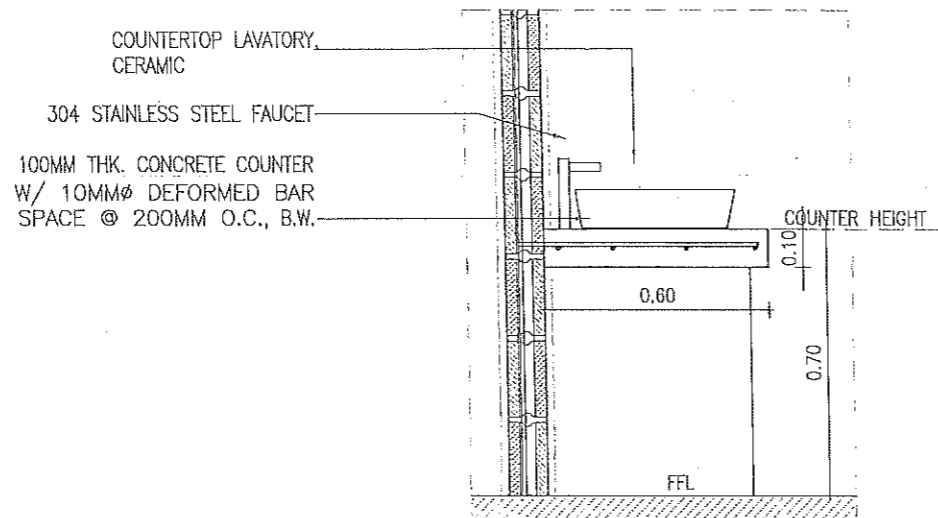


1 TYPICAL CONCRETE COUNTER DET.
A-32 SCALE 1:20M.

CERAMIC WATER CLOSET
(HCG, PHILIPPINE STANDARD,
AMERICAN STANDARD OR ITS EQUIVALENT)
(BY ARCHITECT'S APPROVAL)

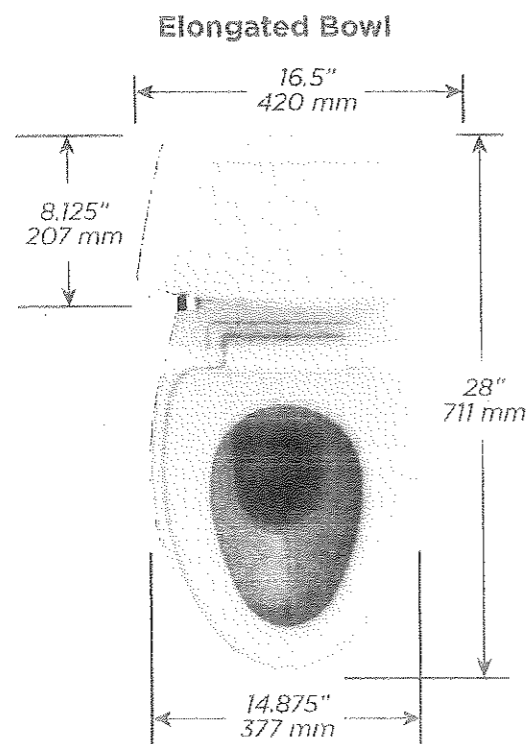

2 TYPICAL WATER CLOSET DET.
A-32

COUNTERTOP CERAMIC LAVATORY
(HCG, PHILIPPINE STANDARD,
AMERICAN STANDARD OR ITS EQUIVALENT)
(SUBJECT TO ARCHITECT'S APPROVAL)

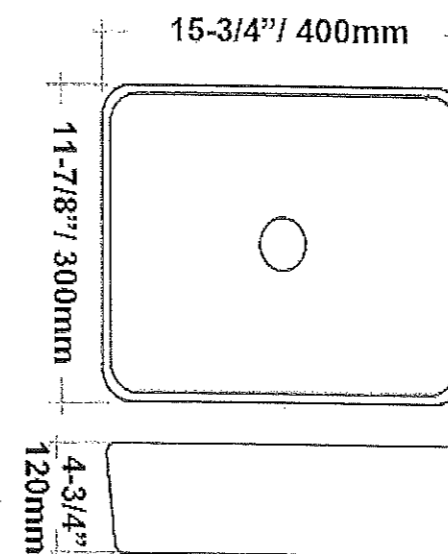

3 COUNTERTOP TYPICAL LAVATORY DETAIL
A-32



REPUBLIC OF THE PHILIPPINES
PROVINCIAL ENGINEER'S OFFICE
SAN AGUSTIN, DIGOS CITY, DAVAO DEL SUR

PROJECT TITLE:
REPAIR /IMPROVEMENT OF SANGGUNIANG
PANLALAWIGAN BUILDING
LOCATION:
MATTI, DIGOS CITY, DAVAO DEL SUR


PREPARED BY:
[Signature]
REXIE GREY B. TABAY
ARCHITECT III

REVIEWED BY:
[Signature]
JOSEPH R. GONZALES
ENGINEER - III
PLANNING AND PROGRAMMING DIV. HEAD

RECOMMENDING APPROVAL:
[Signature]
LEONERL MARCH P. SUARIO
PROVINCIAL ENGINEER


APPROVED BY:
[Signature]
YVONNE ROSA CAGAS
PROVINCIAL GOVERNOR

SHEET NO.:
A-32
32 79

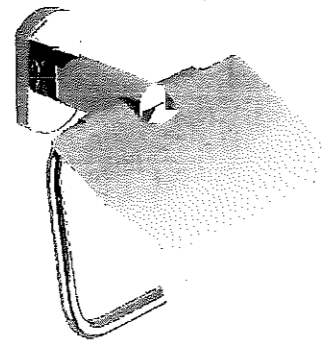


1 TOILET PAPER HOLDER-TYPICAL
A-33

304 STAINLESS STEEL FAUCET
(SUBJECT TO ARCHITECT'S APPROVAL)

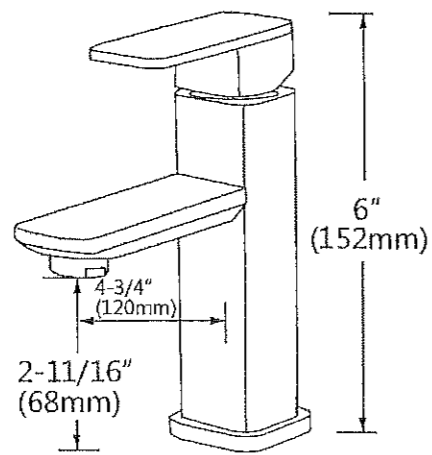


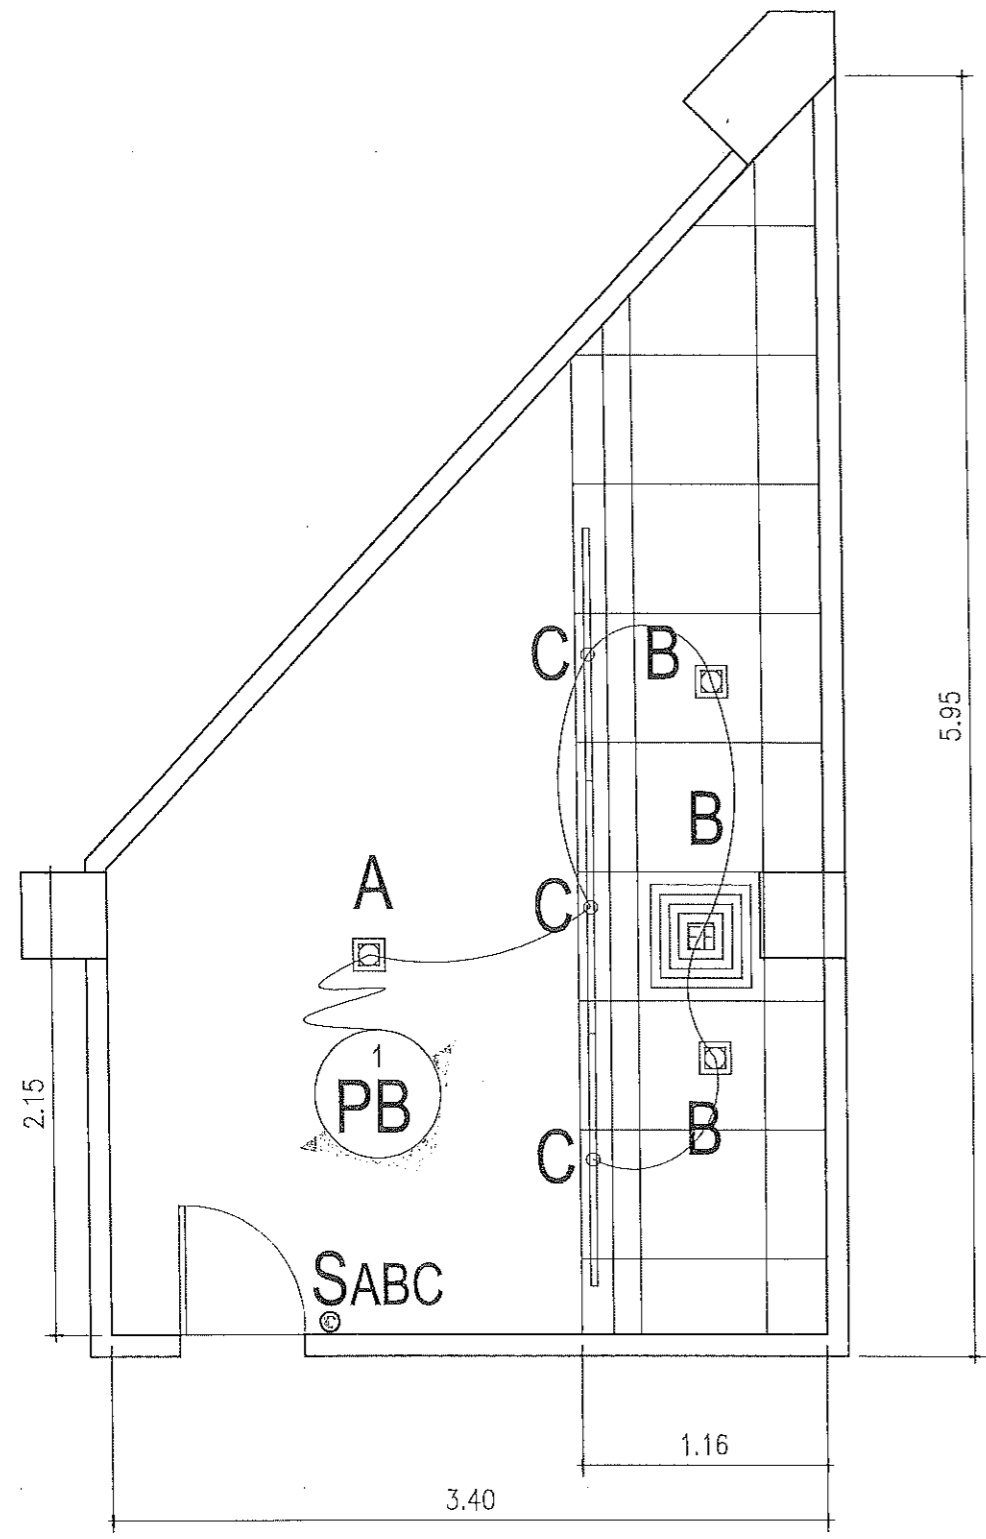
2 TYPICAL LAVATORY FAUCET DET.
A-33

WALL MOUNTED WATERLESS URINAL
(SUBJECT TO ARCHITECT'S APPROVAL)

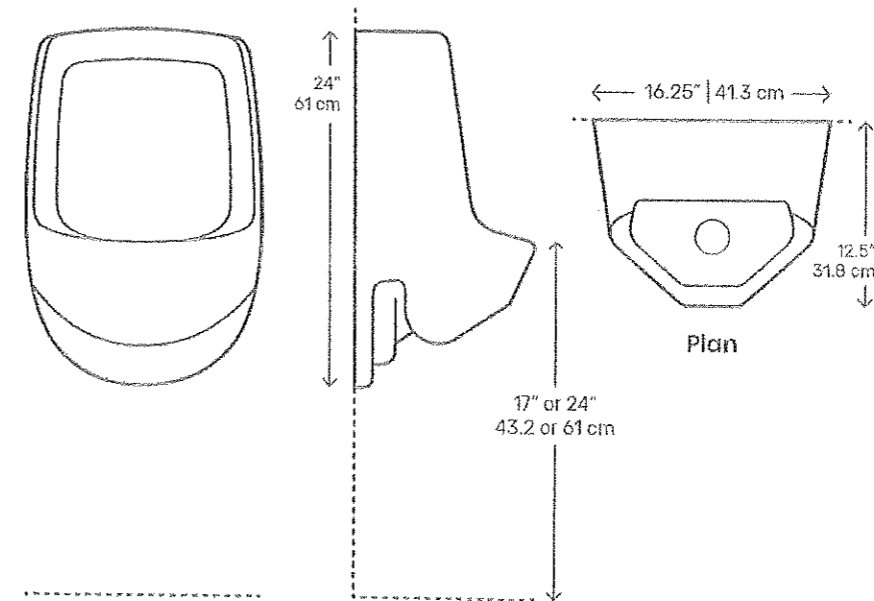

3 TYPICAL URINAL DET.
A-33

 <p>REPUBLIC OF THE PHILIPPINES PROVINCIAL ENGINEER'S OFFICE SAN AGUSTIN, DIGOS CITY, DAVAO DEL SUR</p>	<p>PROJECT TITLE: REPAIR /IMPROVEMENT OF SANGGUNIANG PANLALAWIGAN BUILDING</p>	<p>PREPARED BY: <i>[Signature]</i> REXIE GREY B. TABAY ARCHITECT III</p>	<p>REVIEWED BY: <i>[Signature]</i> JOSEPH R. GONZALES ENGINEER - II PLANNING AND PROGRAMMING DIV. HEAD</p>	<p>RECOMMENDING APPROVAL: <i>[Signature]</i> LEONERL MARCH P. SUARIO PROVINCIAL ENGINEER</p>	<p>APPROVED BY: <i>[Signature]</i> YVONNE ROÑACAGAS PROVINCIAL GOVERNOR</p>	<p>SHEET NO.:</p>
						<p>A-33</p>
					<p>33</p>	<p>79</p>


 

 



LOAD SCHEDULE :

CIRCUIT NO.	DESCRIPTION	QUANTITY	VOLTS	WATTS	AMPS	TRIP	CONDUCTOR SIZE	CONDUIT SIZE
PB 1	LIGHTING OUTLET	7	230	350	1.52	20 A	2- 3.5 mm ² THW Stranded Copper Wire , 1 - 2.0 mm ² THW Stranded Copper Wire	20 mm dia. uPVC

NOTE:
 - CONNECT TO EXISTING PANEL BOARD FOR POWER SOURCE

LEGEND:

-  8W LED PINLIGHT DOWNLIGHT RECESS TYPE E27 STANDARD SOCKET, BLACK SQUARE, COOL DAYLIGHT (15 x 15 cm)
-  15W T5 LED INTEGRATED TUBE, WARM WHITE (1173 x 24 x 32 mm)
-  12 INCH CEILING MOUNTED EXHAUST FAN
-  CIRCUIT HOMERUN (CONNECT TO EXISTING PANELBOARD)
-  THREE-GANG SWITCH WITH PLATE, FLUSH TYPE

1 TOILET - 1 LIGHTING LAYOUT
 E-1 SCALE 1:50



REPUBLIC OF THE PHILIPPINES
PROVINCIAL ENGINEER'S OFFICE
 SAN AGUSTIN, DIGOS CITY, DAVAO DEL SUR

PROJECT TITLE:
 REPAIR /IMPROVEMENT OF SANGGUNIANG PANLALAWIGAN BUILDING
 LOCATION:
 MATTI, DIGOS CITY, DAVAO DEL SUR

PREPARED BY:
Mary Flor L. Hectin
 MARY FLOR L. HECTIN
 ENGINEER I

REVIEWED BY:
Joseph R. Gonzales
 JOSEPH R. GONZALES
 ENGINEER - IN-CHARGE
 PLANNING AND PROGRAMMING DIV. HEAD


RECOMMENDING APPROVAL:
Leonerl March P. Suario
 LEONERL MARCH P. SUARIO
 PROVINCIAL ENGINEER

APPROVED BY:
Yvonne Roña Cagas
 YVONNE ROÑA CAGAS
 PROVINCIAL GOVERNOR

SHEET NO.:
 E-1
 34 79

TOILET - 2

**FEMALE TOILET
(@ 1ST FLOOR)**

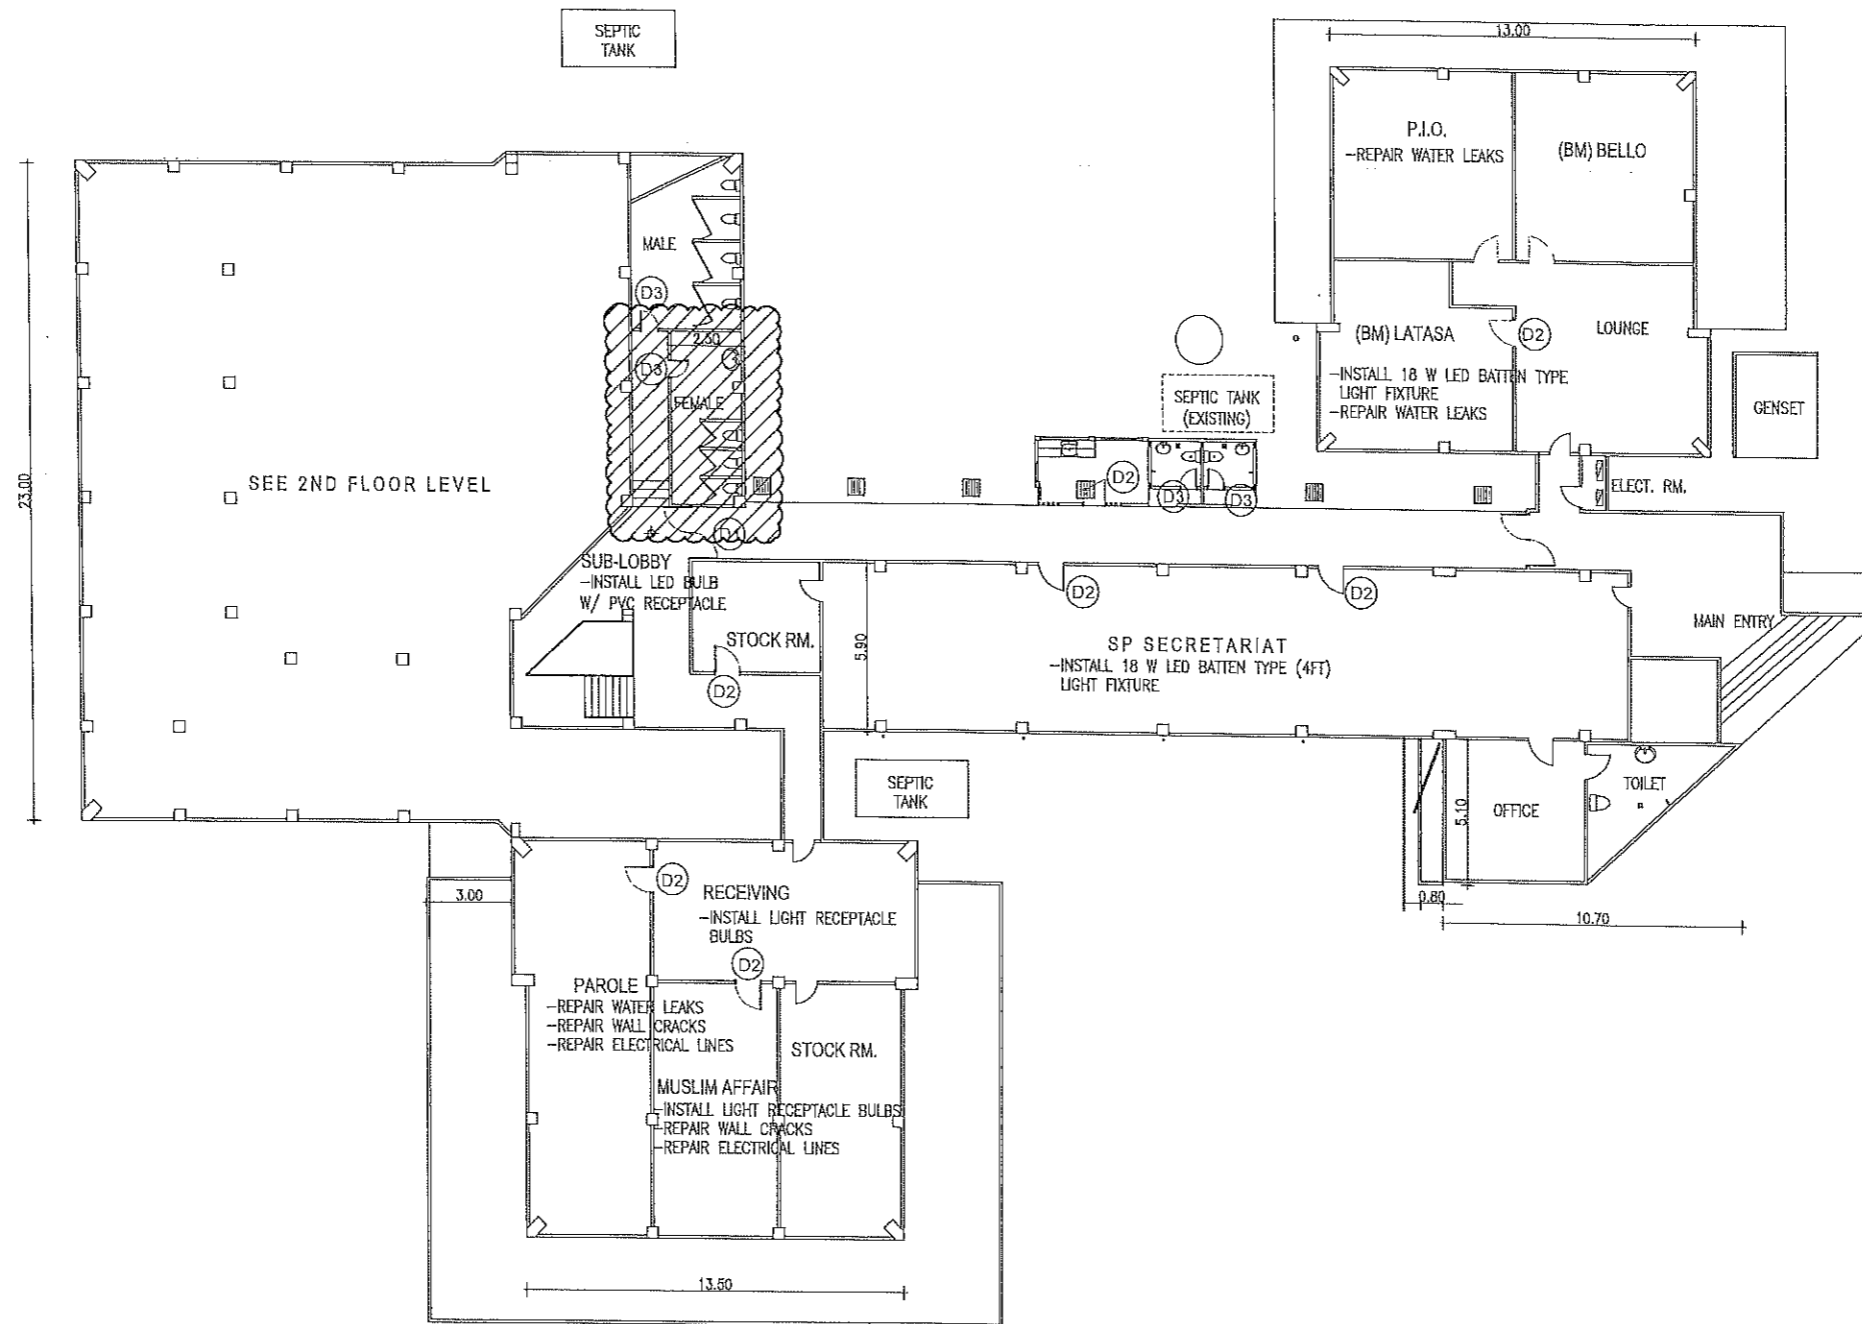

1
**TOILET - 2
FEMALE TOILET (@ 1ST FLOOR)**

A-35



REPUBLIC OF THE PHILIPPINES
PROVINCIAL ENGINEER'S OFFICE
 SAN AGUSTIN, DIGOS CITY, DAVAO DEL SUR

PROJECT TITLE:
**REPAIR /IMPROVEMENT OF SANGGUNIANG
 PANLALAWIGAN BUILDING**

LOCATION:
 MATTI, DIGOS CITY, DAVAO DEL SUR

PREPARED BY:
[Signature]
REXIE GREY B. TABAY
 ARCHITECT III

REVIEWED BY:
[Signature]
JOSEPH R. GONZALES
 ENGINEER - IN
 PLANNING AND PROGRAMMING DIV. HEAD

RECOMMENDING APPROVAL:
[Signature]
LEONERL MARCH P. SUARIO
 PROVINCIAL ENGINEER

APPROVED BY:
[Signature]
YVONNE RONA CAGAS
 PROVINCIAL GOVERNOR

SHEET NO.:
A-35
 35 79

SCOPE OF WORKS


- DEMOLISH CONCRETE CUBICLE WALL
- REMOVE FLOOR AND WALL TILES
- REPAINT WALLS
- INSTALL CEILING
- INSTALL CONCRETE LAVATORY COUNTER
- INSTALL PHENOLIC BOARD CUBICLE PARTITIONS
- REMOVE AND REPLACE LAVATORY
- INSTALL MIRROR, AND WATER CLOSET WITH BIDET.
- INSTALL TOILET PAPER HOLDER (STAINLESS STEEL)
- INSTALL EXHAUST FAN
- INSTALL PANEL DOOR (0.80M WIDTH)
- INSTALL 60MMx60MM SYNTHETIC GRANITE TILES

TOILET FIXTURES SPECIFICATIONS :

- WATER CLOSET -1.6GPF WATER CLOSET, LEVER TYPE FLUSH.
- LAVATORY -COUNTERTOP CERAMIC LAVATORY (SEE DETAIL)
- LAVATORY FAUCET -304 STAINLESS STEEL FAUCET
- SINK FAUCET -304 STAINLESS STEEL GOOSENECK FAUCET
- WALL FAUCET -304 STAINLESS STEEL WALL FAUCET
- BIDET -304 STAINLESS BIDET
- TOILET PAPER HOLDER -304 STAINLESS TOILET PAPER HOLDER
- URINAL -WATERLESS WALL MOUNTED URINAL
- TOILET MIRROR -6.0MM THK TOILET MIRROR

NOTE :

ALL FINISHING MATERIALS AND ITEMS TO BE USED SHALL BE IN ACCORDANCE TO SPECIFICATIONS AND SUBJECT TO THE APPROVAL OF ARCHITECT PRIOR INSTALLATION.

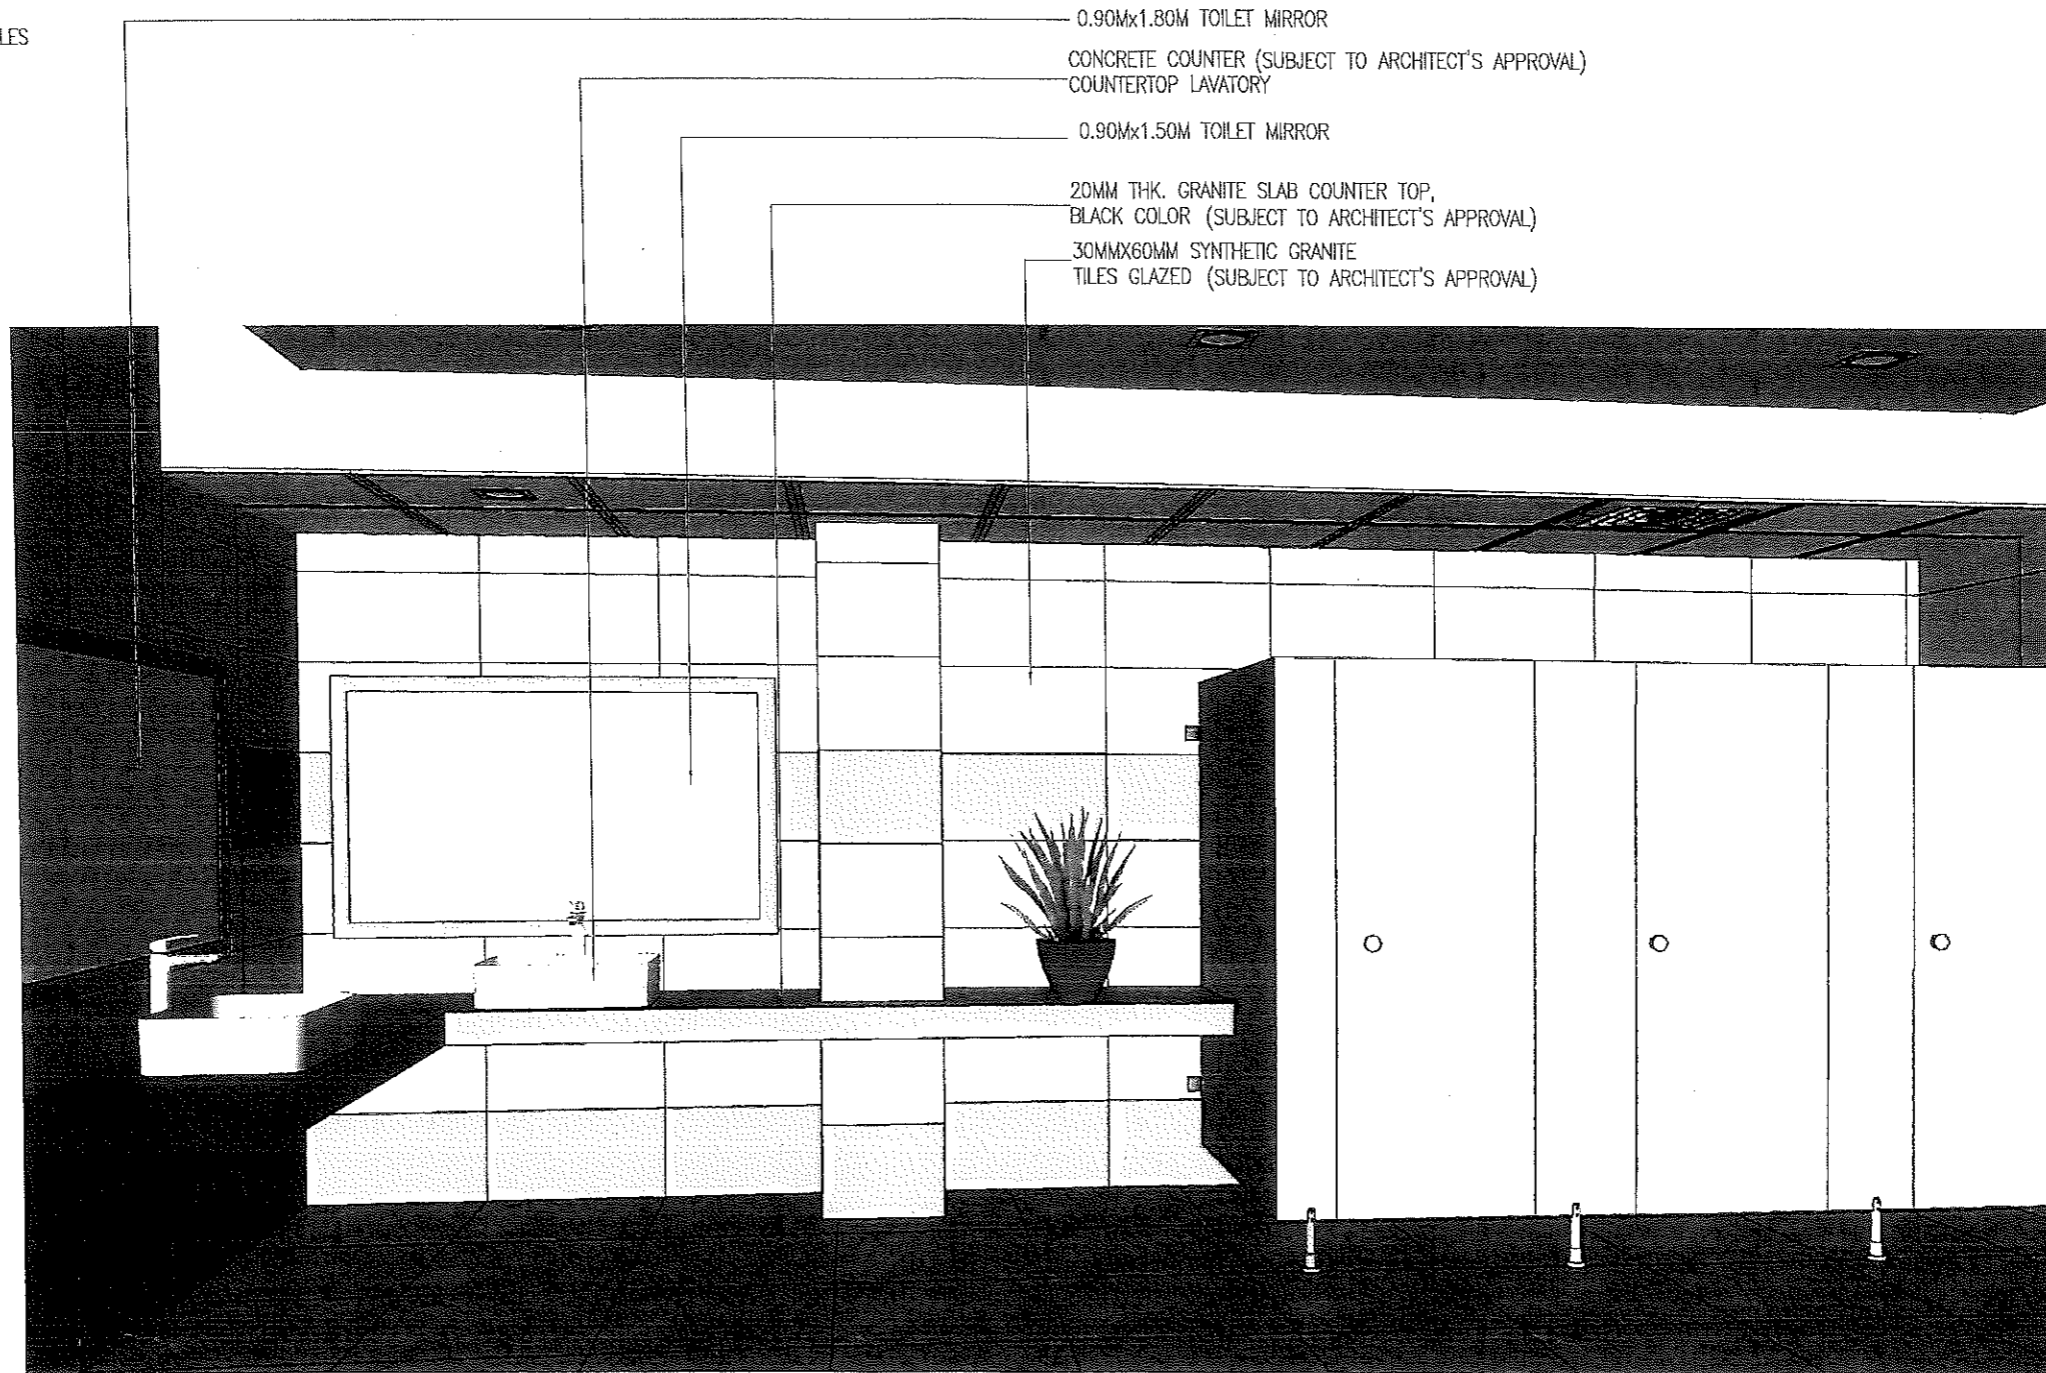

- 0.90Mx1.80M TOILET MIRROR
- CONCRETE COUNTER (SUBJECT TO ARCHITECT'S APPROVAL)
- COUNTERTOP LAVATORY
- 0.90Mx1.50M TOILET MIRROR
- 20MM THK. GRANITE SLAB COUNTER TOP,
BLACK COLOR (SUBJECT TO ARCHITECT'S APPROVAL)
- 30MMx60MM SYNTHETIC GRANITE
TILES GLAZED (SUBJECT TO ARCHITECT'S APPROVAL)

1 PERSPECTIVE
A-36



REPUBLIC OF THE PHILIPPINES
PROVINCIAL ENGINEER'S OFFICE
SAN AGUSTIN, DIGOS CITY, DAVAO DEL SUR

PROJECT TITLE:
REPAIR /IMPROVEMENT OF SANGGUNIANG
PANLALAWIGAN BUILDING

LOCATION:
MATTI, DIGOS CITY, DAVAO DEL SUR


PREPARED BY:
Rexie Grey B. Tabay
REXIE GREY B. TABAY
ARCHITECT III

REVIEWED BY:
Joseph R. Gonzales
JOSEPH R. GONZALES
ENGINEER - II
PLANNING AND PROGRAMMING DIV. HEAD


RECOMMENDING / APPROVAL:
Leonerl March P. Suario
LEONERL MARCH P. SUARIO
PROVINCIAL ENGINEER

APPROVED BY:
Yvonne Roña Cagas
YVONNE ROÑA CAGAS
PROVINCIAL GOVERNOR

SHEET NO.:
A-36
36 79

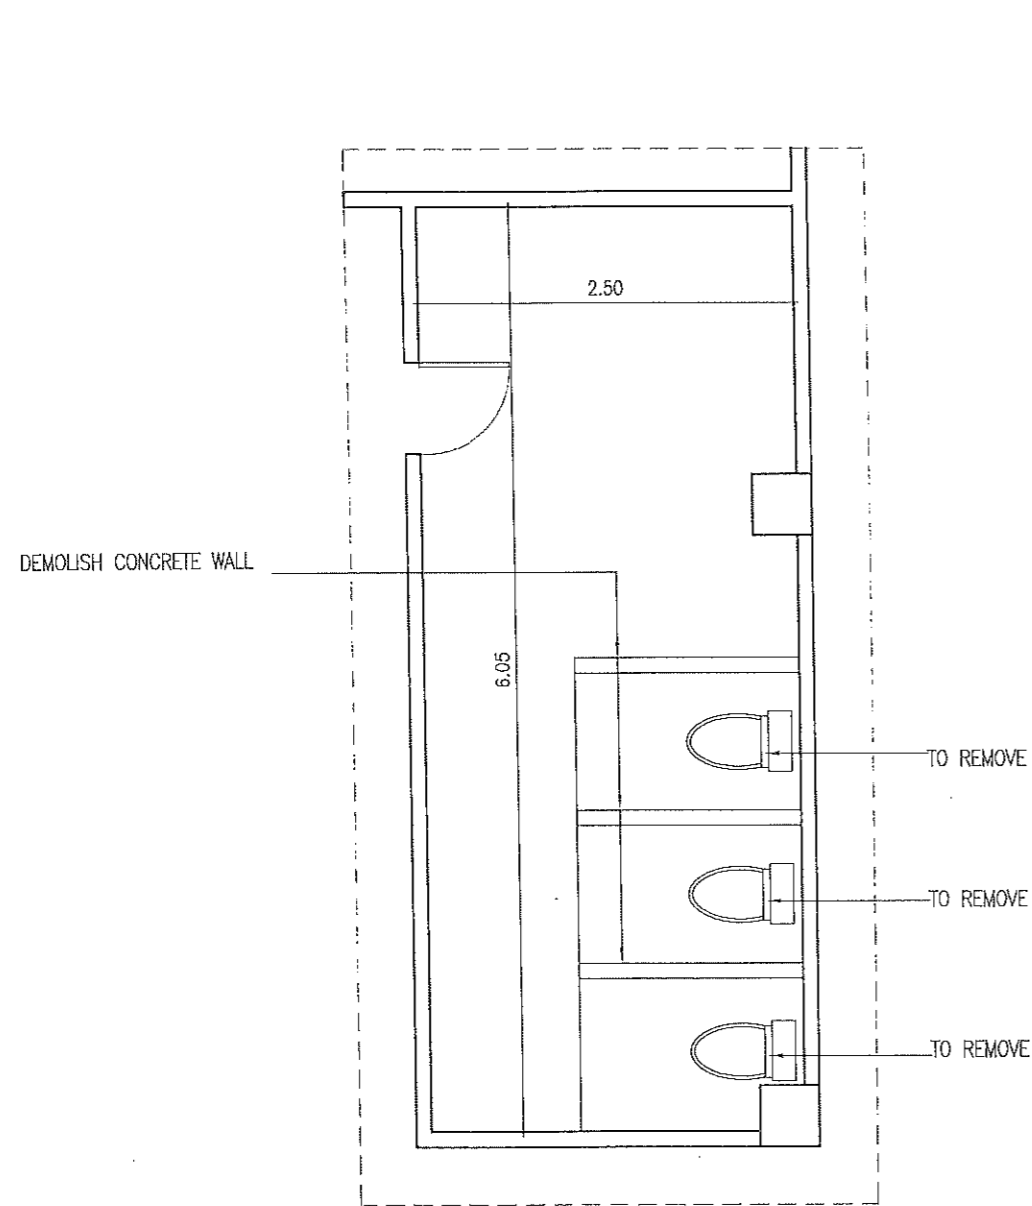

1 EXISTING FLOOR
A-37 SCALE 1:50

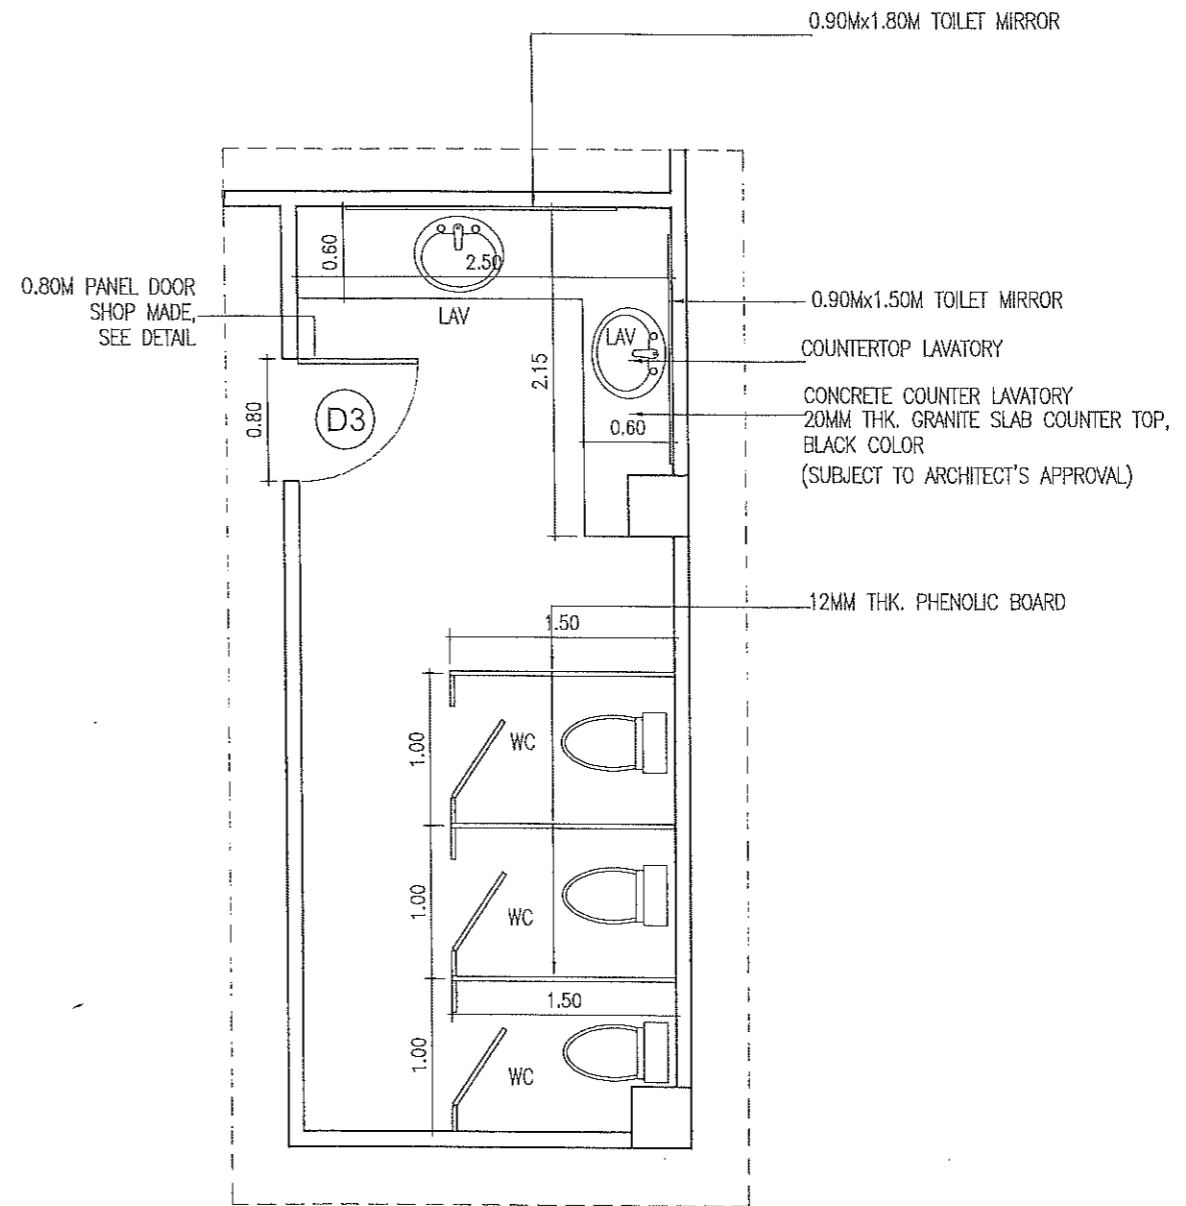

2 PROPOSED FLOOR PLAN
A-37 SCALE 1:50



REPUBLIC OF THE PHILIPPINES
PROVINCIAL ENGINEER'S OFFICE
SAN AGUSTIN, DIGOS CITY, DAVAO DEL SUR

PROJECT TITLE:
REPAIR /IMPROVEMENT OF SANGGUNIANG
PANLALAWIGAN BUILDING

LOCATION:
MATTI, DIGOS CITY, DAVAO DEL SUR

PREPARED BY:
[Signature]
REXIE GREY B. TABAY
ARCHITECT III

REVIEWED BY:
[Signature]
JOSEPH R. GONZALES
ENGINEER - III
PLANNING AND PROGRAMMING DIV. HEAD

RECOMMENDING APPROVAL:
[Signature]
LEONERL MARCH P. SUARIO
PROVINCIAL ENGINEER

APPROVED BY:
[Signature]
YVONNE RONA CAGAS
PROVINCIAL GOVERNOR


SHEET NO.:

A-37

37 79

60MMx60MM SYNTHETIC
GRANITE FLOOR TILES (NON-SKID)
(SUBJECT TO ARCHITECT'S APPROVAL)


30MMx60MM SYNTHETIC
GRANITE WALL TILES (GLAZED)
(SUBJECT TO ARCHITECT'S APPROVAL)

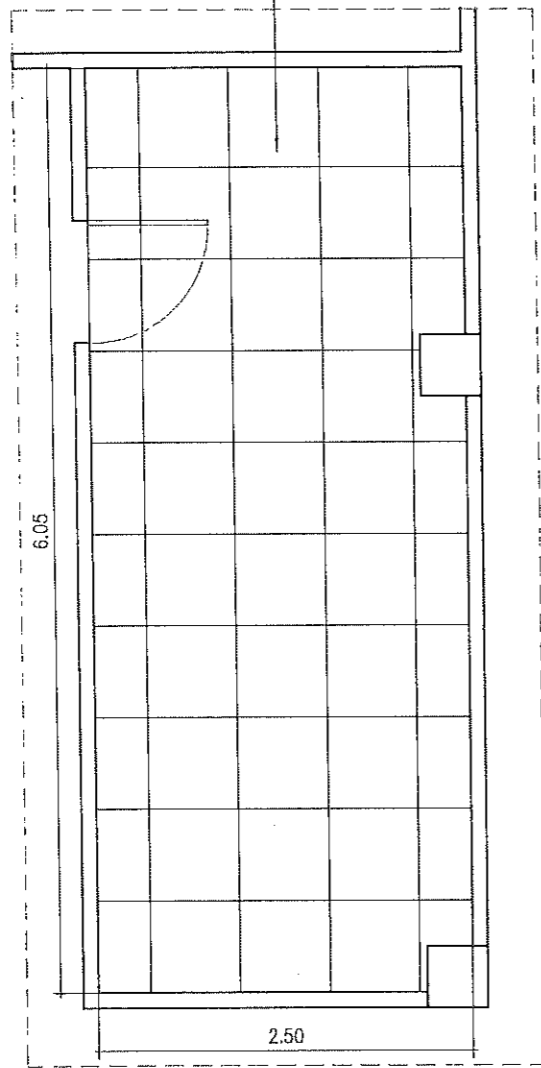

600MMx600MM GYPSUM
BOARD CEILING TILES

5.0MM THK. MARINE
PLYWOOD CEILING
ON METAL FURRING
W/ CEILING CORNICE

PINLIGHT
REFER TO ELECTRICAL

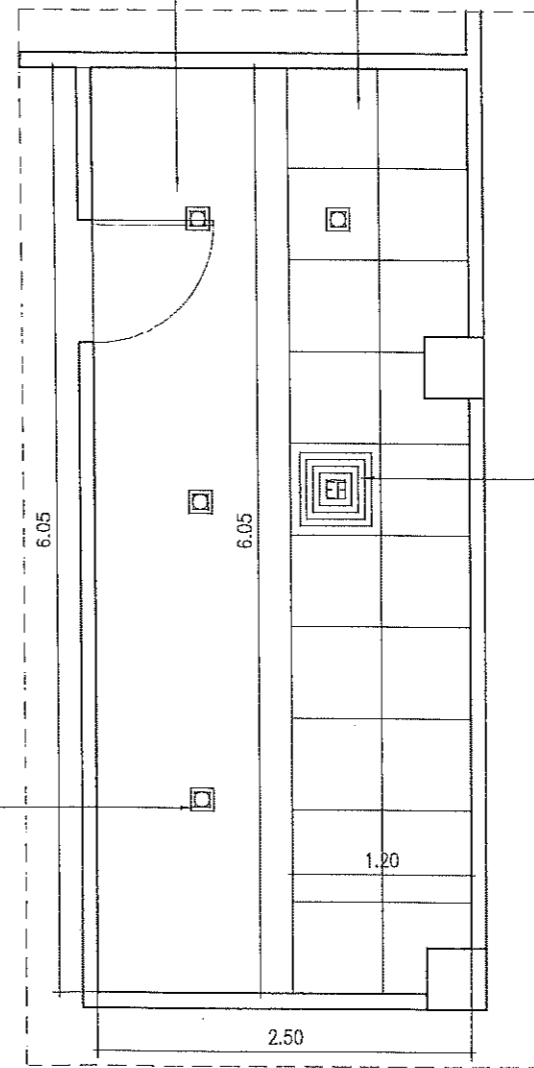

EXHAUST FAN

1 FLOOR TILE LAYOUT
A-38 SCALE 1:50

2 CEILING PLAN
A-38 SCALE 1:50



REPUBLIC OF THE PHILIPPINES
PROVINCIAL ENGINEER'S OFFICE
SAN AGUSTIN, DIGOS CITY, DAVAO DEL SUR

PROJECT TITLE:
**REPAIR /IMPROVEMENT OF SANGGUNIANG
PANLALAWIGAN BUILDING**

LOCATION:
MATTI, DIGOS CITY, DAVAO DEL SUR


PREPARED BY:
[Signature]
REXE GREY B. TABAY
ARCHITECT III

REVIEWED BY:
[Signature]
JOSEPH R. GONZALES
ENGINEER - III
PLANNING AND PROGRAMMING DIV. HEAD

RECOMMENDING APPROVAL:
[Signature]
LEONERL MARCH P. SUARIO
PROVINCIAL ENGINEER


APPROVED BY:
[Signature]
YVONNE ROÑA CAGAS
PROVINCIAL GOVERNOR

SHEET NO.:
A-38
38 79

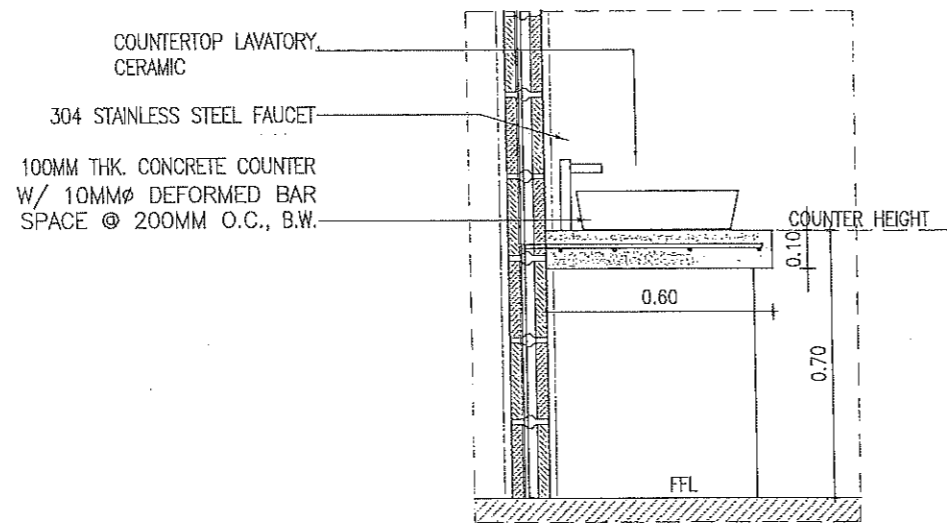


3 TYPICAL CONCRETE COUNTER DET.
 A-39 SCALE 1:20M.

CERAMIC WATER CLOSET
 (HCG, PHILIPPINE STANDARD,
 AMERICAN STANDARD OR ITS EQUIVALENT)
 (SUBJECT TO ARCHITECT'S APPROVAL)

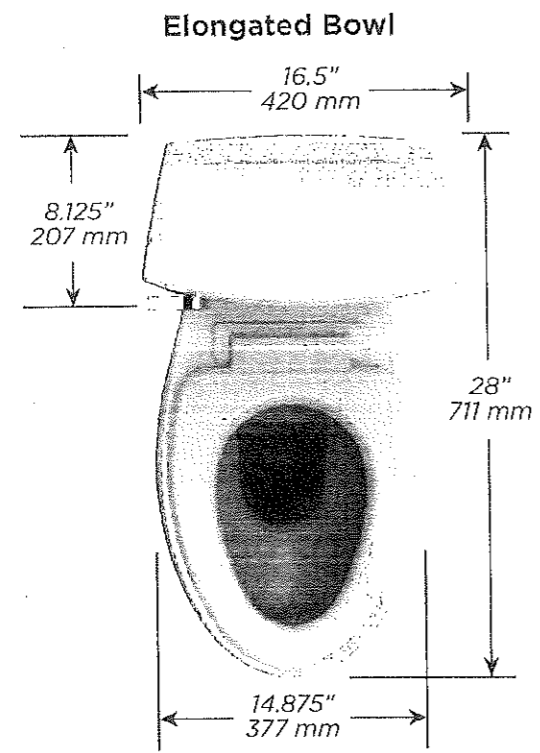


1 TYPICAL WATER CLOSET DET.
 A-39

COUNTERTOP CERAMIC LAVATORY
 (HCG, PHILIPPINE STANDARD,
 AMERICAN STANDARD OR ITS EQUIVALENT)
 (SUBJECT TO ARCHITECT'S APPROVAL)

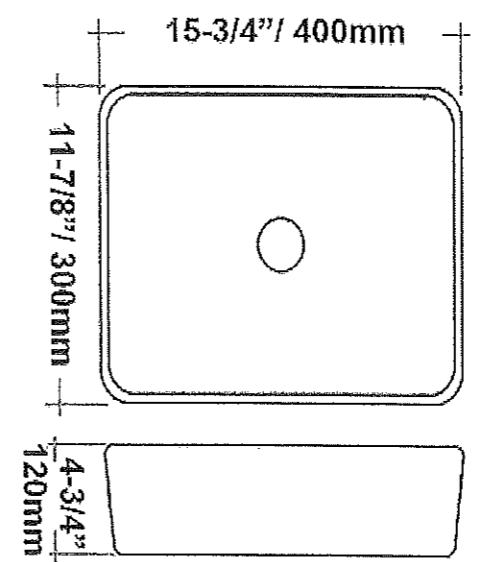


2 COUNTERTOP TYPICAL LAVATORY DETAIL
 A-39

	REPUBLIC OF THE PHILIPPINES PROVINCIAL ENGINEER'S OFFICE SAN AGUSTIN, DIGOS CITY, DAVAO DEL SUR	PROJECT TITLE: REPAIR /IMPROVEMENT OF SANGGUNIANG PANLALAWIGAN BUILDING	PREPARED BY: REXIE GREY B. TABAY ARCHITECT III	REVIEWED BY: JOSEPH R. GONZALES ENGINEER III PLANNING AND PROGRAMMING DIV. HEAD	RECOMMENDING APPROVAL: LEONERL MARCH P. SUARIO PROVINCIAL ENGINEER	APPROVED BY: YVONNE ROÑA CAGAS PROVINCIAL GOVERNOR	SHEET NO.: A-39 39 79
	LOCATION: MATTI, DIGOS CITY, DAVAO DEL SUR						

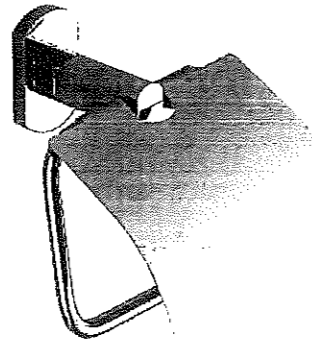


3 TOILET PAPER HOLDER-TYPICAL
A-40

304 STAINLESS STEEL FAUCET
(SUBJECT TO ARCHITECT'S APPROVAL)

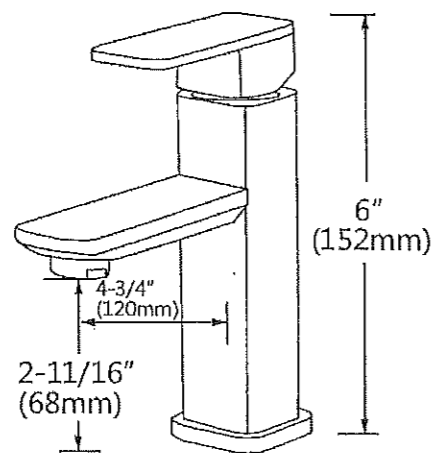

1 TYPICAL LAVATORY FAUCET DET.
A-40

WALL MOUNTED WATERLESS URINAL
(SUBJECT TO ARCHITECT'S APPROVAL)

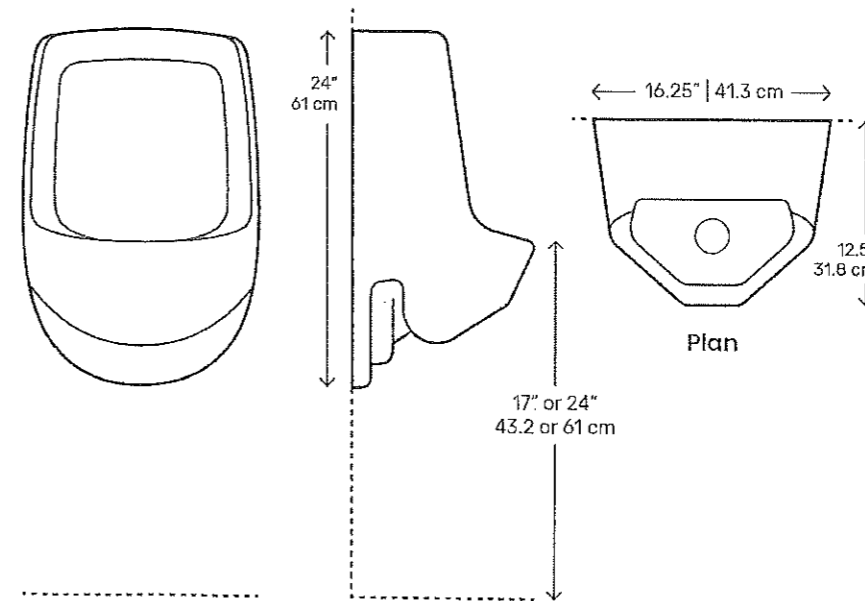

2 TYPICAL URINAL DET.
A-40



REPUBLIC OF THE PHILIPPINES
PROVINCIAL ENGINEER'S OFFICE
SAN AGUSTIN, DIGOS CITY, DAVAO DEL SUR

PROJECT TITLE:
REPAIR /IMPROVEMENT OF SANGGUNIANG
PANLALAWIGAN BUILDING
LOCATION:
MATTI, DIGOS CITY, DAVAO DEL SUR


PREPARED BY:
[Signature]
REXIE GREY B. TABAY
ARCHITECT III

REVIEWED BY:
[Signature]
JOSEPH R. GONZALES
ENGINEER - III
PLANNING AND PROGRAMMING DIV. HEAD

RECOMMENDING APPROVAL:
[Signature]
LEONERL MARCH P. SUARIO
PROVINCIAL ENGINEER

APPROVED BY:
[Signature]
YVONNE ROÑA CAGAS
PROVINCIAL GOVERNOR

SHEET NO.:
A-40
40 79

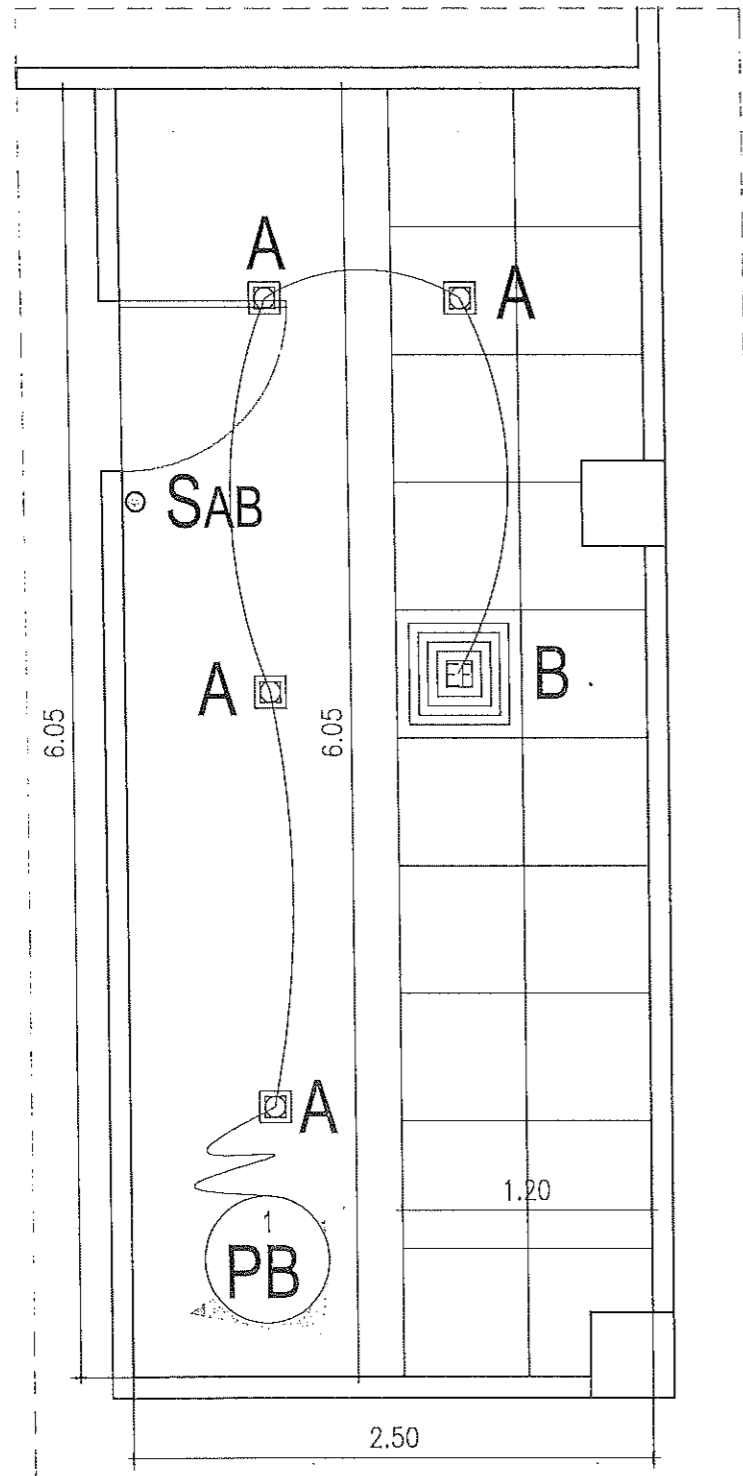





LOAD SCHEDULE :

CIRCUIT NO.	DESCRIPTION	QUANTITY	VOLTS	WATTS	AMPS	TRIP	CONDUCTOR SIZE	CONDUIT SIZE
PB 1	LIGHTING OUTLET	5	230	250	1.09	20 A	2- 3.5 mm ² THW Stranded Copper Wire , 1 - 2.0 mm ² THW Stranded Copper Wire	20 mm dia. uPVC

NOTE:

- CONNECT TO EXISTING PANEL BOARD FOR POWER SOURCE

 LEGEND:

-  6W LED PINLIGHT DOWNLIGHT RECESS TYPE E27 STANDARD SOCKET, BLACK SQUARE, COOL DAYLIGHT (15 x 15 cm)
-  12 INCH CEILING MOUNTED EXHAUST FAN
-  CIRCUIT HOMERUN (CONNECT TO EXISTING PANELBOARD)
-  TWO-GANG SWITCH WITH PLATE, FLUSH TYPE

1 TOILET - 2 LIGHTING LAYOUT
E-1 SCALE 1:50



REPUBLIC OF THE PHILIPPINES
PROVINCIAL ENGINEER'S OFFICE
SAN AGUSTIN, DIGOS CITY, DAVAO DEL SUR

PROJECT TITLE:
REPAIR /IMPROVEMENT OF SANGGUNIANG PANLALAWIGAN BUILDING
LOCATION:
MATTI, DIGOS CITY, DAVAO DEL SUR

PREPARED BY:
Mary Flor L. Hectin
MARY FLOR L. HECTIN
ENGINEER I

REVIEWED BY:
Joseph R. Gonzales
JOSEPH R. GONZALES
ENGINEER, III
PLANNING AND PROGRAMMING DIV. HEAD


RECOMMENDING APPROVAL:
Leonerl March P. Suarion
LEONERL MARCH P. SUARIO
PROVINCIAL ENGINEER

APPROVED BY:
Yvonne Romo Cagas
YVONNE ROMO CAGAS
PROVINCIAL GOVERNOR

SHEET NO.:
E-1
41 79

TOILET - 3

**FEMALE
(@ 2ND FLOOR)**

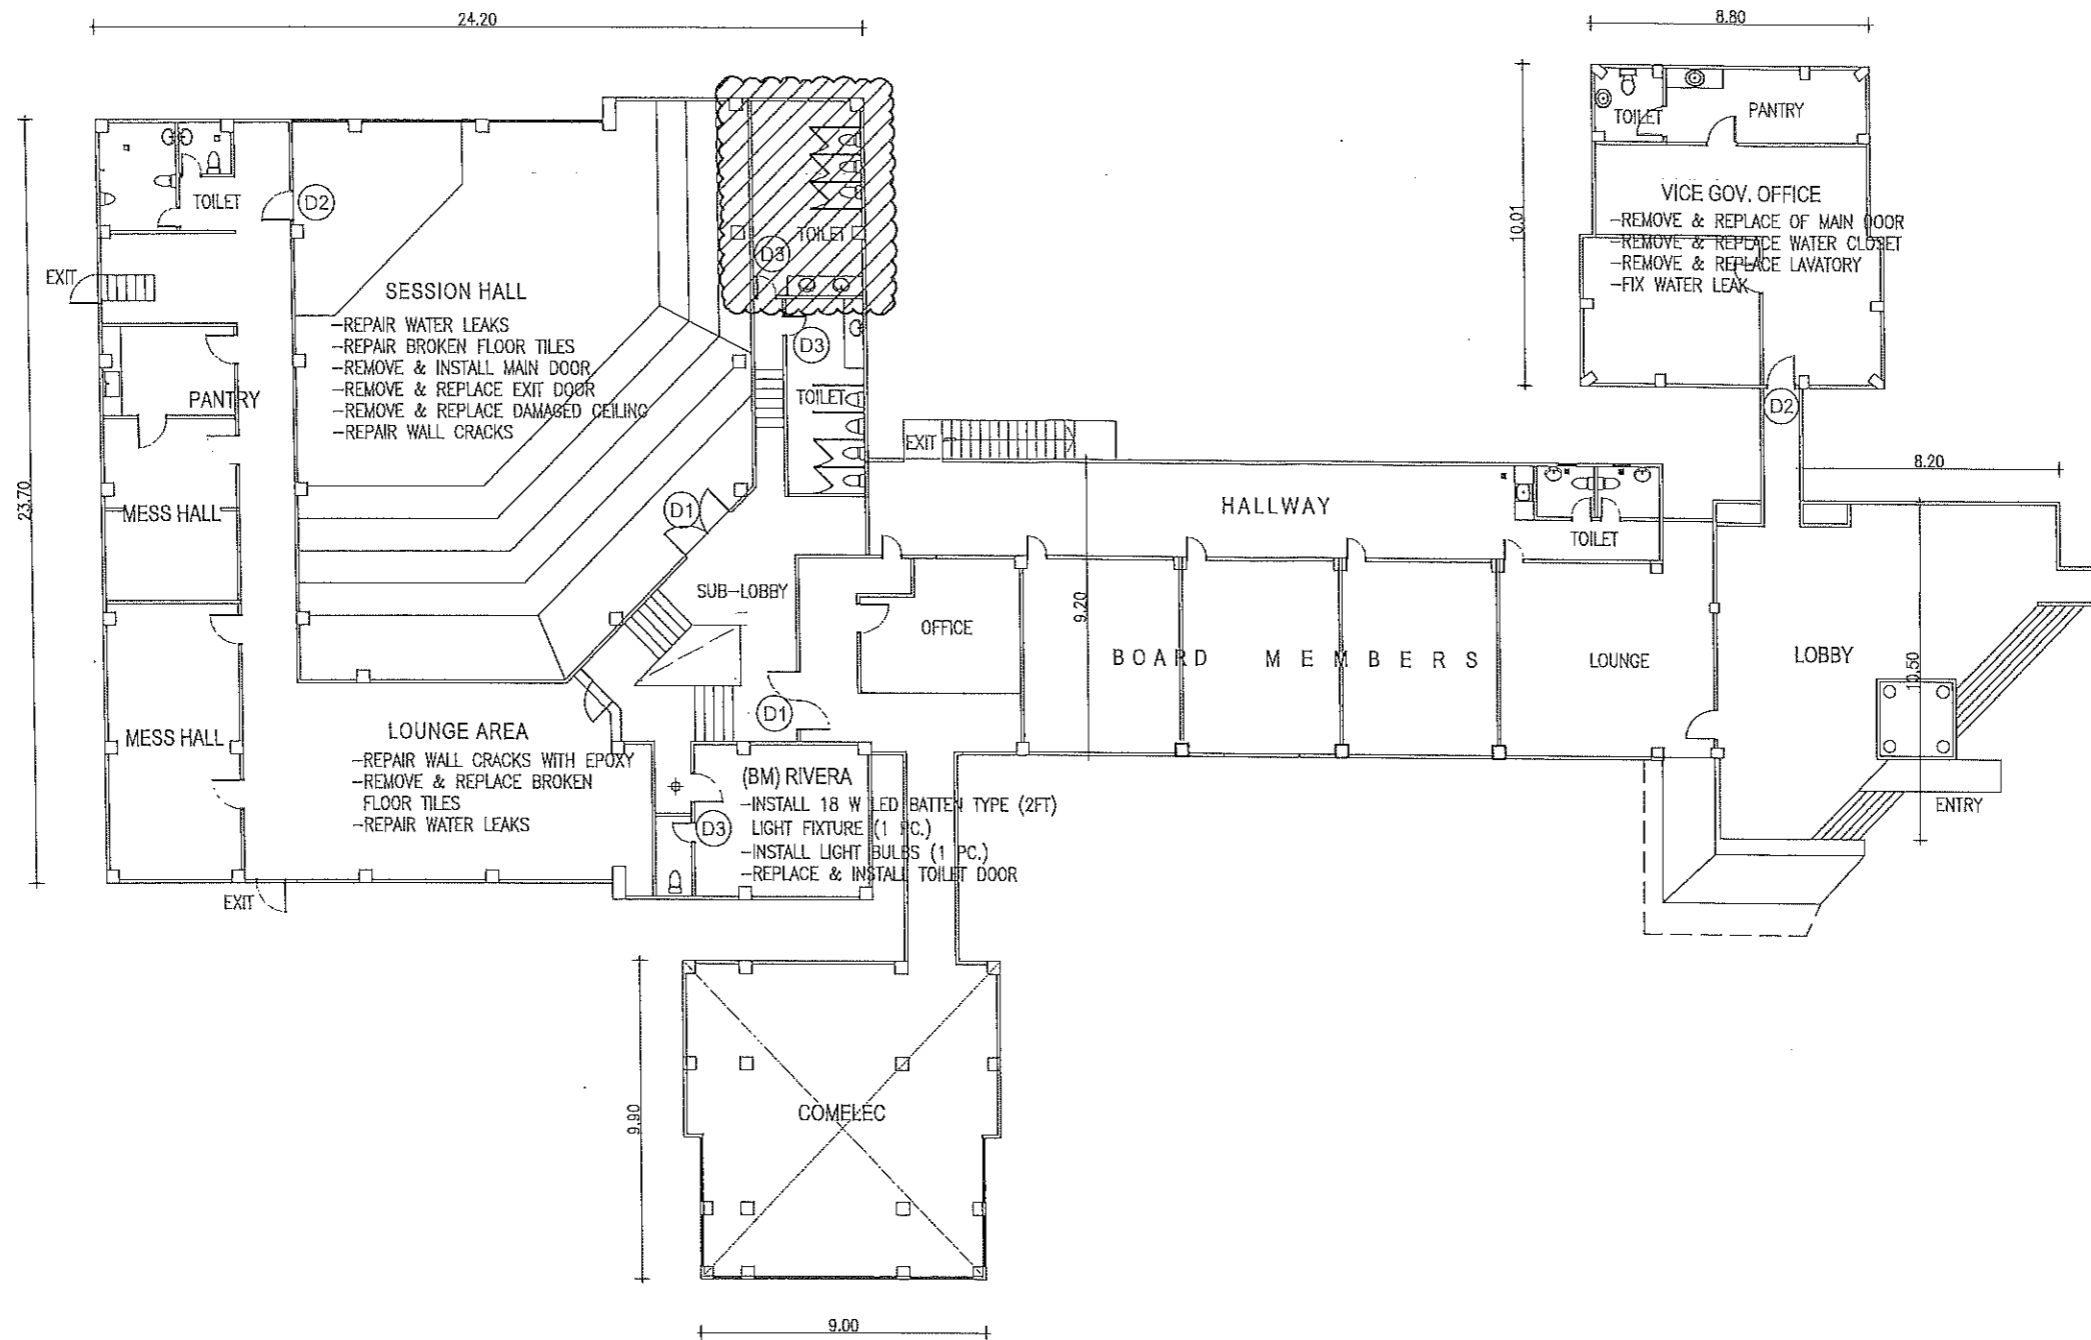

**TOILET - 3
FEMALE TOILET (@ 2nd FLOOR)**

1
A-42



REPUBLIC OF THE PHILIPPINES
PROVINCIAL ENGINEER'S OFFICE
SAN AGUSTIN, DIGOS CITY, DAVAO DEL SUR

PROJECT TITLE:
REPAIR /IMPROVEMENT OF SANGGUNIANG
PANLALAWIGAN BUILDING
LOCATION:
MATTI, DIGOS CITY, DAVAO DEL SUR


PREPARED BY:
[Signature]
REXIE GREY B. TABAY
ARCHITECT III

REVIEWED BY:
[Signature]
JOSEPH R. GONZALES
ENGINEER - III
PLANNING AND PROGRAMMING DIV. HEAD


RECOMMENDING APPROVAL:
[Signature]
LEONERL MARCH P. SUARIO
PROVINCIAL ENGINEER

APPROVED BY:
[Signature]
YVONNE ROMA CAGAS
PROVINCIAL GOVERNOR


SHEET NO.:
A-42
42 79

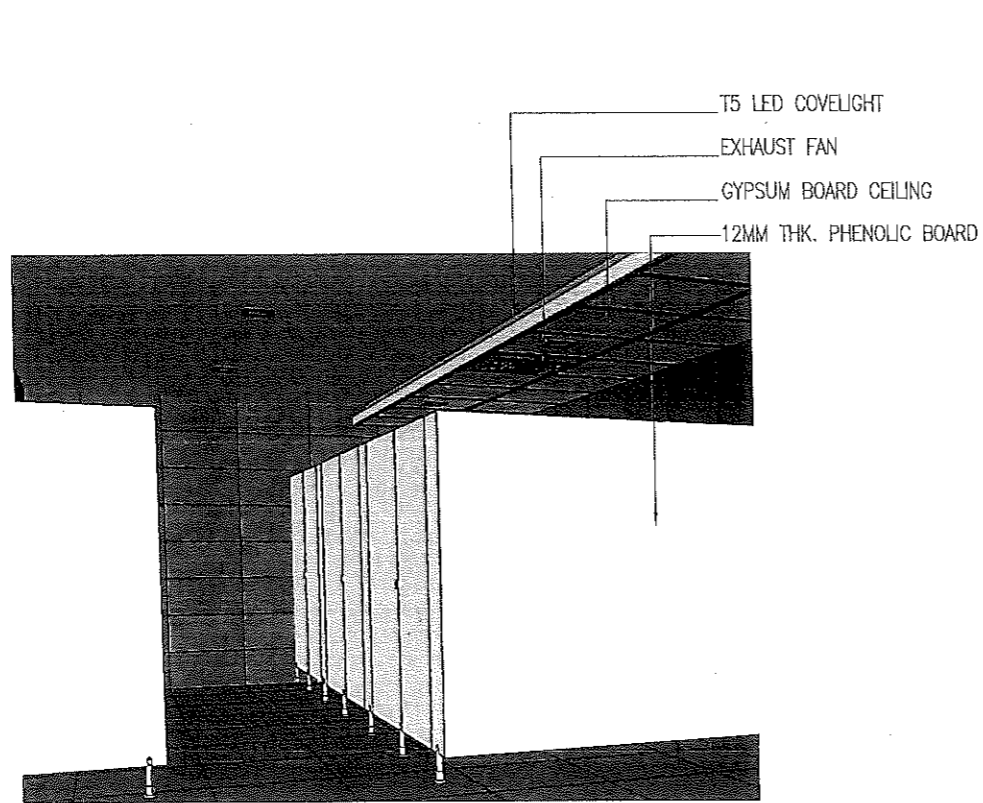

VIEW AT CUBICLES

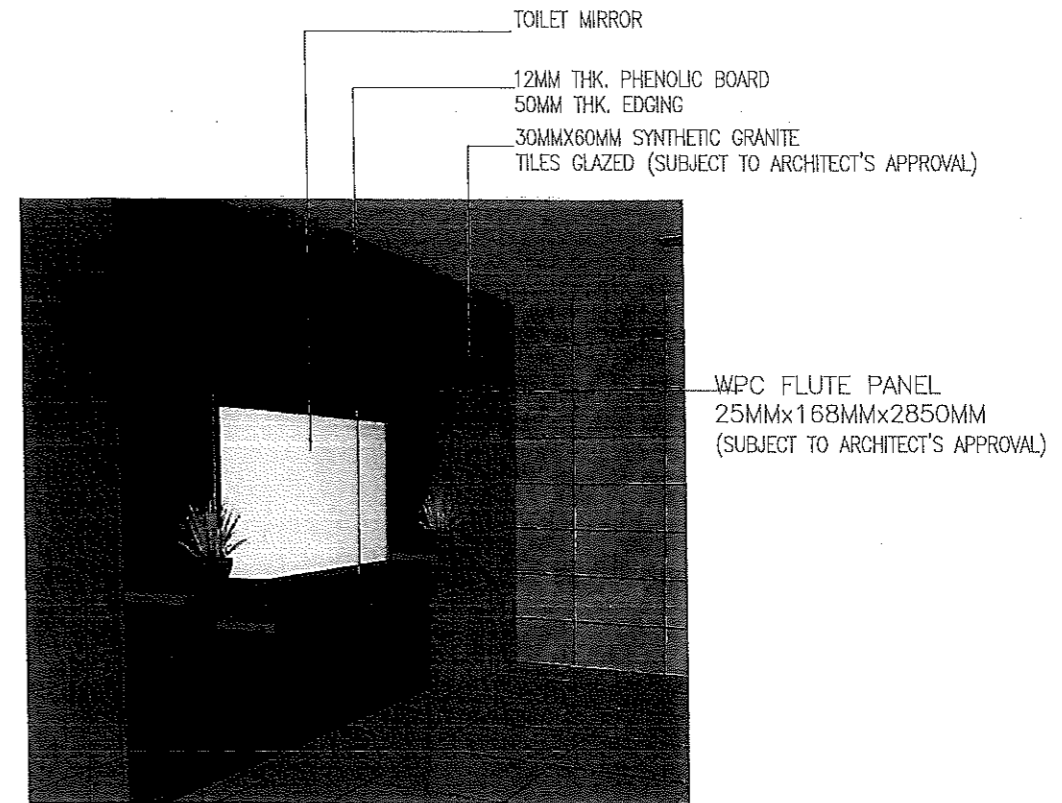

VIEW AT LEDGE

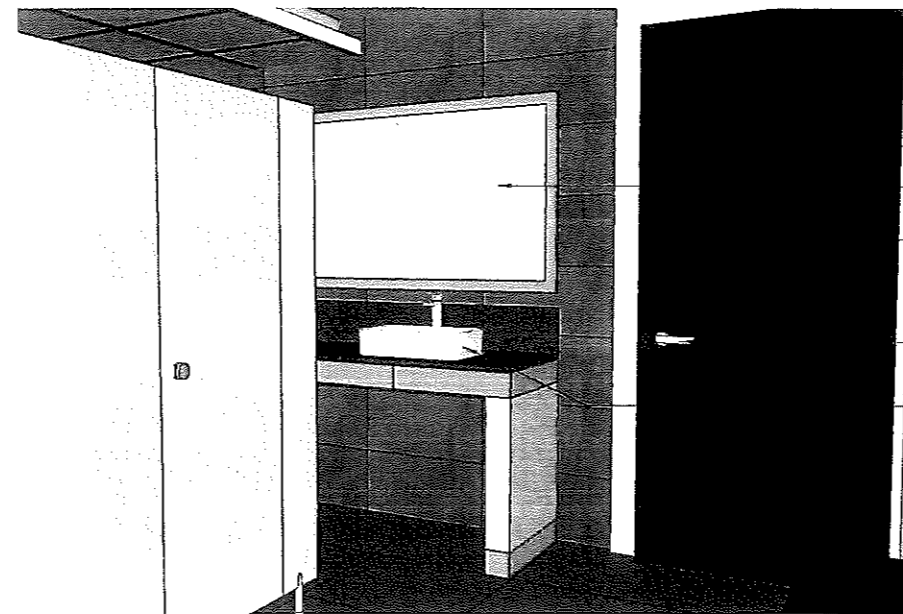

VIEW AT LAVATORY

1 PERSPECTIVE
 A-43



REPUBLIC OF THE PHILIPPINES
 PROVINCIAL ENGINEER'S OFFICE
 SAN AGUSTIN, DIGOS CITY, DAVAO DEL SUR

PROJECT TITLE:
 REPAIR /IMPROVEMENT OF SANGGUNIANG
 PANLALAWIGAN BUILDING
 LOCATION:
 MATTI, DIGOS CITY, DAVAO DEL SUR

PREPARED BY:
[Signature]
 REXIE GREY B. TABAY
 ARCHITECT III

REVIEWED BY:
[Signature]
 JOSEPH R. GONZALES
 ENGINEER - III
 PLANNING AND PROGRAMMING DIV. HEAD

RECOMMENDING APPROVAL:
[Signature]
 LEONERL MARCH P. SUARIO
 PROVINCIAL ENGINEER

APPROVED BY:
[Signature]
 YVONNE ROÑA CAGAS
 PROVINCIAL GOVERNOR

SHEET NO.:
 A-43
 43 79

SCOPE OF WORKS


- DEMOLISH CONCRETE CUBICLE WALL
- REMOVE FLOOR AND WALL TILES
- REPAINT WALLS
- INSTALL CEILING
- INSTALL CONCRETE LAVATORY COUNTER
- INSTALL PHENOLIC BOARD CUBICLE PARTITIONS
- REMOVE AND REPLACE LAVATORY
- INSTALL MIRROR, AND WATER CLOSET WITH BIDET,
- INSTALL TOILET PAPER HOLDER (STAINLESS STEEL)
- INSTALL EXHAUST FAN
- INSTALL PANEL DOOR (0.80M WIDTH)
- INSTALL 60MMx60MM SYNTHETIC GRANITE TILES

TOILET FIXTURES SPECIFICATIONS :

- | | |
|---------------------|---|
| WATER CLOSET | -1.6GPF WATER CLOSET, LEVER TYPE FLUSH. |
| LAVATORY | -COUNTERTOP CERAMIC LAVATORY (SEE DETAIL) |
| LAVATORY FAUCET | -304 STAINLESS STEEL FAUCET |
| SINK FAUCET | -304 STAINLESS STEEL GOOSENECK FAUCET |
| WALL FAUCET | -304 STAINLESS STEEL WALL FAUCET |
| BIDET | -304 STAINLESS BIDET |
| TOILET PAPER HOLDER | -304 STAINLESS TOILET PAPER HOLDER |
| URINAL | -WATERLESS WALL MOUNTED URINAL |
| TOILET MIRROR | -6.0MM THK TOILET MIRROR |

NOTE :

ALL FINISHING MATERIALS AND ITEMS TO BE USED SHALL BE IN ACCORDANCE TO SPECIFICATIONS AND SUBJECT TO THE APPROVAL OF ARCHITECT PRIOR INSTALLATION.

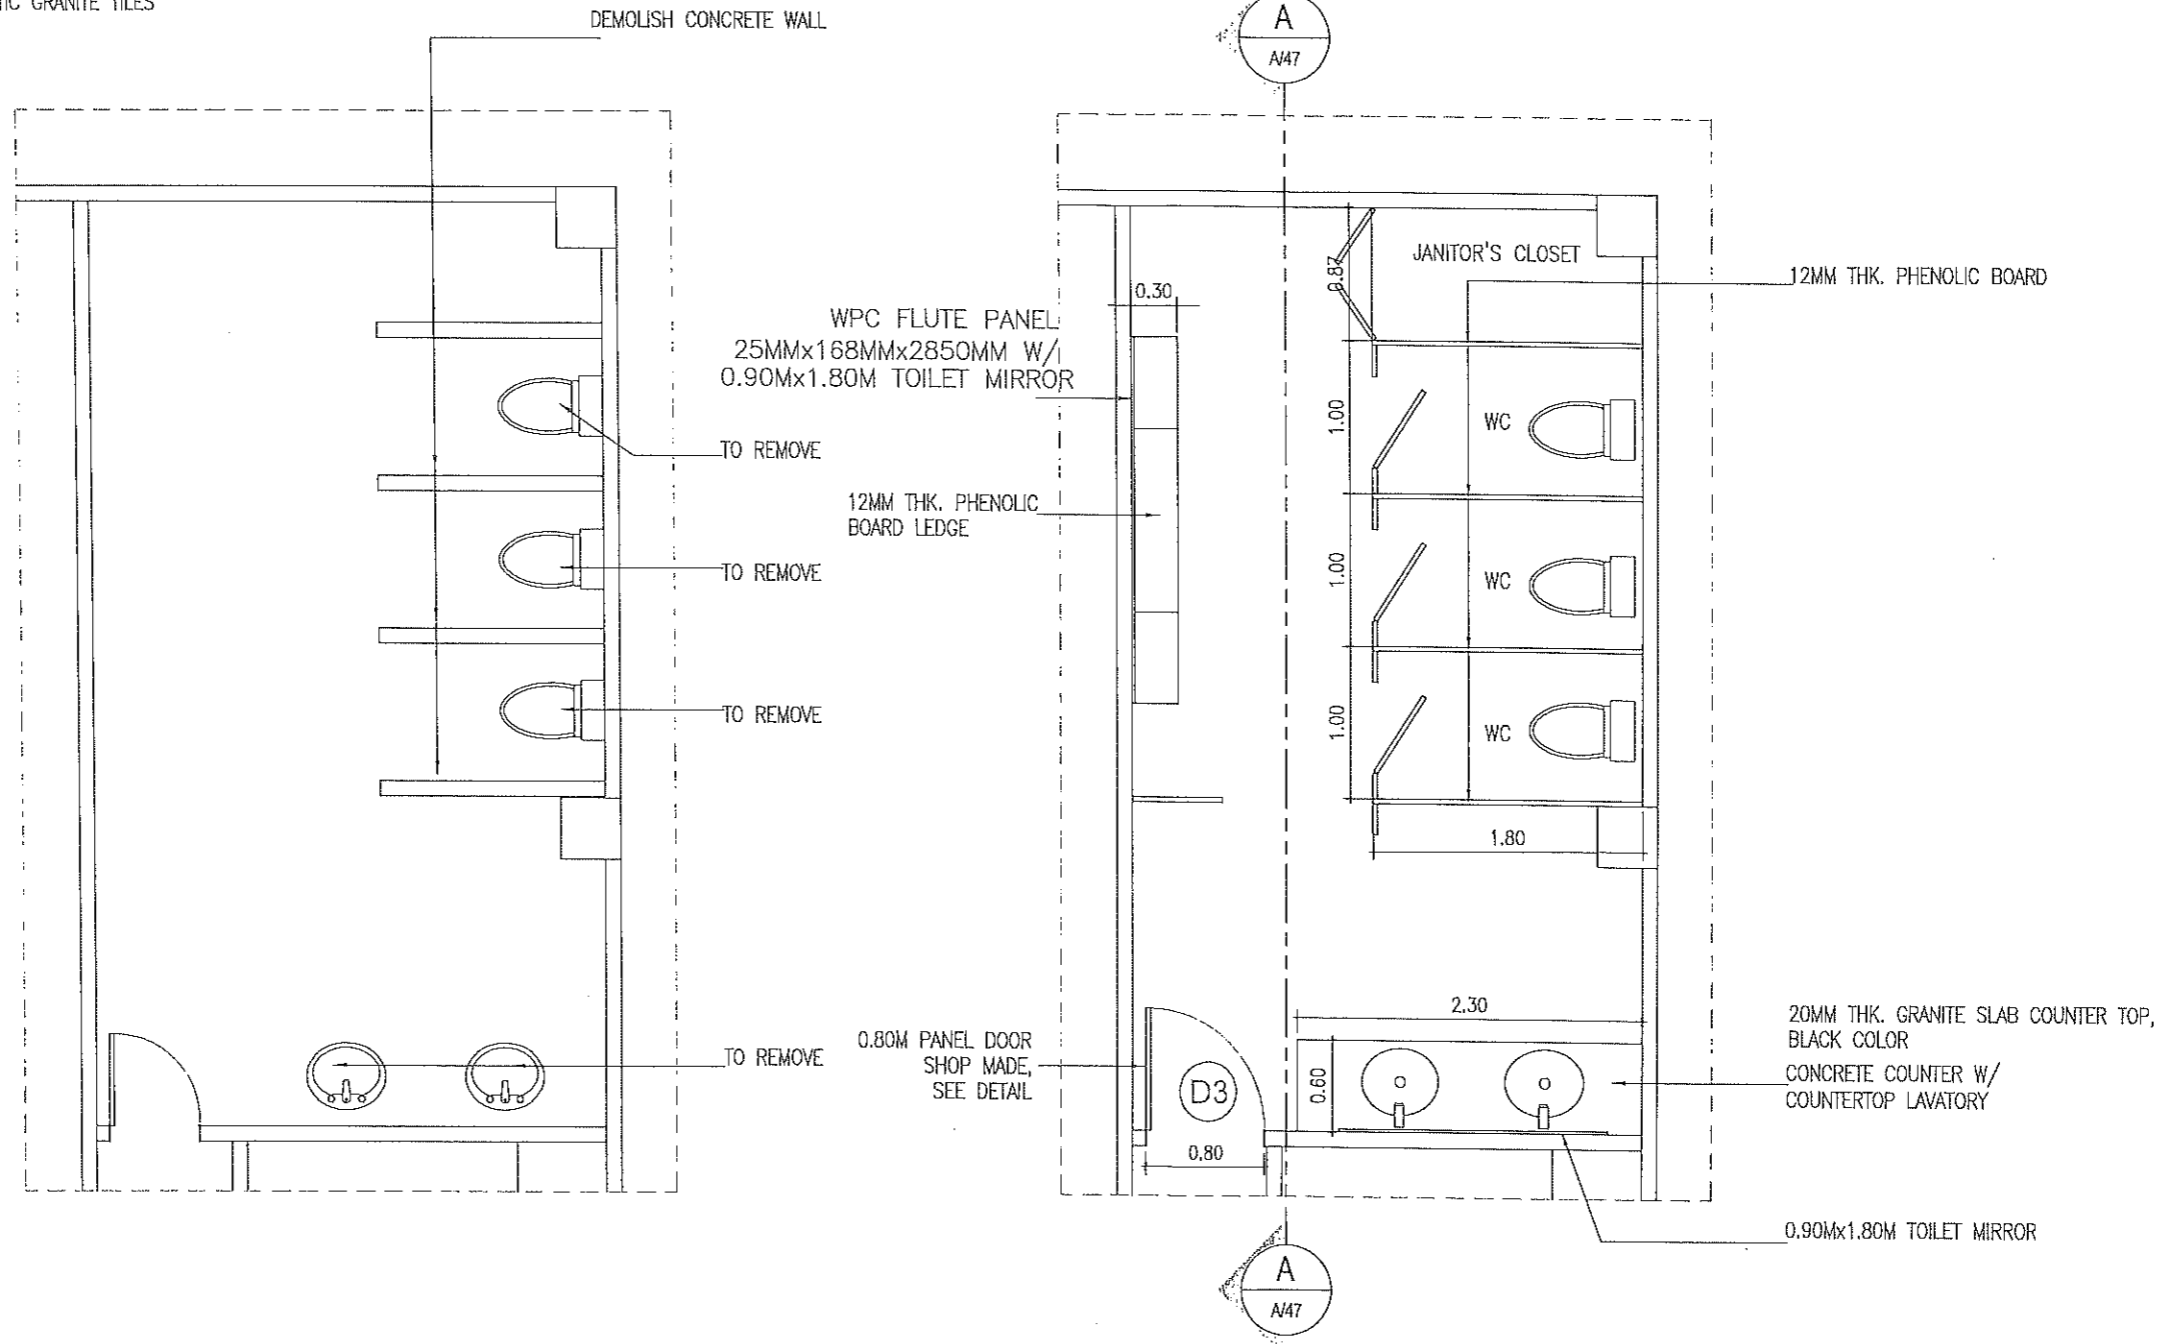

1 EXISTING FLOOR
A-44 SCALE 1:50

2 PROPOSED FLOOR PLAN
A-44 SCALE 1:50



REPUBLIC OF THE PHILIPPINES
PROVINCIAL ENGINEER'S OFFICE
SAN AGUSTIN, DIGOS CITY, DAVAO DEL SUR

PROJECT TITLE:
REPAIR /IMPROVEMENT OF SANGGUNIANG
PANLALAWIGAN BUILDING
LOCATION:
MATTI, DIGOS CITY, DAVAO DEL SUR

PREPARED BY:
[Signature]
REXIE GREY B. TABAY
ARCHITECT III

REVIEWED BY:
[Signature]
JOSEPH R. GONZALES
ENGINEER - III
PLANNING AND PROGRAMMING DIV. HEAD


RECOMMENDING APPROVAL:
[Signature]
LEONERL MARCH P. SUARIO
PROVINCIAL ENGINEER

APPROVED BY:
[Signature]
YVONNE ROÑA CAGAS
PROVINCIAL GOVERNOR

SHEET NO.:
A-44
44 79

60MMx60MM SYNTHETIC
GRANITE FLOOR TILES (NON-SKID)


30MMx60MM SYNTHETIC
GRANITE WALL TILES (GLAZED)

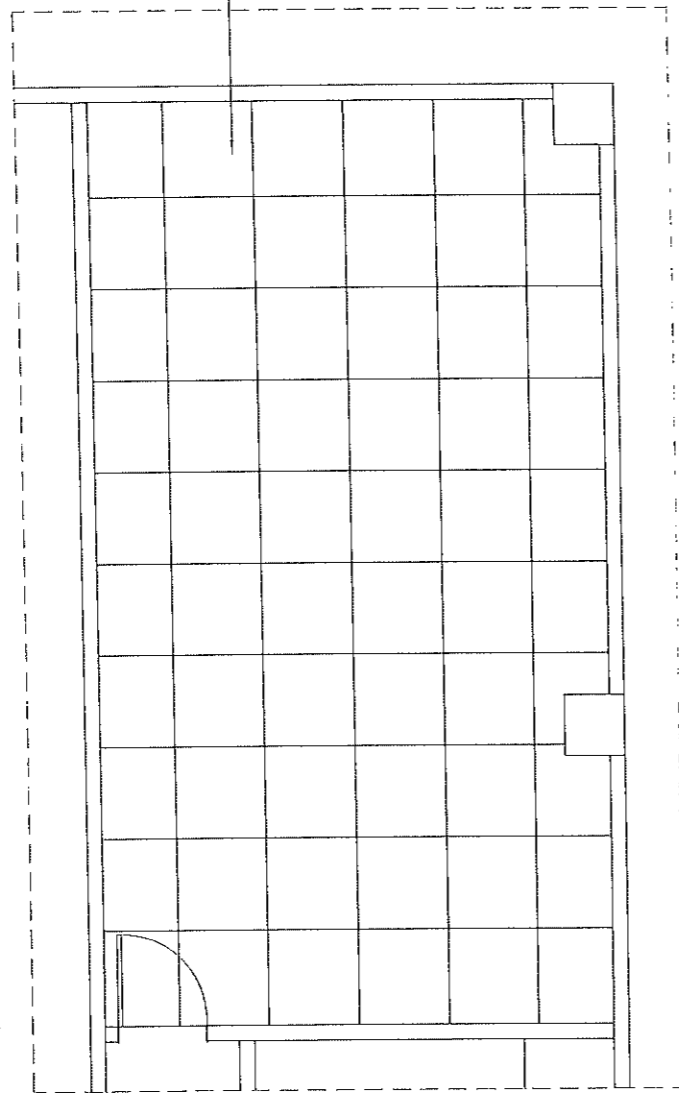

60MMx60MM GYPSUM
BOARD CEILING TILES

T5 LED COVELIGHT

5.0MM THK. MARINE
PLYWOOD CEILING
ON METAL FURRING
W/ CEILING CORNICE

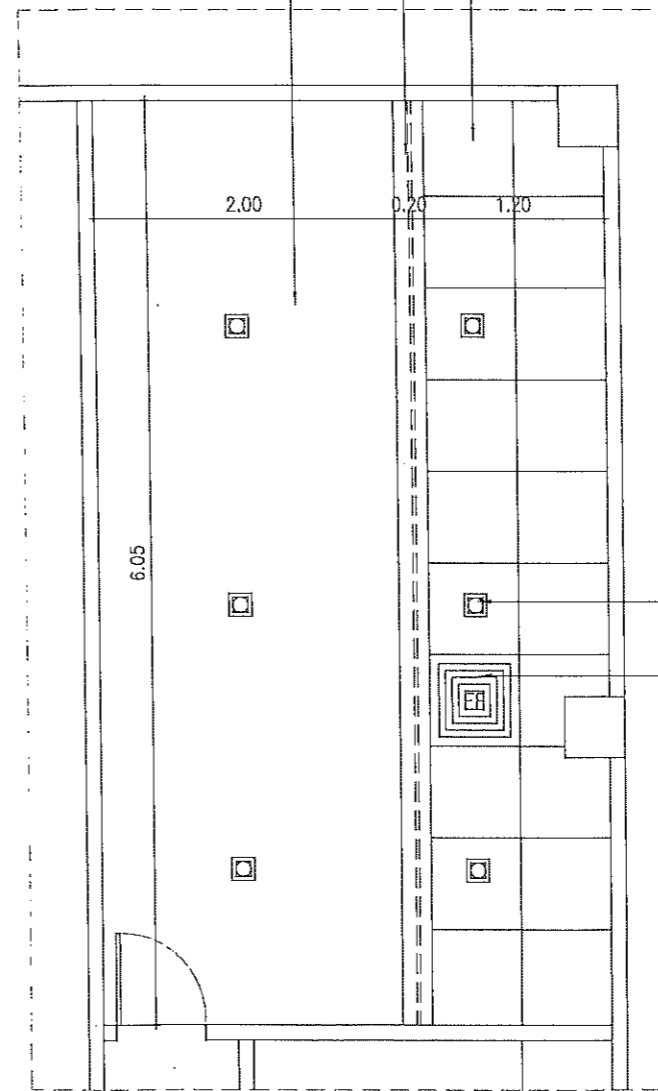

PINLIGHT
REFER TO ELECTRICAL

EXHAUST FAN

1 FLOOR TILE LAYOUT
A-45 SCALE 1:50

2 CEILING PLAN
A-45 SCALE 1:50



REPUBLIC OF THE PHILIPPINES
PROVINCIAL ENGINEER'S OFFICE
SAN AGUSTIN, DIGOS CITY, DAVAO DEL SUR

PROJECT TITLE:
REPAIR /IMPROVEMENT OF SANGGUNIANG
PANLALAWIGAN BUILDING
LOCATION:
MATTI, DIGOS CITY, DAVAO DEL SUR


PREPARED BY:
[Signature]
REX E GREY B. TABAY
ARCHITECT III

REVIEWED BY:
[Signature]
JOSEPH R. GONZALES
ENGINEER III
PLANNING AND PROGRAMMING DIV. HEAD

RECOMMENDING APPROVAL:
[Signature]
LEONERL MARGH P. SUARIO
PROVINCIAL ENGINEER


APPROVED BY:
[Signature]
YVONNE RONC CAGAS
PROVINCIAL GOVERNOR

SHEET NO.:
A-45
45 79

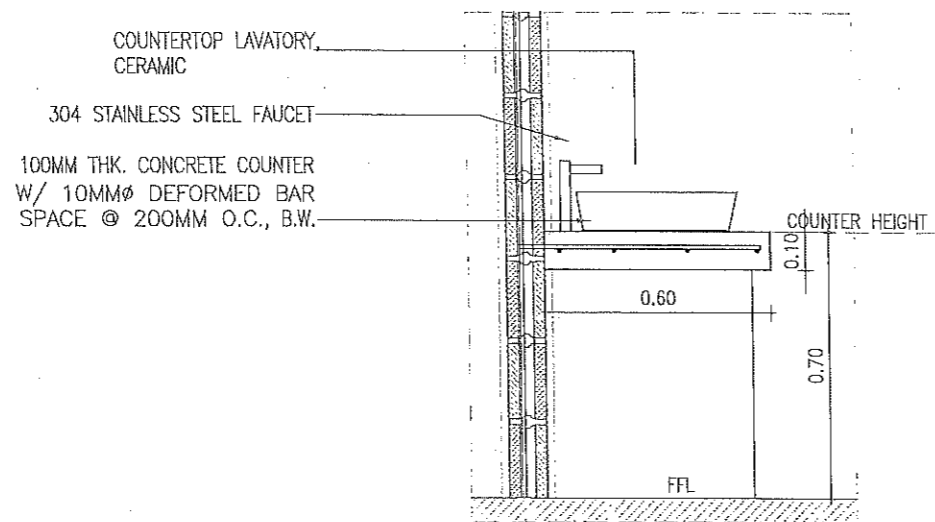


3 TYPICAL CONCRETE COUNTER DET.
A-46 SCALE 1:20M.

CERAMIC WATER CLOSET
(HCG, PHILIPPINE STANDARD,
AMERICAN STANDARD OR ITS EQUIVALENT)
(SUBJECT TO ARCHITECT'S APPROVAL)

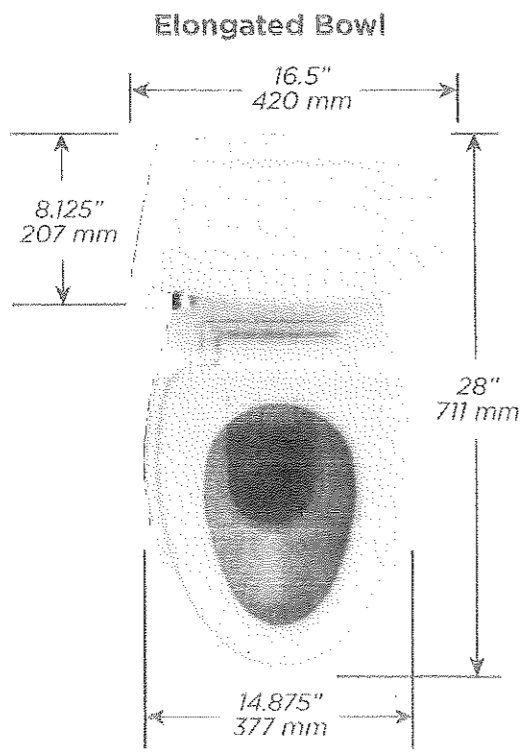


1 TYPICAL WATER CLOSET DET.
A-46

COUNTERTOP CERAMIC LAVATORY
(HCG, PHILIPPINE STANDARD,
AMERICAN STANDARD OR ITS EQUIVALENT)
(SUBJECT TO ARCHITECT'S APPROVAL)

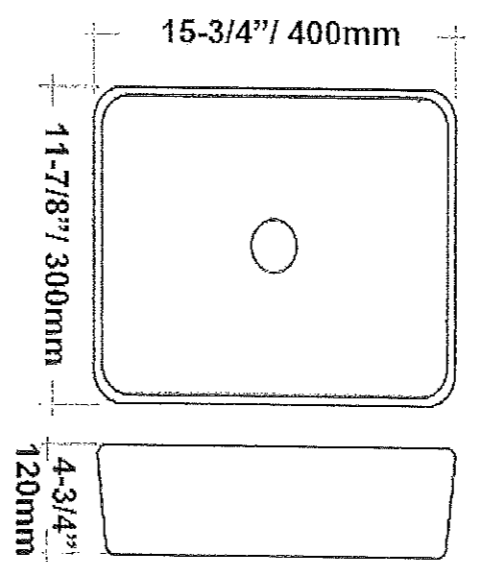


2 COUNTERTOP TYPICAL LAVATORY DETAIL
A-46

	REPUBLIC OF THE PHILIPPINES PROVINCIAL ENGINEER'S OFFICE SAN AGUSTIN, DIGOS CITY, DAVAO DEL SUR	PROJECT TITLE: REPAIR /IMPROVEMENT OF SANGGUNIANG PANLALAWIGAN BUILDING	PREPARED BY: 	REVIEWED BY: 	RECOMMENDING APPROVAL: 	APPROVED BY: 	SHEET NO.: A-46
		LOCATION: MATTI, DIGOS CITY, DAVAO DEL SUR	REXIE GREY B. TABAY ARCHITECT III	JOSEPH R. GONZALES ENGINEER III PLANNING AND PROGRAMMING DIV. HEAD	LEONERL MARCH P. SUARIO PROVINCIAL ENGINEER	YVONNE ROÑA CAGAS PROVINCIAL GOVERNOR	46 79

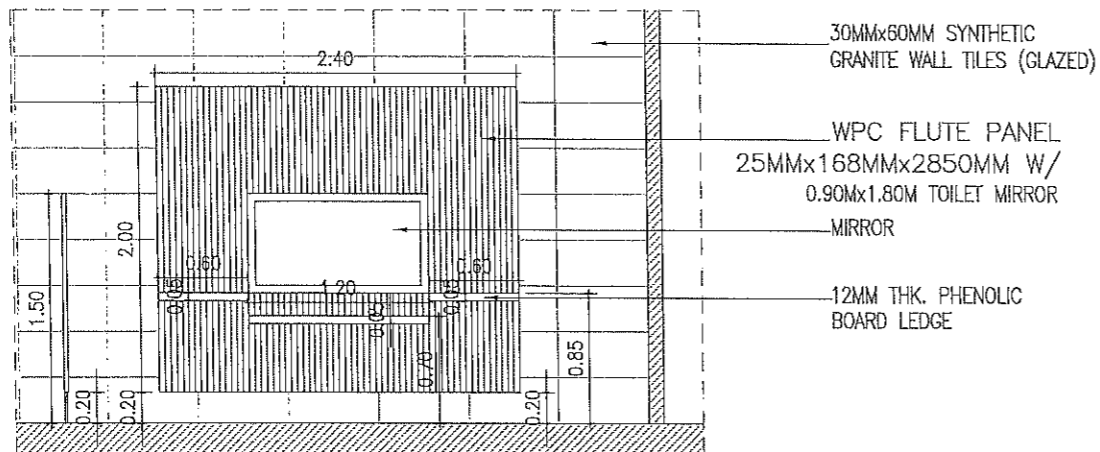


3 SECTION A-A
 SCALE 1:50M

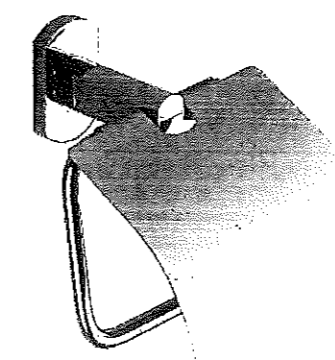


4 TOILET PAPER HOLDER-TYPICAL

304 STAINLESS STEEL FAUCET
 (SUBJECT TO ARCHITECT'S APPROVAL)

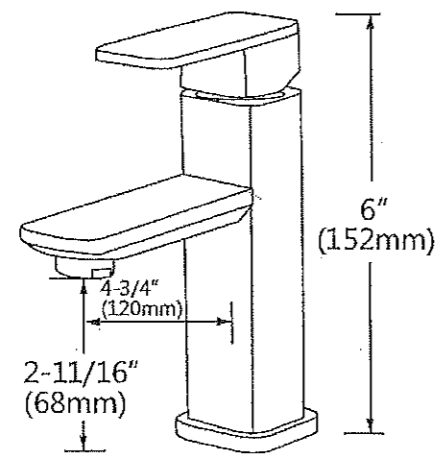

1 TYPICAL LAVATORY FAUCET DET.

WALL MOUNTED WATERLESS URINAL
 (SUBJECT TO ARCHITECT'S APPROVAL)

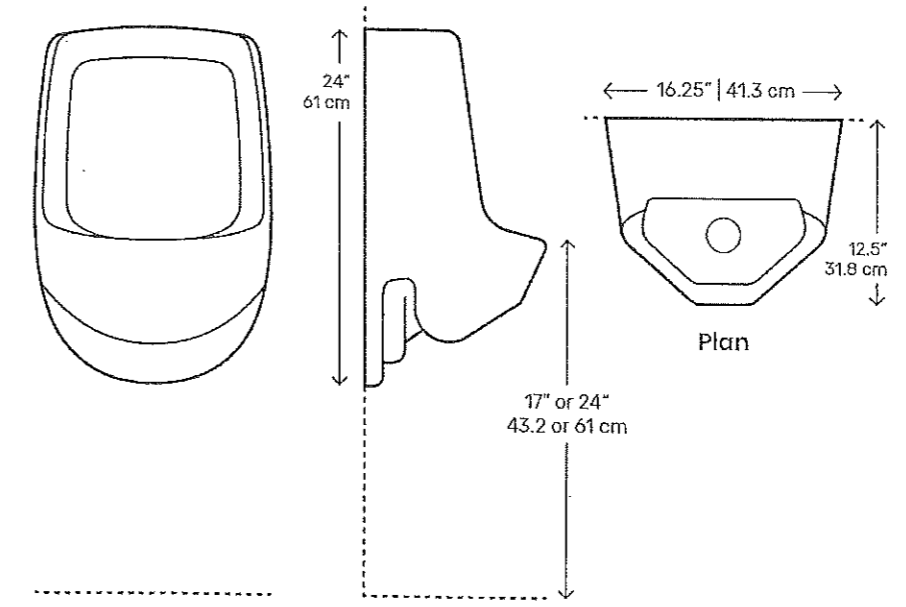

2 TYPICAL URINAL DET.



REPUBLIC OF THE PHILIPPINES
PROVINCIAL ENGINEER'S OFFICE
 SAN AGUSTIN, DIGOS CITY, DAVAO DEL SUR

PROJECT TITLE:
**REPAIR /IMPROVEMENT OF SANGGUNIANG
 PANLALAWIGAN BUILDING**

LOCATION:
 MATTI, DIGOS CITY, DAVAO DEL SUR


PREPARED BY:
[Signature]
REXIE GREY B. TAGAY
 ARCHITECT III

REVIEWED BY:
[Signature]
JOSUE R. GONZALES
 ENGINEER III
 PLANNING AND PROGRAMMING DIV. HEAD

RECOMMENDING APPROVAL:
[Signature]
LEONERL MARCH P. SUARIO
 PROVINCIAL ENGINEER

APPROVED BY:
[Signature]
YVONNE RORA CAGAS
 PROVINCIAL GOVERNOR

SHEET NO.:
A-47
 47 79

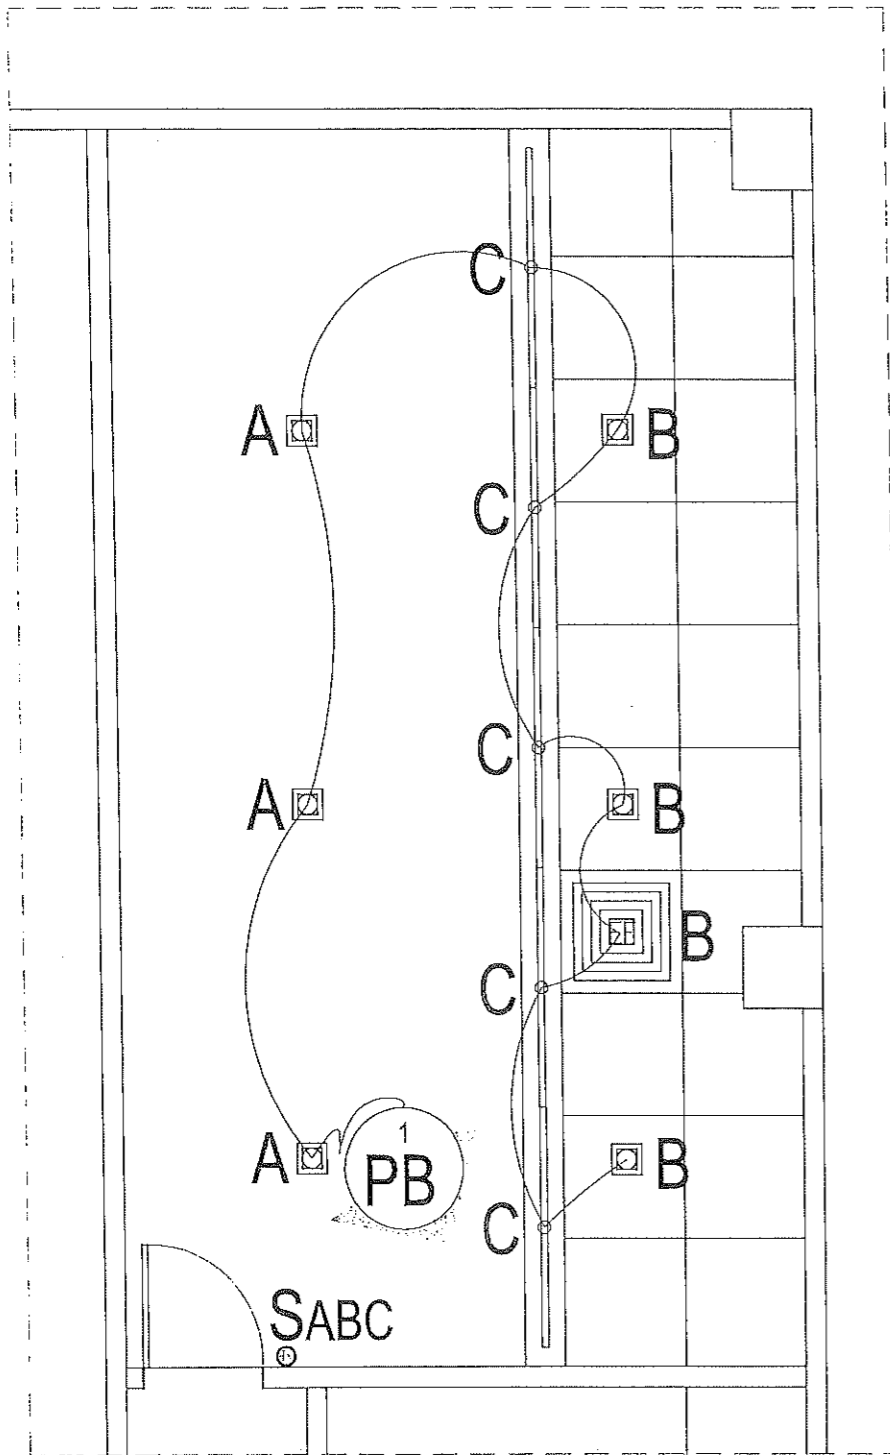






LOAD SCHEDULE :

CIRCUIT NO.	DESCRIPTION	QUANTITY	VOLTS	WATTS	AMPS	TRIP	CONDUCTOR SIZE	CONDUIT SIZE
PB 1	LIGHTING OUTLET	12	230	600	2.61	20 A	2- 3.5 mm ² THW Stranded Copper Wire , 1 - 2.0 mm ² THW Stranded Copper Wire	20 mm dia. uPVC

NOTE:

- CONNECT TO EXISTING PANEL BOARD FOR POWER SOURCE

 LEGEND:

-  6W LED PINLIGHT DOWNLIGHT RECESS TYPE E27 STANDARD SOCKET, BLACK SQUARE, COOL DAYLIGHT (15 x 15 cm)
-  16W T5 LED INTEGRATED TUBE, WARM WHITE (1173 x 24 x 32 mm)
-  12 INCH CEILING MOUNTED EXHAUST FAN
-  CIRCUIT HOMERUN (CONNECT TO EXISTING PANELBOARD)
-  THREE-GANG SWITCH WITH PLATE, FLUSH TYPE

1 TOILET - 3 LIGHTING LAYOUT
E-1 SCALE 1:50



REPUBLIC OF THE PHILIPPINES
PROVINCIAL ENGINEER'S OFFICE
SAN AGUSTIN, DIGOS CITY, DAVAO DEL SUR

PROJECT TITLE:
REPAIR /IMPROVEMENT OF SANGGUNIANG
PANLALAWIGAN BUILDING
LOCATION:
MATTI, DIGOS CITY, DAVAO DEL SUR

PREPARED BY:
Mary Flor L. Hectin
MARY FLOR L. HECTIN
ENGINEER I

REVIEWED BY:
Joseph R. Gonzales
JOSEPH R. GONZALES
ENGINEER - III
PLANNING AND PROGRAMMING DIV. HEAD

RECOMMENDING APPROVAL:
Leonerl March P. Suario
LEONERL MARCH P. SUARIO
PROVINCIAL ENGINEER


APPROVED BY:
Yvonne Roña Cagas
YVONNE ROÑA CAGAS
PROVINCIAL GOVERNOR

SHEET NO.:
E-1
48 79

TOILET - 4


 
 


MALE

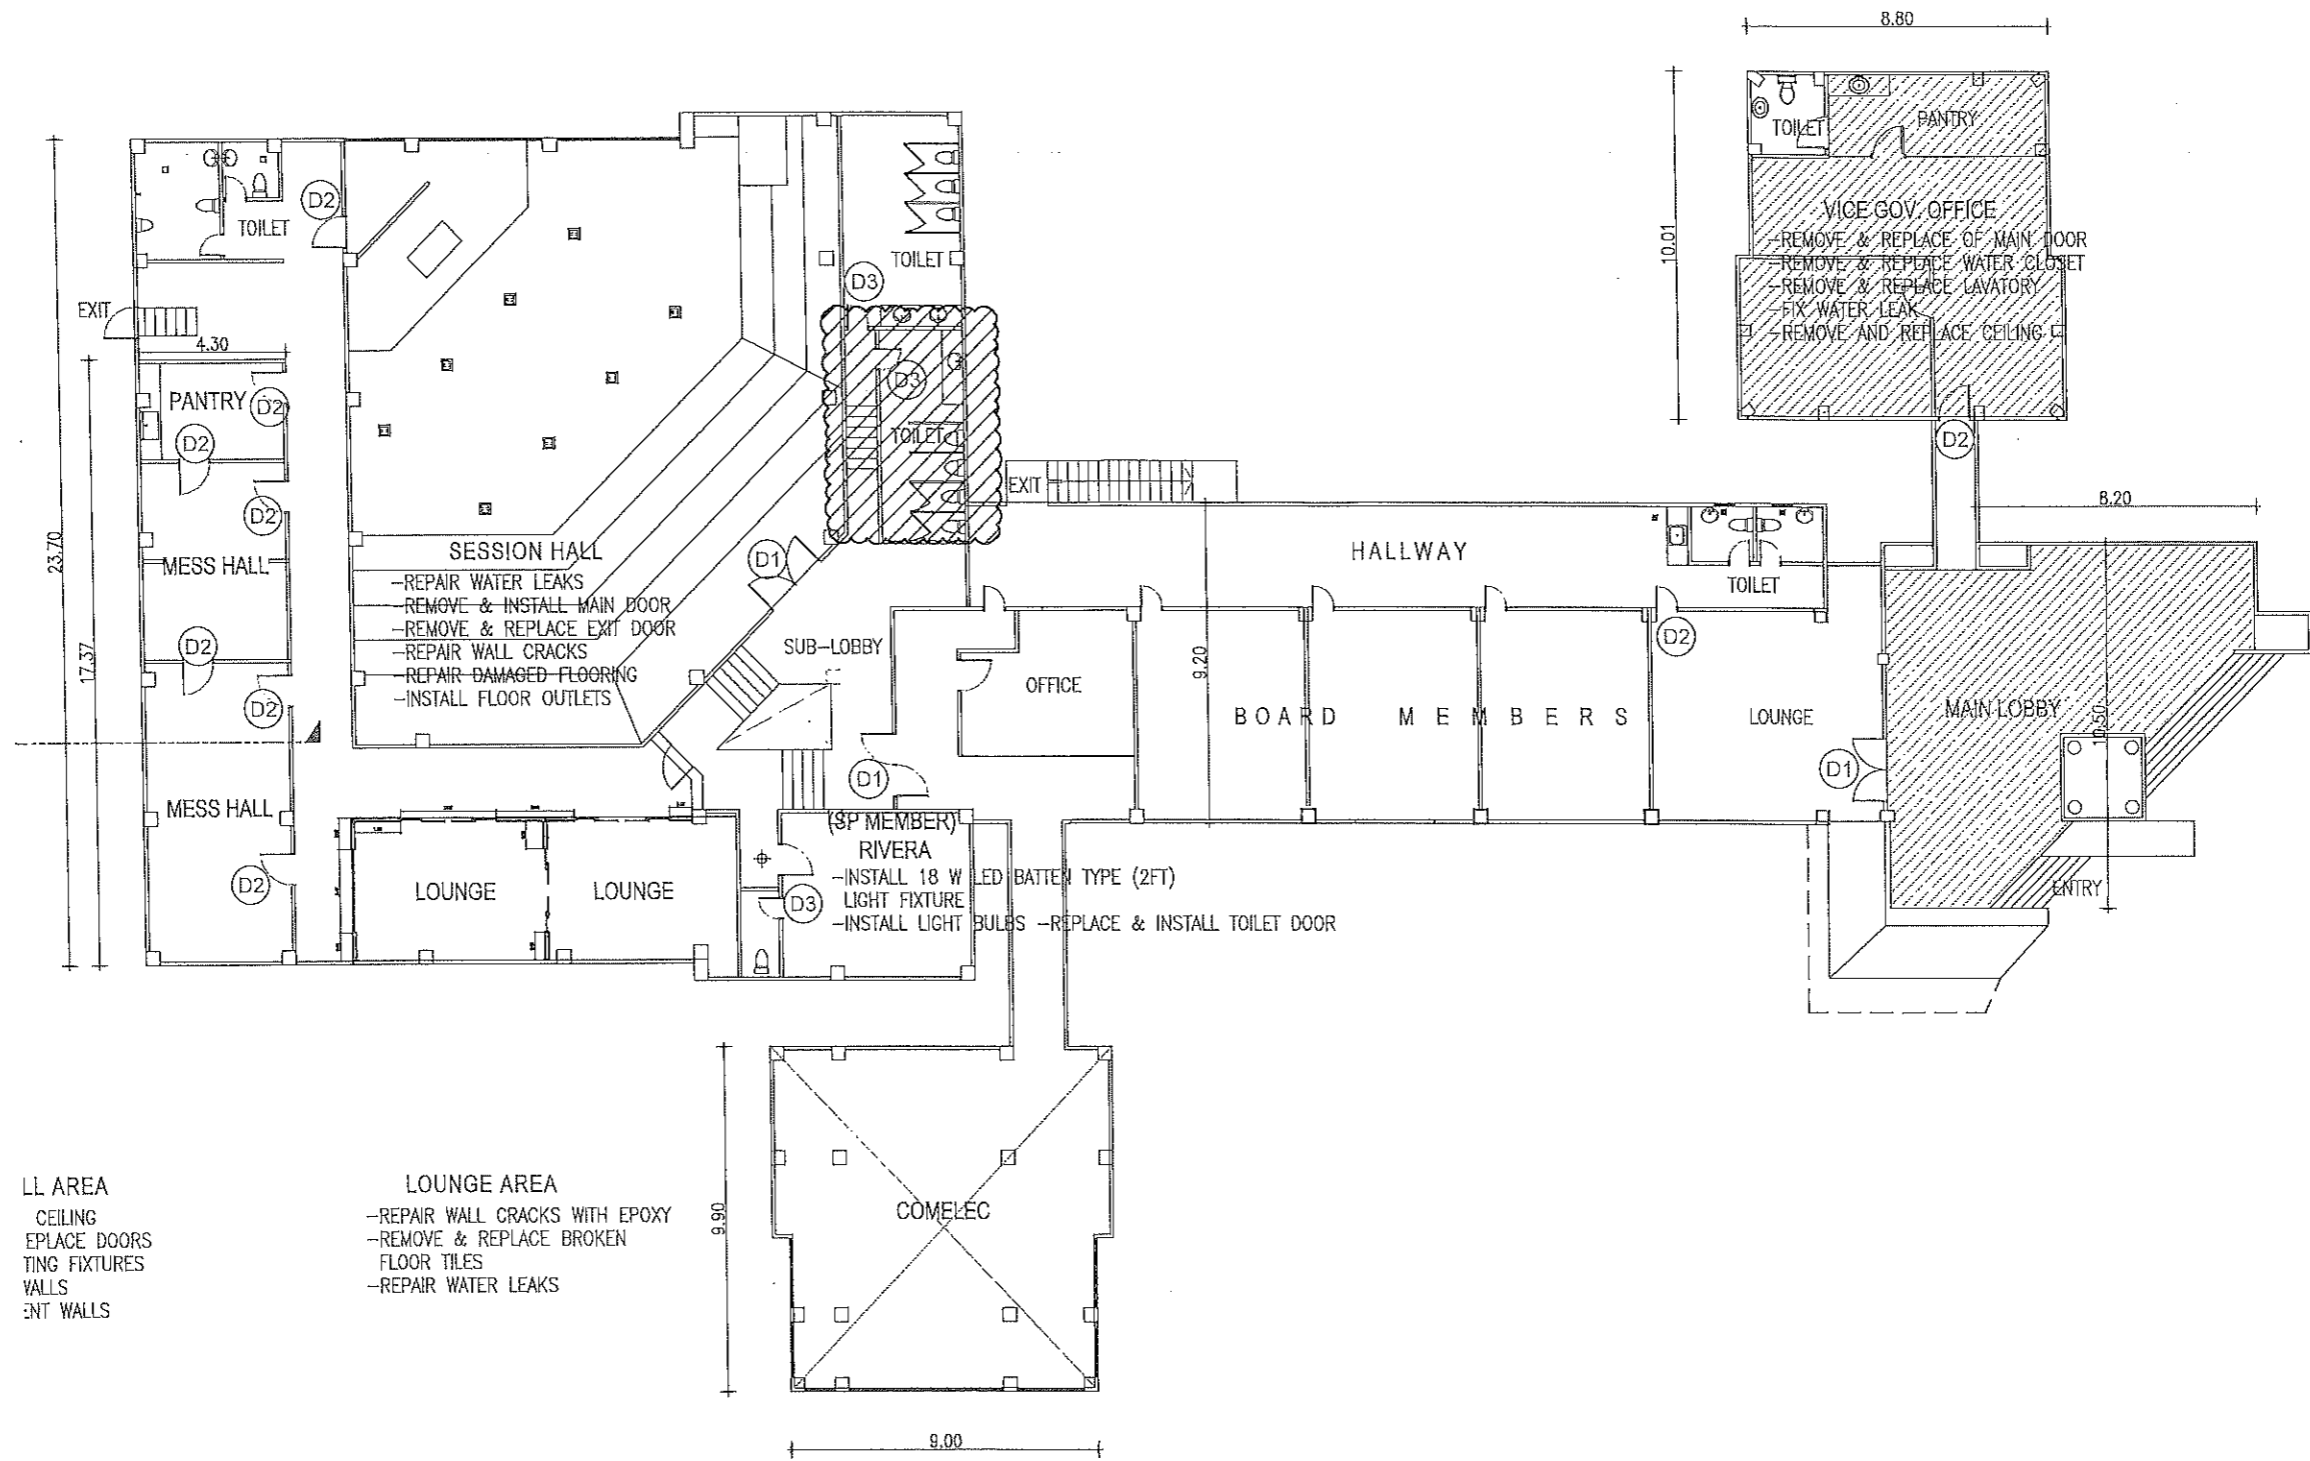
(@ 2ND FLOOR)



TOILET - 4
MALE TOILET (@ 2ND FLOOR)

1
 A-49


 <p>REPUBLIC OF THE PHILIPPINES PROVINCIAL ENGINEER'S OFFICE SAN AGUSTIN, DIGOS CITY, DAVAO DEL SUR</p>	PROJECT TITLE: REPAIR /IMPROVEMENT OF SANGGUNIANG PANLALAWIGAN BUILDING	PREPARED BY:  REXIE GREY B. TABAY ARCHITECT III	REVIEWED BY:  JOSEPH R. GONZALES ENGINEER - III PLANNING AND PROGRAMMING DIV. HEAD	RECOMMENDING APPROVAL:  LEONERL MARCH P. SUARIO PROVINCIAL ENGINEER	APPROVED BY:  YVONNE RONA CAGAS PROVINCIAL GOVERNOR	SHEET NO.: A-49 49 79
	LOCATION: MATTI, DIGOS CITY, DAVAO DEL SUR					

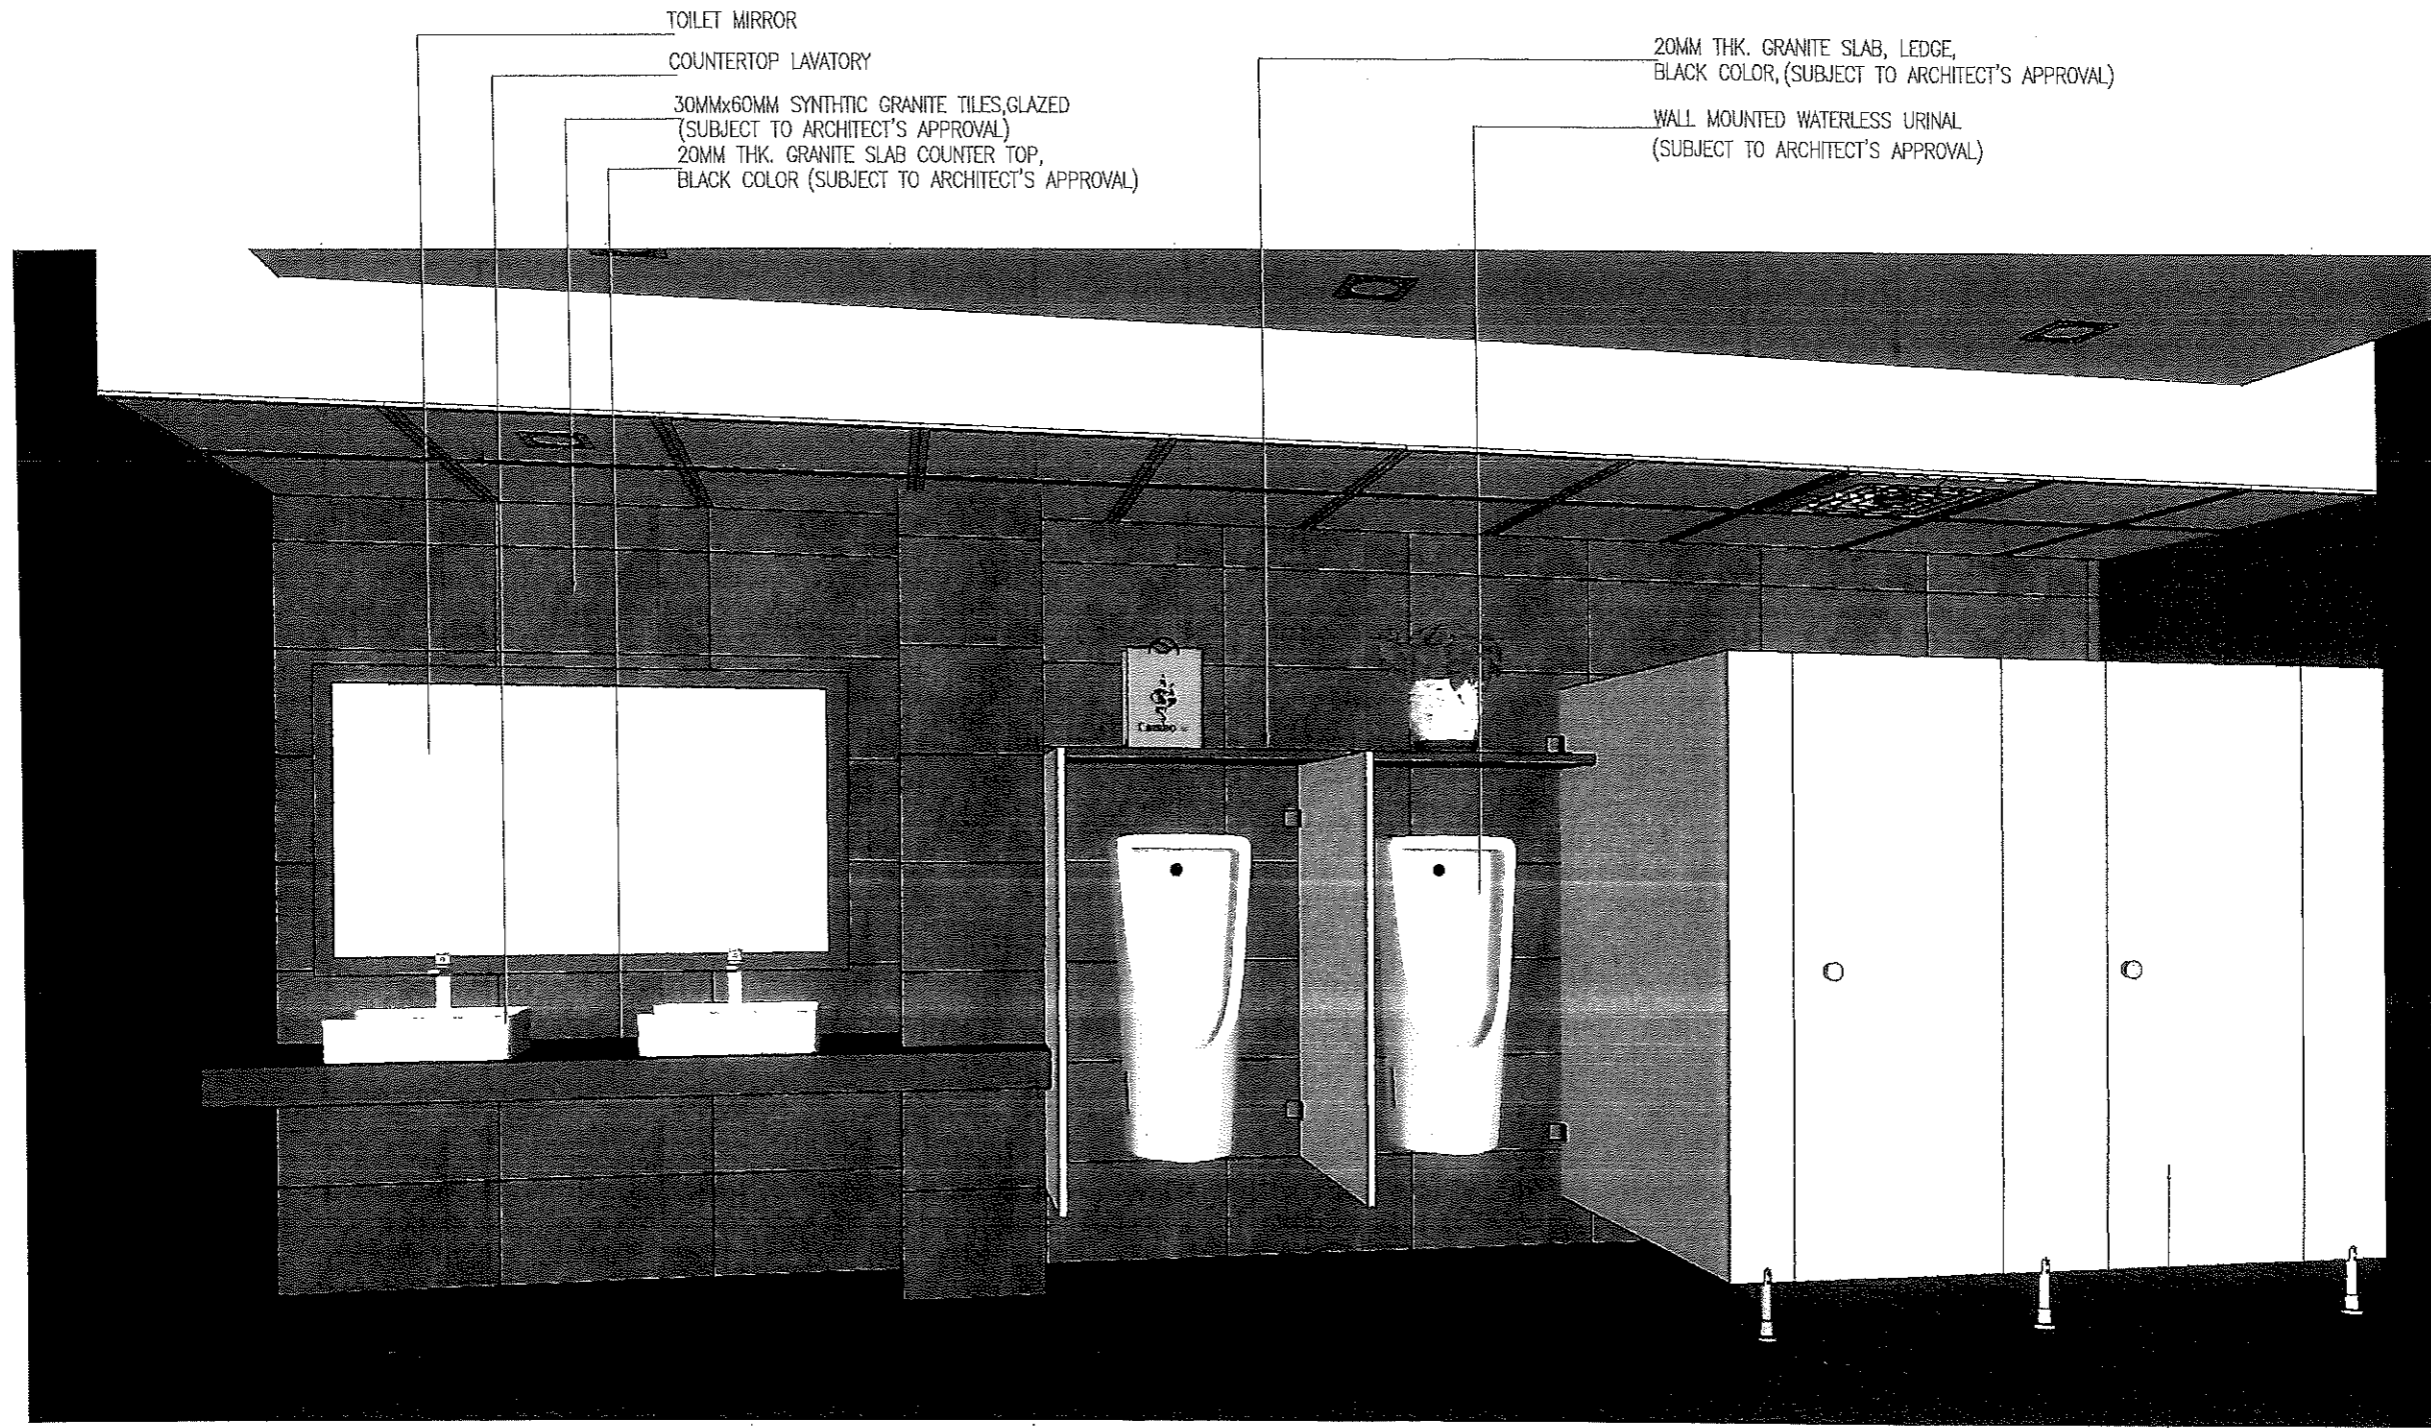

1
A-50

PERSPECTIVE

12MM THK. PHENOLIC BOARD

 <p>REPUBLIC OF THE PHILIPPINES PROVINCIAL ENGINEER'S OFFICE SAN AGUSTIN, DIGOS CITY, DAVAO DEL SUR</p>	<p>PROJECT TITLE: REPAIR /IMPROVEMENT OF SANGGUNIANG PANLALAWIGAN BUILDING</p>	<p>PREPARED BY: <i>[Signature]</i> REXIE GREY B. TABAY ARCHITECT III</p>	<p>REVIEWED BY: <i>[Signature]</i> JOSEPH R. GONZALES ENGINEER, III PLANNING AND PROGRAMMING DIV. HEAD</p>	<p>RECOMMENDING APPROVAL: <i>[Signature]</i> LEONERL MARCH P. SUARIO PROVINCIAL ENGINEER</p>	<p>APPROVED BY: <i>[Signature]</i> YVONNE ROMA CAGAS PROVINCIAL GOVERNOR</p>	<p>SHEET NO.:</p>
						<p>A-50</p> <p>50 79</p>

SCOPE OF WORKS


- DEMOLISH CONCRETE CUBICLE WALL
- REMOVE FLOOR AND WALL TILES
- REPAINT WALLS
- INSTALL CEILING
- INSTALL CONCRETE LAVATORY COUNTER
- INSTALL PHENOLIC BOARD CUBICLE PARTITIONS
- REMOVE AND REPLACE LAVATORY
- INSTALL MIRROR, AND WATER CLOSET WITH BIDET,
- INSTALL TOILET PAPER HOLDER (STAINLESS STEEL)
- INSTALL EXHAUST FAN
- INSTALL PANEL DOOR (0.80M WIDTH)
- INSTALL 60MMx60MM SYNTHETIC GRANITE TILES,FLOOR
- INSTALL 30MMx60MM SYNTHETIC GRANITE GLAZED TILES,WALLS

TOILET FIXTURES SPECIFICATIONS :

- WATER CLOSET
- LAVATORY
- LAVATORY FAUCET
- SINK FAUCET
- WALL FAUCET
- BIDET
- TOILET PAPER HOLDER
- URINAL
- TOILET MIRROR
- 1.6GPF WATER CLOSET,LEVER TYPE FLUSH.
- COUNTERTOP CERAMIC LAVATORY (SEE DETAIL)
- 304 STAINLESS STEEL FAUCET
- 304 STAINLESS STEEL GOOSENECK FAUCET
- 304 STAINLESS STEEL WALL FAUCET
- 304 STAINLESS BIDET
- 304 STAINLESS TOILET PAPER HOLDER
- WATERLESS WALL MOUNTED URINAL
- 6.0MM THK TOILET MIRROR


NOTE :

ALL FINISHING MATERIALS AND ITEMS TO BE USED SHALL BE IN ACCORDANCE TO SPECIFICATIONS AND SUBJECT TO THE APPROVAL OF ARCHITECT PRIOR INSTALLATION.

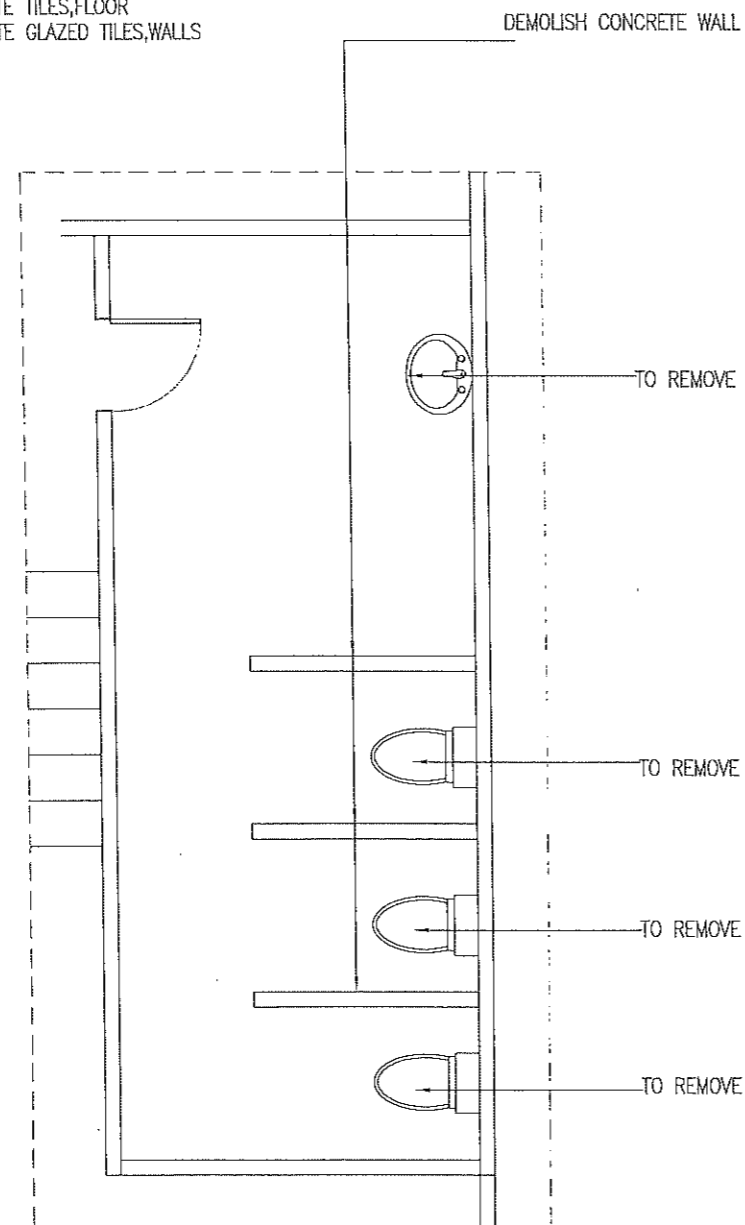

1 EXISTING FLOOR
A-45 SCALE 1:50

(0.80M) PANEL DOOR SHOP MADE, SEE DOORS DETAIL AND DESIGN

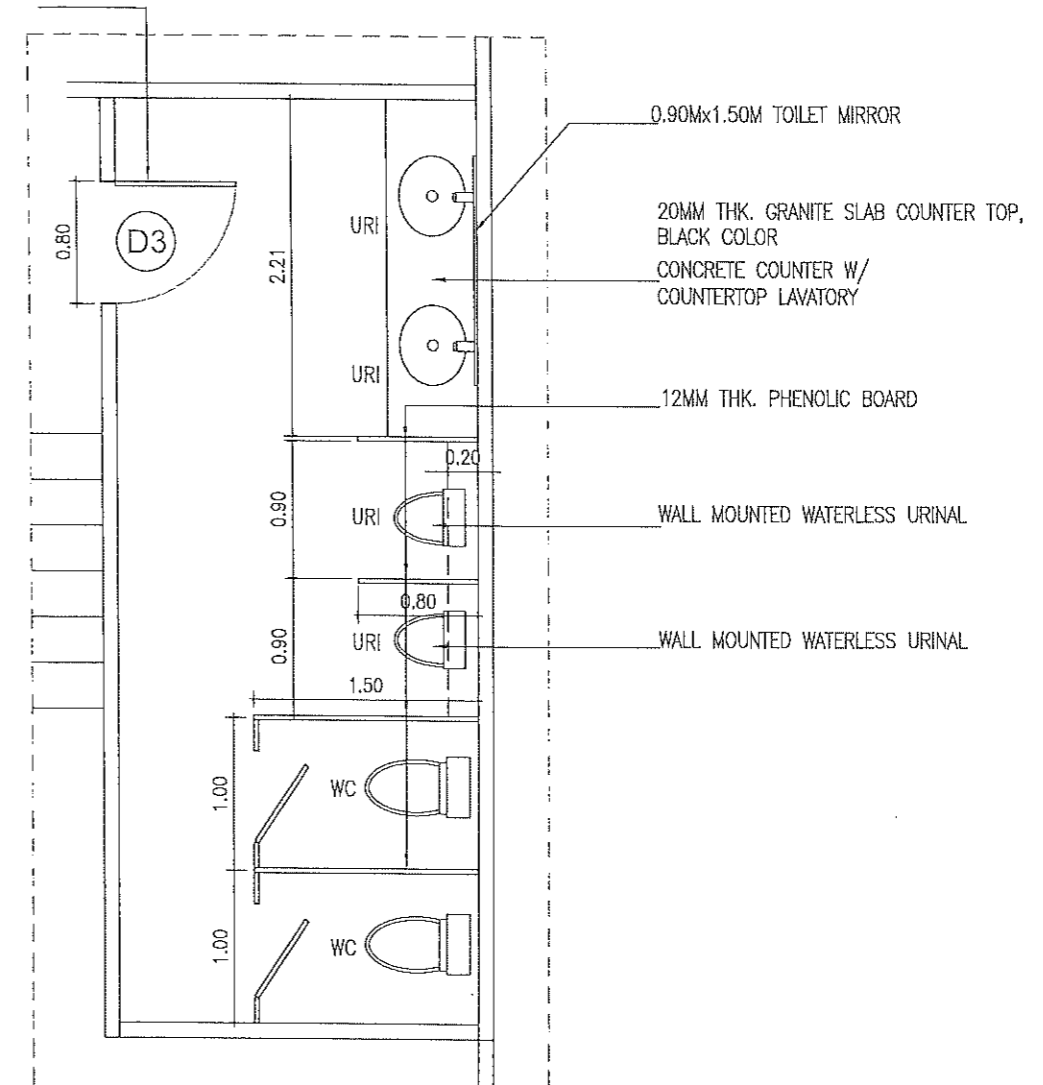

2 PROPOSED FLOOR PLAN
A-45 SCALE 1:50



REPUBLIC OF THE PHILIPPINES
PROVINCIAL ENGINEER'S OFFICE
SAN AGUSTIN, DIGOS CITY, DAVAO DEL SUR

PROJECT TITLE:
REPAIR /IMPROVEMENT OF SANGGUNIANG
PANLALAWIGAN BUILDING
LOCATION:
MATTI, DIGOS CITY, DAVAO DEL SUR

PREPARED BY:
[Signature]
REXIE GREY B. TABAY
ARCHITECT III

REVIEWED BY:
[Signature]
JOSEPH R. GONZALES
ENGINEER - III
PLANNING AND PROGRAMMING DIV. HEAD


RECOMMENDING APPROVAL:
[Signature]
LEONERL MARCH P. SUARIO
PROVINCIAL ENGINEER

APPROVED BY:
[Signature]
YVONNE ROÑA CAGAS
PROVINCIAL GOVERNOR

SHEET NO.:
A-51
51 79


60MMx60MM SYNTHETIC
GRANITE FLOOR TILES (NON-SKID)

30MMx60MM SYNTHETIC
GRANITE WALL TILES (GLAZED)
(SUBJECT TO ARCHITECT'S APPROVAL)

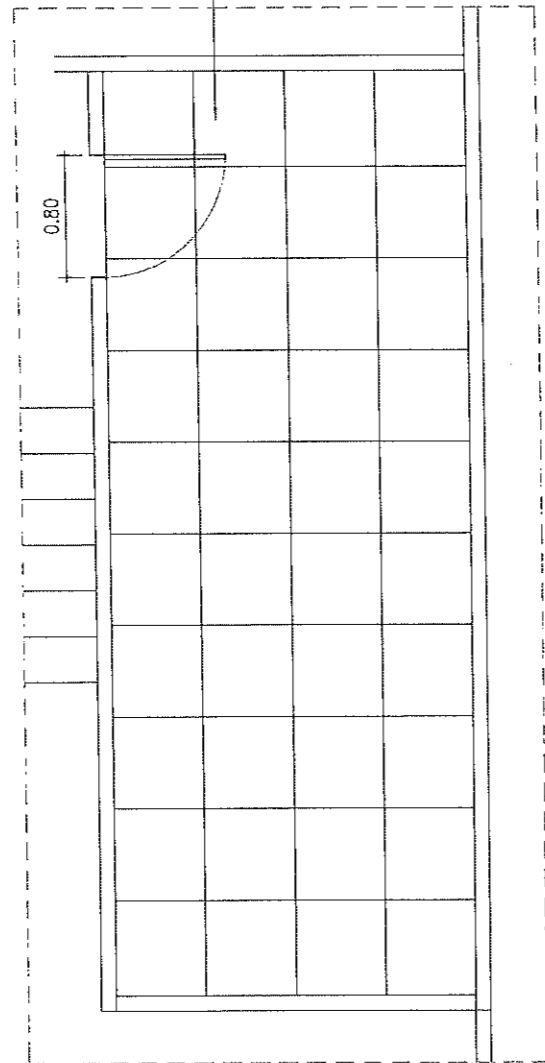

600MMx600MM GYPSUM
BOARD CEILING TILES

5.0MM THK. MARINE
PLYWOOD CEILING
ON METAL FURRING
W/ CEILING CORNICE

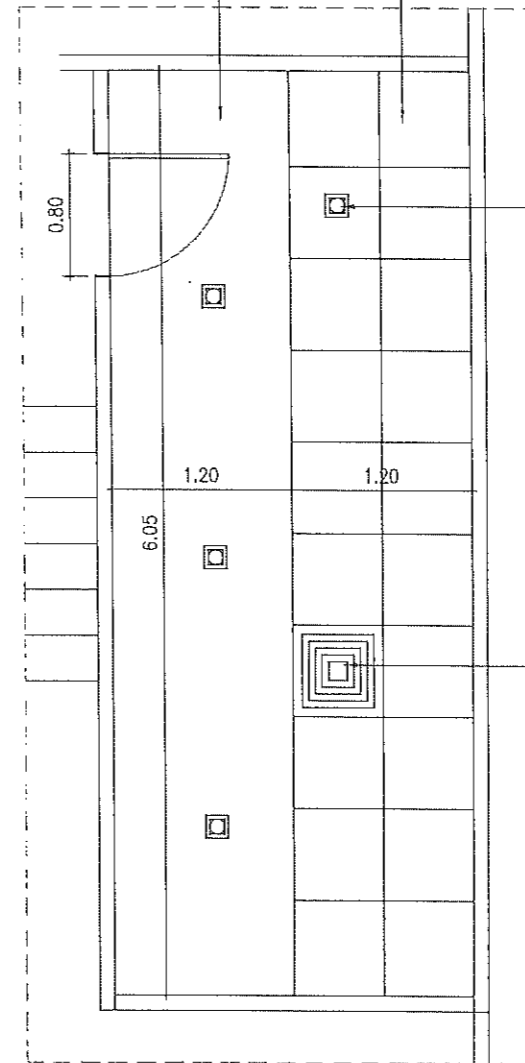

PINLIGHT
REFER TO ELECTRICAL

EXHAUST FAN

1 FLOOR TILE LAYOUT
SCALE 1:50

2 CEILING PLAN
SCALE 1:50



REPUBLIC OF THE PHILIPPINES
PROVINCIAL ENGINEER'S OFFICE
SAN AGUSTIN, DIGOS CITY, DAVAO DEL SUR

PROJECT TITLE:
**REPAIR /IMPROVEMENT OF SANGGUNIANG
PANLALAWIGAN BUILDING**

LOCATION:
MATTI, DIGOS CITY, DAVAO DEL SUR


PREPARED BY:
[Signature]
REXE GREY B. TABAY
ARCHITECT III

REVIEWED BY:
[Signature]
JOSEPH R. GONZALES
ENGINEER - II
PLANNING AND PROGRAMMING DIV. HEAD

RECOMMENDING APPROVAL:
[Signature]
LEONERL MARCH P. SUARIO
PROVINCIAL ENGINEER


APPROVED BY:
[Signature]
YVONNE ROÑA CAGAS
PROVINCIAL GOVERNOR

SHEET NO.:
A-52
52 79

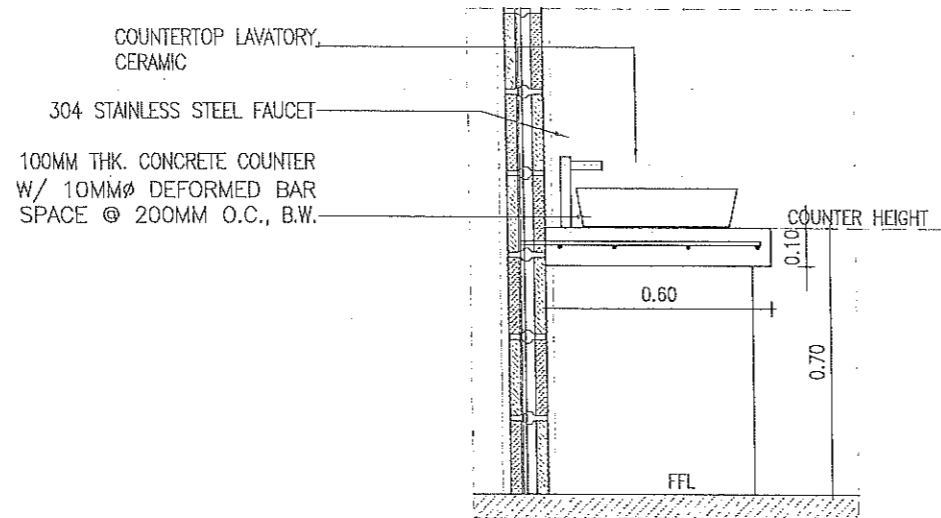


3 TYPICAL CONCRETE COUNTER DET.
 A-53 SCALE 1:20M.

CERAMIC WATER CLOSET
 (HCG, PHILIPPINE STANDARD,
 AMERICAN STANDARD OR ITS EQUIVALENT)
 (SUBJECT TO ARCHITECT'S APPROVAL)

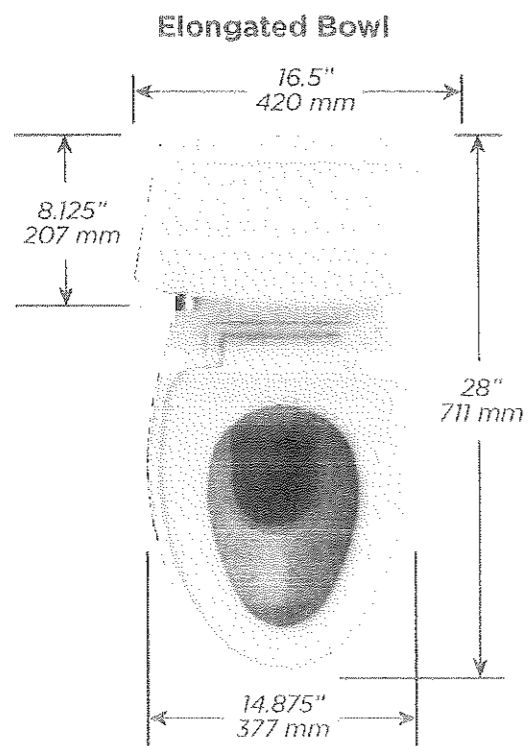

1 TYPICAL WATER CLOSET DET.
 A-53

COUNTERTOP CERAMIC LAVATORY
 (HCG, PHILIPPINE STANDARD,
 AMERICAN STANDARD OR ITS EQUIVALENT)
 (SUBJECT TO ARCHITECT'S APPROVAL)

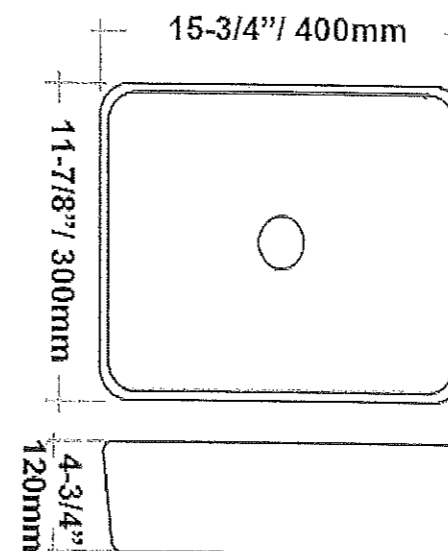

2 COUNTERTOP TYPICAL LAVATORY DETAIL
 A-53



REPUBLIC OF THE PHILIPPINES
 PROVINCIAL ENGINEER'S OFFICE
 SAN AGUSTIN, DIGOS CITY, DAVAO DEL SUR

PROJECT TITLE:
 REPAIR /IMPROVEMENT OF SANGGUNIANG
 PANLALAWIGAN BUILDING
 LOCATION:
 MATTI, DIGOS CITY, DAVAO DEL SUR


PREPARED BY:
[Signature]
 REXIE GREY B. TABAY
 ARCHITECT III

REVIEWED BY:
[Signature]
 JOSEPH R. GONZALES
 ENGINEER - III
 PLANNING AND PROGRAMMING DIV. HEAD

RECOMMENDING APPROVAL:
[Signature]
 LEONERL MARCH P. SUARIO
 PROVINCIAL ENGINEER


APPROVED BY:
[Signature]
 YVONNE ROMA CAGAS
 PROVINCIAL GOVERNOR

SHEET NO.:
 A-53
 53 79

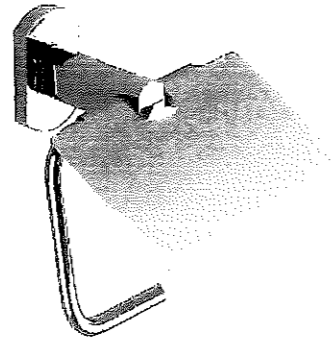


3 TOILET PAPER HOLDER-TYPICAL
A-54

304 STAINLESS STEEL FAUCET
(SUBJECT TO ARCHITECT'S APPROVAL)

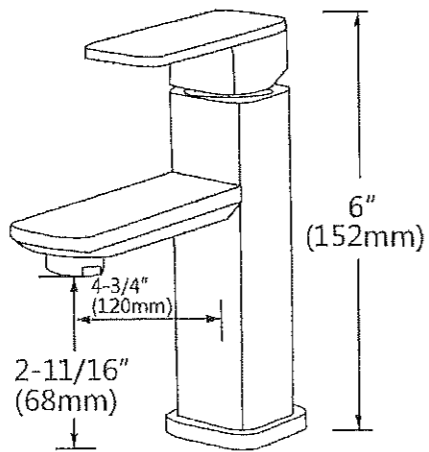

1 TYPICAL LAVATORY FAUCET DET.
A-54

WALL MOUNTED WATERLESS URINAL
(SUBJECT TO ARCHITECT'S APPROVAL)

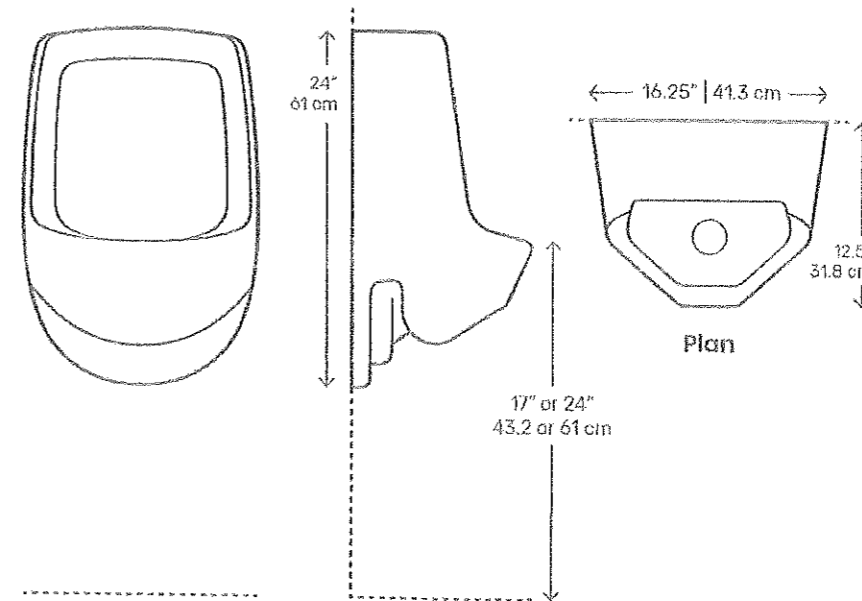

2 TYPICAL URINAL DET.
A-54



REPUBLIC OF THE PHILIPPINES
PROVINCIAL ENGINEER'S OFFICE
SAN AGUSTIN, DIGOS CITY, DAVAO DEL SUR

PROJECT TITLE:
REPAIR /IMPROVEMENT OF SANGGUNIANG
PANLALAWIGAN BUILDING
LOCATION:
MATTI, DIGOS CITY, DAVAO DEL SUR


PREPARED BY:
[Signature]
REXIE GREY B. TABAY
ARCHITECT III

REVIEWED BY:
[Signature]
JOSEPH R. GONZALES
ENGINEER - III
PLANNING AND PROGRAMMING DIV. HEAD

RECOMMENDING APPROVAL:
[Signature]
LEONERL MARCH P. SUARIO
PROVINCIAL ENGINEER

APPROVED BY:
[Signature]
YVONNE ROÑA CAGAS
PROVINCIAL GOVERNOR

SHEET NO.:
A-54
54 79

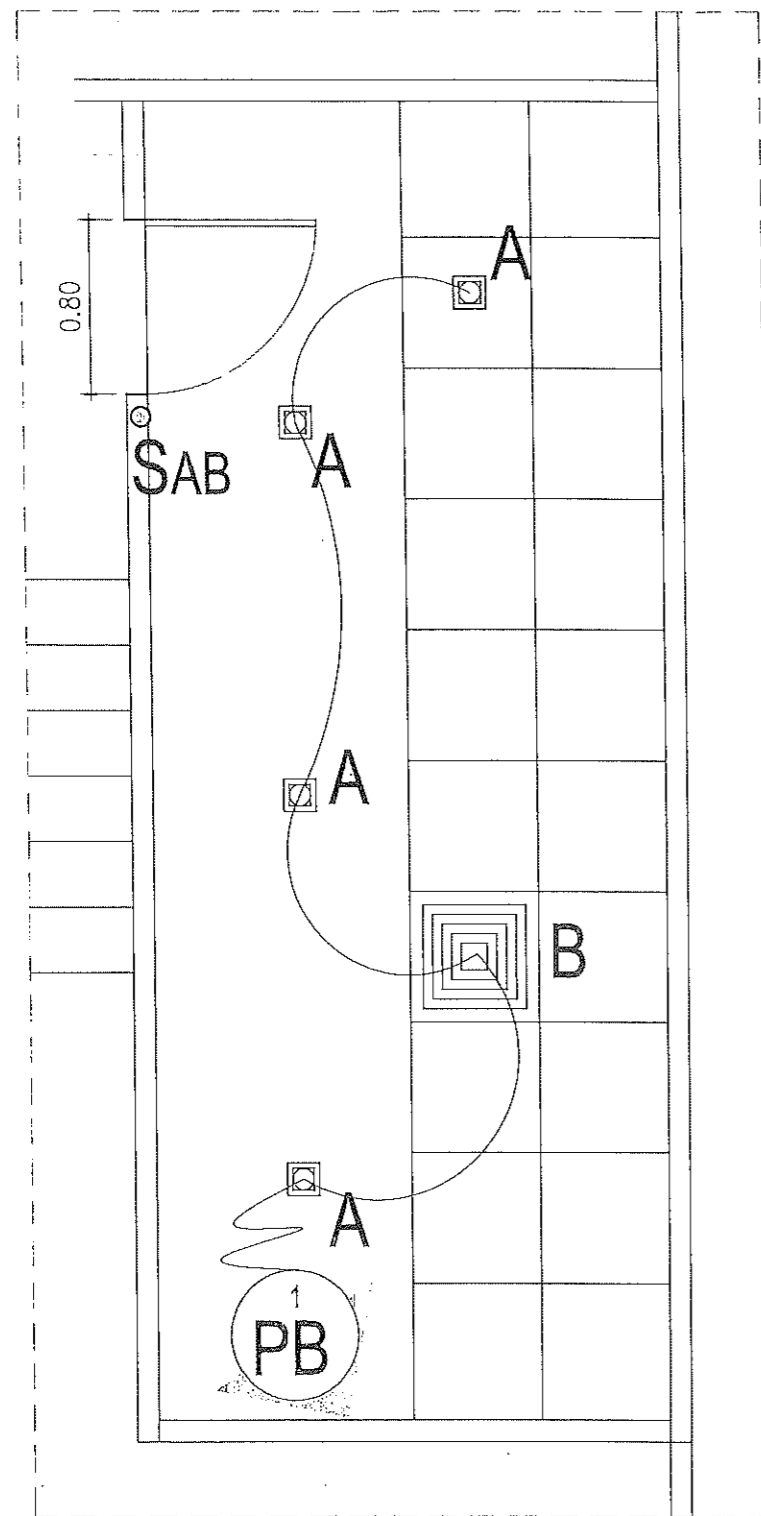





LOAD SCHEDULE :

CIRCUIT NO.	DESCRIPTION	QUANTITY	VOLTS	WATTS	AMPS	TRIP	CONDUCTOR SIZE	CONDUIT SIZE
PB 1	LIGHTING OUTLET	5	230	250	1.09	20 A	2- 3.5 mm ² THW Stranded Copper Wire , 1 - 2.0 mm ² THW Stranded Copper Wire	20 mm dia. uPVC

NOTE:

- CONNECT TO EXISTING PANEL BOARD FOR POWER SOURCE

 LEGEND:


-  6W LED PINLIGHT DOWNLIGHT RECESS TYPE E27 STANDARD SOCKET, BLACK SQUARE, COOL DAYLIGHT (15 x 15 cm)
-  12 INCH CEILING MOUNTED EXHAUST FAN
-  CIRCUIT HOMERUN (CONNECT TO EXISTING PANELBOARD)
-  TWO-GANG SWITCH WITH PLATE, FLUSH TYPE


1
TOILET - 4 LIGHTING LAYOUT
 E-1 SCALE 1:50





REPUBLIC OF THE PHILIPPINES
PROVINCIAL ENGINEER'S OFFICE
 SAN AGUSTIN, DIGOS CITY, DAVAO DEL SUR

 PROJECT TITLE:
 REPAIR /IMPROVEMENT OF SANGGUNIANG
 PANLALAWIGAN BUILDING
 LOCATION:
 MATTI, DIGOS CITY, DAVAO DEL SUR

PREPARED BY:

  MARY FLOR L. HECTIN
 ENGINEER I

 REVIEWED BY:

 JOSEPH R. GONZALES
 ENGINEER III
 PLANNING AND PROGRAMMING DIV. HEAD


RECOMMENDING APPROVAL:

 LEONERL MARCH P. SUARIO
 PROVINCIAL ENGINEER

APPROVED BY:

 YVONNE ROÑA CAGAS
 PROVINCIAL GOVERNOR


SHEET NO.:
 E-1
 55 79

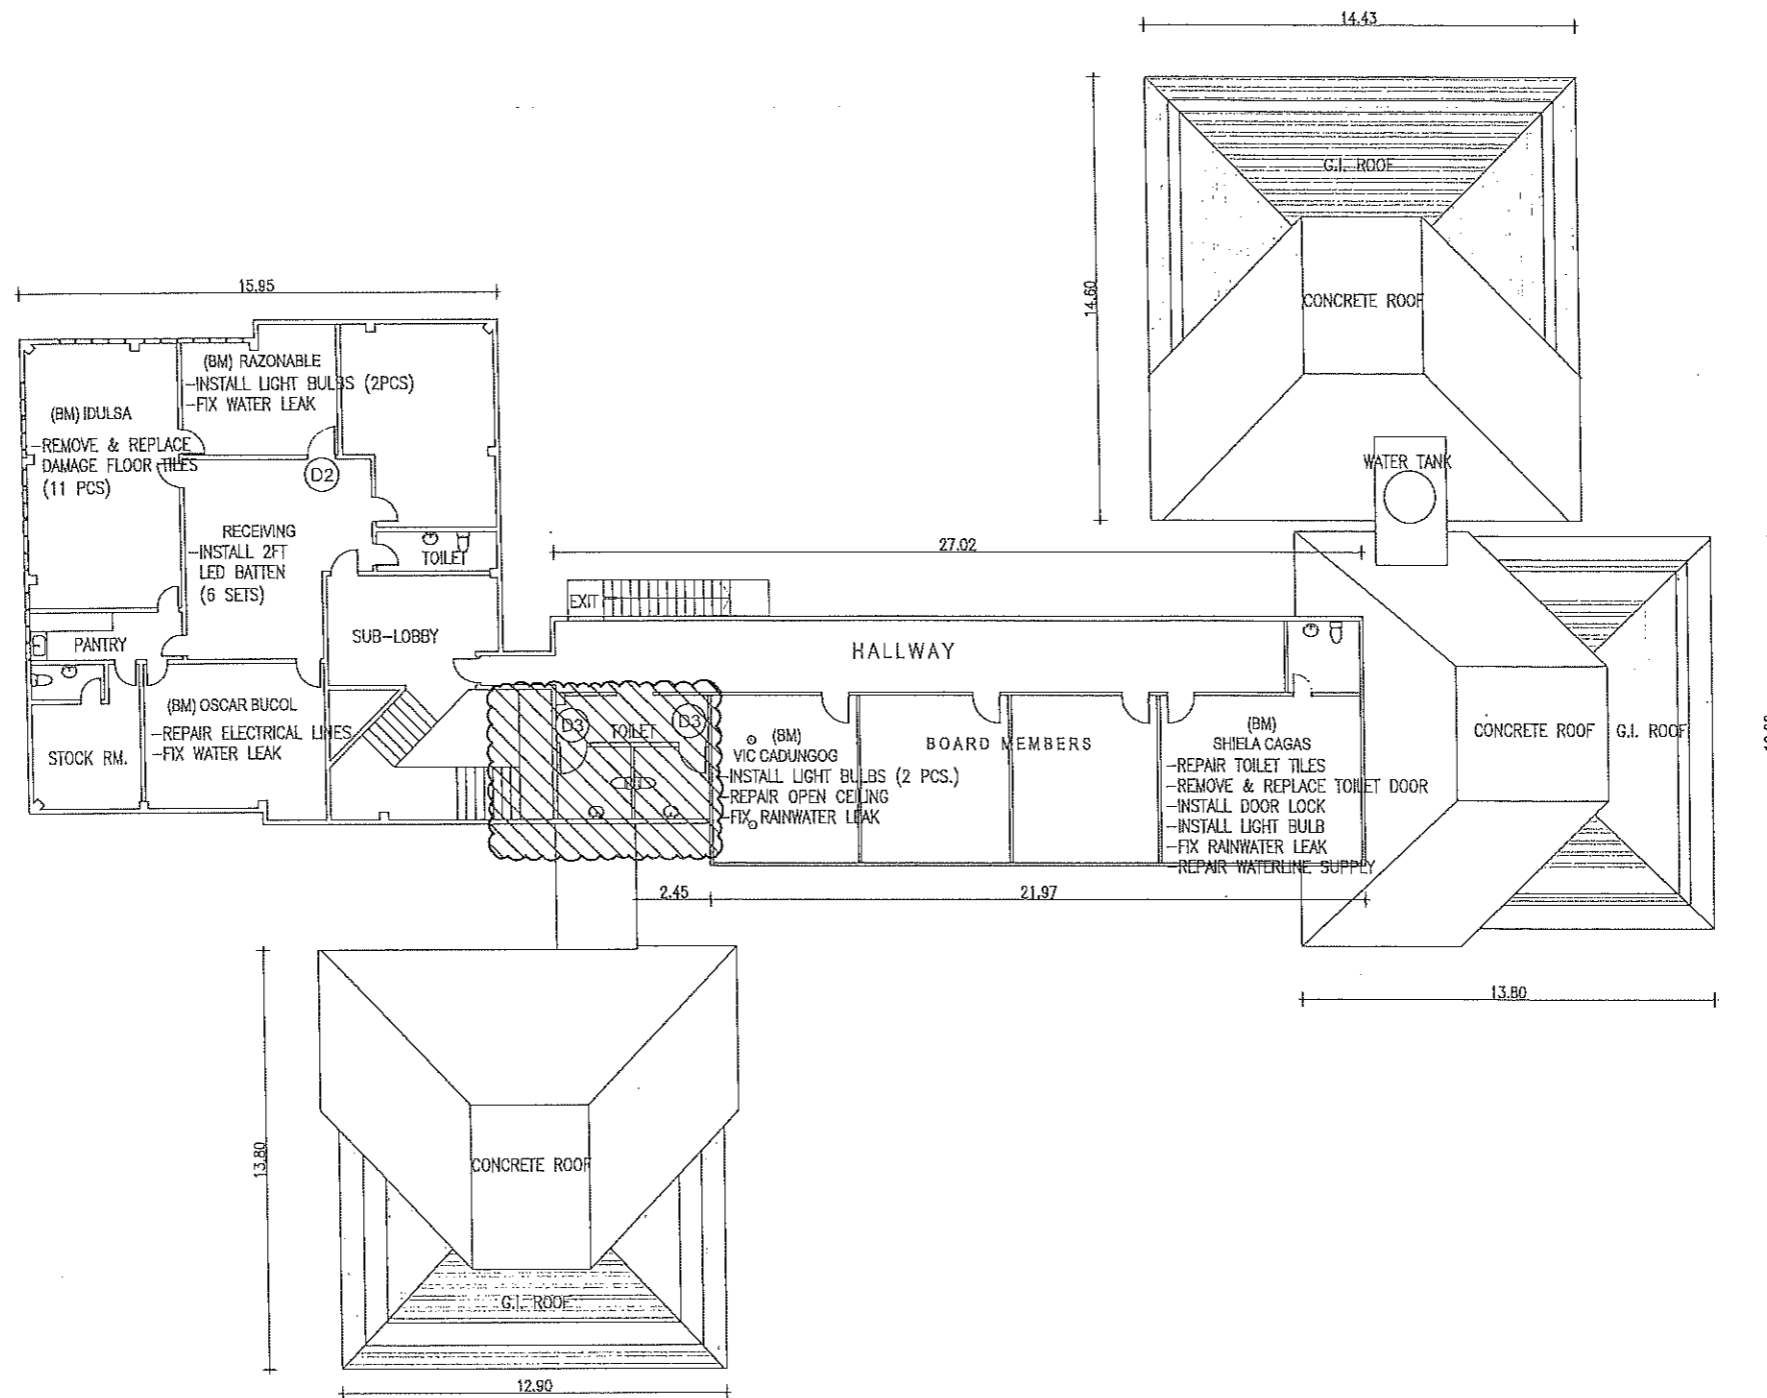
TOILET - 5

(@ 3RD FLOOR)




1 TOILET -5 DETAIL (@ 3RD FLOOR)
A-56

 <p>REPUBLIC OF THE PHILIPPINES PROVINCIAL ENGINEER'S OFFICE SAN AGUSTIN, DIGOS CITY, DAVAO DEL SUR</p>	PROJECT TITLE: REPAIR /IMPROVEMENT OF SANGGUNIANG PANLALAWIGAN BUILDING	PREPARED BY: <i>[Signature]</i> REXIE GREY B. TABAY ARCHITECT III	REVIEWED BY: <i>[Signature]</i> JOSEPH R. GONZALES ENGINEER - III PLANNING AND PROGRAMMING DIV. HEAD	RECOMMENDING APPROVAL: <i>[Signature]</i> LEONERL MARCH P. SUARIO PROVINCIAL ENGINEER	APPROVED BY: <i>[Signature]</i> YVONNE RONA CAGAS PROVINCIAL GOVERNOR	SHEET NO.:
	LOCATION: MATTI, DIGOS CITY, DAVAO DEL SUR					A-56
						56 79

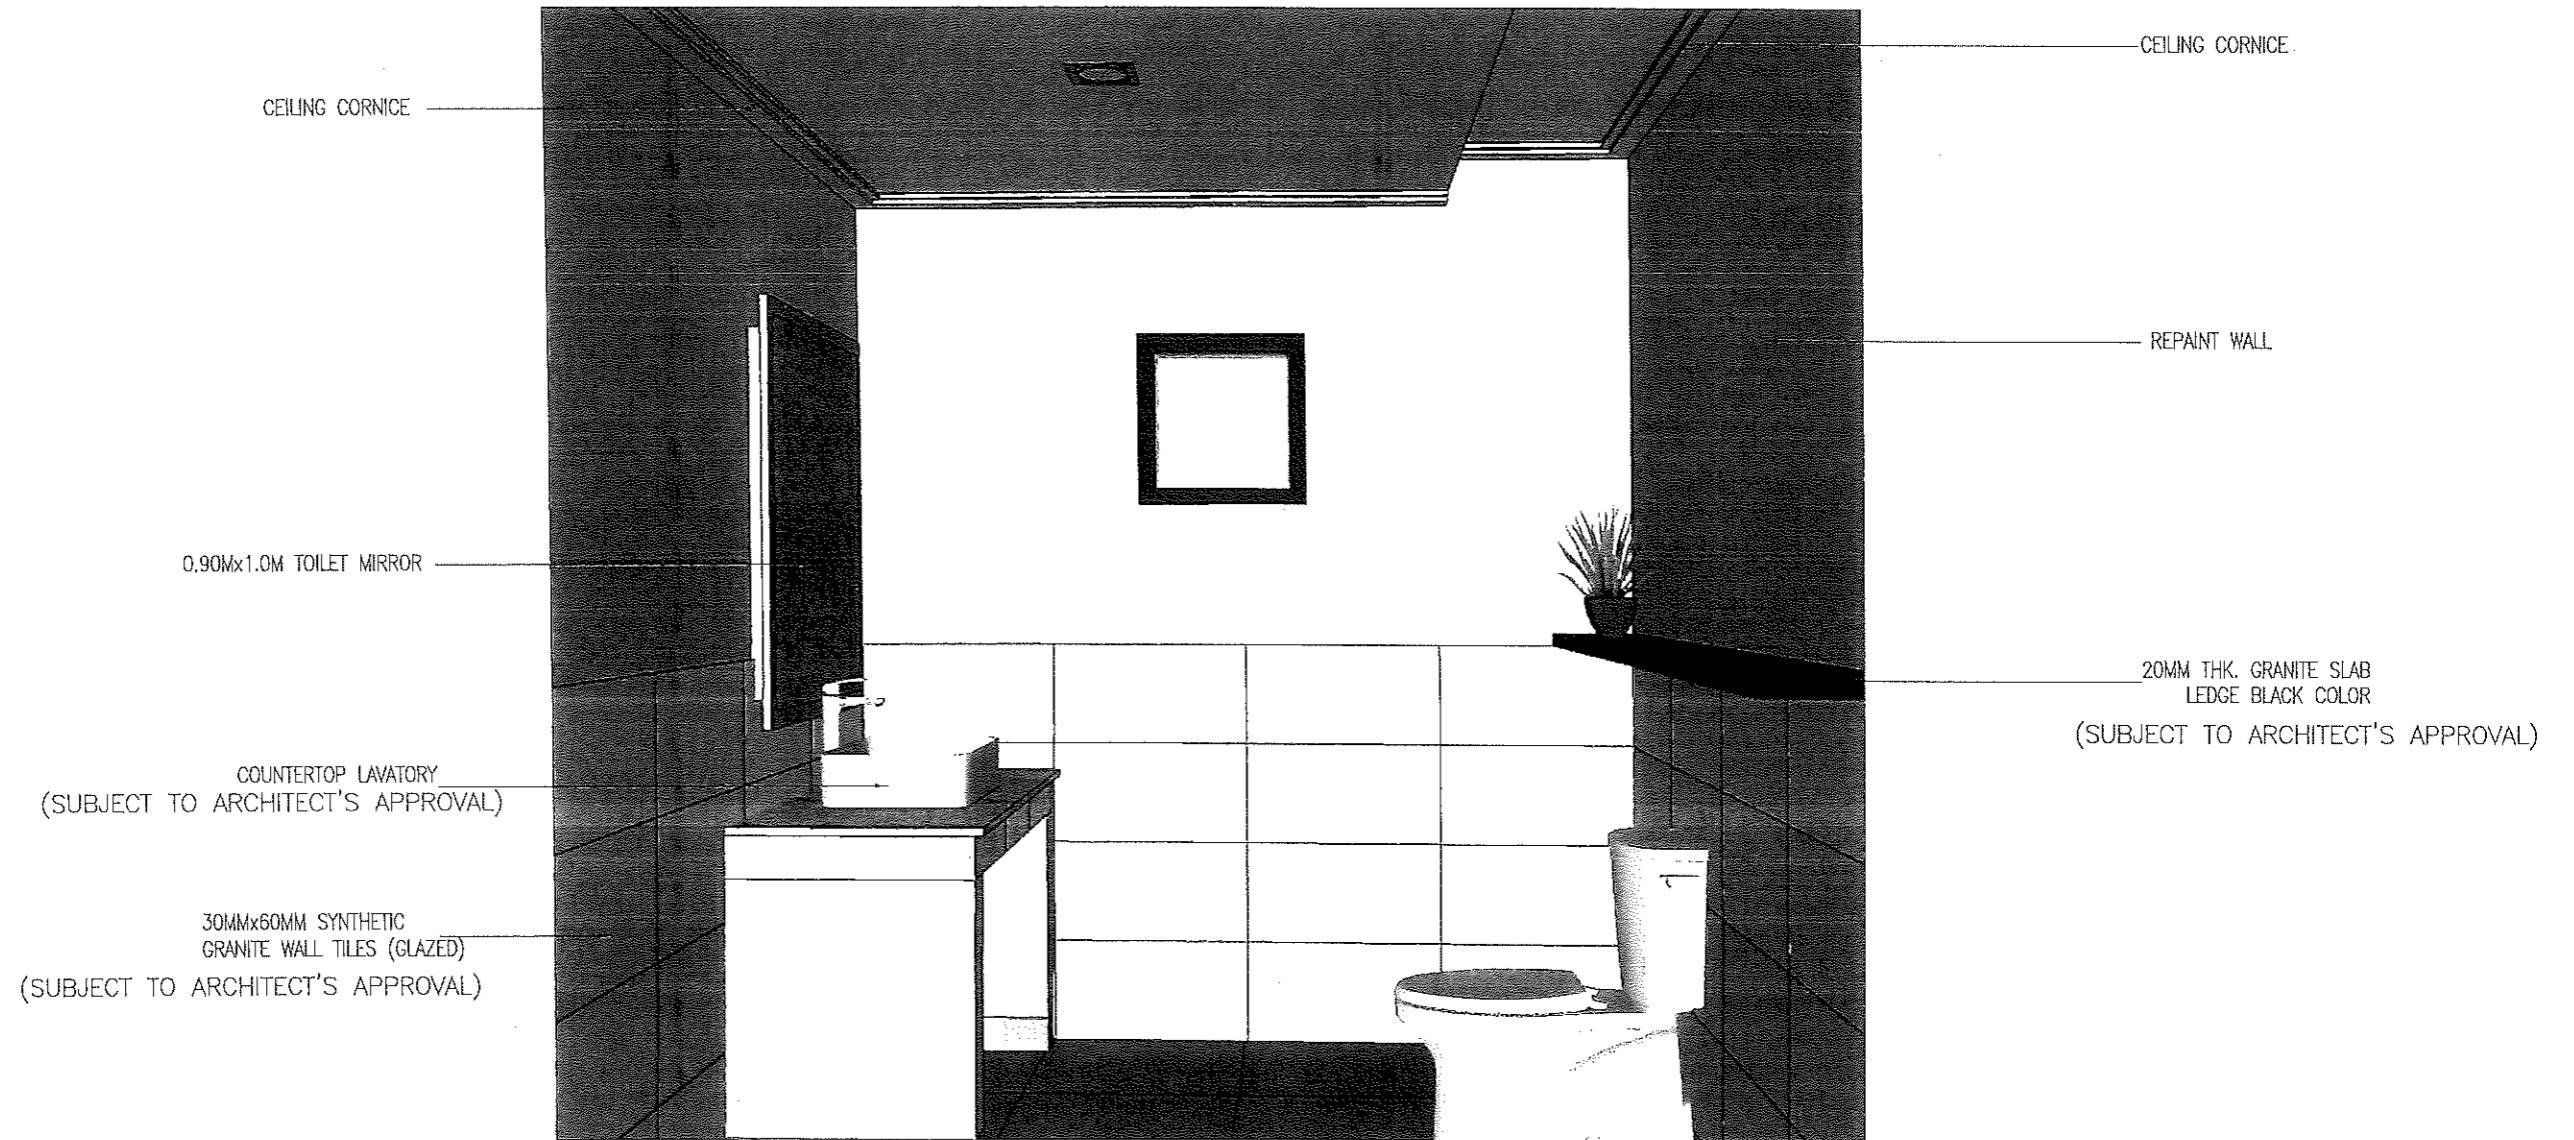

1
PERSPECTIVE
A-57

	REPUBLIC OF THE PHILIPPINES PROVINCIAL ENGINEER'S OFFICE SAN AGUSTIN, DIGOS CITY, DAVAO DEL SUR	PROJECT TITLE: REPAIR /IMPROVEMENT OF SANGGUNIANG PANLALAWIGAN BUILDING	PREPARED BY: <i>[Signature]</i> REXIE GREY B. TABAY ARCHITECT III	REVIEWED BY: <i>[Signature]</i> JOSEPH R. GONZALES ENGINEER, III PLANNING AND PROGRAMMING DIV. HEAD	RECOMMENDING APPROVAL: <i>[Signature]</i> LEONERL MARCH P. SUARIO PROVINCIAL ENGINEER	APPROVED BY: <i>[Signature]</i> YVONNE ROÑA CAGAS PROVINCIAL GOVERNOR	SHEET NO.:
		LOCATION: MATTI, DIGOS CITY, DAVAO DEL SUR					A-57

SCOPE OF WORKS


- REMOVE FLOOR AND WALL TILES
- REPAINT WALLS
- INSTALL CEILING
- INSTALL CONCRETE LAVATORY COUNTER
- REMOVE AND REPLACE LAVATORY
- INSTALL MIRROR, AND WATER CLOSET WITH BIDET,
- INSTALL TOILET PAPER HOLDER (STAINLESS STEEL)
- INSTALL EXHAUST FAN
- INSTALL PANEL DOOR (0.80M WIDTH)
- INSTALL 60MMx60MM SYNTHETIC GRANITE TILES

TOILET FIXTURES SPECIFICATIONS :


- | | |
|---------------------|---|
| WATER CLOSET | -1.6GPF WATER CLOSET, LEVER TYPE FLUSH. |
| LAVATORY | -COUNTERTOP CERAMIC LAVATORY (SEE DETAIL) |
| LAVATORY FAUCET | -304 STAINLESS STEEL FAUCET |
| SINK FAUCET | -304 STAINLESS STEEL GOOSENECK FAUCET |
| WALL FAUCET | -304 STAINLESS STEEL WALL FAUCET |
| BIDET | -304 STAINLESS BIDET |
| TOILET PAPER HOLDER | -304 STAINLESS TOILET PAPER HOLDER |
| URINAL | -WATERLESS WALL MOUNTED URINAL |
| TOILET MIRROR | -6.0MM THK TOILET MIRROR |

NOTE :

ALL FINISHING MATERIALS AND ITEMS TO BE USED SHALL BE IN ACCORDANCE TO SPECIFICATIONS AND SUBJECT TO THE APPROVAL OF ARCHITECT PRIOR INSTALLATION.

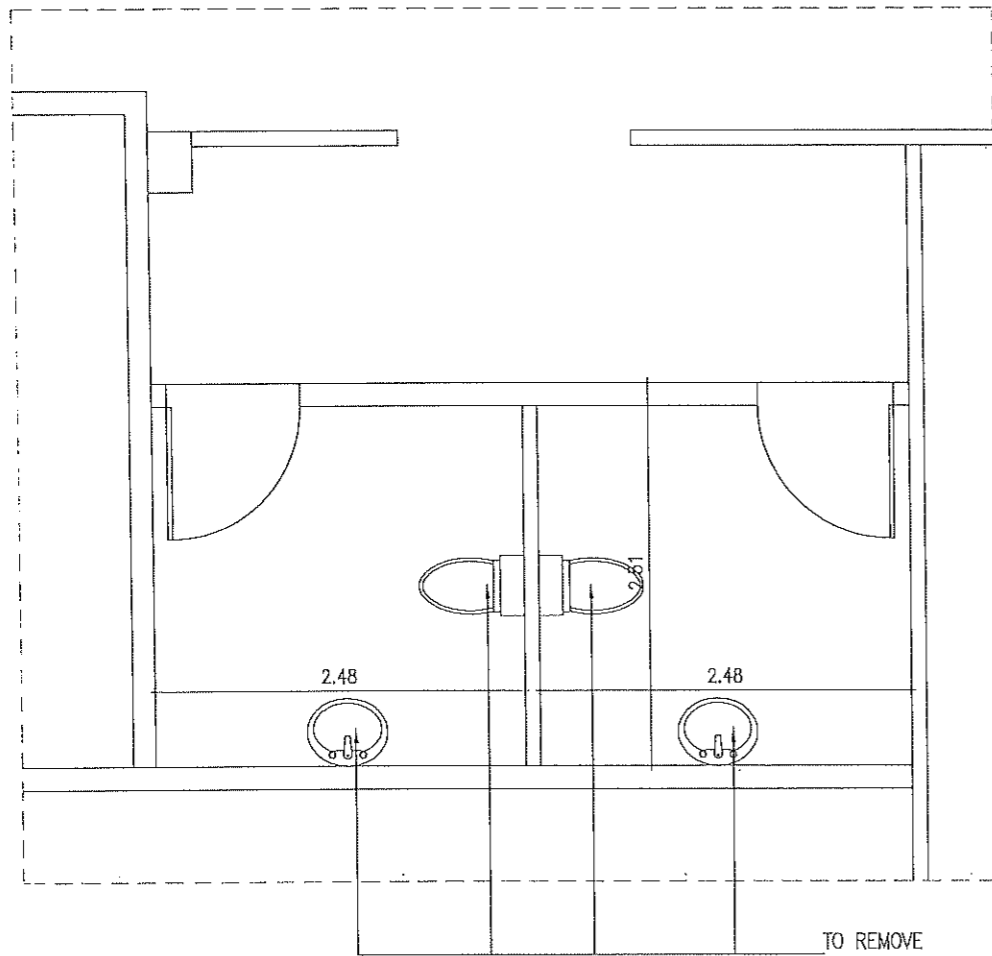

1 EXISTING FLOOR
A-58 SCALE 1:50

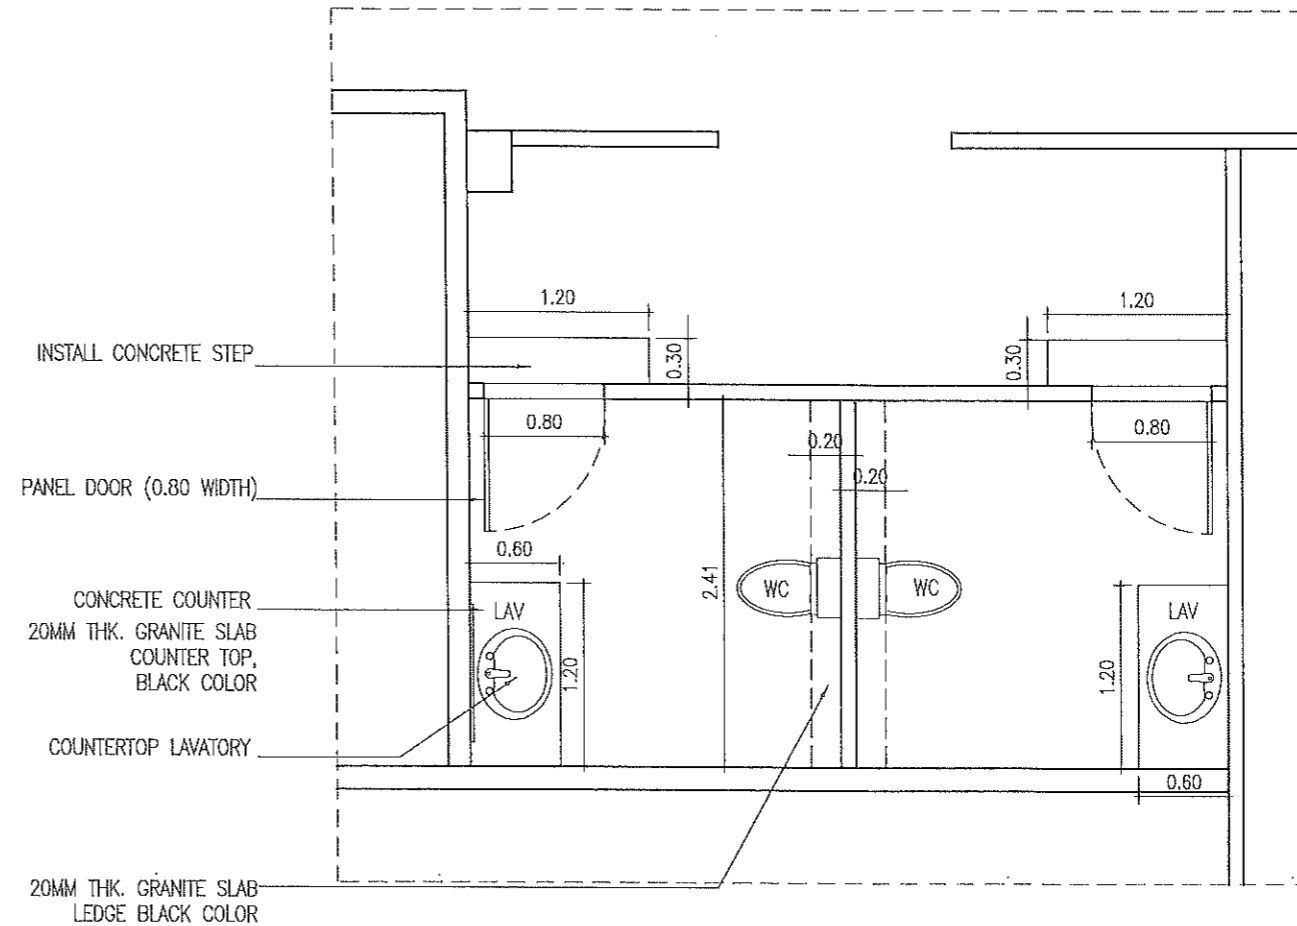

2 PROPOSED FLOOR PLAN
A-58 SCALE 1:50



REPUBLIC OF THE PHILIPPINES
PROVINCIAL ENGINEER'S OFFICE
SAN AGUSTIN, DIGOS CITY, DAVAO DEL SUR

PROJECT TITLE:
REPAIR /IMPROVEMENT OF SANGGUNIANG
PANLALAWIGAN BUILDING
LOCATION:
MATTI, DIGOS CITY, DAVAO DEL SUR

PREPARED BY:
[Signature]
REXIE GREY B. TABAY
ARCHITECT III

REVIEWED BY:
[Signature]
JOSEPH R. GONZALES
ENGINEER - II
PLANNING AND PROGRAMMING DIV. HEAD


RECOMMENDING APPROVAL:
[Signature]
LEONERL MARCH P. SUARIO
PROVINCIAL ENGINEER

APPROVED BY:
[Signature]
YVONNE RONA CAGAS
PROVINCIAL GOVERNOR


SHEET NO.:
A-58
58 79

60MMx60MM SYNTHETIC
GRANITE FLOOR TILES (NON-SKID)

30MMx60MM SYNTHETIC
GRANITE WALL TILES (GLAZED)
(SUBJECT TO ARCHITECT'S APPROVAL)

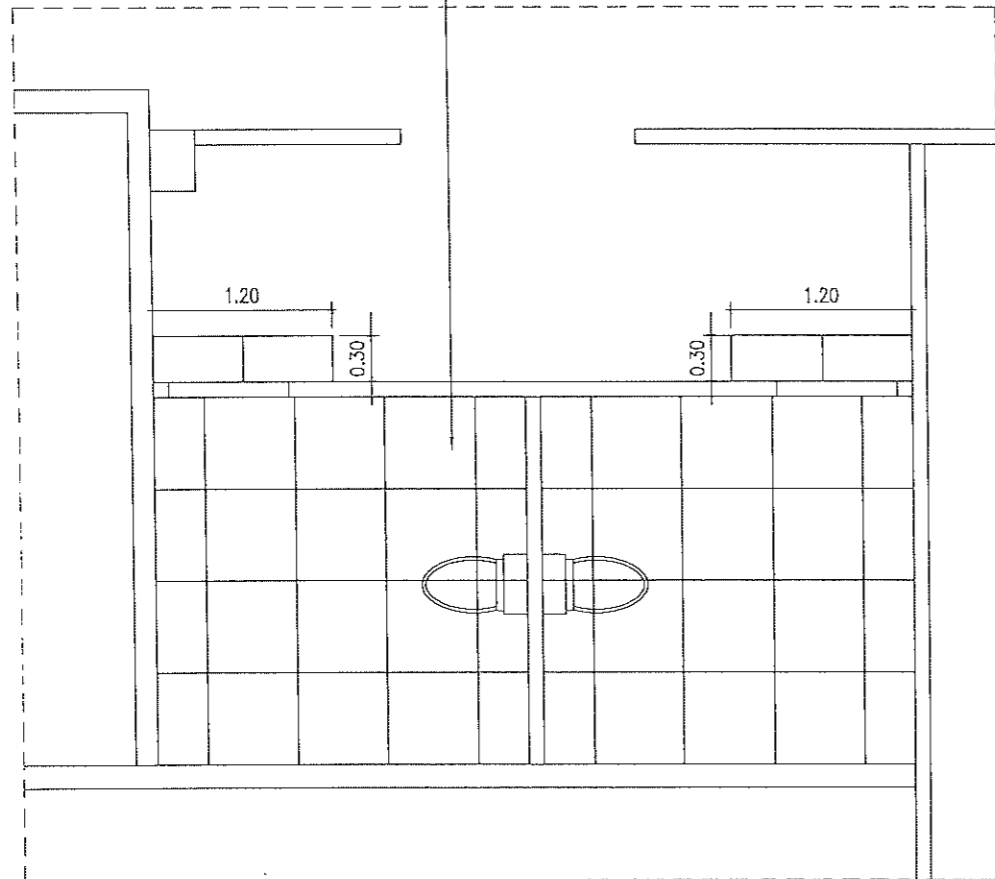

5.0MM THK. MARINE
PLYWOOD CEILING
ON METAL FURRING
W/ CEILING CORNICE

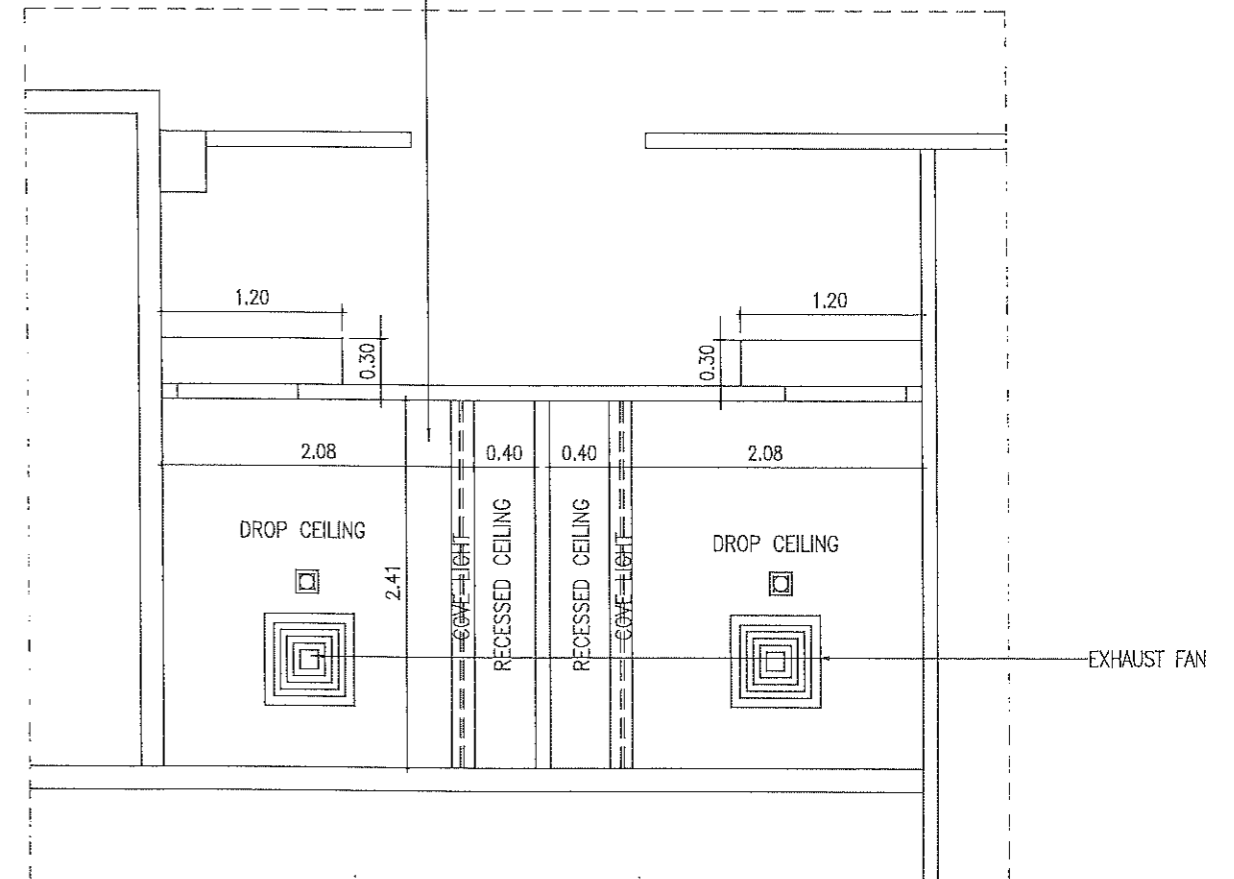

1 FLOOR TILE LAYOUT
SCALE 1:50

2 CEILING PLAN
SCALE 1:50



REPUBLIC OF THE PHILIPPINES
PROVINCIAL ENGINEER'S OFFICE
SAN AGUSTIN, DIGOS CITY, DAVAO DEL SUR

PROJECT TITLE:
REPAIR /IMPROVEMENT OF SANGGUNIANG
PANLALAWIGAN BUILDING
LOCATION:
MATTI, DIGOS CITY, DAVAO DEL SUR

PREPARED BY:
[Signature]
REXIE GREY B. TABAY
ARCHITECT III


REVIEWED BY:
[Signature]
JOSEPH R. GONZALES
ENGINEER - III
PLANNING AND PROGRAMMING DIV. HEAD

RECOMMENDING APPROVAL:
[Signature]
LEONERL MARCH P. SUARIO
PROVINCIAL ENGINEER


APPROVED BY:
[Signature]
YVONNE ROÑA CAGAS
PROVINCIAL GOVERNOR

SHEET NO.:
A-59
59 79

CERAMIC WATER CLOSET
 (HCG, PHILIPPINE STANDARD,
 AMERICAN STANDARD OR ITS EQUIVALENT)
 (SUBJECT TO ARCHITECT'S APPROVAL)

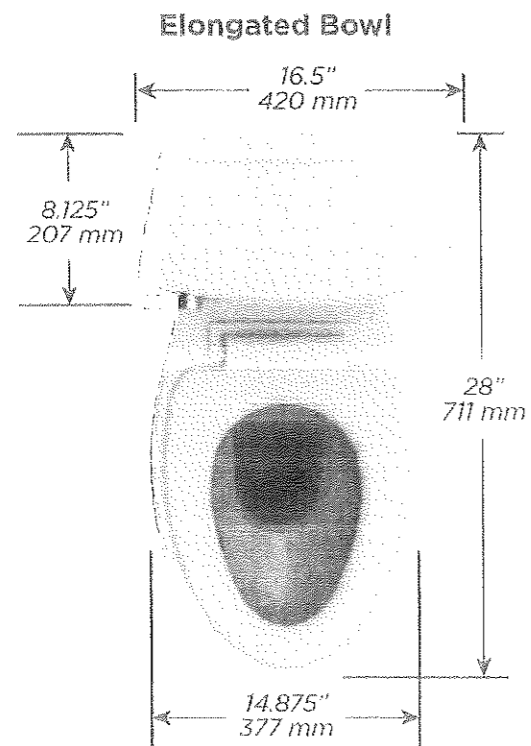

COUNTERTOP CERAMIC LAVATORY
 (HCG, PHILIPPINE STANDARD,
 AMERICAN STANDARD OR ITS EQUIVALENT)
 (SUBJECT TO ARCHITECT'S APPROVAL)

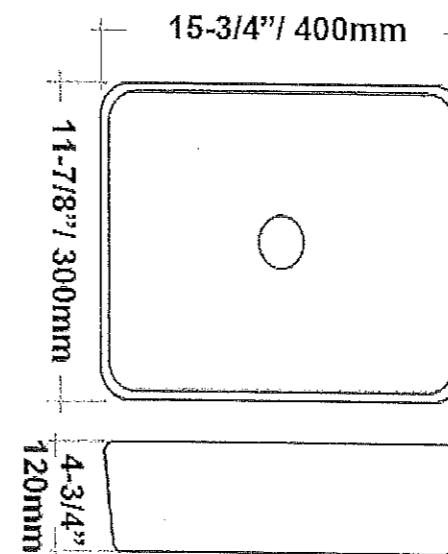

1
A-60

TYPICAL WATER CLOSET DET.

2
A-60

**COUNTERTOP
 TYPICAL LAVATORY DETAIL**



REPUBLIC OF THE PHILIPPINES
PROVINCIAL ENGINEER'S OFFICE
 SAN AGUSTIN, DIGOS CITY, DAVAO DEL SUR

PROJECT TITLE:
 REPAIR /IMPROVEMENT OF SANGGUNIANG
 PANLALAWIGAN BUILDING
 LOCATION:
 MATTI, DIGOS CITY, DAVAO DEL SUR


PREPARED BY:
[Signature]
 REXIE GREY B. TABAY
 ARCHITECT III

REVIEWED BY:
[Signature]
 JOSEPH R. GONZALES
 ENGINEER - II
 PLANNING AND PROGRAMMING DIV. HEAD

RECOMMENDING APPROVAL:
[Signature]
 LEONERL MARCH P. SUARIO
 PROVINCIAL ENGINEER


APPROVED BY:
[Signature]
 YVONNE ROÑACAGAS
 PROVINCIAL GOVERNOR

SHEET NO.:
 A-60
 60 79

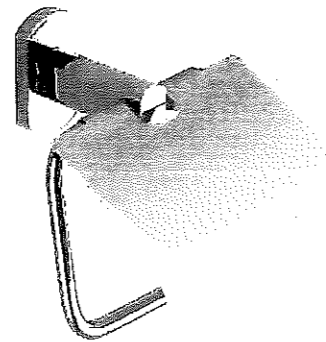


1 TOILET PAPER HOLDER-TYPICAL
A-61

304 STAINLESS STEEL FAUCET
(SUBJECT TO ARCHITECT'S APPROVAL)

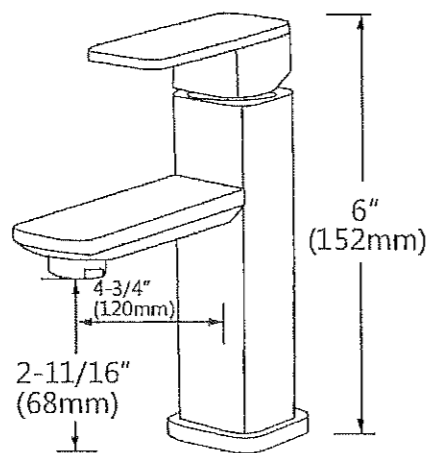

1 TYPICAL LAVATORY FAUCET DET.
A-61

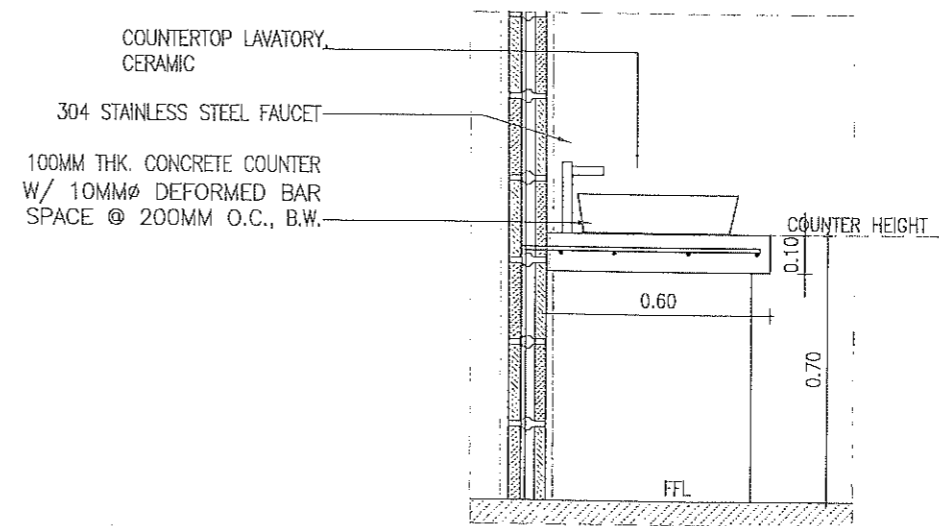

1 TYPICAL CONCRETE COUNTER DET.
A-61 SCALE 1:20M.



REPUBLIC OF THE PHILIPPINES
PROVINCIAL ENGINEER'S OFFICE
SAN AGUSTIN, DIGOS CITY, DAVAO DEL SUR

PROJECT TITLE:
REPAIR /IMPROVEMENT OF SANGGUNIANG
PANLALAWIGAN BUILDING
LOCATION:
MATTI, DIGOS CITY, DAVAO DEL SUR


PREPARED BY:
[Signature]
REXIE GREY B. TABAY
ARCHITECT III

REVIEWED BY:
[Signature]
JOSEPH R. GONZALES
ENGINEER III
PLANNING AND PROGRAMMING DIV. HEAD

RECOMMENDING APPROVAL:
[Signature]
LEONERL MARCH P. SUARIO
PROVINCIAL ENGINEER

APPROVED BY:
[Signature]
YVONNE RONA CAGAS
PROVINCIAL GOVERNOR

SHEET NO.:
A-61
61 | 79

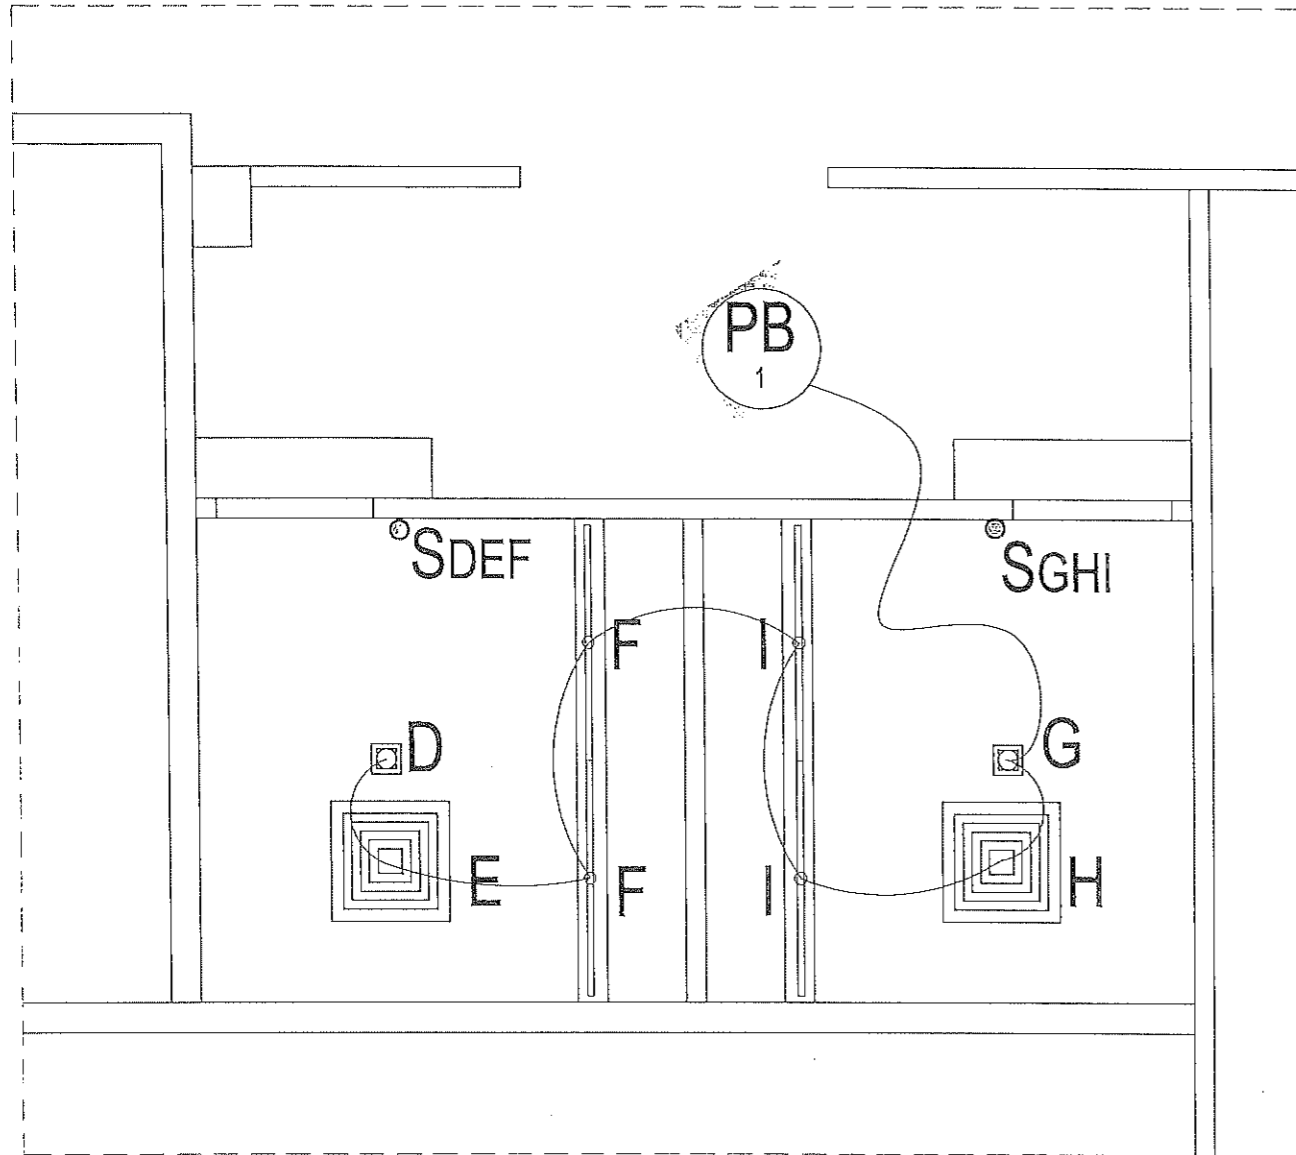




 
 
LOAD SCHEDULE :

CIRCUIT NO.	DESCRIPTION	QUANTITY	VOLTS	WATTS	AMPS	TRIP	CONDUCTOR SIZE	CONDUIT SIZE
PB 1	LIGHTING OUTLET	8	230	400	1.74	20 A	2- 3.5 mm ² THW Stranded Copper Wire , 1 - 2.0 mm ² THW Stranded Copper Wire	20 mm dia. uPVC

NOTE:

- CONNECT TO EXISTING PANEL BOARD FOR POWER SOURCE

LEGEND:

-  6W LED PINLIGHT DOWNLIGHT RECESS TYPE E27 STANDARD SOCKET, BLACK SQUARE, COOL DAYLIGHT (15 x 15 cm)
-  16W T5 LED INTEGRATED TUBE, WARM WHITE (1173 x 24 x 32 mm)
-  12 INCH CEILING MOUNTED EXHAUST FAN
-  CIRCUIT HOMERUN (CONNECT TO EXISTING PANELBOARD)
-  THREE-GANG SWITCH WITH PLATE, FLUSH TYPE

1 TOILET - 5 LIGHTING LAYOUT
E-1 SCALE 1:50




REPUBLIC OF THE PHILIPPINES
PROVINCIAL ENGINEER'S OFFICE
SAN AGUSTIN, DIGOS CITY, DAVAO DEL SUR

PROJECT TITLE: REPAIR /IMPROVEMENT OF SANGGUNIANG PANLALAWIGAN BUILDING	PREPARED BY: <i>Mary Flor L. Hectin</i> MARY FLOR L. HECTIN ENGINEER I	REVIEWED BY: <i>Jose P. Gonzales</i> JOSE P. GONZALES ENGINEER III PLANNING AND PROGRAMMING DIV. HEAD	RECOMMENDING APPROVAL: <i>Leonerl March P. Suario</i> LEONERL MARCH P. SUARIO PROVINCIAL ENGINEER	APPROVED BY: <i>Yvonne Roña Cagas</i> YVONNE RONÁ CAGAS PROVINCIAL GOVERNOR	SHEET NO.: E-1 62 79
--	---	---	--	--	----------------------------

TOILET-6 & PANTRY

(@ 1ST FLOOR)

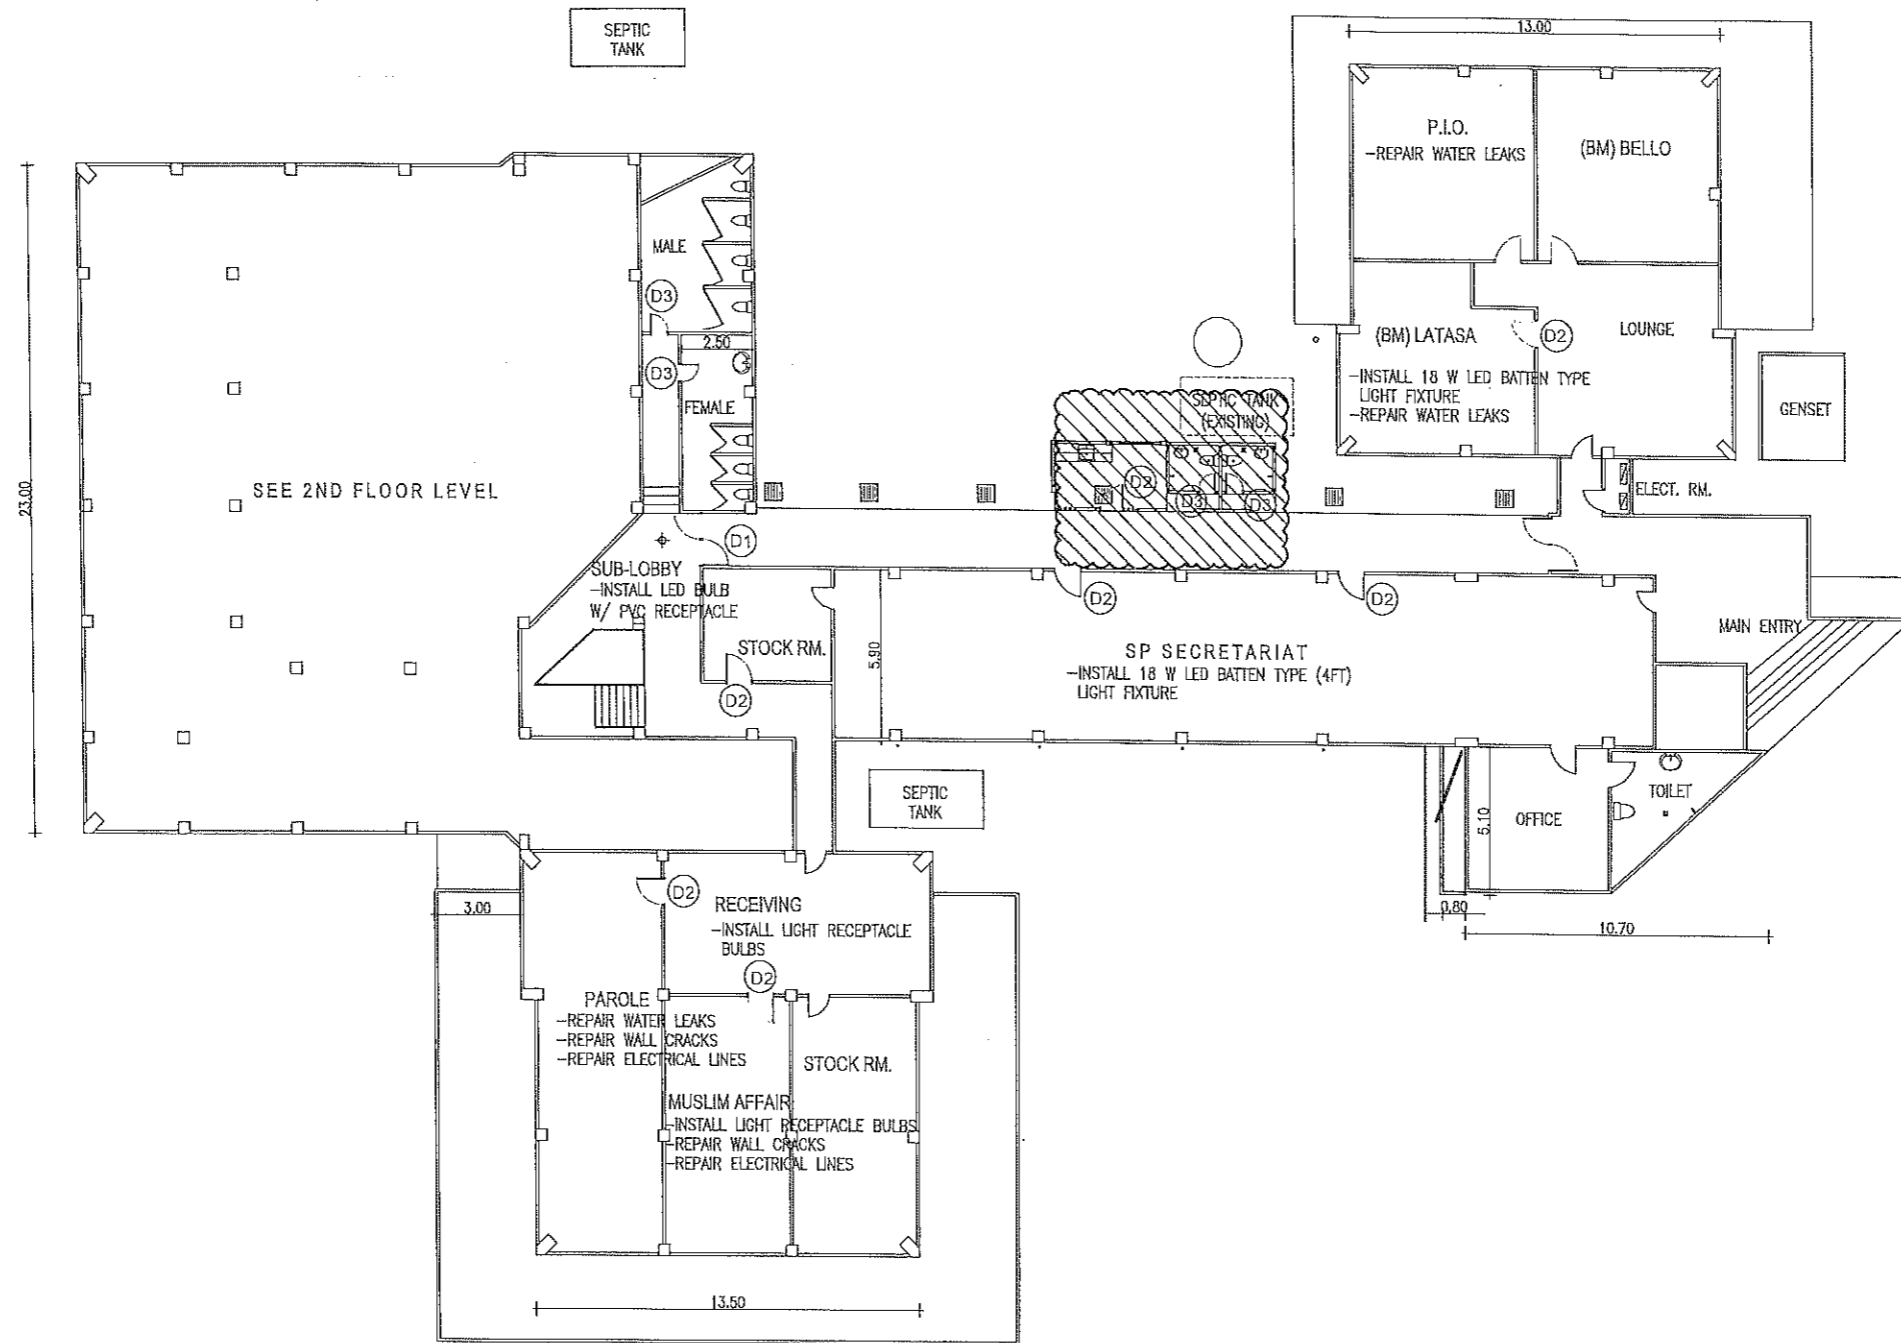

1
63
TOILET-6 & PANTRY DETAIL (@ 1ST FLOOR)




REPUBLIC OF THE PHILIPPINES
PROVINCIAL ENGINEER'S OFFICE
 SAN AGUSTIN, DIGOS CITY, DAVAO DEL SUR


PROJECT TITLE: REPAIR /IMPROVEMENT OF SANGGUNIANG PANLALAWIGAN BUILDING	PREPARED BY: REXIE GREY B. TABAY ARCHITECT III	REVIEWED BY: JOSE P. GONZALES ENGINEER - III PLANNING AND PROGRAMMING DIV. HEAD	RECOMMENDING APPROVAL: LEONERL MARCH P. SUARIO PROVINCIAL ENGINEER	APPROVED BY: YVONNE RON CAGAS PROVINCIAL GOVERNOR	SHEET NO.: <div style="border: 1px solid black; padding: 2px; text-align: center;"> A-63 </div> <div style="display: flex; justify-content: space-between; font-size: small;"> 63 79 </div>
LOCATION: MATTI, DIGOS CITY, DAVAO DEL SUR					



TOILET

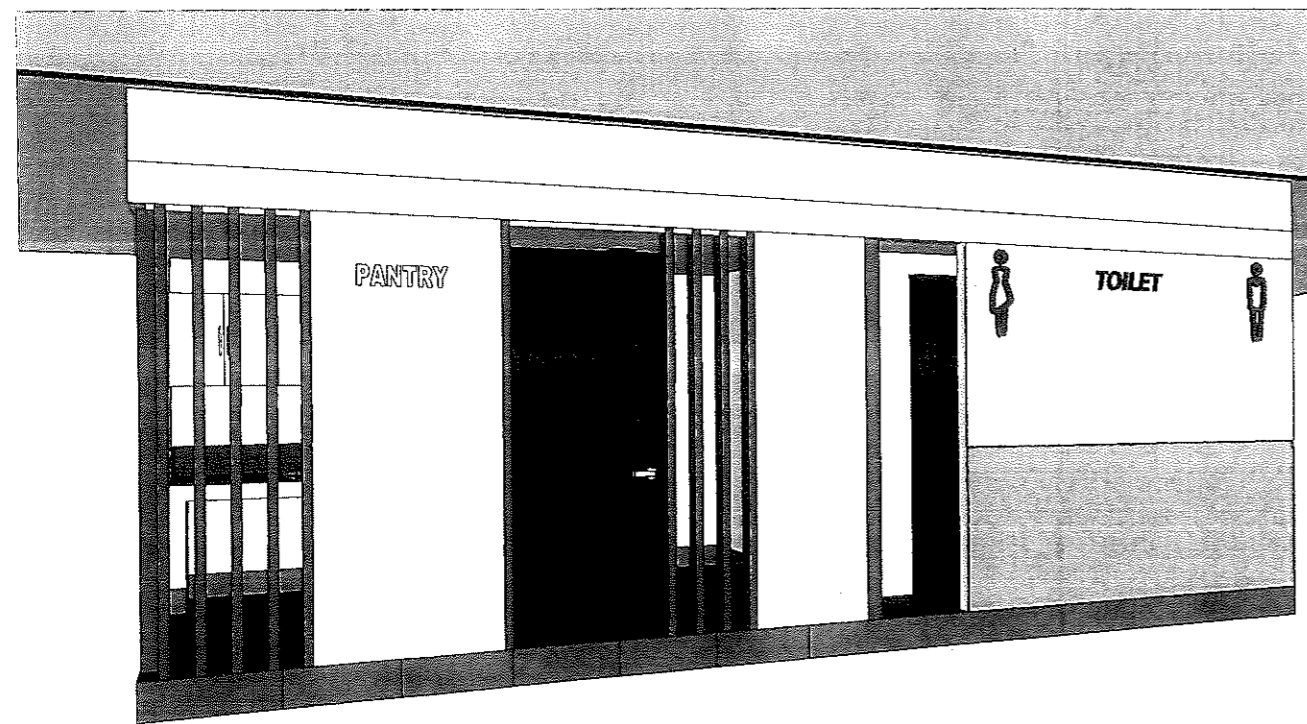

PANTRY (OUTSIDE VIEW)

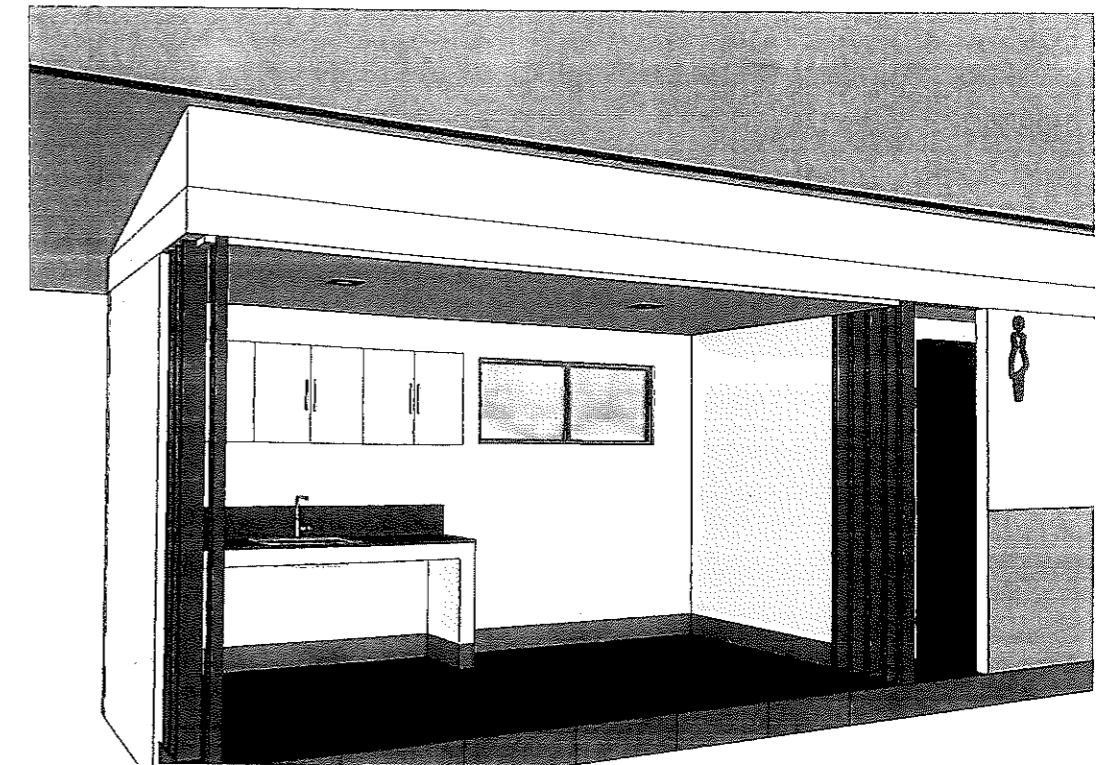

PANTRY (INSIDE VIEW)

1 PERSPECTIVE
A-64



REPUBLIC OF THE PHILIPPINES
PROVINCIAL ENGINEER'S OFFICE
SAN AGUSTIN, DIGOS CITY, DAVAO DEL SUR

PROJECT TITLE:
REPAIR /IMPROVEMENT OF SANGGUNIANG
PANLALAWIGAN BUILDING
LOCATION:
MATTI, DIGOS CITY, DAVAO DEL SUR

PREPARED BY:
Rexie Grey B. Tabay
REXIE GREY B. TABAY
ARCHITECT III

REVIEWED BY:
Joseph R. Gonzales
JOSEPH R. GONZALES
ENGINEER - VII
PLANNING AND PROGRAMMING DIV. HEAD


RECOMMENDING APPROVAL:
Leonerl March P. Suario
LEONERL MARCH P. SUARIO
PROVINCIAL ENGINEER

APPROVED BY:
Yvonne Ronk Cagas
YVONNE RONK CAGAS
PROVINCIAL GOVERNOR


SHEET NO.:
A-64
64 79

SCOPE OF WORKS

- REMOVE FLOOR AND WALL TILES
- REPAINT WALLS
- REMOVE AND INSTALL CEILING
- INSTALL CONCRETE LAVATORY COUNTER
- REMOVE LAVATORY
- INSTALL COUNTERTOP LAVATORY
- INSTALL WATER CLOSET WITH BIDET,
- INSTALL TOILET PAPER HOLDER (304 STAINLESS STEEL)
- INSTALL PANEL DOOR (0.80M WIDTH)
- INSTALL 60MMx60MM SYNTHETIC GRANITE TILES
- REPAIR WALL CRACKS
- REMOVE AND REPLACE ROOFING

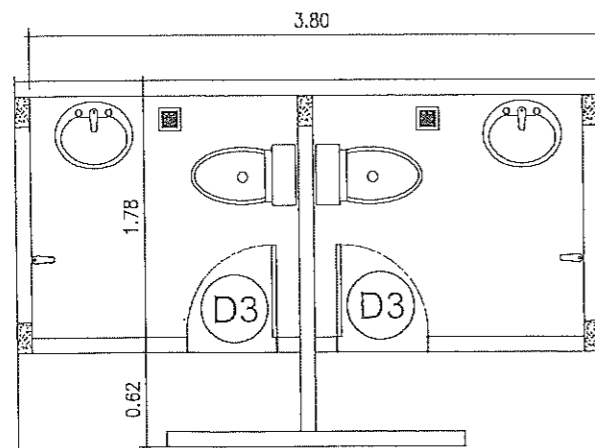

1 EXISTING FLOOR
A-65 SCALE 1:50

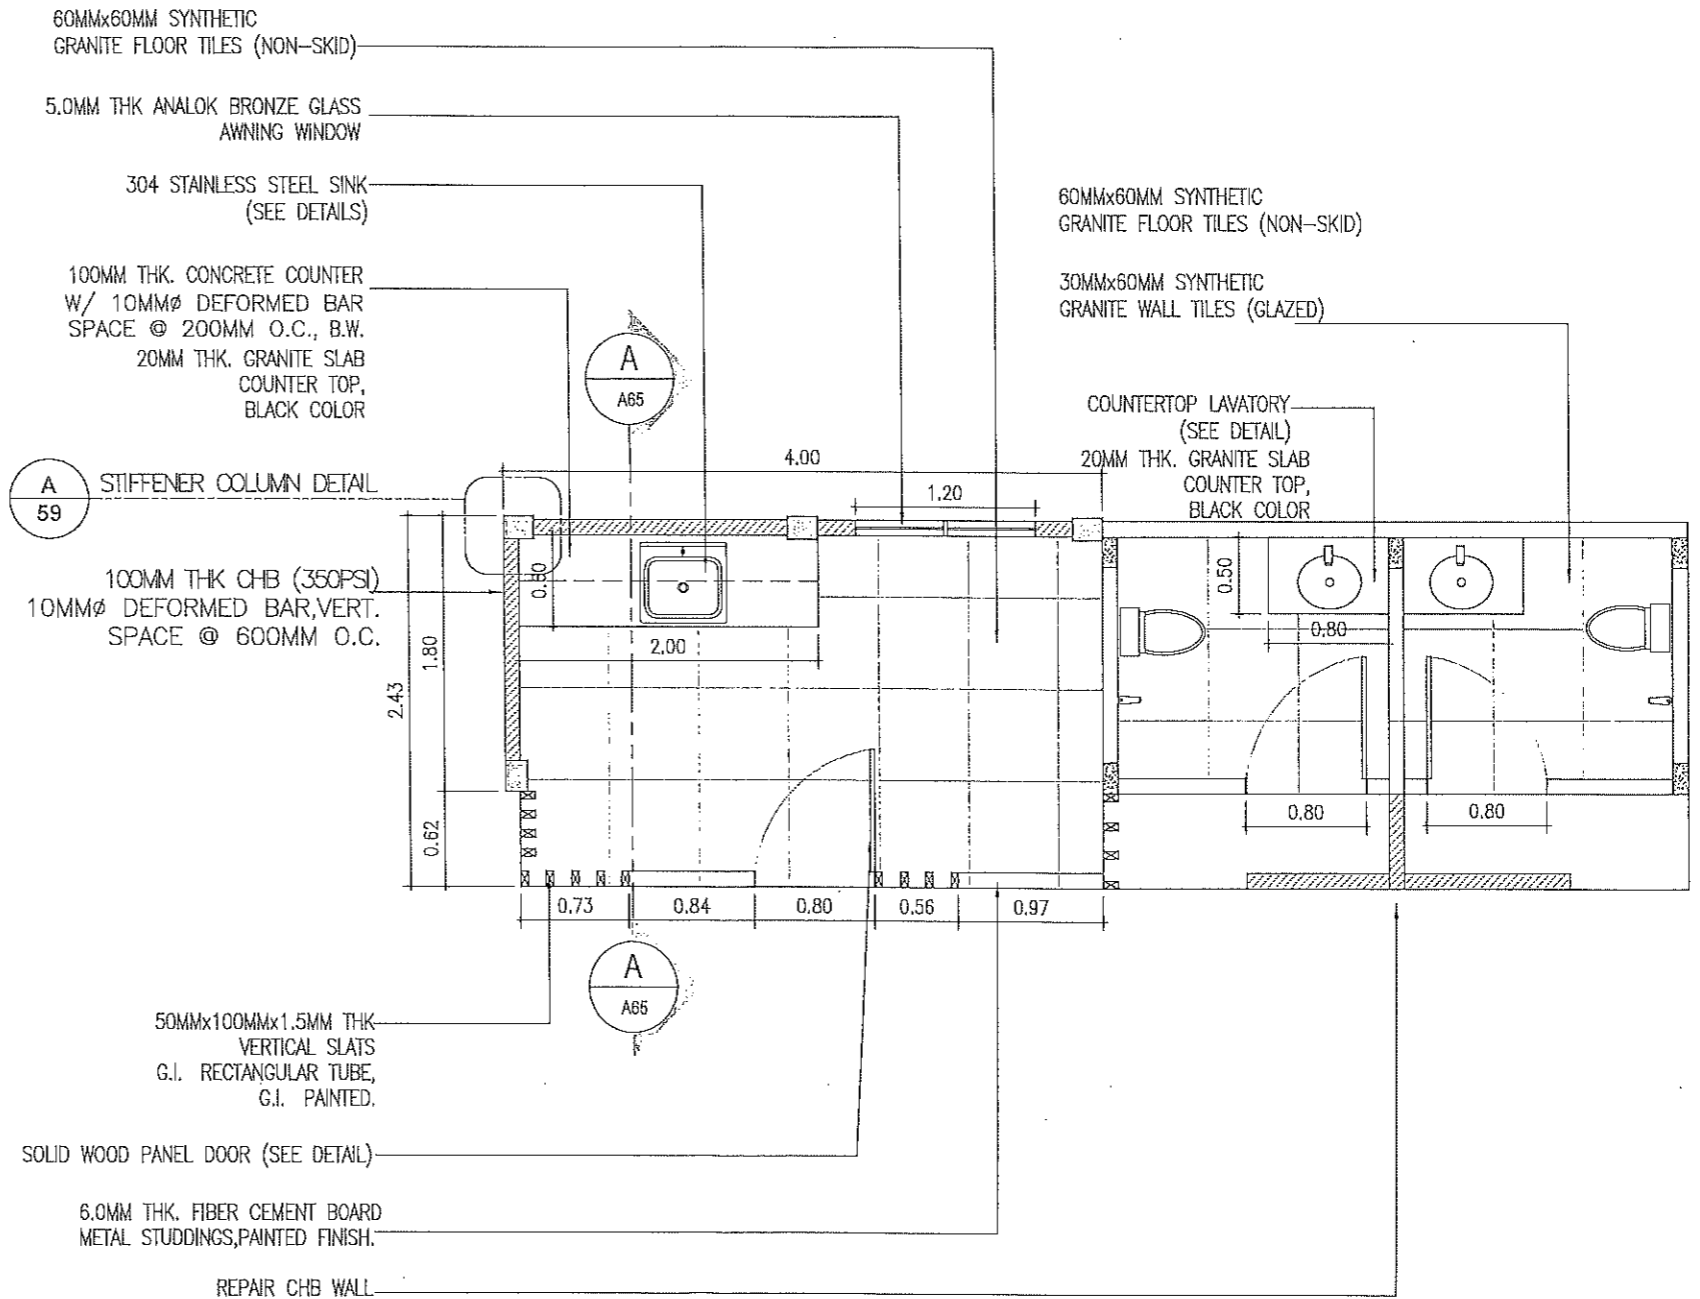

2 PROPOSED FLOOR PLAN
A-65 SCALE 1:50



REPUBLIC OF THE PHILIPPINES
PROVINCIAL ENGINEER'S OFFICE
SAN AGUSTIN, DIGOS CITY, DAVAO DEL SUR

PROJECT TITLE:
REPAIR /IMPROVEMENT OF SANGGUNIANG
PANLALAWIGAN BUILDING
LOCATION:
MATTI, DIGOS CITY, DAVAO DEL SUR


PREPARED BY:
[Signature]
REXIE GREY B. TABAY
ARCHITECT III

REVIEWED BY:
[Signature]
JOSEPH R. GONZALES
ENGINEER - III
PLANNING AND PROGRAMMING DIV. HEAD


RECOMMENDING / APPROVAL:
[Signature]
LEONERL MARCH P. SUARIO
PROVINCIAL ENGINEER

APPROVED BY:
[Signature]
YVONNE RONA CAGAS
PROVINCIAL GOVERNOR

SHEET NO.:
A-65
65 79

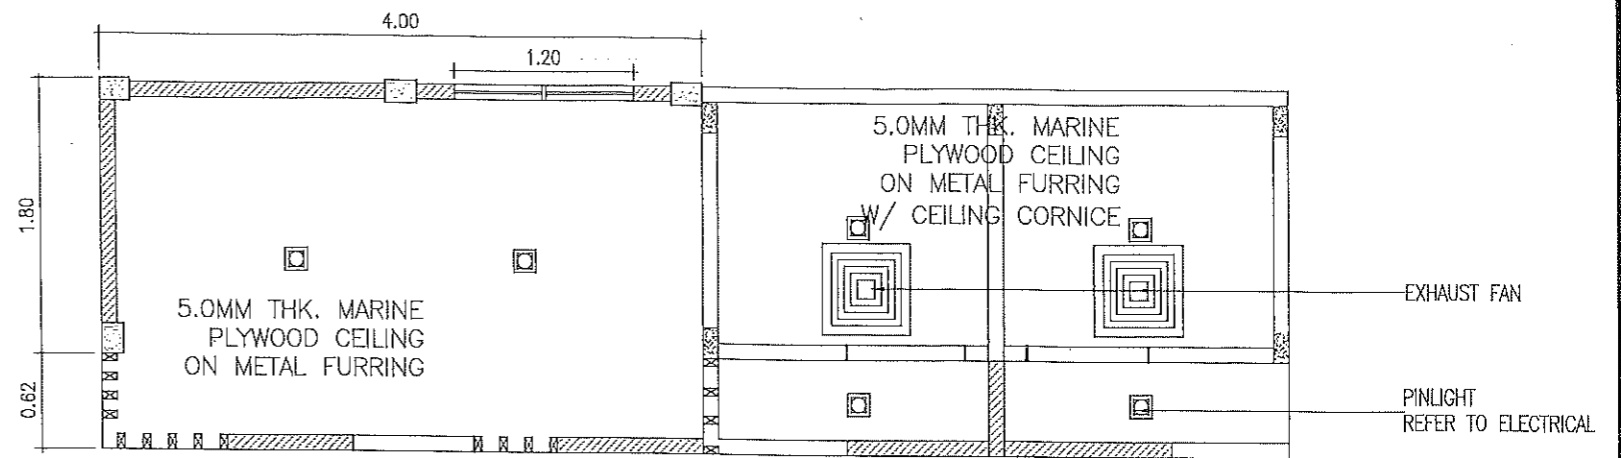

3 CEILING PLAN
A-66 SCALE 1:50

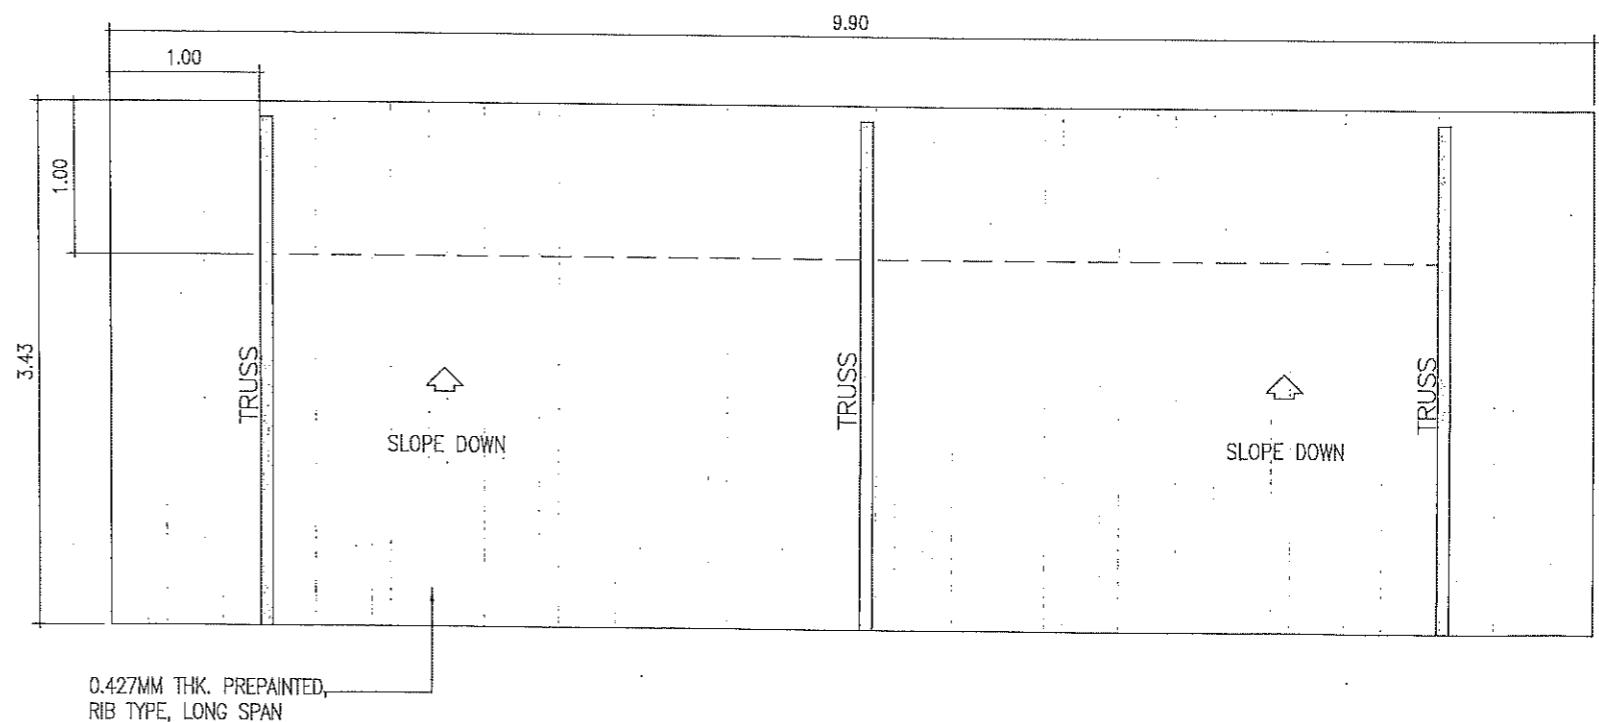

2 ROOF PLAN
A-66 SCALE 1:50

0.427MM THK. PREPAINTED, RIB TYPE, LONG SPAN

50MMx100MMx1.5MM THK A.A. RECTANGULAR TUBE, G.I. PAINTED.

50MMx75MMx1.2MM THK C-PURLIN

5.0MM THK. MARINE PLYWOOD CEILING ON METAL FURRING


18MM THK. MARINE PLYWOOD CABINET, PAINTED

75MM THK. CONCRETE SLAB WITH 10MM ϕ RSB SP @ 0.60M O.C., B.W.

100MM THK CHB (350PSI)
10MM ϕ DEFORMED BAR, VERT. SPACE @ 600MM O.C.
10MM ϕ DEFORMED BAR, HOR. SP @ EVERY 3-LAYER

CONCRETE FOOTING W/ 2-10MM ϕ LONG BARS 10MM ϕ TRANSVERSE BARS SP @ 0.30M O.C.

100MM THK. GRAVEL BASE

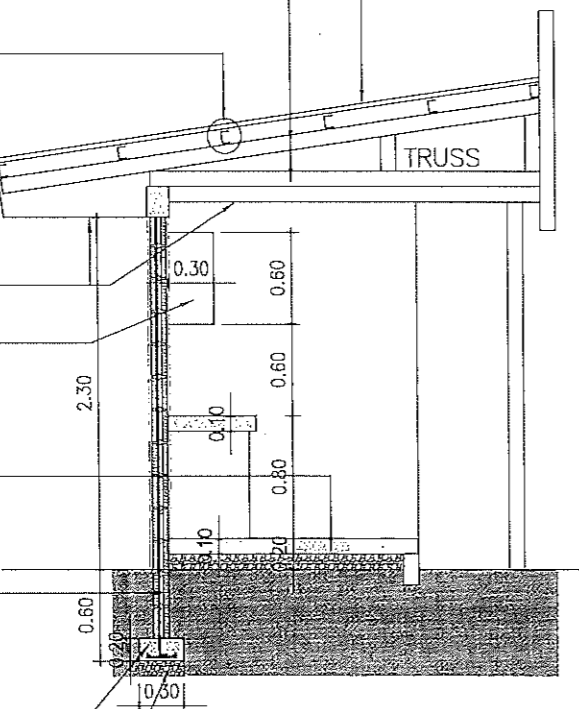

1 SECTION A-A
A-66 SCALE 1:50



REPUBLIC OF THE PHILIPPINES
PROVINCIAL ENGINEER'S OFFICE
SAN AGUSTIN, DIGOS CITY, DAVAO DEL SUR

PROJECT TITLE:
REPAIR /IMPROVEMENT OF SANGGUNIANG PANLALAWIGAN BUILDING

LOCATION:
MATTI, DIGOS CITY, DAVAO DEL SUR


PREPARED BY:
[Signature]
REXIE GREY B. TABAY
ARCHITECT III

REVIEWED BY:
[Signature]
JOSEPH R. GONZALES
ENGINEER - III
PLANNING AND PROGRAMMING DIV. HEAD

RECOMMENDING APPROVAL:
[Signature]
LEONERL MARCH P. SUARIO
PROVINCIAL ENGINEER

APPROVED BY:
[Signature]
YVONNE ROÑA CAGAS
PROVINCIAL GOVERNOR


SHEET NO.:
A-66
66 79

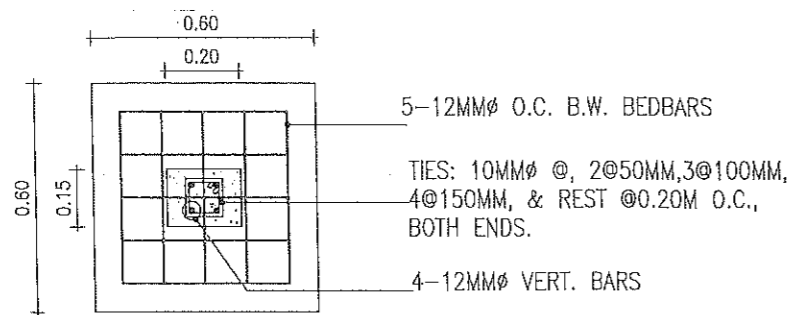

4

STIFFENER COLUMN DET.


A-67

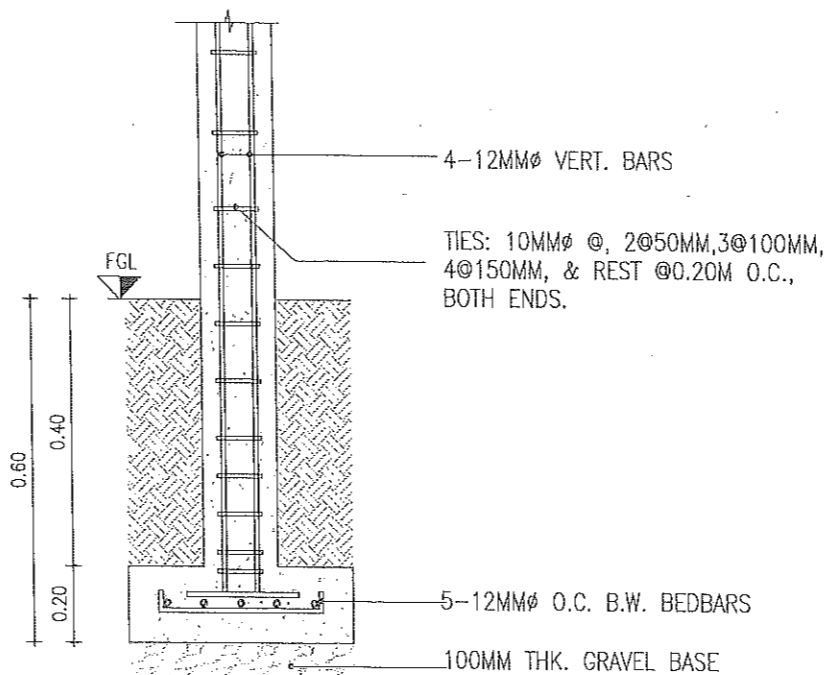

3


TOILET PAPER HOLDER

A-67

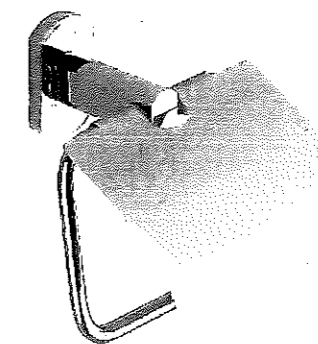

CERAMIC WATER CLOSET
(HCG, PHILIPPINE STANDARD,
AMERICAN STANDARD OR ITS EQUIVALENT)
(SUBJECT TO ARCHITECT'S APPROVAL)

Elongated Bowl

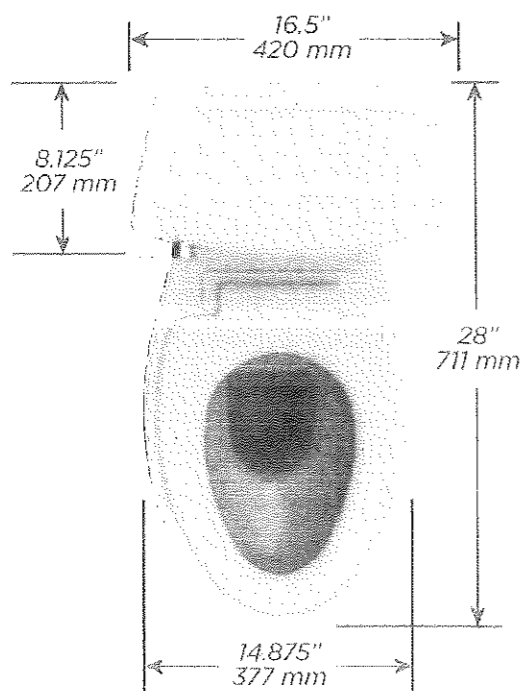


1

TYPICAL WATER CLOSET DET.

A-67

COUNTERTOP CERAMIC LAVATORY
(HCG, PHILIPPINE STANDARD,
AMERICAN STANDARD OR ITS EQUIVALENT)
(SUBJECT TO ARCHITECT'S APPROVAL)

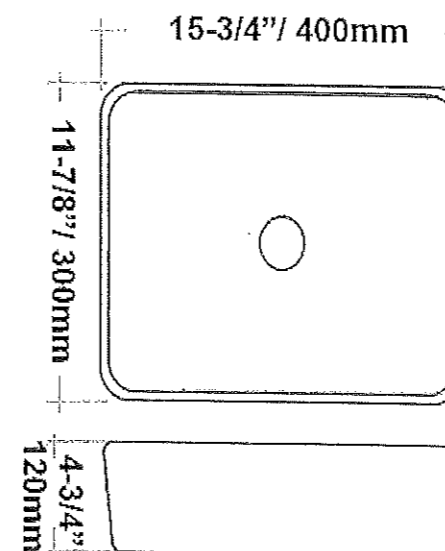

2

**COUNTERTOP
TYPICAL LAVATORY DETAIL**

A-67



REPUBLIC OF THE PHILIPPINES
PROVINCIAL ENGINEER'S OFFICE
SAN AGUSTIN, DIGOS CITY, DAVAO DEL SUR

PROJECT TITLE:
REPAIR /IMPROVEMENT OF SANGGUNIANG
PANLALAWIGAN BUILDING

LOCATION:
MATTI, DIGOS CITY, DAVAO DEL SUR

PREPARED BY:
[Signature]
REXIE GREY B. TAYAY
ARCHITECT III

REVIEWED BY:
[Signature]
JOSEPH R. GONZALES
ENGINEER - III
PLANNING AND PROGRAMMING DIV. HEAD


RECOMMENDING APPROVAL:
[Signature]
LEONERL MARCH P. SUARIO
PROVINCIAL ENGINEER

APPROVED BY:
[Signature]
YVONNE ROÑA CAGAS
PROVINCIAL GOVERNOR

SHEET NO.:


A-67

67 79

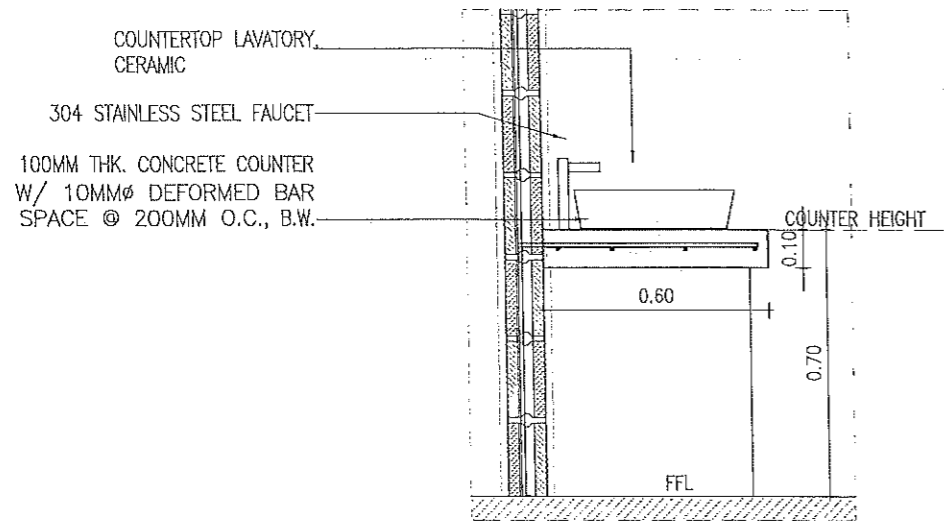


3 TYPICAL CONCRETE COUNTER DET.
 A-68 SCALE 1:20M.

304 STAINLESS STEEL FAUCET
 (SUBJECT TO ARCHITECT'S APPROVAL)

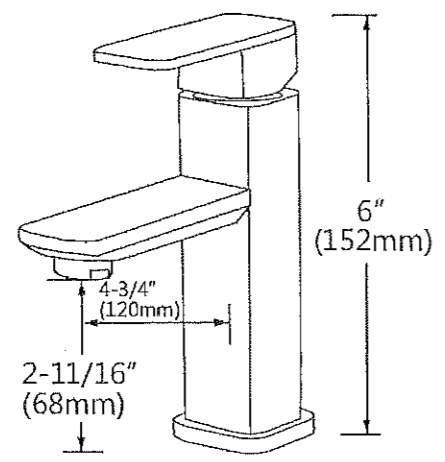


1 TYPICAL LAVATORY FAUCET DET.
 A-68

STAINLESS STEEL SINK, Ga.# 16
 (SUBJECT TO ARCHITECT'S APPROVAL)

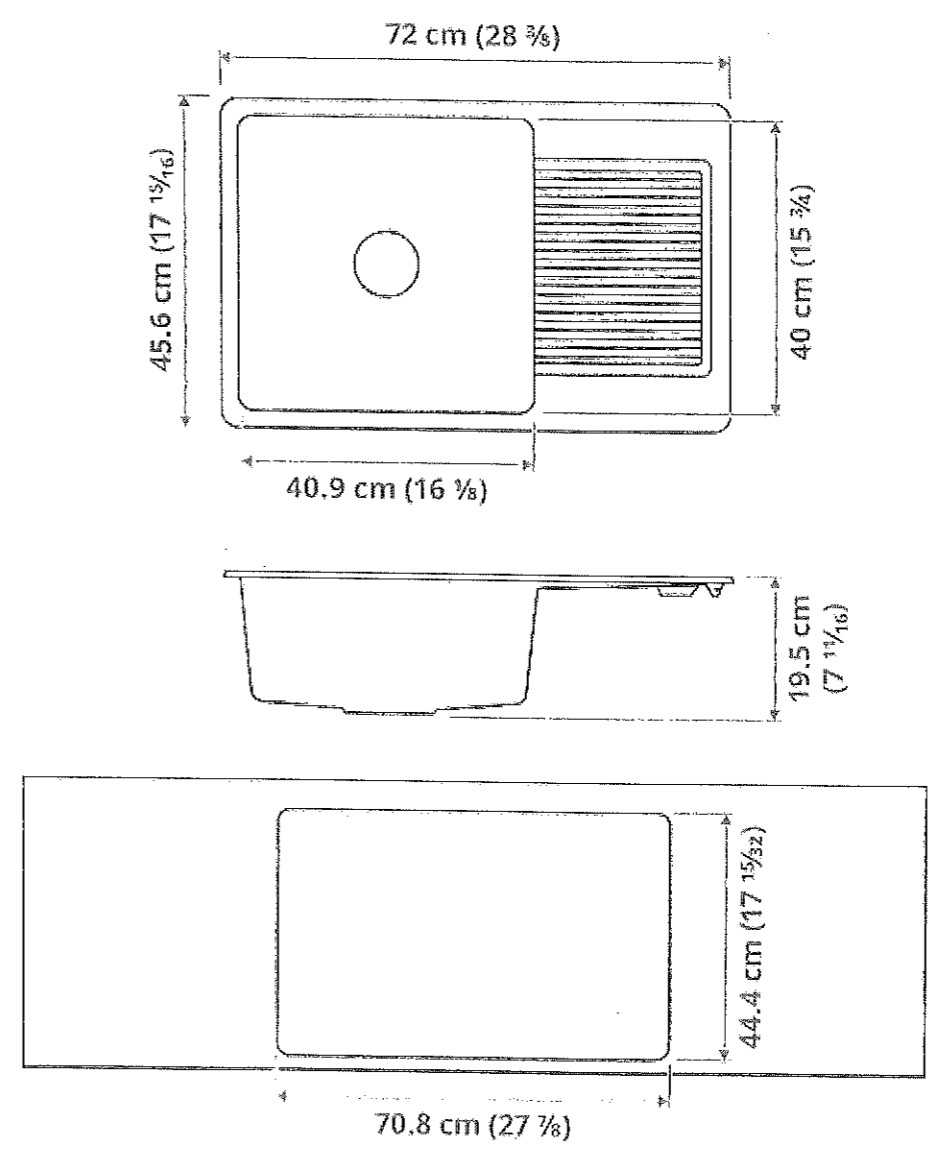

2 KITCHEN SINK DETAIL
 A-68

	REPUBLIC OF THE PHILIPPINES PROVINCIAL ENGINEER'S OFFICE SAN AGUSTIN, DIGOS CITY, DAVAO DEL SUR	PROJECT TITLE: REPAIR /IMPROVEMENT OF SANGGUNIANG PANLALAWIGAN BUILDING	PREPARED BY: REXIE GREY B. TABAY ARCHITECT III	REVIEWED BY: JOSEPH R. GONZALES ENGINEER - III PLANNING AND PROGRAMMING DIV. HEAD	RECOMMENDING APPROVAL: LEONERL MARCH P. SUARIO PROVINCIAL ENGINEER	APPROVED BY: YVONNE ROÑA CAGAS PROVINCIAL GOVERNOR	SHEET NO.: A-68 68 79
		LOCATION: MATTI, DIGOS CITY, DAVAO DEL SUR					

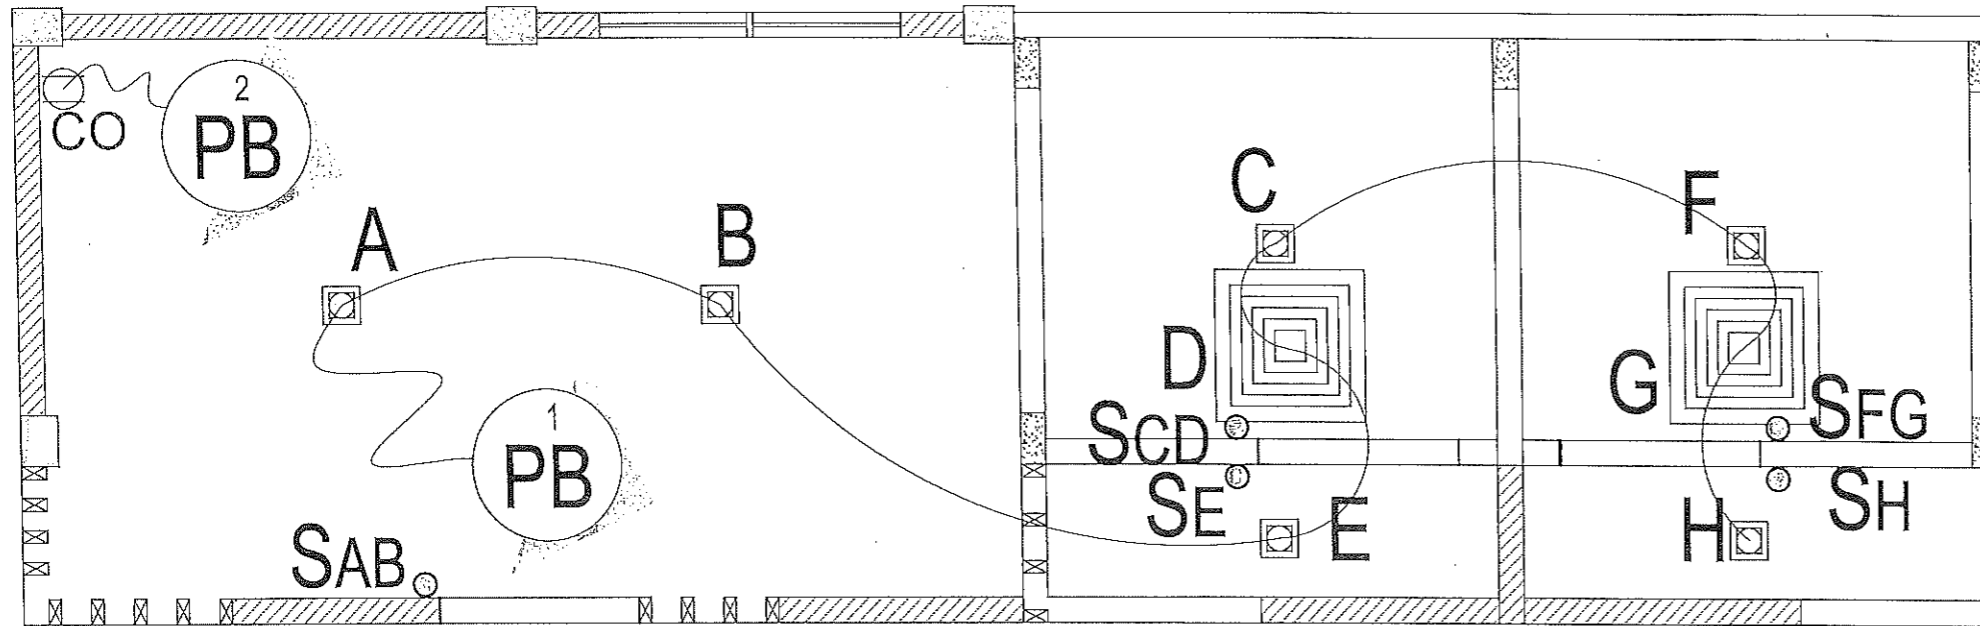

LOAD SCHEDULE :

CIRCUIT NO.	DESCRIPTION	QUANTITY	VOLTS	WATTS	AMPS	TRIP	CONDUCTOR SIZE	CONDUIT SIZE
PB 1	LIGHTING OUTLET	8	230	400	1.74	20 A	2- 3.5 mm ² THW Stranded Copper Wire , 1 - 2.0 mm ² THW Stranded Copper Wire	20 mm dia. uPVC
PB 2	CONVENIENCE OUTLET	1	230	180	0.78	20 A	2- 3.5 mm ² THW Stranded Copper Wire , 1 - 2.0 mm ² THW Stranded Copper Wire	20 mm dia. uPVC

LEGEND:

- 9W LED PINLIGHT DOWNLIGHT RECESS TYPE E27 STANDARD SOCKET, BLACK SQUARE, COOL DAYLIGHT (15 x 15 cm)
- 12 INCH CEILING MOUNTED EXHAUST FAN
- TWO-GANG CONVENIENCE UNIVERSAL OUTLET
- CIRCUIT HOMERUN (CONNECT TO EXISTING PANELBOARD)
- TWO-GANG SWITCH WITH PLATE, FLUSH TYPE
- ONE-GANG SWITCH WITH PLATE, FLUSH TYPE

NOTE:

- CONNECT TO EXISTING PANEL BOARD FOR POWER SOURCE

1
E-1

TOILET - 6 & PANTRY ELECTRICAL PLAN

SCALE

1:50



REPUBLIC OF THE PHILIPPINES
PROVINCIAL ENGINEER'S OFFICE
SAN AGUSTIN, DIGOS CITY, DAVAO DEL SUR

PROJECT TITLE:
REPAIR /IMPROVEMENT OF SANGGUNIANG PANLALAWIGAN BUILDING
LOCATION:
MATTI, DIGOS CITY, DAVAO DEL SUR

PREPARED BY:
Mary Flor L. Hectin
MARY FLOR L. HECTIN
ENGINEER I


REVIEWED BY:
Joseph R. Gonzales
JOSEPH R. GONZALES
ENGINEER - III
PLANNING AND PROGRAMMING DIV. HEAD

RECOMMENDING APPROVAL:
Leonerl Maroh P. Suario
LEONERL MAROH P. SUARIO
PROVINCIAL ENGINEER

APPROVED BY:
Yvonne Roña Cagas
YVONNE ROÑA CAGAS
PROVINCIAL GOVERNOR

SHEET NO.:
A-69
69 79

COVERED PATHWALK

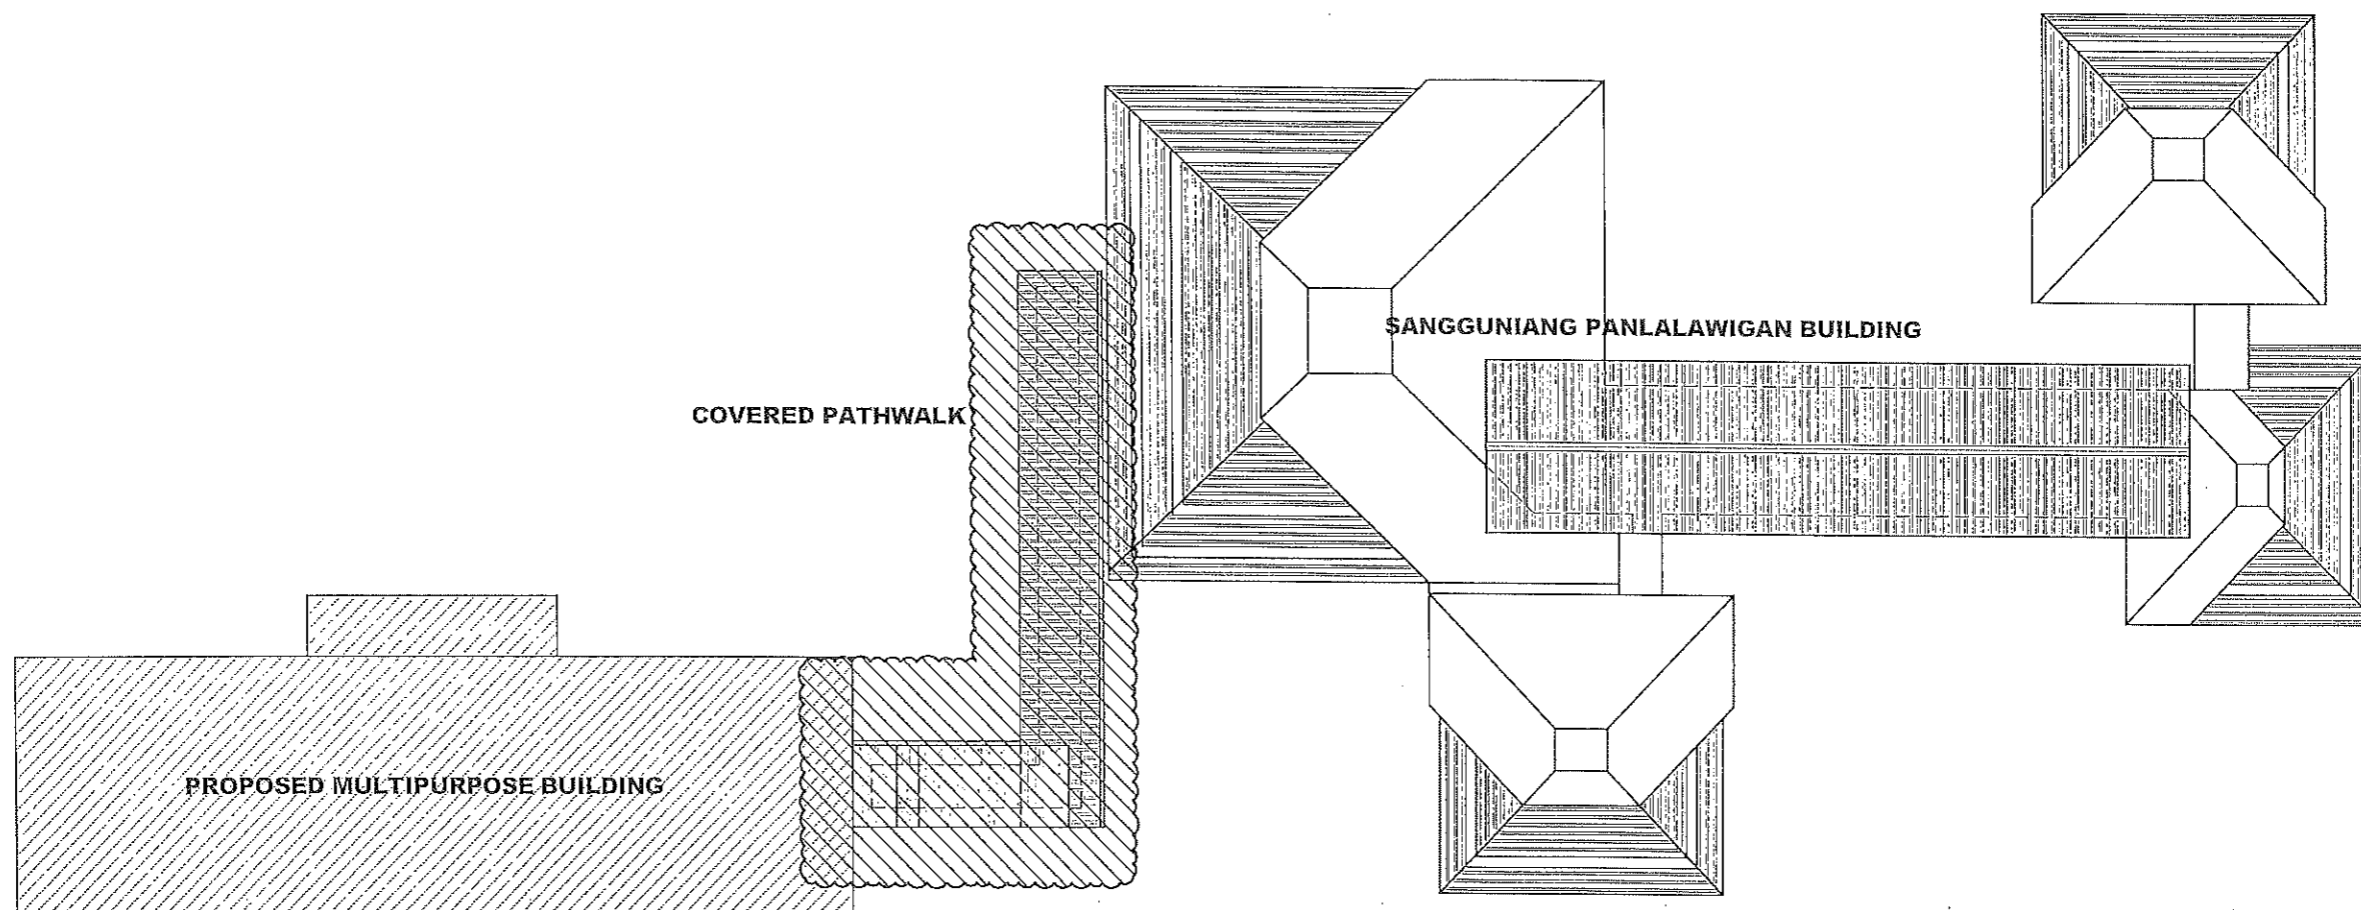


1 KEY PLAN
A-70



REPUBLIC OF THE PHILIPPINES
PROVINCIAL ENGINEER'S OFFICE
 SAN AGUSTIN, DIGOS CITY, DAVAO DEL SUR

PROJECT TITLE: REPAIR /IMPROVEMENT OF SANGGUNIANG PANLALAWIGAN BUILDING	PREPARED BY: <i>[Signature]</i> REXIE GREY B. TABAY ARCHITECT III	REVIEWED BY: <i>[Signature]</i> JOSEPH R. GONZALES ENGINEER - III PLANNING AND PROGRAMMING DIV. HEAD	RECOMMENDING APPROVAL: <i>[Signature]</i> LEONERL MARCH P. SUARIO PROVINCIAL ENGINEER	APPROVED BY: <i>[Signature]</i> YVONNE ROÑA CAGAS PROVINCIAL GOVERNOR	SHEET NO.: A-70 70 79
---	--	--	--	--	-----------------------------

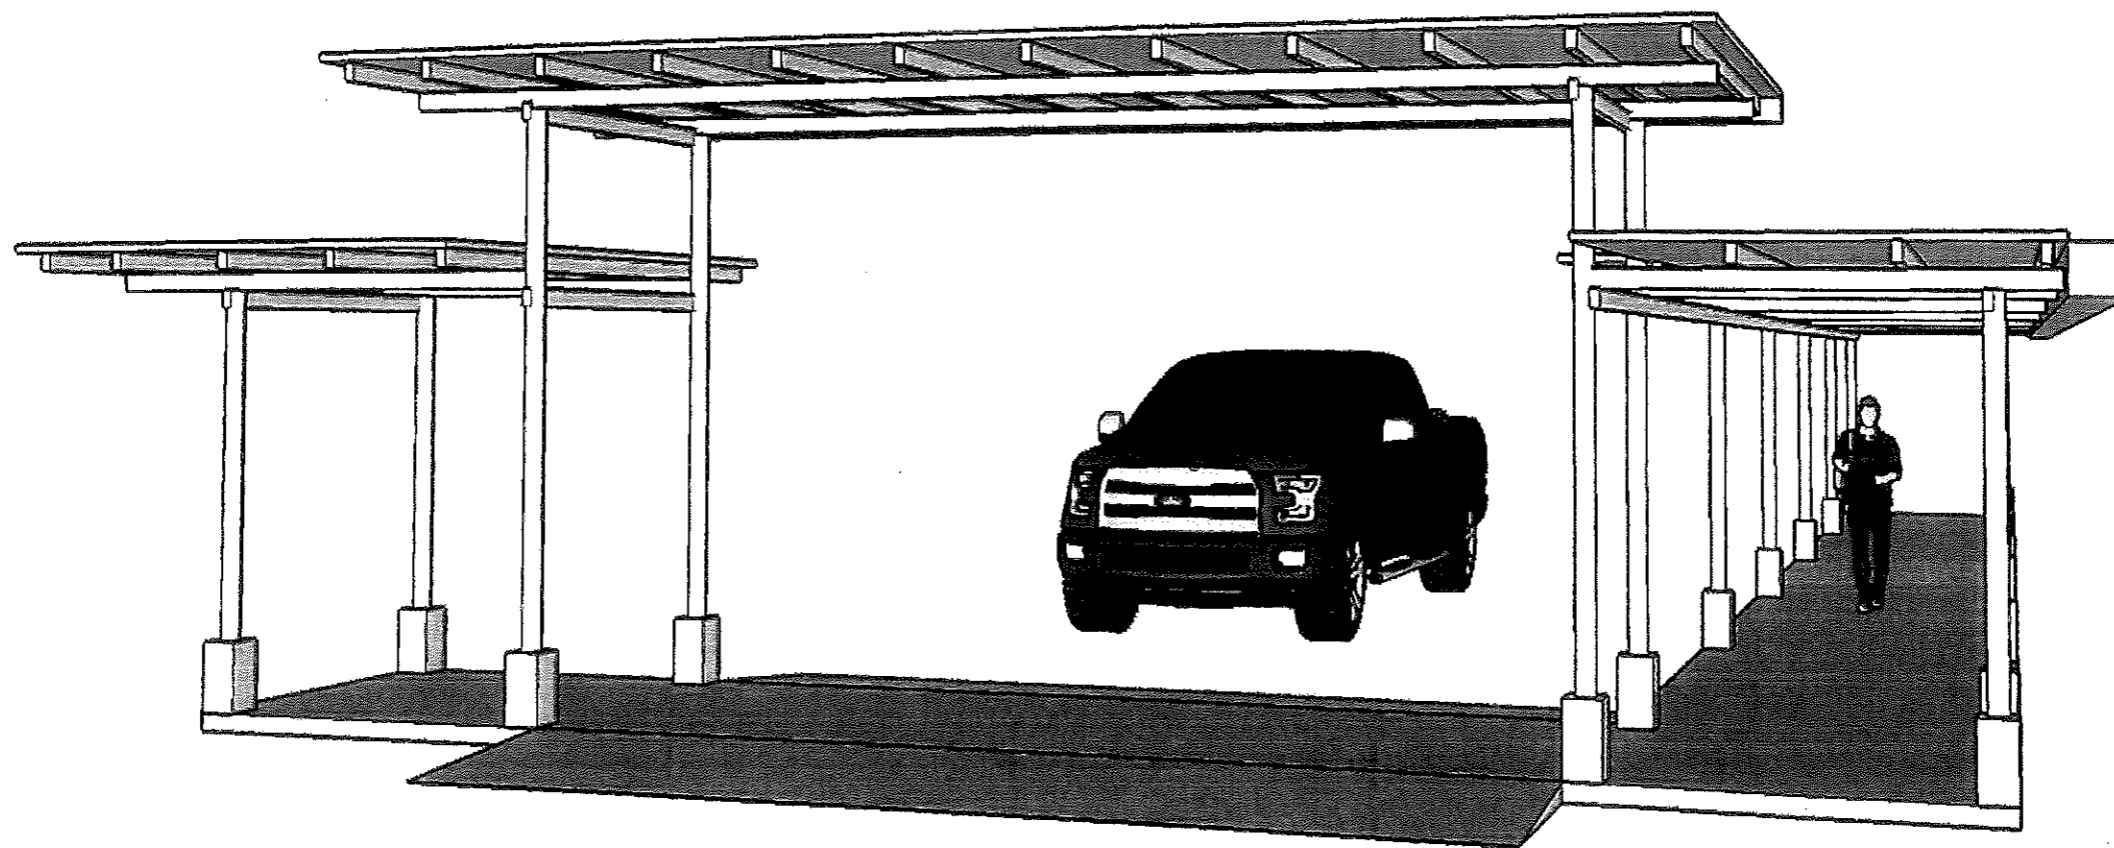


1
A-71

PERSPECTIVE



REPUBLIC OF THE PHILIPPINES
PROVINCIAL ENGINEER'S OFFICE
SAN AGUSTIN, DIGOS CITY, DAVAO DEL SUR

PROJECT TITLE: REPAIR /IMPROVEMENT OF SANGGUNIANG PANLALAWIGAN BUILDING	PREPARED BY: <i>[Signature]</i> REXIE/GREY B. TABAY ARCHITECT III	REVIEWED BY: <i>[Signature]</i> JOSEPH R. GONZALES ENGINEER - III PLANNING AND PROGRAMMING DIV. HEAD	RECOMMENDING APPROVAL: <i>[Signature]</i> LEONERL MARCH P. SUARIO PROVINCIAL ENGINEER	APPROVED BY: <i>[Signature]</i> YVONNE ROÑA CAGAS PROVINCIAL GOVERNOR	SHEET NO.: A-71 71 79
---	--	--	--	--	-----------------------------

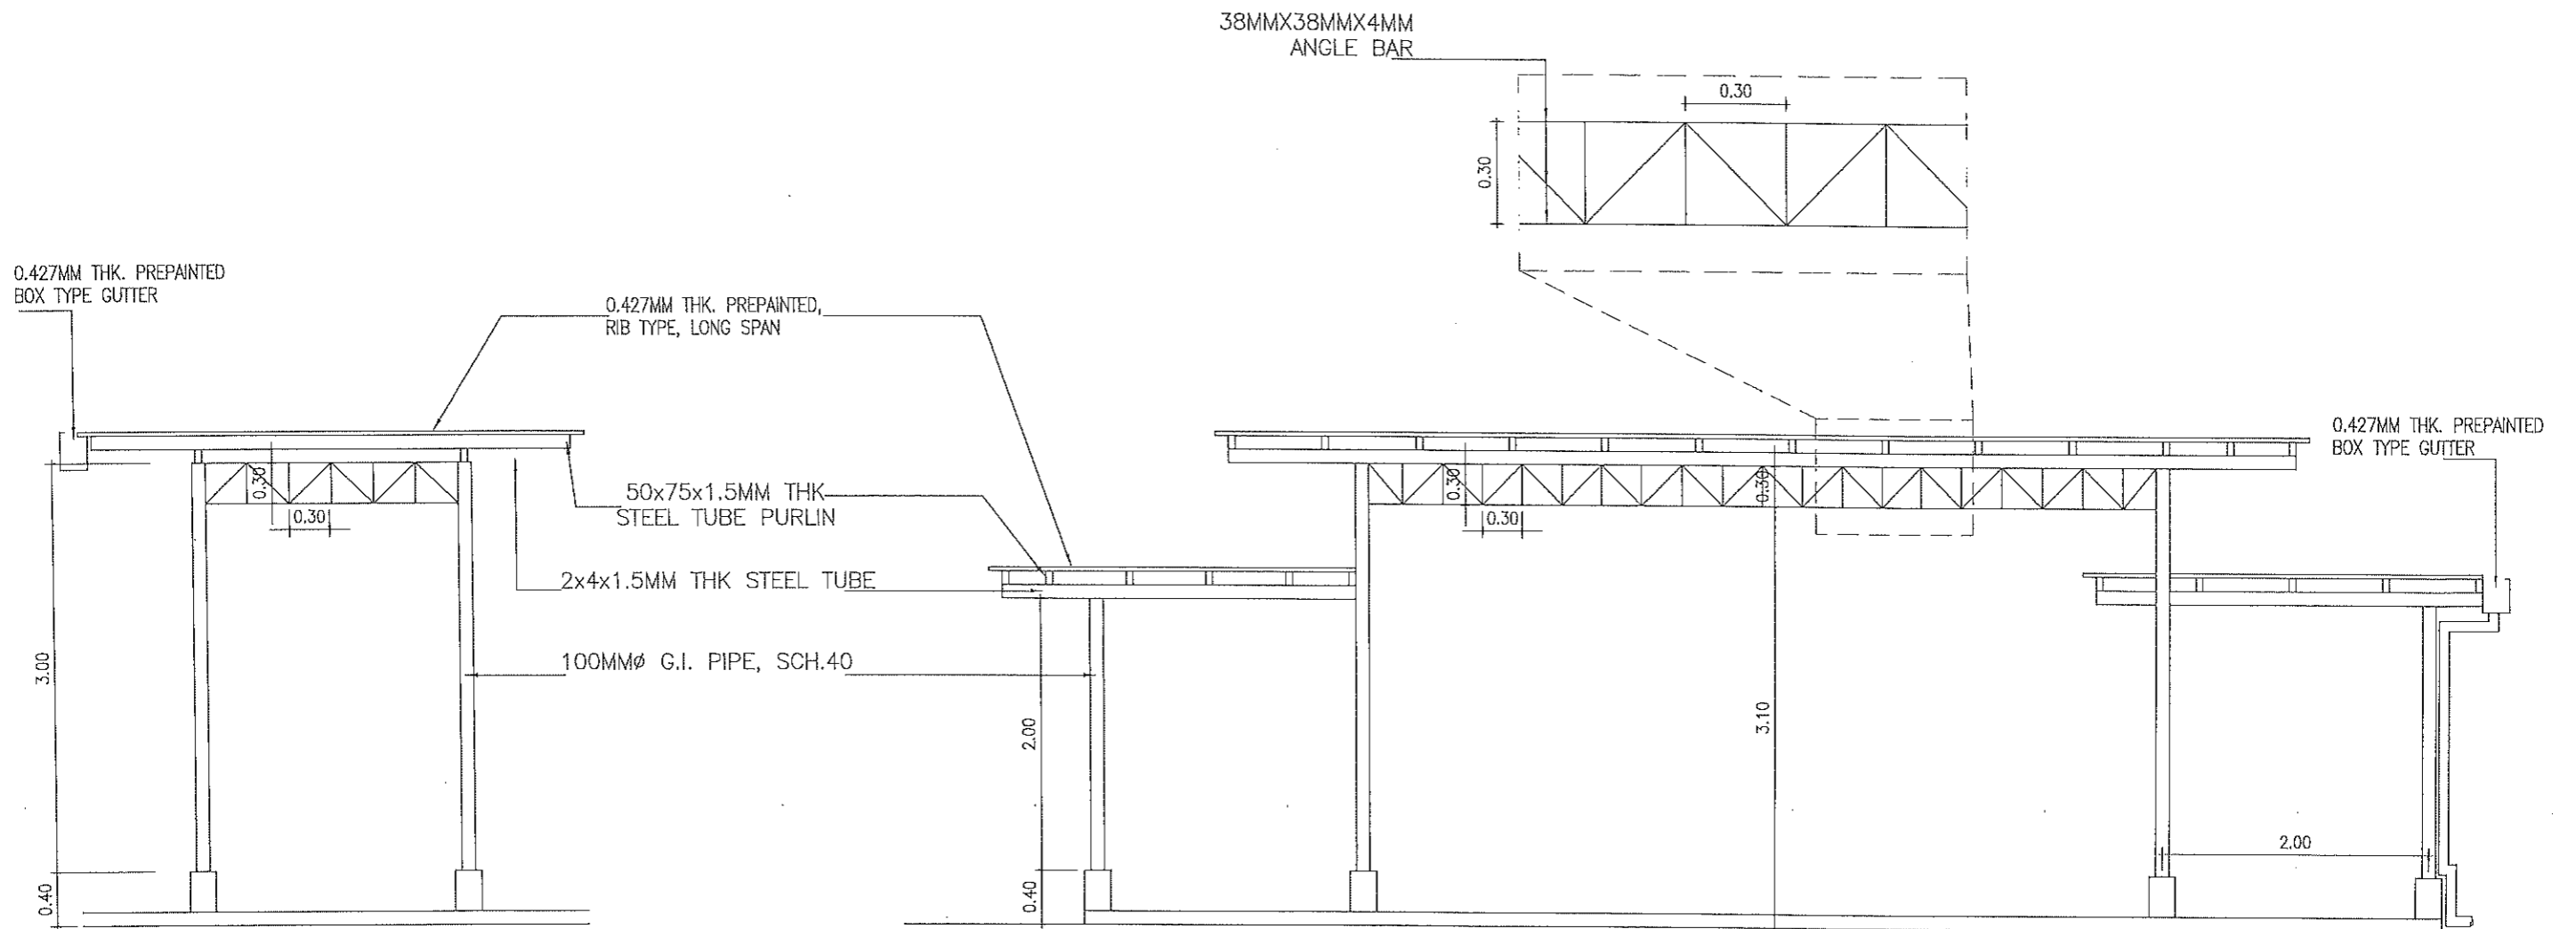

1 CROSS SECTION
 A-72 SCALE 1:20 M.

2 FRONT VIEW
 A-72 SCALE 1:20 M.



REPUBLIC OF THE PHILIPPINES
PROVINCIAL ENGINEER'S OFFICE
 SAN AGUSTIN, DIGOS CITY, DAVAO DEL SUR

PROJECT TITLE:
**REPAIR /IMPROVEMENT OF SANGGUNIANG
 PANLALAWIGAN BUILDING**
 LOCATION:
 MATTI, DIGOS CITY, DAVAO DEL SUR


PREPARED BY:
[Signature]
REXIE GREY B. TABAY
 ARCHITECT III

REVIEWED BY:
[Signature]
JOSEPH R. GONZALES
 ENGINEER, III
 PLANNING AND PROGRAMMING DIV. HEAD


RECOMMENDING APPROVAL:
[Signature]
LEONERL MARGH P. SUARIO
 PROVINCIAL ENGINEER

APPROVED BY:
[Signature]
YVONNE ROÑA CAGAS
 PROVINCIAL GOVERNOR

SHEET NO.:
A-72
 72 79

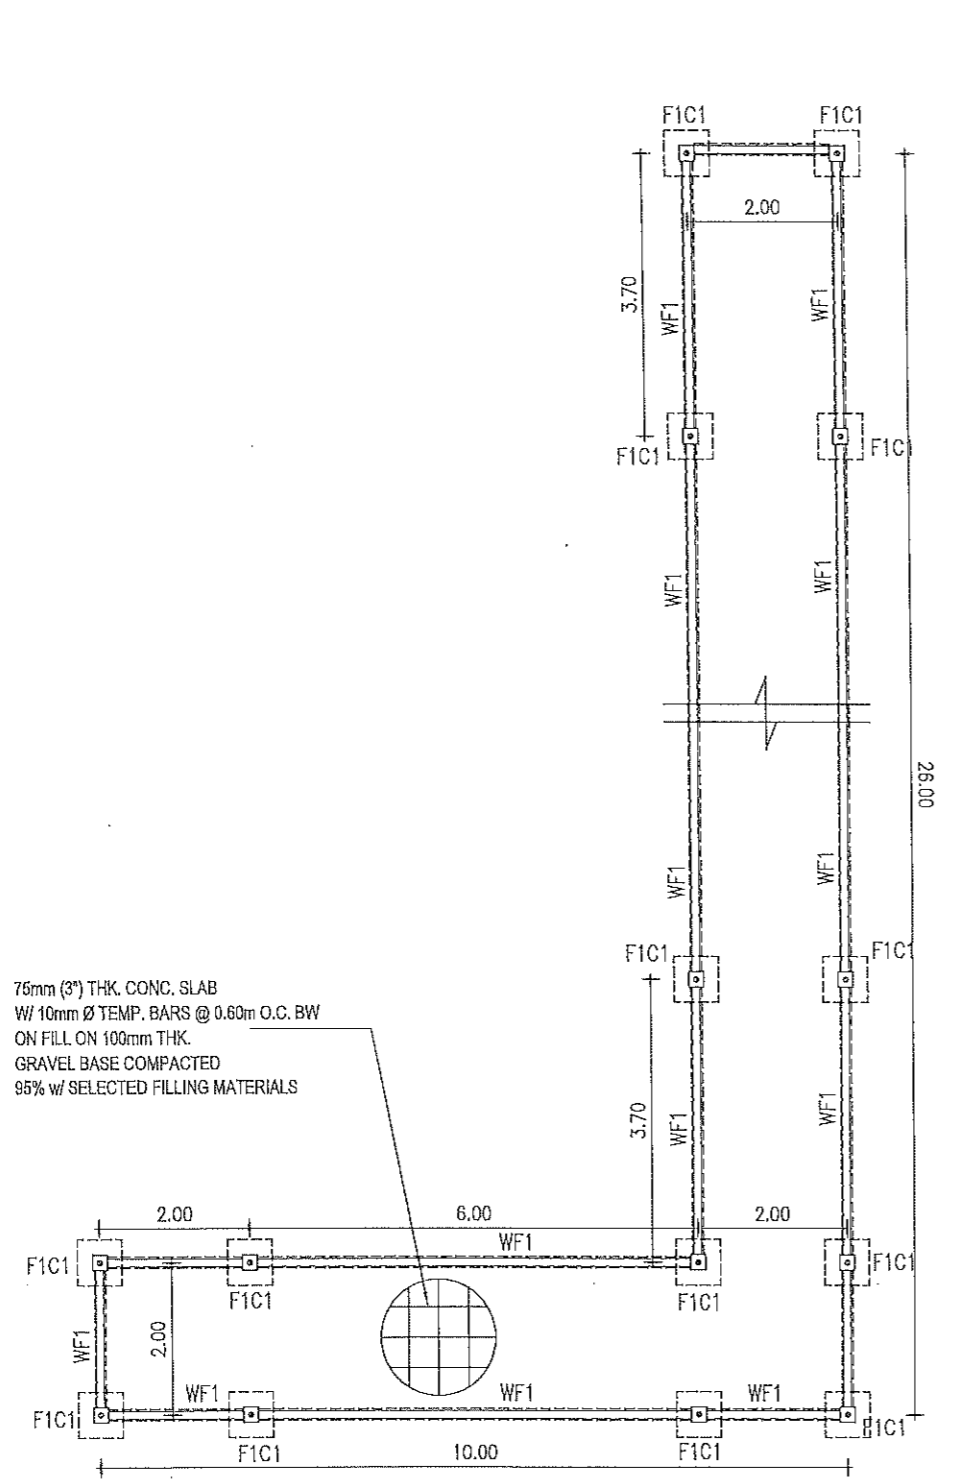

1 FOUNDATION PLAN
S-1 SCALE 1:20 M.

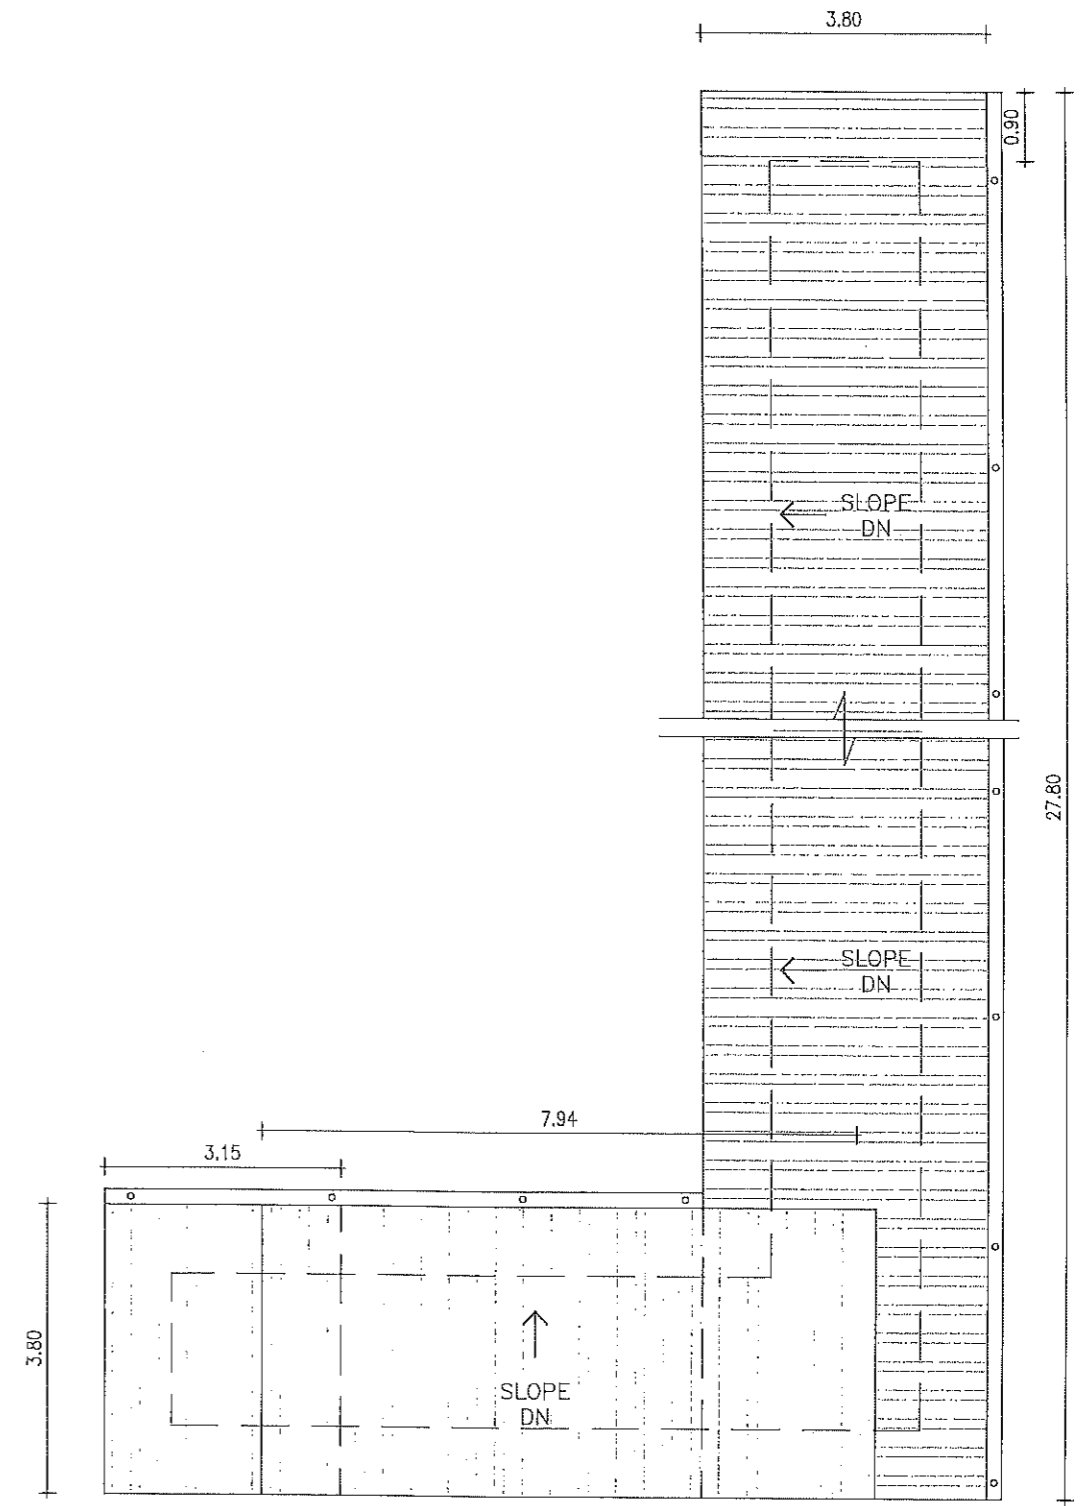

2 ROOF PLAN
S-1 SCALE 1:100 M.



REPUBLIC OF THE PHILIPPINES
PROVINCIAL ENGINEER'S OFFICE
SAN AGUSTIN, DIGOS CITY, DAVAO DEL SUR

PROJECT TITLE:
**REPAIR /IMPROVEMENT OF SANGGUNIANG
PANLALAWIGAN BUILDING**

LOCATION:
MATTI, DIGOS CITY, DAVAO DEL SUR




PREPARED BY:
[Signature]
REXIE GREY B. TABAY
ARCHITECT III

REVIEWED BY:
[Signature]
JOSEPH R. GONZALES
ENGINEER - III
PLANNING AND PROGRAMMING DIV. HEAD

RECOMMENDING APPROVAL:
[Signature]
LEONERL MARCH P. SUARIO
PROVINCIAL ENGINEER

APPROVED BY:
[Signature]
YVONNE RONA CAGAS
PROVINCIAL GOVERNOR

SHEET NO.:
S-1
73 79

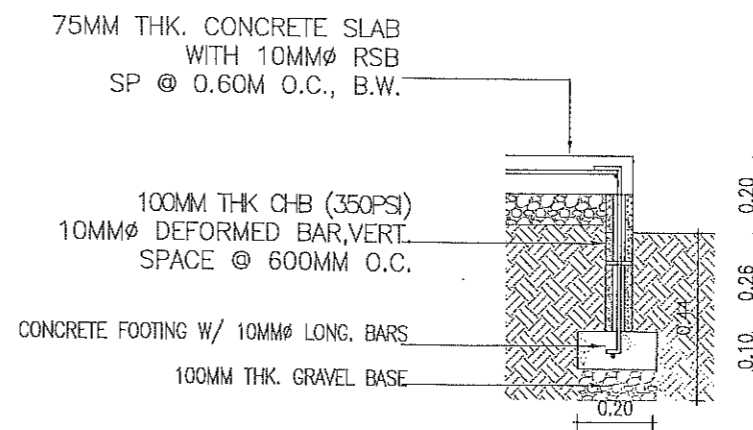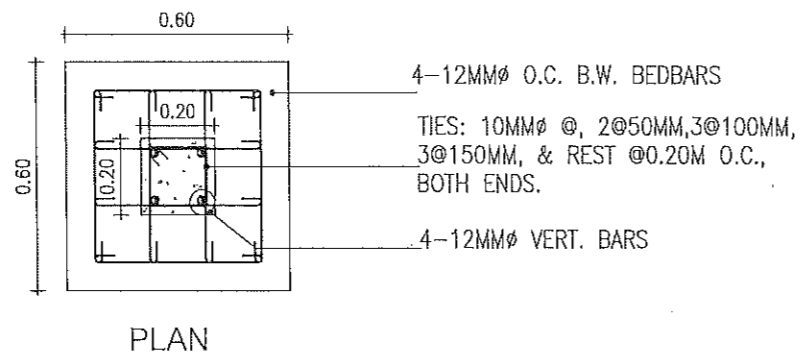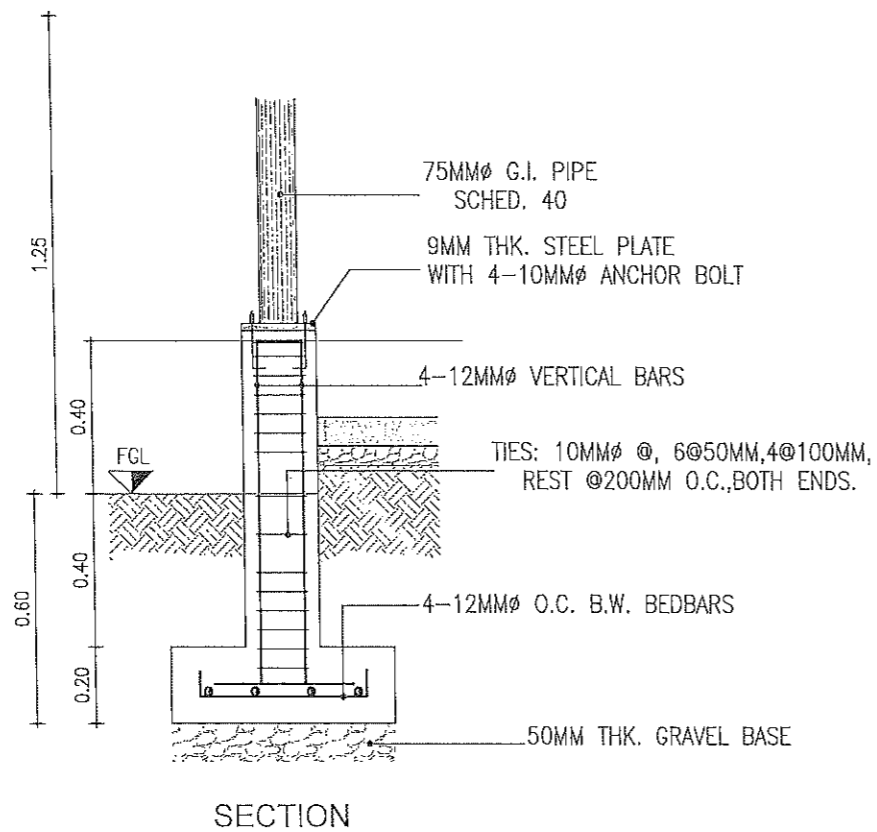

1 F1C1 DETAIL
S-2 SCALE 1:20 M.

2 WALL FOOTING (WF- 01) DET.
S-2 SCALE 1:20



REPUBLIC OF THE PHILIPPINES
PROVINCIAL ENGINEER'S OFFICE
SAN AGUSTIN, DIGOS CITY, DAVAO DEL SUR

PROJECT TITLE:
REPAIR /IMPROVEMENT OF SANGGUNIANG
PANLALAWIGAN BUILDING
LOCATION:
MATTI, DIGOS CITY, DAVAO DEL SUR


PREPARED BY:
[Signature]
REXIE GREY B. TABAY
ARCHITECT III

REVIEWED BY:
[Signature]
JOSEPH R. GONZALES
ENGINEER - IN
PLANNING AND PROGRAMMING DIV. HEAD

RECOMMENDING APPROVAL:
[Signature]
LEONERL MARCH P. SUARIO
PROVINCIAL ENGINEER

APPROVED BY:
[Signature]
YVONNE RONALD CAGAS
PROVINCIAL GOVERNOR

SHEET NO.:
S-2
74 79

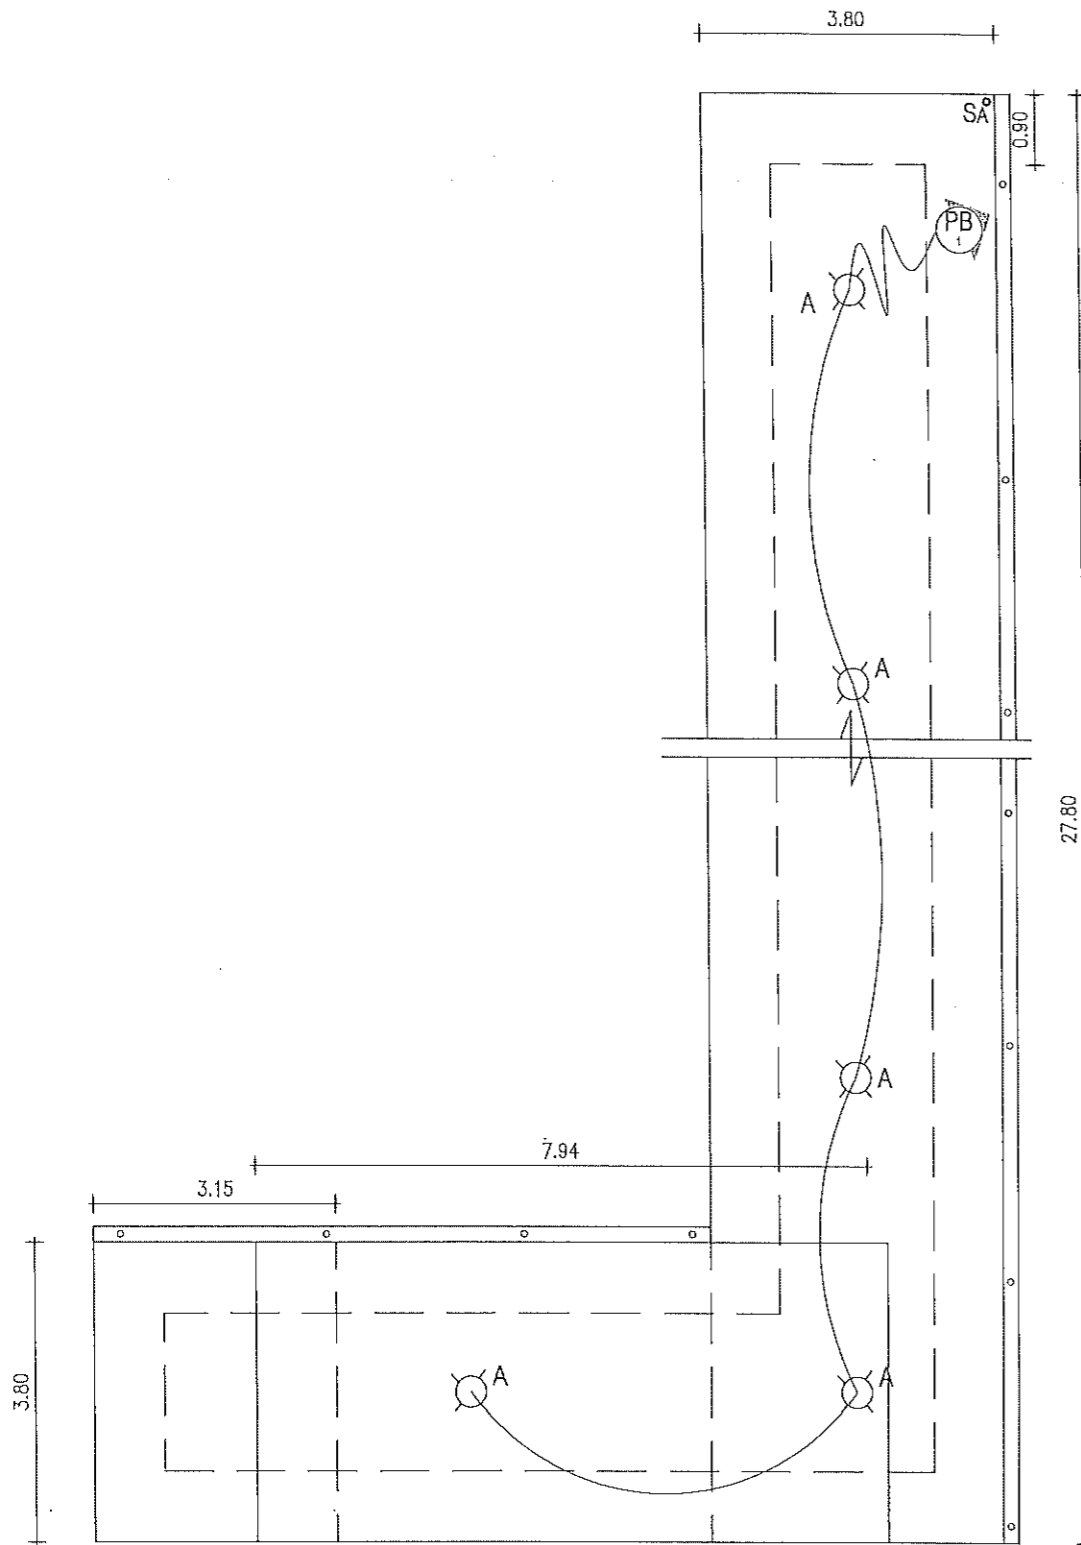

LOAD SCHEDULE :

CIRCUIT NO.	DESCRIPTION	QUANTITY	VOLTS	WATTS	AMPS	TRIP	CONDUCTOR SIZE	CONDUIT SIZE
PB 1	LIGHTING OUTLET	6	230	300	1.30	20 A	2-3.5 mm ² THW Stranded Copper Wire , 1 - 2.0 mm ² THW Stranded Copper Wire	20 mm dia. uPVC

NOTE:

- CONNECT TO EXISTING PANEL BOARD FOR POWER SOURCE

LEGEND:

⊗ 4" Ø uPVC RECEPTACLE W/ 9 WATTS LED BULB, DAYLIGHT

⊗ PB CIRCUIT HOMERUN (CONNECT TO EXISTING PANELBOARD)

⊙ SA ONE-GANG SWITCH WITH PLATE, FLUSH TYPE

1
E-1

COVERED WALK LIGHTING LAYOUT

SCALE

1:50



REPUBLIC OF THE PHILIPPINES
PROVINCIAL ENGINEER'S OFFICE
SAN AGUSTIN, DIGOS CITY, DAVAO DEL SUR

PROJECT TITLE:
REPAIR /IMPROVEMENT OF SANGGUNIANG PANLALAWIGAN BUILDING
LOCATION:
MATTI, DIGOS CITY, DAVAO DEL SUR

PREPARED BY:
Mary Flor L. Hectin
MARY FLOR L. HECTIN
ENGINEER I


REVIEWED BY:
Joseph R. Gonzales
JOSEPH R. GONZALES
ENGINEER - III
PLANNING AND PROGRAMMING DIV. HEAD

RECOMMENDING APPROVAL:
Leonerl March P. Suarico
LEONERL MARCH P. SUARICO
PROVINCIAL ENGINEER

APPROVED BY:
Yvonne Rona Cagas
YVONNE RONA CAGAS
PROVINCIAL GOVERNOR

SHEET NO.:
A-75
75 79

GENSET ROOM

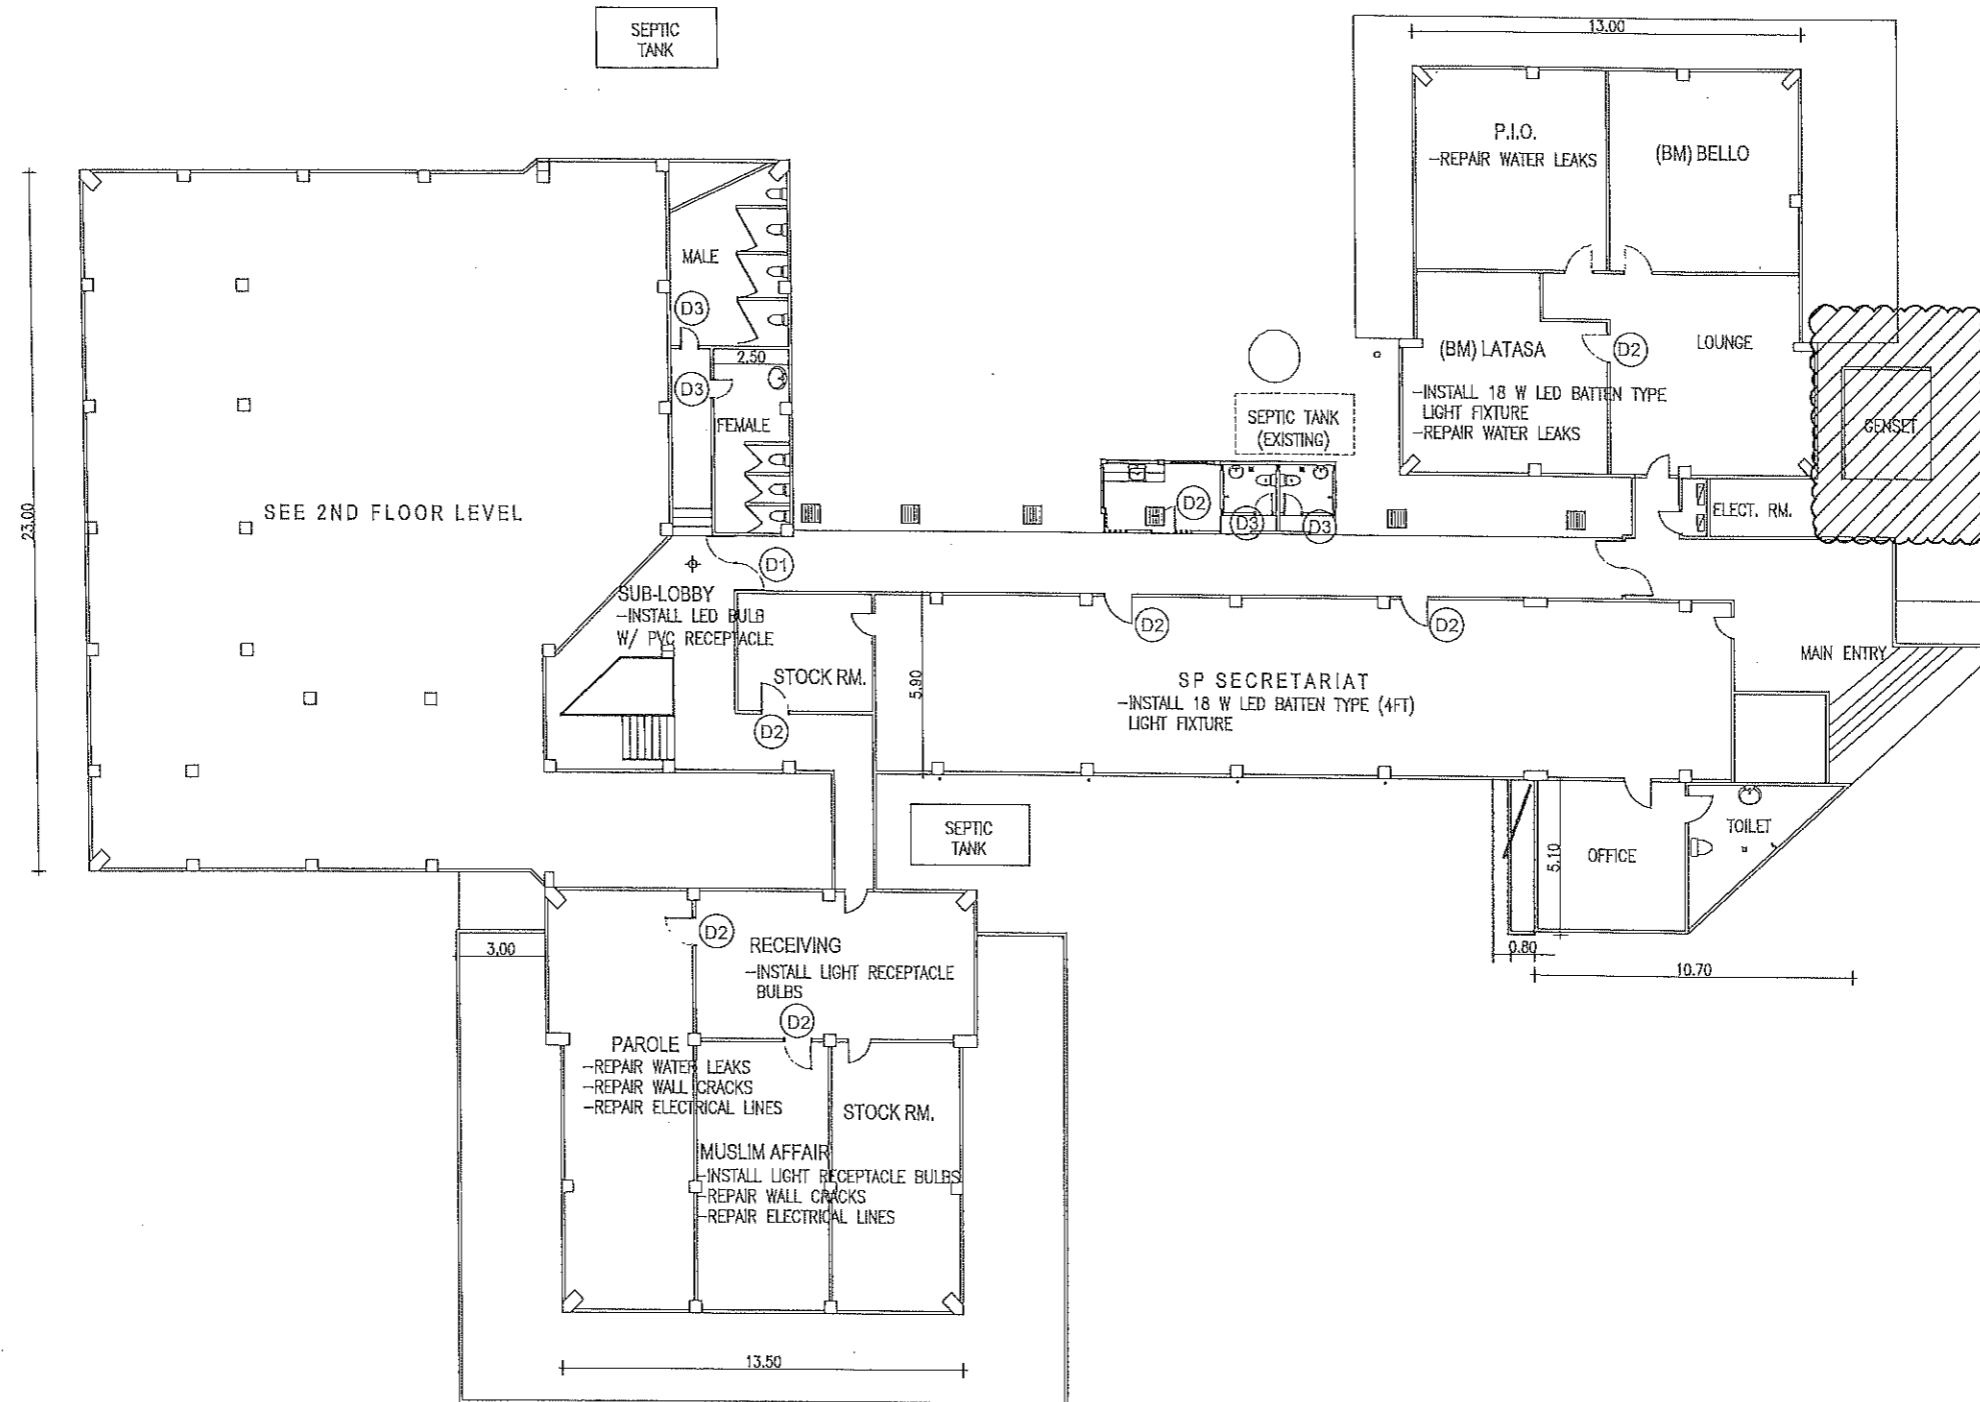

GENSET ROOM KEY PLAN

1
A-76



REPUBLIC OF THE PHILIPPINES
PROVINCIAL ENGINEER'S OFFICE
SAN AGUSTIN, DIGOS CITY, DAVAO DEL SUR

PROJECT TITLE:
**REPAIR /IMPROVEMENT OF SANGGUNIANG
PANLALAWIGAN BUILDING**

LOCATION:
MATTI, DIGOS CITY, DAVAO DEL SUR



PREPARED BY:
[Signature]
REXIE GREY B. TABAY
ARCHITECT III

REVIEWED BY:
[Signature]
JOSEPH R. GONZALES
ENGINEER - II
PLANNING AND PROGRAMMING DIV. HEAD

RECOMMENDING APPROVAL:
[Signature]
LEONERL MARCH P. SUARIO
PROVINCIAL ENGINEER

APPROVED BY:
[Signature]
YVONNE ROÑA CAGAS
PROVINCIAL GOVERNOR

SHEET NO.:
A-76
76 79

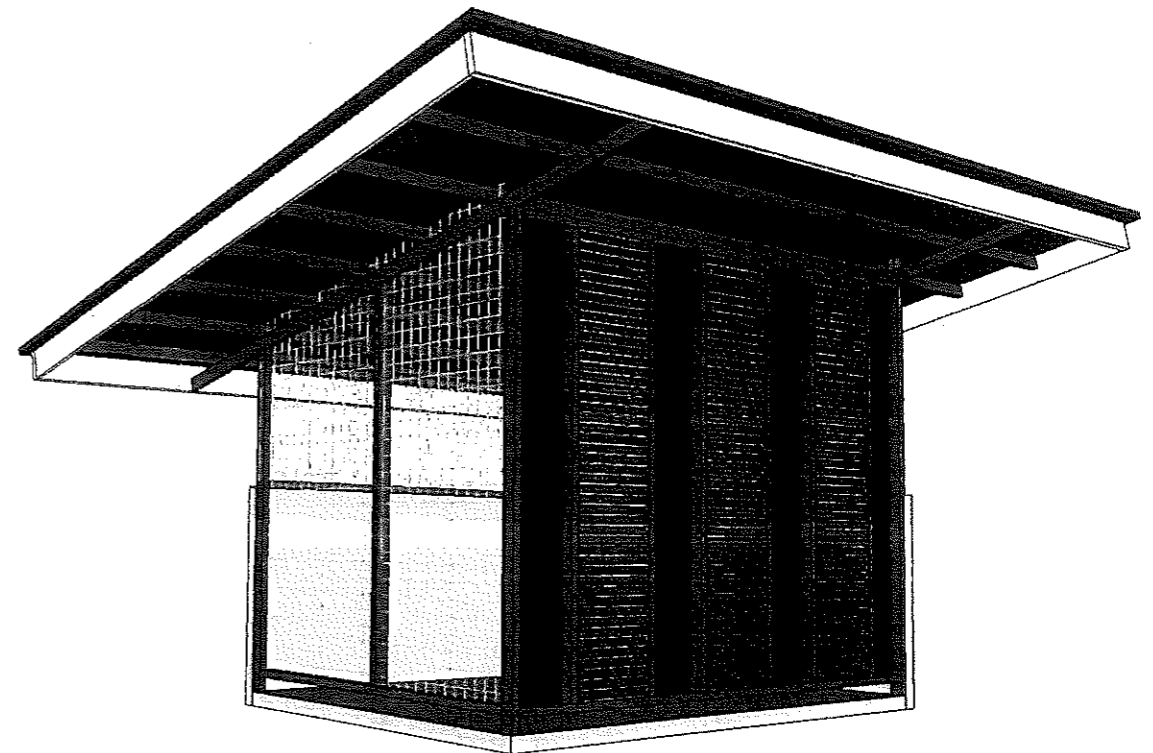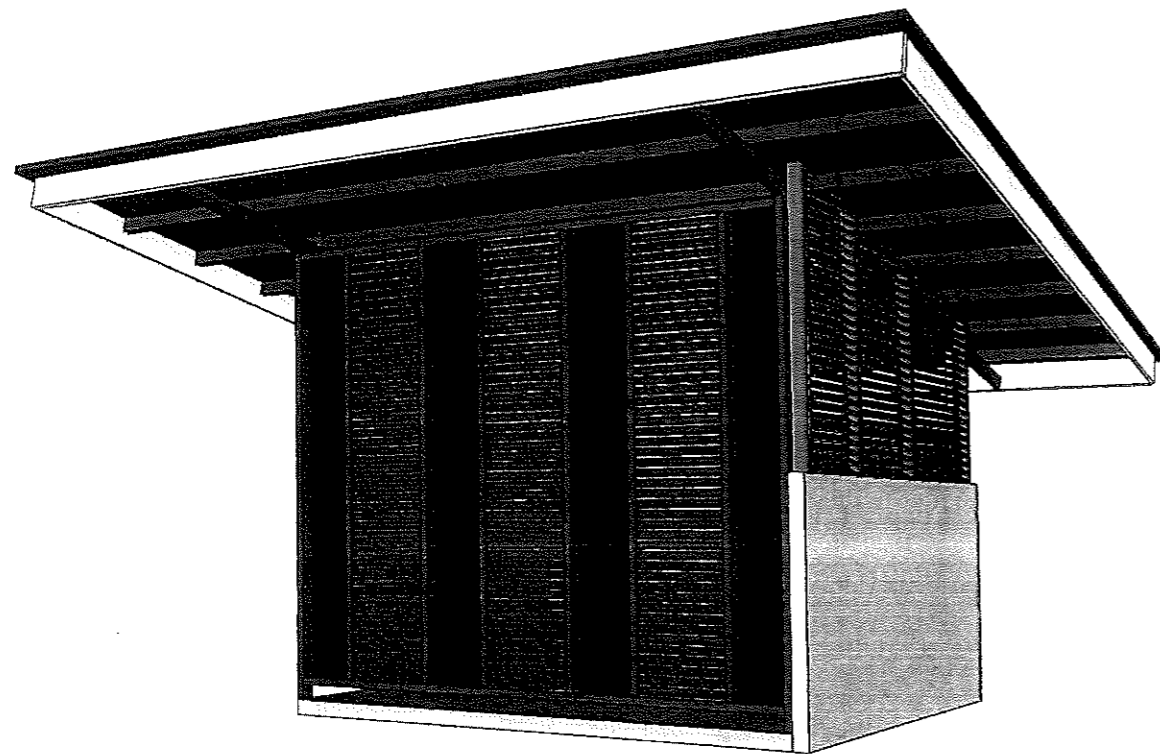


1
A-77

**PERSPECTIVE
GENSET ROOM**




REPUBLIC OF THE PHILIPPINES
PROVINCIAL ENGINEER'S OFFICE
SAN AGUSTIN, DIGOS CITY, DAVAO DEL SUR


PROJECT TITLE: REPAIR /IMPROVEMENT OF SANGGUNIANG PANLALAWIGAN BUILDING	PREPARED BY: REXIE GREY B. TABAY ARCHITECT III	REVIEWED BY: JOSEPH R. GONZALES ENGINEER - III PLANNING AND PROGRAMMING DIV. HEAD	RECOMMENDING APPROVAL: LEONERL MARCH P. SUARIO PROVINCIAL ENGINEER	APPROVED BY: YVONNE ROÑA CAGAS PROVINCIAL GOVERNOR	SHEET NO.: A-77 77 79
---	--	--	--	--	-----------------------------

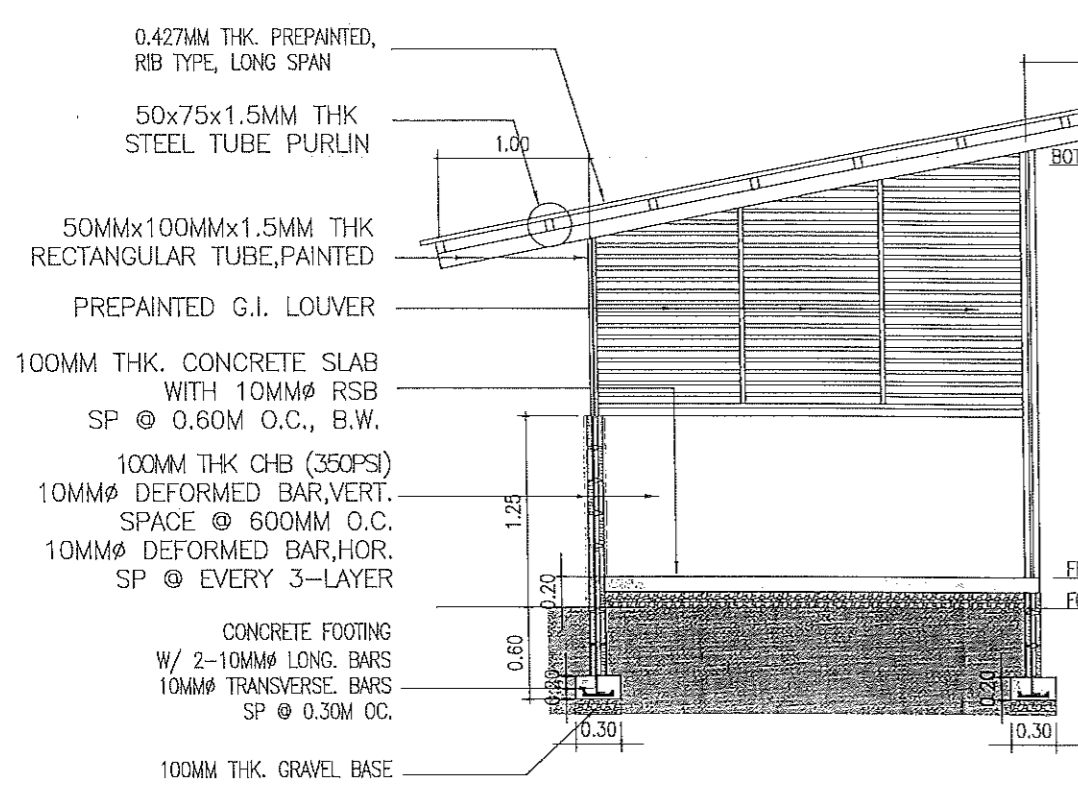


3 CROSS SECTION
 A-78 SCALE 1:50 M.

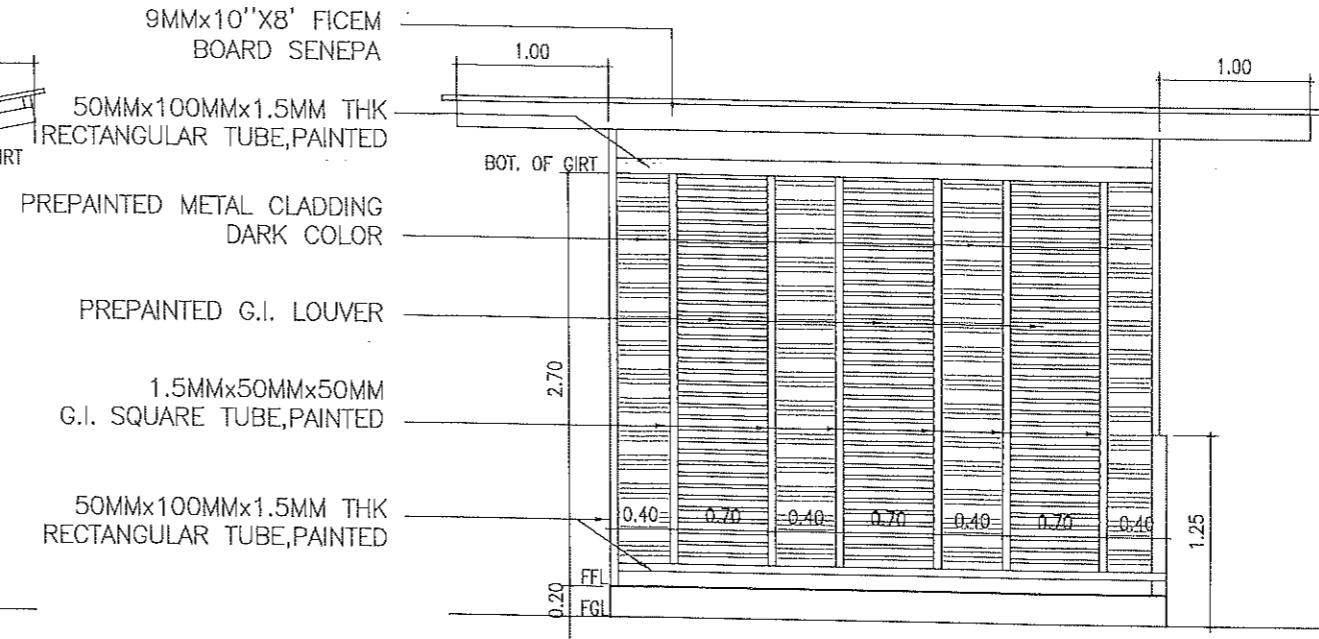

4 FRONT ELEVATION
 A-78 SCALE 1:50 M.

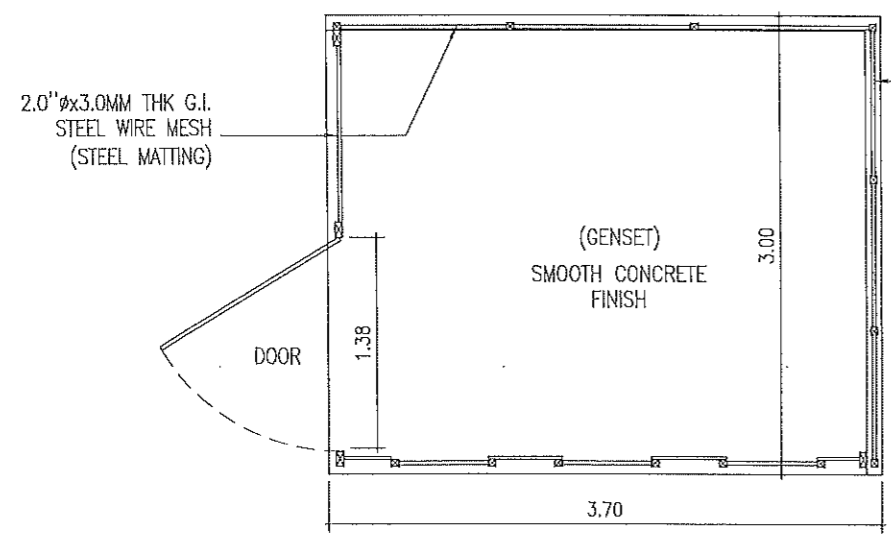

1 FLOOR PLAN
 A-78 SCALE 1:20 M.

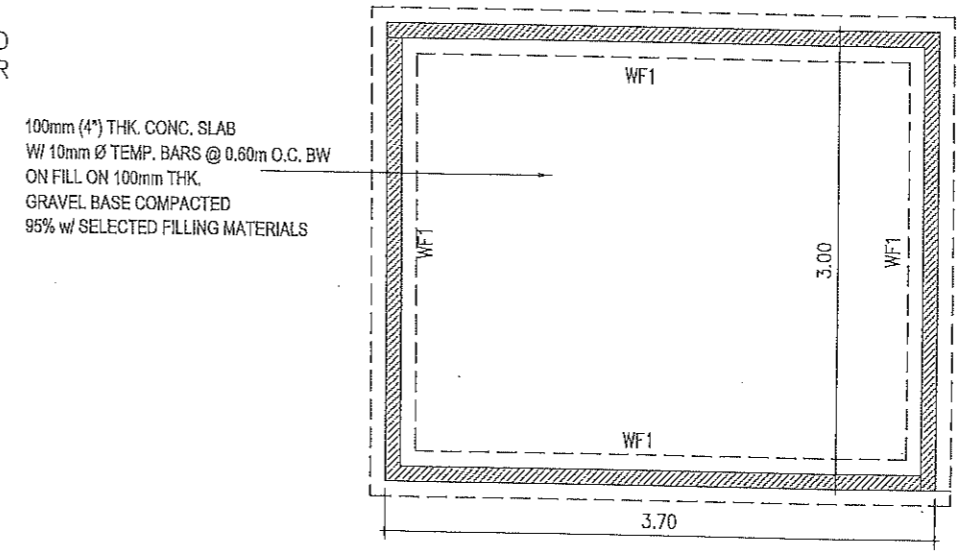

2 FOUNDATION PLAN
 A-78 SCALE 1:50 M.



REPUBLIC OF THE PHILIPPINES
PROVINCIAL ENGINEER'S OFFICE
 SAN AGUSTIN, DIGOS CITY, DAVAO DEL SUR

PROJECT TITLE:
REPAIR /IMPROVEMENT OF SANGGUNIANG PANLALAWIGAN BUILDING
 LOCATION:
 MATTI, DIGOS CITY, DAVAO DEL SUR


PREPARED BY:
[Signature]
REXIE GREY B. TABAY
 ARCHITECT III

REVIEWED BY:
[Signature]
JOSEPH R. GONZALES
 ENGINEER - III
 PLANNING AND PROGRAMMING DIV. HEAD

RECOMMENDING APPROVAL:
[Signature]
LEONERL MARCH P. SUARIO
 PROVINCIAL ENGINEER

APPROVED BY:
[Signature]
YVONNE ROÑA CAGAS
 PROVINCIAL GOVERNOR

SHEET NO.:
A-78
 78 79

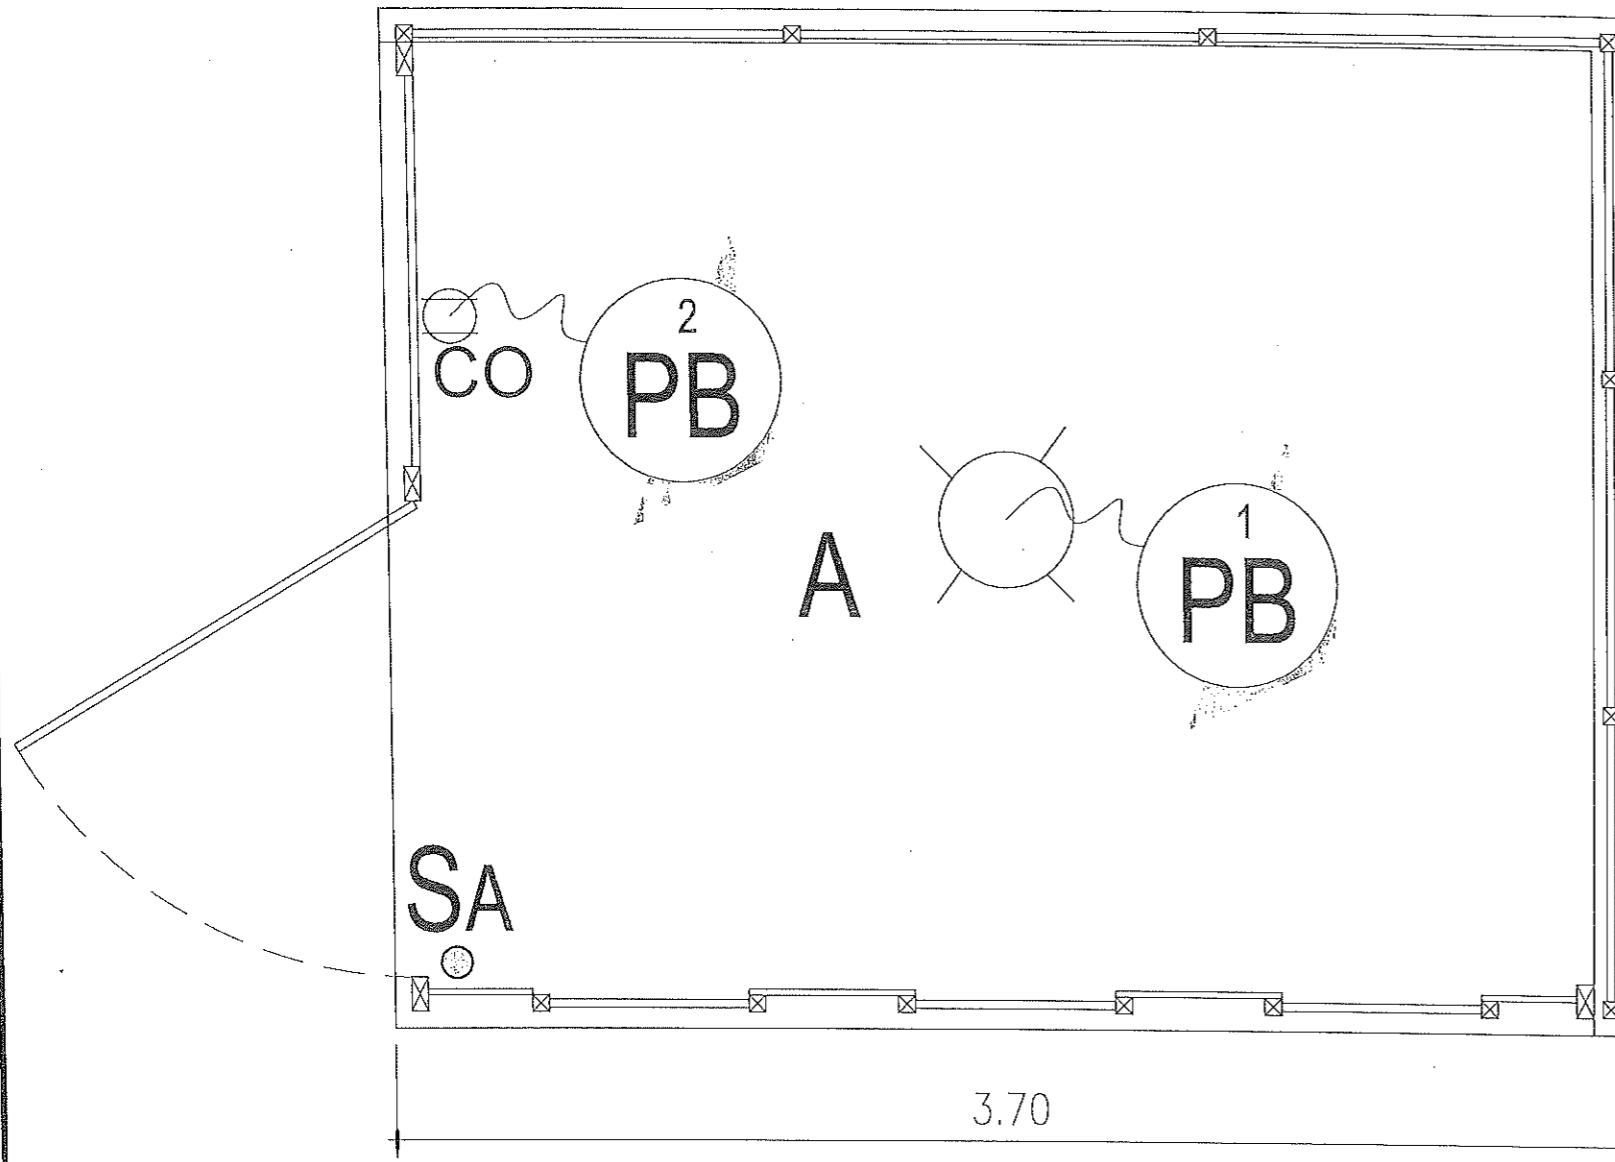

LOAD SCHEDULE :

CIRCUIT NO.	DESCRIPTION	QUANTITY	VOLTS	WATTS	AMPS	TRIP	CONDUCTOR SIZE	CONDUIT SIZE
PB 1	LIGHTING OUTLET	1	230	50	0.22	20 A	2- 3.5 mm ² THW Stranded Copper Wire , 1 - 2.0 mm ² THW Stranded Copper Wire	20 mm dia. uPVC
PB 2	CONVENIENCE OUTLET	1	230	180	0.78	20 A	2- 3.5 mm ² THW Stranded Copper Wire , 1 - 2.0 mm ² THW Stranded Copper Wire	20 mm dia. uPVC

NOTE:

- CONNECT TO EXISTING PANEL BOARD FOR POWER SOURCE

LEGEND:

- 4" Ø uPVC RECEPTACLE W/ 9 WATTS LED BULB, DAYLIGHT
- TWO-GANG CONVENIENCE UNIVERSAL OUTLET
- CIRCUIT HOMERUN (CONNECT TO EXISTING PANELBOARD)
- ONE-GANG SWITCH WITH PLATE, FLUSH TYPE

1
E-1

GENSET ROOM ELECTRICAL ROOM

SCALE

1:50



REPUBLIC OF THE PHILIPPINES
PROVINCIAL ENGINEER'S OFFICE
SAN AGUSTIN, DIGOS CITY, DAVAO DEL SUR

PROJECT TITLE:
REPAIR /IMPROVEMENT OF SANGGUNIANG
PANLALAWIGAN BUILDING
LOCATION:
MATTI, DIGOS CITY, DAVAO DEL SUR

PREPARED BY:
Mary Flor L. Hectin
MARY FLOR L. HECTIN
ENGINEER I

REVIEWED BY:
Joseph R. Gonzales
JOSEPH R. GONZALES
ENGINEER
PLANNING AND PROGRAMMING DIV. HEAD

RECOMMENDING APPROVAL:
Leonerl March P. Suario
LEONERL MARCH P. SUARIO
PROVINCIAL ENGINEER

APPROVED BY:
Yvonne Roñacagas
YVONNE ROÑACAGAS
PROVINCIAL GOVERNOR

SHEET NO.:
E-1
79 79

SECTION VIII.

BILL OF QUANTITIES

[See attached file.]

A

Republic of the Philippines
PROVINCE OF DAVAO DEL SUR
PROVINCIAL ENGINEER'S OFFICE
Samariguatan, Digos City

BILL OF QUANTITIES

Contract Name : REPAIR/IMPROVEMENT OF SANGUNIANG PANALAWIGAN BUILDING

Location of the Contract : MATI, DIGOS CITY, DAVAO DEL SUR

Project Duration : 75 Calendar Days

SUMMARY OF BID PRICES
(All Parts of Bill of Quantities)

1. Part No. - Enter the "Part No." for each section of the Bill of Quantities (BOQ) where unit prices are entered.
2. Part Description - Enter the "Part Description" corresponding to the "Part No."
3. Total Amount - Enter the "total amount" in Pesos for all pages having the same "Part Description".
4. Adopting Green Procurement Policy by SBAC Resolution No. 140 series of 2019.

Contract ID:	Part Description	Total Amount
B.5	Project Billboard/Signboard	P
B.7	Occupational Safety and Health	P
801(1)	Removal of Structures and Obstruction	P
803(1)a	Structure Excavation, (Common Soil)	P
804(7)	Gravel Fill	P
900(2)a	Structural Concrete, Class B, 7 Days	P
903(1)a1	Reinforcing Steel (Deformed) Grade 40	P
903(1)	Formworks and Falseworks	P
1046(2)a1	CHB Non-Load Bearing(Including reinforcing Steel),100mm	P
1027(1)	Cement Plaster Finish	P
1010(2)b	Doors (Wood Panel)	P
1010(1)	Frames (Jambs, Sills, Head Transoms and Mullions)	P
1004 (2)	Finishing Hardware	P
1004 (2)	Carpentry & Joinery Works	P
1004 (2)	Gypsum Board on Metal Frame Ceiling	P
1004 (2)	4.5 mm Marine plywood on metal frame ceiling	P
1004 (2)	Glazed Tiles	P
1004 (2)	Unglazed Tiles	P
1004 (2)	Aluminum Glass Door, (Sliding/Fixed Type)	P
1010 (2)	6.0mm thk. Fiber Cement Board on Metal Frame Double Wall Partition	P
1014(1)b2	Pre-painted Metal Sheets, above 0.427 mm, Rib Type, Long Span	P
1013(2)a2	Fabricated Metal Roofing Accessory, Gauge 26 (0.551 mm), Flashing	P
1013(2)b1	Fabricated Metal Roofing Accessory, Gauge 24 (0.701 mm), Gutters	P
1002(4)	Plumbing Fixtures	P
1001(1.1)	Septic Vault/Tank,Concrete/CHB	P
1019(1)	Wood Tiles (Narra, Tanguile, others)	P
1047 (8)	Structural Steel	P
1001(9)	Storm Drainage Downspout	P
1032(1)a	Painting Works, Masonry/Concrete	P
1032(1)b	Painting Works, Wood	P
1032(1)c	Painting Works, Steel	P
SPL-I	Siphoning/Cleaning of Septic Tank	P
SPL-II	Supply & Installation of Ergodynamic Deluxe Theater Seat	P
SPL-III	Installation of WPC Flute Panel	P
SPL-IV	Tempered Glass Railing	P
SPL-V	20mm thk. Granite Slab	P
SPL-VI	PVC Ceiling	P
SPL-VII	Carpet Floor	P
SPL-VIII	Davao del Sur Logo	P
1100 (10)	Conduits, Boxes & Fittings (Conduit Works/Conduit Rough-in)	P
1101(33)	Wires and Wiring Devices	P
1103 (1)	Lighting Fixtures	P
1200 (1)	Ventilating Equipment	P
Total of All Amounts		P

Total of All Amounts In Words:
 PESOS

_____ and _____ centavos

Name : _____ In capacity of _____

Signed : _____ Date _____

Duly authorized to sign the Bid for and on behalf of _____

Contract Name : REPAIR / IMPROVEMENT OF SANGGUNIANG PANLALAWIGAN BUILDING

Location of the Contract : Matti, Digos City, Davao Del Sur
 Project Duration : 75 Calendar Days

BILL OF QUANTITIES

Part No. _____ :

Pay Item No.	Description	Unit	Quantity	Unit Price (Pesos)	Amount (Pesos)
1	2	3	4	5	6
B.5	Project Billboard/Signboard	each	1.00	In words: _____ In figures: _____	In words: _____ In figures: _____
B.7	Occupational Safety and Health	l.s.	1.00	In words: _____ In figures: _____	In words: _____ In figures: _____
801(1)	Removal of Structures and Obstruction	l.s.	1.00	In words: _____ In figures: _____	In words: _____ In figures: _____
803(1)a	Structure Excavation, (Common Soil)	cu.m.	34.26	In words: _____ In figures: _____	In words: _____ In figures: _____
804(7)	Gravel Fill	cu.m.	8.39	In words: _____ In figures: _____	In words: _____ In figures: _____

Submitted by: _____

Date : _____

Name of the Representative of the Bidder _____

Position _____

Name of Bidder _____

Contract Name : REPAIR / IMPROVEMENT OF SANGGUNIANG PANLALAWIGAN BUILDING

Location of the Contract : Matti, Digos City, Davao Del Sur
 Project Duration : 75 Calendar Days

BILL OF QUANTITIES

Part No. _____

Pay Item No.	Description	Unit	Quantity	Unit Price (Pesos)	Amount (Pesos)
1	2	3	4	5	6
900(2)a	Structural Concrete, Class B, 7 Days	cu.m.	37.97	In words: _____ In figures: _____	In words: _____ In figures: _____
902(1)a1 40	Reinforcing Steel (Deformed) Grade	kgs.	381.60	In words: _____ In figures: _____	In words: _____ In figures: _____
903(1)	Formworks and Falseworks	l.s.	1.00	In words: _____ In figures: _____	In words: _____ In figures: _____
1046(2)a1	CHB Non-Load Bearing(Including reinforcing Steel),100mm	sq.m.	43.22	In words: _____ In figures: _____	In words: _____ In figures: _____
1027(1)	Cement Plaster Finish	sq.m.	43.43	In words: _____ In figures: _____	In words: _____ In figures: _____

Submitted by: _____

Date : _____

Name of the Representative of the Bidder _____

Position _____

Name of Bidder _____

Contract Name

: REPAIR / IMPROVEMENT OF SANGGUNIANG PANGALAWIGAN BUILDING

Location of the Contract

: Mati, Digos City, Davao Del Sur

Project Duration

: 75 Calendar Days

BILL OF QUANTITIES

Part No. _____

Pay Item No. 1	Description 2	Unit 3	Quantity 4	Unit Price (Pesos) 5	Amount (Pesos) 6
1010(2)b	Doors (Wood Panel)	sq.m.	69.72	In words: _____ In figures: _____	In words: _____ In figures: _____
1010(1)	Frames (Jambs, Sills, Head Transoms and Mullions)	set	22.00	In words: _____ In figures: _____	In words: _____ In figures: _____
1004 (2)	Finishing Hardware	l.s.	1.00	In words: _____ In figures: _____	In words: _____ In figures: _____
1003 (17)	Carpentry & Joinery Works	l.s.	1.00	In words: _____ In figures: _____	In words: _____ In figures: _____
1003(1)a	Gypsum Board on Metal Frame Ceiling	sq.m.	13.26	In words: _____ In figures: _____	In words: _____ In figures: _____

Submitted by: _____

Date : _____

Name of the Representative of the Bidder

Position

Name of Bidder

Contract Name : REPAIR / IMPROVEMENT OF SANGGUNIAN PANLALAWIGAN BUILDING

Location of the Contract : Matji, Digos City, Davao Del Sur
 Project Duration : 75 Calendar Days

BILL OF QUANTITIES

Part No. _____ : _____

Pay Item No.	Description	Unit	Quantity	Unit Price (Pesos)	Amount (Pesos)
1	2	3	4	5	6
1003(1)	4.5 mm Marine Plywood on metal frame ceiling	sq.m.	613.40	In words: _____ In figures: _____	In words: _____ In figures: _____
1018 (1)	Glazed Tiles	sq.m.	260.10	In words: _____ In figures: _____	In words: _____ In figures: _____
1018	Un glazed Tiles	sq.m.	89.00	In words: _____ In figures: _____	In words: _____ In figures: _____
1007(1)d	Aluminum Glass Door, (Sliding/Fixed Type)	sq.m.	19.62	In words: _____ In figures: _____	In words: _____ In figures: _____
1003(2)	6.0mm thk. Fiber Cement Board on Metal Frame Double Wall Partition	sq.m.	98.18	In words: _____ In figures: _____	In words: _____ In figures: _____

Submitted by: _____

Name of the Representative of the Bidder _____

Position _____

Name of Bidder _____

Date : _____

Contract Name

: REPAIR / IMPROVEMENT OF SANGGUNIANG PANLALAWIGAN BUILDING

Location of the Contract

: Matti, Digos City, Davao Del Sur

Project Duration

: 75 Calendar Days

BILL OF QUANTITIES

Part No. _____

Pay Item No.	Description	Unit	Quantity	Unit Price (Pesos)	Amount (Pesos)
1	2	3	4	5	6
1014(1)b2	Pre-painted Metal Sheets, above 0.427 mm, Rib Type, Long Span	sq.m.	481.41	In words: _____ In figures: _____	In words: _____ In figures: _____
1013(2)a2	Fabricated Metal Roofing Accessory, Gauge 26 (0.551 mm), Flashing	Ln.m.	171.00	In words: _____ In figures: _____	In words: _____ In figures: _____
1013(2)b1	Fabricated Metal Roofing Accessory, Gauge 24 (0.701 mm), Gutters	Ln.m.	29.49	In words: _____ In figures: _____	In words: _____ In figures: _____
1002(4)	Plumbing Fixtures	l.s.	1.00	In words: _____ In figures: _____	In words: _____ In figures: _____
1001(11)	Septic Vault/Tank,Concrete/CHB	l.s.	1.00	In words: _____ In figures: _____	In words: _____ In figures: _____

Submitted by: _____

Date : _____

Name of the Representative of the Bidder _____

Position _____

Name of Bidder _____

Contract Name

: REPAIR / IMPROVEMENT OF SANGUNIANG PANLALAWIGAN BUILDING

Location of the Contract

: Mati, Digos City, Davao Del Sur

Project Duration

: 75 Calendar Days

BILL OF QUANTITIES

Part No. _____

Pay Item No. 1	Description 2	Unit 3	Quantity 4	Unit Price (Pesos) 5	Amount (Pesos) 6
1019(1)	Wood Tiles (Narra, Tangile, others)	sq.m.	12.00	In words: _____ In figures: _____	In words: _____ In figures: _____
1047 (8)	Structural Steel	l.s.	1.00	In words: _____ In figures: _____	In words: _____ In figures: _____
1001(9)	Storm Drainage Downspout	l.s.	1.00	In words: _____ In figures: _____	In words: _____ In figures: _____
1032(1)a	Painting Works, Masonry/Concrete	sq.m.	1,200.00	In words: _____ In figures: _____	In words: _____ In figures: _____
1032(1)b	Painting Works, Wood	sq.m.	901.73	In words: _____ In figures: _____	In words: _____ In figures: _____

Submitted by: _____

Date : _____

Name of the Representative of the Bidder _____

Position _____

Name of Bidder _____

Contract Name

: REPAIR / IMPROVEMENT OF SANGGUNIANG PANLAWIGAN BUILDING

Location of the Contract
Project Duration

: Matti, Digos City, Davao Del Sur
: 75 Calendar Days

BILL OF QUANTITIES

Part No. _____

Pay Item No.	Description	Unit	Quantity	Unit Price (Pesos)	Amount (Pesos)
1	2	3	4	5	6
1032(D)c	Painting Works, Steel	sq.m.	80.00	In words: _____ In figures: _____	In words: _____ In figures: _____
SPL-I	Siphoning/Cleaning of Septic Tank	l.s.	1.00	In words: _____ In figures: _____	In words: _____ In figures: _____
SPL-II	Supply & Installation of Ergodynamic Deluxe Theater Seat	l.s.	1.00	In words: _____ In figures: _____	In words: _____ In figures: _____
SPL-III	Installation of WPC Flute Panel	sq.m.	104	In words: _____ In figures: _____	In words: _____ In figures: _____
SPL-IV	Tempered Glass Railing	l.s.	1.00	In words: _____ In figures: _____	In words: _____ In figures: _____

Submitted by: _____

Name of the Representative of the Bidder _____

Date : _____

Position _____

Name of Bidder _____

Contract Name

: REPAIR / IMPROVEMENT OF SANGUNIANG PANTALAWIGAN BUILDING

Location of the Contract
Project Duration

: Matti, Digos City, Davao Del Sur
: 75 Calendar Days

BILL OF QUANTITIES

Part No. _____

Pay Item No.	Description	Unit	Quantity	Unit Price (Pesos)	Amount (Pesos)
1	2	3	4	5	6
SPL-V	20mm thk. Granite Slab	sq.m.	13.88	In words: _____ In figures: _____	In words: _____ In figures: _____
SPL-VI	PVC Ceiling	sq.m.	143.7	In words: _____ In figures: _____	In words: _____ In figures: _____
SPL-VII	Carpet Floor	sq.m.	276.00	In words: _____ In figures: _____	In words: _____ In figures: _____
SPL-VIII	Davao del Sur Logo	I.s.	1.00	In words: _____ In figures: _____	In words: _____ In figures: _____
1100 (10)	Conduits, Boxes & Fittings (Conduit Works/Conduit Rough-In)	I.s.	1.00	In words: _____ In figures: _____	In words: _____ In figures: _____

Submitted by: _____

Name of the Representative of the Bidder _____

Date : _____

Position _____

Name of Bidder _____

Contract Name : REPAIR / IMPROVEMENT OF SANGUNIANG PANLALAWIGAN BUILDING

Location of the Contract : Matti, Digos City, Davao Del Sur

Project Duration : 75 Calendar Days

BILL OF QUANTITIES

Part No. _____ :

Pay Item No.	Description	Unit	Quantity	Unit Price (Pesos)	Amount (Pesos)
1	2	3	4	5	6
1101(33)	Wires and Wiring Devices	l.s.	1.00	In words: _____ In figures: _____	In words: _____ In figures: _____
1103 (1)	Lighting Fixtures	l.s.	1.00	In words: _____ In figures: _____	In words: _____ In figures: _____
1200 (1)	Ventilating Equipment	l.s.	1.00	In words: _____ In figures: _____	In words: _____ In figures: _____

Submitted by: _____

Date : _____

Name of the Representative of the Bidder _____

Position _____

Name of Bidder _____

SECTION IX.

CHECKLIST OF TECHNICAL AND FINANCIAL DOCUMENTS

A



Office
PROCUREMENT MANAGEMENT OFFICE
BIDS AND AWARDS COMMITTEE

Mobile Nos: 0905-229-0526/0908-332-2024 (Goods), 0948-768-5848 (Infra)
 Telefax: (082) 553-9579
 Website: www.davaodelsur.gov.ph/pgc-bac
 Email Add: bac.davaodelsur2@gmail.com/sbaocda/adodelsur@gmail.com

90 Years of Service to the People

CHECKLIST-CIVIL

IB No: _____ Opening of Bids: _____

Name of Project/Brief Description of Goods:			
PR:	Dated:	ABC	End User:
Name of Contractor/Supplier:			
Address:			
Contact Number:			
ENVELOPE 1- ELIGIBILITY DOCUMENTS/TECHNICAL			
1.		Class "A" Documents	
Legal Documents			
a. Valid PhilGEPs Registration Certificate (Platinum Membership) with its corresponding Annex A.			
Technical Documents			
b. Statement of the prospective bidder of all its on-going government and private contracts, including contracts awarded but not yet started (7 calendar days before the bid opening), if any, whether similar or not similar in nature and complexity to the contract to be bid with supporting documents such as Notice of Award and/or Contract, Notice to Proceed, and Certificate of Accomplishment or Statement of Time Elapsed and Work Accomplished.			
c. Statement of the bidder's Single Largest Completed Contract (SLCC) similar to the contract to be bid for the last (3) years, and whose value, adjusted to current prices using the PSA consumer price indices, must be at least fifty percent (50%) of the ABC to be bid: Provided, however, that contractors under Small A and Small B categories without similar experience on the contract to be bid may be allowed to bid if the cost of such contract is not more than the Allowable Range of Contract Cost (ARCC) of their registration based on the guidelines as prescribed by the PCAB. This Statement must be supported with the following: Contract/ Purchase Order, Certificate of Completion/ Acceptance or Inspection Report or Official Receipt, Validated Contractors/Constructors Performance Evaluation System (CPES) in DPWH website.			
d. Valid Philippine Contractors Accreditation Board (PCAB) License or Special PCAB License in case of Joint Ventures, and Registration for the type and cost of the contract to be bid.			
Financial Documents			
e. The prospective bidder's computation of Net Financial Contracting Capacity (NFCC). However, in the case of procurement of Goods, a bidder may submit a committed Line of Credit from a Universal or Commercial Bank, in lieu of its NFCC computation. (Note: K=15)			
2		Class "B" Documents	
a. For Infrastructure Projects, Joint Venture bidders shall submit a Joint Venture Agreement in accordance with R.A. 4566 and its IRR. Each partner of the joint venture shall submit their respective PhilGEPs Certificates of Registration in accordance with Section 8.5.2 of this IRR. The submission of technical and financial eligibility documents by any of the joint venture partners constitutes compliance: Provided, that the partner responsible to submit the NFCC shall likewise submit the Statement of all of its ongoing contracts and Audited Statements.			
TECHNICAL PROPOSAL			
1. Original copy of Bid Security in the form of the following: <ul style="list-style-type: none"> <input type="checkbox"/> Cash or Cashier's/ Manager's check (2%) <input type="checkbox"/> Bank Guarantee/ Draft or Irrevocable Letter of Credit (2%) <input type="checkbox"/> Surety Bond callable upon demand (5%) <input type="checkbox"/> Bid Securing Declaration (in the prescribed form)			
2. Project Requirements, which shall include the following: <ul style="list-style-type: none"> a. Organizational chart for the contract to be bid 			

	<p>b. List of contractor's personnel (viz., Project Manager, Project Engineers, Materials Engineers, and Foremen), to be assigned to the contract to be bid, with their complete qualifications and experience data;</p>
	<p>c. List of contractor's equipment units, which are owned, leased, and/or under purchase agreements, supported by certification of availability of equipment from the equipment lessor/vendor for the duration of the project;</p>
	<p>3. Original Duly Signed Omnibus Sworn Statement (OSS) by the prospective bidder or its duly authorized representative; and if applicable, Original Notarized Secretary's Certificate in case of a corporation, partnership, or cooperative; or Original Special Power of Attorney of all members of the joint venture giving full power and authority to its officer to sign the OSS and do acts to represent the bidder.</p>
	<p>4. Other documents/materials to comply with other non-discretionary criteria and requirements as stated in the instruction to Bidders:</p> <ul style="list-style-type: none"> • Construction Methods • Construction schedule and S-Curve • Pert-CPM • Manpower Utilization Schedule • Equipment Utilization Schedule • Construction Safety & Health Program • Duly Notarized Affidavit of Site Inspection • Duly Notarized Certification as to Compliance to Labor Laws and Standard
<p>QUALIFIED</p>	
<p>DISQUALIFIED</p>	
<p>ENVELOPE 2- FINANCIAL PROPOSAL</p>	
	<p>1. Duly Signed Financial Bid Form</p>
	<p>2. Duly Signed Bid Prices in the Bill of Quantities</p>
	<p>3. Duly Signed Detailed Estimates</p>
	<p>4. Duly Signed Cash Flow by Quarter and Payment Schedules</p>

SECTION X.

OTHER DOCUMENTS

- 1) Purchase Request
- 2) Statement of all On-going Government & Private Contracts including Contracts awarded but not yet started (Prescribed Form)
- 3) Statement of Single Largest Completed Contract (Prescribed Form)
- 4) Bid Securing Declaration (Prescribed Form)
- 5) Omnibus Sworn Statement (Prescribed Form)
- 6) Bid Form (Prescribed Form)
- 7) Resolution No. 1333 Series of 2023 / Three-Strike Policy
- 8) Resolution No. 052 Series of 2022
- 9) Resolution No. 053 Series of 2022
- 10) TWG – Checklist for Bid Evaluation
- 11) TWG – Checklist for Post Qualification



PURCHASE REQUEST
PROVINCE OF DAVAO DEL SUR
MATTI, DIGOS CITY

Department : PROVINCIAL ENGINEER'S OFFICE
 Section : Construction


PR NO. : 164-23-S Date : 12-28-2023
 SAI NO. : _____ Date : _____

STOCK No.	UNIT OF ISSUE	ITEM DESCRIPTION	QTY	UNIT COST	TOTAL COST
1	Job Order	REPAIR / IMPROVEMENT OF SANGGUNIANG PANLALAWIGAN BUILDING located at MATTI, DIGOS CITY, DAVAO DEL SUR all in accordance, to plans, specifications and scope of work and the Green Procurement Policy as adopted by Executive Order No. 30 series of 2019. XXXXXXXXXXXXXXXX	1		
		TOTAL			P 7,400,000.00 wwwww
<p><i>Charge to:</i> Repair/Improvement of Sangguniang Panlalawigan Building Matti, Digos City, Davao del Sur CY 2022 - Supplemental No. 5</p>					

TECHNICAL WORKING GROUP
TECHNICAL SPECS CONTROLLED
 BY: *[Signature]*
 DATE: *12/26/23*

Purpose/Remarks
 For use in the **REPAIR / IMPROVEMENT OF SANGGUNIANG PANLALAWIGAN BUILDING** located at **MATTI, DIGOS CITY, DAVAO DEL SUR**

Signature :	<i>[Signature]</i>	CASH AVAILABILITY	<i>[Signature]</i>	APPROVED :	<i>[Signature]</i>
Printed Name	LEONERI MARCH R. SUARIO		FARAH GEMMA V. BIDAN, CPA		YVONNE ROMA CAGAS
Designation	<i>Provincial Engineer</i>		<i>Provincial Treasurer</i>		<i>Governor</i>
Date	November 29, 2023		<i>[Signature]</i>		<i>[Signature]</i>

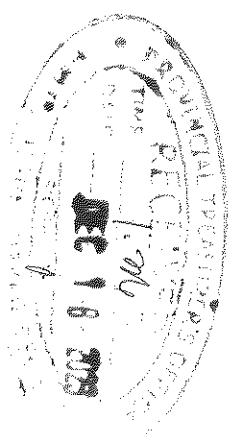

Statement of all On-going Government & Private Contracts including Contracts awarded but not yet started

Name of Project / Contact : _____

IB No. _____

Location: _____

Name of Contract / Location	a)Owner's Name b)Address c)Telephone No.	Nature of Work	Bidder's Role Description %	a) Amount at award b) Date Started c)Target Completion Date	% of Accomplishment		Government	Private
					Planned	Actual		
Total Cost								P

Note: This Statement shall be supported with:

1. Notice of Award and/or Contract
2. Notice to Proceed issued by the Procuring Entity
3. Certificate of Accomplishments signed by the owner or authorized representative

Submitted by _____

(Printed Name & Signature)

Designation _____

Date _____

Statement of Single Largest Completed Contract (SLCC)
 (Similar in Nature for the Last 3 years)

Name of Project/Contract: _____

IB No. _____

Location: _____

Name of Contract / Location Project Cost	a) Owner's Name b) Address c) Telephone No.	Nature of Work	Bidder's Role		a) Amount at Award b) Amount at Completion c) Duration	a) Date Awarded b) Date Started c) Date of Completion
			Description	%		

Note: This statement shall be supported with:

1. Contract/Purchase Order
2. Certificate of Completion/Acceptance or Inspection and Acceptance Report or Official Receipts

Submitted by: _____

(Printed Name & Signature)

Designation: _____

Date: _____

Bid Securing Declaration Form
[shall be submitted with the Bid if bidder opts to provide this form of bid security]

REPUBLIC OF THE PHILIPPINES)
CITY OF _____) S.S.

BID SECURING DECLARATION
Project Identification No.: [insert number]

To: *[insert name and address of the Procuring Entity]*

I/We, the undersigned, declare that:

1. I/We understand that, according to your conditions, bids must be supported by a Bid Security, which may be in the form of a Bid Securing Declaration.
2. I/We accept that: (a) I/we will be automatically disqualified from bidding for any procurement contract with any procuring entity for a period of two (2) years upon receipt of your Blacklisting Order; and, (b) I/we will pay the applicable fine provided under Section 6 of the Guidelines on the Use of Bid Securing Declaration, within fifteen (15) days from receipt of the written demand by the procuring entity for the commission of acts resulting to the enforcement of the bid securing declaration under Sections 23.1(b), 34.2, 40.1 and 69.1, except 69.1(f), of the IRR of RA No. 9184; without prejudice to other legal action the government may undertake.

3. I/We understand that this Bid Securing Declaration shall cease to be valid on the following circumstances:
 - a. Upon expiration of the bid validity period, or any extension thereof pursuant to your request;
 - b. I am/we are declared ineligible or post-disqualified upon receipt of your notice to such effect, and (i) I/we failed to timely file a request for reconsideration or (ii) I/we filed a waiver to avail of said right; and
 - c. I am/we are declared the bidder with the Lowest Calculated Responsive Bid, and I/we have furnished the performance security and signed the Contract.

IN WITNESS WHEREOF, I/We have hereunto set my/our hand/s this ____ day of [month]
[year] at [place of execution].

*[insert NAME OF BIDDER OR ITS AUTHORIZED
REPRESENTATIVE]*
[insert signatory's legal capacity]
Affiant

Jurat
[Format shall be based on the latest Rules on Notarial Practice]

Omnibus Sworn Statement (Revised)
[shall be submitted with the Bid]

REPUBLIC OF THE PHILIPPINES)
CITY/MUNICIPALITY OF _____) S.S.

AFFIDAVIT

1. [Name of Affiant], of legal age, [Civil Status], [Nationality], and residing at [Address of Affiant], after having been duly sworn in accordance with law, do hereby depose and state that:

1. *[Select one, delete the other:]*

[If a sole proprietorship:] I am the sole proprietor or authorized representative of [Name of Bidder] with office address at [address of Bidder];

[If a partnership, corporation, cooperative, or joint venture:] I am the duly authorized and designated representative of [Name of Bidder] with office address at [address of Bidder];

2. *[Select one, delete the other:]*

[If a sole proprietorship:] As the owner and sole proprietor, or authorized representative of [Name of Bidder], I have full power and authority to do, execute and perform any and all acts necessary to participate, submit the bid, and to sign and execute the ensuing contract for [Name of the Project] of the [Name of the Procuring Entity], as shown in the attached duly notarized Special Power of Attorney;

[If a partnership, corporation, cooperative, or joint venture:] I am granted full power and authority to do, execute and perform any and all acts necessary to participate, submit the bid, and to sign and execute the ensuing contract for [Name of the Project] of the [Name of the Procuring Entity], as shown in the attached [state title of attached document showing proof of authorization (e.g., duly notarized Secretary's Certificate, Board/Partnership Resolution, or Special Power of Attorney, whichever is applicable)];

3. [Name of Bidder] is not "blacklisted" or barred from bidding by the Government of the Philippines or any of its agencies, offices, corporations, or Local Government Units, foreign government/foreign or international financing institution whose blacklisting rules have been recognized by the Government Procurement Policy Board, by itself or by relation, membership, association, affiliation, or controlling interest with another blacklisted person or entity as defined and provided for in the Uniform Guidelines on Blacklisting;

4. Each of the documents submitted in satisfaction of the bidding requirements is an authentic copy of the original, complete, and all statements and information provided therein are true and correct;

5. [Name of Bidder] is authorizing the Head of the Procuring Entity or its duly authorized representative(s) to verify all the documents submitted;

6. *[Select one, delete the rest:]*

[If a sole proprietorship:] The owner or sole proprietor is not related to the Head of the Procuring Entity, members of the Bids and Awards Committee (BAC), the Technical

Working Group, and the BAC Secretariat, the head of the Project Management Office or the end-user unit, and the project consultants by consanguinity or affinity up to the third civil degree;

[If a partnership or cooperative:] None of the officers and members of *[Name of Bidder]* is related to the Head of the Procuring Entity, members of the Bids and Awards Committee (BAC), the Technical Working Group, and the BAC Secretariat, the head of the Project Management Office or the end-user unit, and the project consultants by consanguinity or affinity up to the third civil degree;

[If a corporation or joint venture:] None of the officers, directors, and controlling stockholders of *[Name of Bidder]* is related to the Head of the Procuring Entity, members of the Bids and Awards Committee (BAC), the Technical Working Group, and the BAC Secretariat, the head of the Project Management Office or the end-user unit, and the project consultants by consanguinity or affinity up to the third civil degree;

7. *[Name of Bidder]* complies with existing labor laws and standards; and

8. *[Name of Bidder]* is aware of and has undertaken the responsibilities as a Bidder in compliance with the Philippine Bidding Documents, which includes:

- a. Carefully examining all of the Bidding Documents;
- b. Acknowledging all conditions, local or otherwise, affecting the implementation of the Contract;
- c. Making an estimate of the facilities available and needed for the contract to be bid, if any; and
- d. Inquiring or securing Supplemental/Bid Bulletin(s) issued for the *[Name of the Project]*.

9. *[Name of Bidder]* did not give or pay directly or indirectly, any commission, amount, fee, or any form of consideration, pecuniary or otherwise, to any person or official, personnel or representative of the government in relation to any procurement project or activity.

10. In case advance payment was made or given, failure to perform or deliver any of the obligations and undertakings in the contract shall be sufficient grounds to constitute criminal liability for Swindling (Estafa) or the commission of fraud with unfaithfulness or abuse of confidence through misappropriating or converting any payment received by a person or entity under an obligation involving the duty to deliver certain goods or services, to the prejudice of the public and the government of the Philippines pursuant to Article 315 of Act No. 3815 s. 1930, as amended, or the Revised Penal Code.

IN WITNESS WHEREOF, I have hereunto set my hand this ___ day of ___, 20__ at _____, Philippines.

[Insert NAME OF BIDDER OR ITS AUTHORIZED REPRESENTATIVE]
[Insert signatory's legal capacity]
Affiant

[Jurat]
[Format shall be based on the latest Rules on Notarial Practice]

Bid Form for the Procurement of Infrastructure Projects

[shall be submitted with the Bid]

BID FORM

Project Identification No. : _____

Date : _____

To: *[name and address of Procuring Entity]*

Having examined the Philippine Bidding Documents (PBDs) including the Supplemental or Bid Bulletin Numbers *[insert numbers]*, the receipt of which is hereby duly acknowledged, we, the undersigned, declare that:

- a. We have no reservation to the PBDs, including the Supplemental or Bid Bulletins, for the Procurement Project: *[insert name of contract]*;
- b. We offer to execute the Works for this Contract in accordance with the PBDs;
- c. The total price of our Bid in words and figures, excluding any discounts offered below is: *[insert information]*;
- d. The discounts offered and the methodology for their application are: *[insert information]*;
- e. The total bid price includes the cost of all taxes, such as, but not limited to: *[specify the applicable taxes, e.g. (i) value added tax (VAT), (ii) income tax, (iii) local taxes; and (iv) other fiscal levies and duties]*, which are itemized herein and reflected in the detailed estimates;
- f. Our Bid shall be valid within the a period stated in the PBDs, and it shall remain binding upon us at any time before the expiration of that period;
- g. If our Bid is accepted, we commit to obtain a Performance Security in the amount of *[insert percentage amount]* percent of the Contract Price for the due performance of the Contract, or a Performance Securing Declaration in lieu of the the allowable forms of Performance Security, subject to the terms and conditions of issued GPPB guidelines¹ for this purpose;
- h. We are not participating, as Bidders, in more than one Bid in this bidding process, other than alternative offers in accordance with the Bidding Documents;
- i. We understand that this Bid, together with your written acceptance thereof included in your notification of award, shall constitute a binding contract between us, until a formal Contract is prepared and executed; and
- j. We understand that you are not bound to accept the Lowest Calculated Bid or any other Bid that you may receive.
- k. We likewise certify/confirm that the undersigned, is the duly authorized

¹ currently based on GPPB Resolution No. 09-2020

representative of the bidder, and granted full power and authority to do, execute and perform any and all acts necessary to participate, submit the bid, and to sign and execute the ensuing contract for the [Name of Project] of the [Name of the Procuring Entity].

- I. We acknowledge that failure to sign each and every page of this Bid Form, including the Bill of Quantities, shall be a ground for the rejection of our bid.

Name: _____

Legal Capacity: _____

Signature: _____

Duly authorized to sign the Bid for and behalf of: _____

Date: _____



Resolution No.1333
Series of 2023

**A RESOLUTION
RECOMMENDING TO THE HEAD OF THE PROCURING ENTITY, GOVERNOR
YVONNE RONA CAGAS TO FURTHER AMEND THE 3-STRIKE POLICY IN THE
PROCUREMENT OF CONTRACTS FOR GOODS AND SERVICES, AND
INFRASTRUCTURE PROJECTS OF THE PROVINCIAL GOVERNMENT OF DAVAO
DEL SUR.**

WHEREAS, the Provincial Government of Davao del Sur encounters several failures of biddings due to constant errors committed by the participating Bidders in the submission of their bidding documents despite of the orientation during Pre-Bid Conference and the instruction to Bidders;

WHEREAS, to further strengthen the integrity of the competitive bidding process, the Bids and Awards Committee unanimously agreed that the following instructions are hereby issued pertaining to the implementation of the 3-Strike Policy of the Provincial Government of Davao del Sur against violations of Section 69 of the IRR of RA 9184;

1. The provision of Section 69.1 of the said IRR, pertaining to the 3-Strike Policy of the Provincial Government of Davao del Sur, is hereby reiterated as follows:

"In addition to the provisions of Rules XXI and XXII of this IRR, the Head of the Procuring Entity, subject to the authority delegated to the BAC, if any, shall impose on bidders or prospective bidders, the administrative penalty of suspension for one (1) year for the first offense, and suspension of two (2) years for the second offense from participating in the competitive bidding process, as well as disqualification from further participating in the competitive bidding being undertaken by the Procuring Entity concerned, where applicable, for the following violations: 69.1.1 All other acts that tend to defeat the purpose of the competitive bidding, such as habitually withdrawing from bidding, submitting late Bids or patently insufficient bid, for at least three (3) times within a year, except for valid reasons."

2. The violations enumerated, which are considered as acts that tend to defeat the purpose of competitive bidding, are hereby clarified to read as follows:
 - a) Non-submission of post-qualification and other requirements within the prescribed period as specified in the notice issued by the BAC;
 - b) All other acts that tend to defeat the purpose of competitive bidding, such as:
 - 1.) Withdrawing from bidding or Non-dropping of Bid Documents,
 - 2.) Submitting late Bids;
 - 3.) Submitting of patently insufficient bid. Patently insufficient bid is clarified as the "total absence" of the required document.

4.) Refusal to receive/acknowledge notice/s issued by the Head of the Procuring Entity and/or Bids and Awards Committee

BAC RES. NO. 1333, S.2023

Page -2-

x-x-x-x-x-x-x-x-x-x-x-x-x

- c) Habitually committing offenses that are not grounds for disqualification such as improper sealing, non-tabbing, and the like.
3. Every time a bidder is observed to have done committed any of the acts enumerated under Item 2 of this Resolution, the Chairperson of the BAC shall immediately issue a Show Cause Order to the erring bidder informing of his act, and giving him three (3) calendar days to show cause why he should not be sanctioned for committing an act which tends to defeat the purpose of public bidding under the 3-Strike Policy of the Provincial Government of Davao del Sur;
4. Based on the evaluation by the BAC of the bidder's response to the Show Cause Order mentioned in Item No. 3 of this Resolution, the BAC shall, within five (5) calendar days from the receipt of the bidder's response determine whether the bidder's act was done with or without a valid cause;
5. The BAC Secretariat shall submit to the BAC a 3-Strike Policy Report, which shall contain the information in Item 3 and 9 of this Resolution.
6. The BAC through its Secretariat shall monitor the participation of bidders in all of its projects/participations, and maintain a tally of violations by each bidder of the 3-Strike Policy in its jurisdiction as well as of the violations by the bidder of the said policy in other offices of the Provincial Government of Davao del Sur;
7. All other petty defects found in the bid documents of the bidder which will not in any manner defeat the purpose of Competitive Bidding shall not be a ground for the imposition of a strike, subject to the discretion of the BAC
8. For the procurement of Infrastructure Projects, this Policy is applicable to all methods of procurement, be it Competitive Bidding or alternative methods of procurement. For the procurement of Goods and Consulting Services, this Policy is applicable to Competitive Bidding only
9. For the sanctions to be imposed:
 - **ONE (1) STRIKE** will be imposed for various IB Nos. participated by the bidder with the same nature of violation opened on the same date, or was disqualified during post-qualification stage with the same case of the latter;
 - **MULTIPLE STRIKES** for different discrepancies/offenses under different IB Nos. opened on the same date, or was disqualified during post-qualification stage with the same case of the latter;
 - **For Item 2.c:** Three habitual offenses are equivalent to one (1) strike
10. Each "offense" by a bidder referred to in Section 69.1.i. of the IRR, as stated in this Resolution, consists of three violations or strikes within a period of one calendar year for all the procurements of all offices of the Provincial Government of Davao del Sur. A Fresh Period of one (1) year in counting of "strikes" shall be observed in the succeeding year;

1 ATTN: DAVAO DEL SUR

11. Based on the 3-Strike reports, the Bids and Awards Committee, shall recommend to the Head of the Procuring Entity, for approval, the following administrative sanctions on the erring Contractor/Supplier for the violation of the 3-Strike Policy:

- a. For the first violation or strike – a first warning.
- b. For the second strike – a second warning.
- c. For the third strike, which together with the first two strikes constitutes the first offense against the 3-Strike Policy – an administrative penalty of suspension for one (1) year from participating in any procurement process in the Provincial Government of Davao del Sur.
- d. For the second offense – the second set of three strikes committed by the bidder – an administrative suspension for two (2) years from participating in any procurement process in the Provincial Government of Davao del Sur.

WHEREFORE, on motion of BAC Member, Raul R. Fueconcillo, Lagri.MagDev. duly seconded by all BAC Members present it was –

RESOLVED, as it is hereby **RESOLVED**, to recommend to the Head of the Procuring Entity, GOVERNOR WYONNE RONÑA CAGAS to **FURTHER AMEND THE 3-STRIKE POLICY IN THE PROCUREMENT OF CONTRACTS FOR GOODS AND SERVICES, AND INFRASTRUCTURE PROJECTS OF THE PROVINCIAL GOVERNMENT OF DAVAO DEL SUR.**

RESOLVED FINALLY, to furnish copies of this Resolution to all agencies concerned, Suppliers, and Concerned End Users, for their information and guidance.

UNANIMOUSLY APPROVED at the Ralota Hall, Governor Douglas RalotaCagas Sports and Business Complex, Barangay Matti, Digos City, Province of Davao del Sur, this 31st day of August, 2023.

12008 DAVAO DEL SUR

I hereby concur to the correctness of the minutes:

ENGR. SHEILA MAE A. ZAPANTA, MPA
Administrative Officer IV, PMO
Head, BAC Secretariat for Infrastructure Projects

NORJANNA M. CAMAGUIN, MPA
Chief Administrative Officer, PMO
Head, BAC Secretariat for Goods and Consulting Services

ENGR. RODERICK MILANA, REA
Provincial Assessor / BAC Member

ALLAN C. PUTONG, JD
PGDH-PGSO / BAC Member

ENGR. ANGELIE R. GELLA
APGDH-PEO / BAC Member

DOMINIC BUCOL, JD
PGDH-PCSMO / BAC Member

RAUL R. FUECONCILLO, Lagri.Mag.Dev.
Provincial Agriculturist / BAC Member

RAUL D. RAUT, ENP, JD
PGDH-PHRMO / BAC Vice-Chairperson

DESSAMIE BUAT-SANCHEZ, CPA, JD
PGDH-PBO / BAC Chairperson
Presiding Officer

Approved by:

YVONNE ROÑA CAGAS
Governor
Head of Procuring Entity

I LORNE DAVAO DEL SUR



Republic of the Philippines
PROVINCE OF DAVAO DEL SUR
 Barangay Matti, Digos City, Davao del Sur
 Mobile: 0921-502-7247 Fax: 0921-502-7247/0921-701-5845
 Telefax: (0921) 502-9117 Website: www.davaodelsur.gov.ph
 E-mail Address: dcm@vawdelsur2.gov.ph; dcm@vawdelsur.davaodelsur.gov.ph

OFFICE OF THE GOVERNOR

BIDS AND AWARDS COMMITTEE (BAC)

Resolution No. 052
 Series of 2022

A RESOLUTION

RECOMMENDING TO THE HEAD OF THE PROCURING ENTITY, GOVERNOR YVONNE RONÁ CAGAS TO ADOPT THE SUSPENSION OF PARTICIPATING BIDDERS WHO WILL INCUR ANY OF THE VIOLATIONS STIPULATED IN SECTION 41 OF THE 2016 REVISED IMPLEMENTING RULES AND REGULATIONS OF REPUBLIC ACT NO. 9184, OTHERWISE KNOWN AS THE GOVERNMENT PROCUREMENT REFORM ACT.

WHEREAS, the Provincial Government of Davao del Sur encounters failures of biddings due to constant violations committed by the participating Bidders in the submission of their bidding documents despite of the orientation during Pre-bid Conference and the Instruction to Bidders;

WHEREAS, to further strengthen the integrity of the competitive bidding process, the Bids and Awards Committee together with the Members of the Technical Working Group unanimously agreed that the following instructions are hereby issued, pertaining to the implementation of the Suspension of the Participating Bidders against violations of Section 41 of the Revised IRR of RA 9184;

1. The provision of Section 41 the Revised IRR of RA 9184 is hereby reiterated as follows:
 - a. *If there is prima facie evidence of collusion between appropriate public officers or employees of the Procuring Entity, or between the BAC and any of the bidders, or if the collusion is between or among the bidders themselves, or between a bidder and a third party, including any act which restricts, suppresses or nullifies or tends to restrict, suppress or nullify competition;*
 - b. *If the BAC is found to have failed in following the prescribed bidding procedures; or*
 - c. *For any justifiable and reasonable ground where the award of the contract will not redound to the benefit of the government as defined in the IRR.*"
2. The violations enumerated, which are considered as acts that tend to defeat the purpose of competitive bidding, are hereby clarified to read as follows:
 - 2.a. *If there is prima facie evidence of collusion between appropriate public officers or employees of the Procuring Entity*
 - 2.b. *If there is prima facie evidence of collusion between the BAC and any of the bidders;*

H

W



Republika ng Pilipinas
 PROVINCE OF DAVAO DEL SUR
 Barangay Mati, Digos City, Davao del Sur
 Mobile No. 082-222-1111 / 082-222-1112 / 082-222-1113
 Telefax (082) 222-1114 / 222-1115 / 222-1116 / 222-1117
 E-mail: bac.davao@ddps.gov.ph / bac.davao@ddps.gov.ph

Resolution No. 053
 Series of 2022

A RESOLUTION

RECOMMENDING TO THE HEAD OF THE PROCURING ENTITY, GOVERNOR YVONNE ROÑA CAGAS, TO DECLARE BIDDERS WHO FAILED TO DISCLOSE ALL ON-GOING PROJECTS AS DISQUALIFIED, AFTER FINDING SUCH NON-INCLUSION DURING POST-QUALIFICATION OF BIDDERS BY THE BAC TECHNICAL WORKING GROUP (TWG).

Be it enacted by the BAC MEMBERS in meeting assembled:

WHEREAS, in line with the Provincial Government of Davao del Sur's initiative to fast-track the procurement transactions of the Province, the Special Bids and Awards Committee hereby adopts this Resolution to produce Contractors with integrity and truthfulness in their submitted bid;

WHEREAS, item number 2 of GPPB NPM 11-1-2013 states that, "Failure to include all on-going and completed contracts in the Statement may be a ground for disqualification for being incomplete, and may also result in blacklisting if proven that such failure amounts to submission of false information or false documents. The submission of the eligibility documents enumerated in Section 23.1 of the IRR is a mandatory requirement that must be complied with by prospective bidders, such that failure to submit any of the documents or the submission of an otherwise incomplete or patently insufficient document, will disqualify the bidder based on the non-discretionary "pass/fail" criterion under Section 30.1 of the IRR."

IN ADDITION, GPPB NPM 006-2018 states that, "Failure to declare an on-going government and private contract, including contracts awarded but not yet started, if any, whether similar or not similar in nature and complexity to the contract to be bid is a ground for disqualification. These contracts, as reflected in the "Statement of all on-going contracts", are vital to the computation of the Net Financial Contracting Capacity of the bidder, and they are necessary information during the post-qualification stage to verify, validate and ascertain the technical qualification of the Lowest Calculated Bidder for the ultimate determination whether it is the Lowest Calculated and Responsive Bidder";


WHEREFORE, after thorough deliberation, BAC Member Milana duly seconded by BAC Member Pulong, it was-

RESOLVED, as it is hereby **RESOLVED**, to recommend to the **HEAD OF PROCURING ENTITY, GOVERNOR YVONNE RONA CAGAS, TO DECLARE BIDDERS WHO FAILED TO DISCLOSE ALL ON-GOING PROJECTS AS DISQUALIFIED AFTER FINDING SUCH NON-INCLUSION DURING POST-GOING QUALIFICATION OF BIDDERS BY THE BAC TECHNICAL WORKING GROUP (TWG);**

RESOLVED FINALLY, to furnish copies of this Resolution to all agencies concerned for their information and guidance.

UNANIMOUSLY APPROVED at the Almendras Hall, Governor Douglas Ralota Cagas Sports and Business Complex, Barangay Mati, Digos City, Province of Davao del Sur, this 14th day of July, 2022.

I hereby certify to the correctness of above-mentioned resolution


 Engr. **SHEILA MAE ZAPANTA, MPA**
 Agricultural Technologist
 Head, BAC Secretariat (Infrastructure Projects)


NORJANNA M. CAMAGUIN, MPA
 LT00 IV
 Head, BAC Secretariat (Goods and Consulting Services)


BAC Resolution No. 053, Series of 2022
 Page 1 of 2

Attested by:



DOMINIC S. BUCCOL JD
PGDH-Provincial Warden Office
BAC Member

 

Engr. ANGELIE R. GELLA
APGDH-PEO
BAC Member

(on leave)
RAUL R. FUECONCILLO, MagDev
PGDH-Office of the Provincial Agriculturist
BAC Member


Engr. RODERICK R. MILANA, REA
PGDH-PASSO
BAC Member



ALLANG C. PUTONG, JD
PGDH-PGSO
BAC Member


RAUL B. RAUT, EnP, JD
PGDH-HRMO
BAC Vice Chairperson


DESSAMIE BUAT-SANCHEZ, CPA, JD
PGDH - FBO
BAC Chairperson – Presiding Officer

Approved by:


YVONNE RONA CAGAS
Governor
Head of Procuring Entity

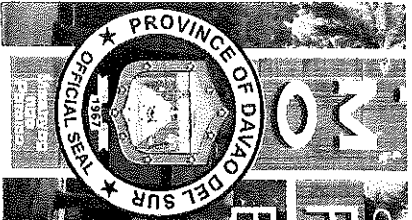

Office
PROCUREMENT MANAGEMENT OFFICE
BIDS AWARDS COMMITTEE

Mobile Nos: 0905-229-0526/0908-332-2024 (Goods), 0948-768-5848 (Infra)
 Website: www.davcodelsur.gov.ph/pgc-bac
 Email Add: bac.davcodelsur2@gmail.com/sbacdavcodelsur@gmail.com

TWG – CHECKLIST FOR BID EVALUATION

IB No.		
Name of Project:		
Contractor:		
ITEMS:		
1. Bid Amount (both in words and in figure) must be below ABC.		
2. Bill of Quantities submitted by the contractor must conform with the Bill of Quantities issued by the End-User.		
3. Detailed Estimates		
A. Check mathematical computation in the Detailed Estimates		
B. The amount in the Detailed Estimates must be reconciled with the amount in the summary of bid and the quantities in the BOQ.		
C. Allowance for waste and/or losses, not to exceed 5% of materials equipment.		
D. Mobilization and demobilization shall not exceed 1% of the Estimated Direct Cost (EDC) of the civil works items.		
E. Overhead expenses must be within the range of %-11% of the EDC.		
F. Contingencies must be within the range of 0.5%-3% of the EDC.		
G. Miscellaneous expenses must be within the range of 0.5%-1% of the EDC.		
H. Contractor's Profit Margin shall be 8% of the EDC for projects above 5 million and 10% for the projects 5 million and below.		
I. VAT Component shall be 5% of the sum of the EDC, OCM, and Profit.		
J. The following non-civil work items shall not be subjected to OCM mark-up:		
1. Field/Laboratory Office & Living Quarters (Rental Basis)		
2. Furnishing of Furniture, Laboratory Equipment, Survey Equipment and Consumables		
3. Assistance to the Engineers		
4. Photographs		
5. Health and Safety		
2. Traffic Management		
3. Environmental Compliance		
4. Communication Equipment		
5. Project Billboard, etc.		
	FINDINGS	REMARKS




PROCUREMENT MANAGEMENT OFFICE

BIDS AWARDS COMMITTEE

Mobile Nos. 0905-229-0526/0908-332-2024 (Goods), 0948-768-5848 (Infra)
 Telefax: (082) 553-9579
 Website: www.davaodelsur.gov.ph/pgo-bac
 Email Add: bac.davaodelsur2@gmail.com/spoadavaodelsur@gmail.com

K. The following items shall not be subjected to OCM and Profit mark-up:			
A.	<i>Mobilization and demobilization</i>		
B.	Provision of Service Vehicle		
C.	<i>Permits and Clearances</i>		
4. Bid Security			
A.	Cash or Cashier's/ Manager's check (2%)		
B.	Bank Guarantee/ Draft or Irrevocable Letter of Credit (2%)		
C.	Surety Bond callable upon demand (5%)		
D.	<i>Bid Securing Declaration (must be in prescribed form, 15 days)</i>		
E.	Cash Flow by quarter and payment schedule (check mathematical computation against the bid amount)		

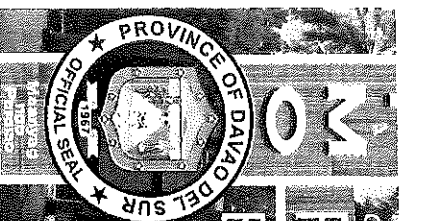


Office
PROCUREMENT MANAGEMENT OFFICE
BIDS AWARDS COMMITTEE

Mobile Nos. 0905-299-0526/0908-332-2024 (Goods), 0948-768-8848 (Infra)
 Telefax: (082) 553-9579
 Website: www.davaodelsur.gov.ph/pgo-bac
 Email Add: bac.davaodelsur2@gmail.com/sbacdavaodelsur@gmail.com

9 Days 9 Hours 90 Minutes 90 Seconds 90

TWG – CHECKLIST FOR POST QUALIFICATION

IB. No.		
Name of Project:		
Contractor:		
TECHNICAL DOCUMENTS:	FINDINGS	REMARKS
1. Not a Blacklisted Contractor per GPPB Website		
2. Registration certificate from SEC, Department of Trade and Industry (DTI) for sole proprietorship, or CDA for cooperatives must be valid (Company Name and Validity)		
3. Mayor's/ Business permit must be valid (Company Name and Validity)		
4. Tax Clearance must be valid (Company Name and Validity)		
5. PhilGEPs Registration (Platinum Membership) must be valid (Company Name and Validity)		
6. Valid Philippine Contractors Accreditation Board or Special PCAB License in case of Joint Ventures (PCAB)		
7. Statement of all on-going government and private contracts including awarded but not yet started <ul style="list-style-type: none"> A. Complete attachments <ul style="list-style-type: none"> I. Notice of Award II. Contract III. Notice to Proceed IV. Contract Extension, if any; V. Statement of Work Accomplishment duly signed by the Procuring Entity B. Evaluate the projects, if any; <ul style="list-style-type: none"> i. Verify Target Date of Completion ii. Must not incur Negative Slippage of more than fifteen percent (15%) in any one project or a negative slippage of more than ten percent (10%) in each two (2) or more contracts. C. Verification of on-going projects via DPWH portal 		
8. Statement of the bidder's Single Largest Completed Contract (SLCC) similar to the contract to be bid for the last (3) years, and whose value, adjusted to current prices using the PSA consumer price indices, must be at least fifty percent (50%) of the ABC to be bid: Provided, however, that contractors under Small A and Small B categories without similar experience on the contract to be bid may be allowed to bid if the cost of such contract is not more than the Allowable Range of Contract Cost (ARCC) of their registration based on the guidelines as prescribed by the PCAB.		
Must be supported with the following:		
A. Contract / Purchase Order		
B. Certificate of Completion / Acceptance or Inspection Report or Official Receipt		
C. Validate Contractors/Constructors Performance Evaluation System (CPES) in DPWH website.		

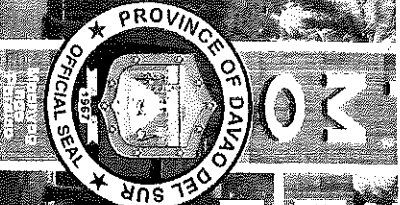

Office
PROCUREMENT MANAGEMENT OFFICE

BIDS AWARDS COMMITTEE

Mobile Nos: 0905-229-0526/0908-332-2024 (Goods); 0948-768-5848 (Infra)
 Telefax: (082) 553-9579
 Website: www.davaodelsur.gov.ph/pgc-bac
 Email Add: bac.davaodelsur2@gmail.com/spccadavaodelsur@gmail.com

9. Omnibus Sworn Statement must be in prescribed form (1 to 9) and duly notarized		
10. Net Financial Contracting Capacity (NFCC) must be reconciled with the Audited Financial Statements		
11. Income Tax Return as of 2020		
12. Business Tax Return Quarterly or Monthly as of 2021		
13. Construction Methods must conform with the approved plan		
14. Construction schedule and S-Curve must conform with the prescribed contract duration and the bid amount		
15. PERT-CPM must conform with the contract duration		
16. Manpower Utilization must conform with the POW		
17. Equipment Utilization must conform with the POW		
18. Duly Notarized Affidavit of Site Inspection		
19. Duly Notarized Compliance to Existing Labor Laws and Standards		